



ELECTRICAL DESIGN GROUP

ELECTRICAL BUILDING SERVICES CONSULTANTS

P.O. Box 15, SHERWOOD Q. 4075

Phone: (07) 3278 4375

Website: www.edg.net.au Email: brisbane@edg.net.au

C2154a - ORMISTON COLLEGE - COVERED COURTS

C2154a-0001(C).xls



ELECTRICAL SERVICES CONTRACT DOCUMENT SCHEDULE

REVISION C - 01 DECEMBER 2025


ISSUING INFORMATION				DATE OF ISSUE						
	DAY	31	03	01						
	MONTH	10	10	12						
	YEAR	25	25	25						
REASON FOR ISSUE				N	N	N				
A = APPROVAL				C = CONSTRUCTION			N = COORDINATION			P = PRELIMINARY
										T = TENDER

DISTRIBUTION			NUMBER OF COPIES						
WWW.EDG.NET.AU			1E	1E	1E				
ROHRIG CONSTRUCTION			1E	1E	1E				
P = PRINT			T = TRACING		D = DISC		E = EMAIL		F = FAX

DOCUMENTS		REVISION							
C2154a-E01.dwg	LEGEND, NOTES & SITE PLAN	A	B	C					
C2154a-E02.dwg	FLOOR PLAN	A	B						
C2154a-0001.xls	CONTRACT DOCUMENT SCHEDULE	A	B	C					

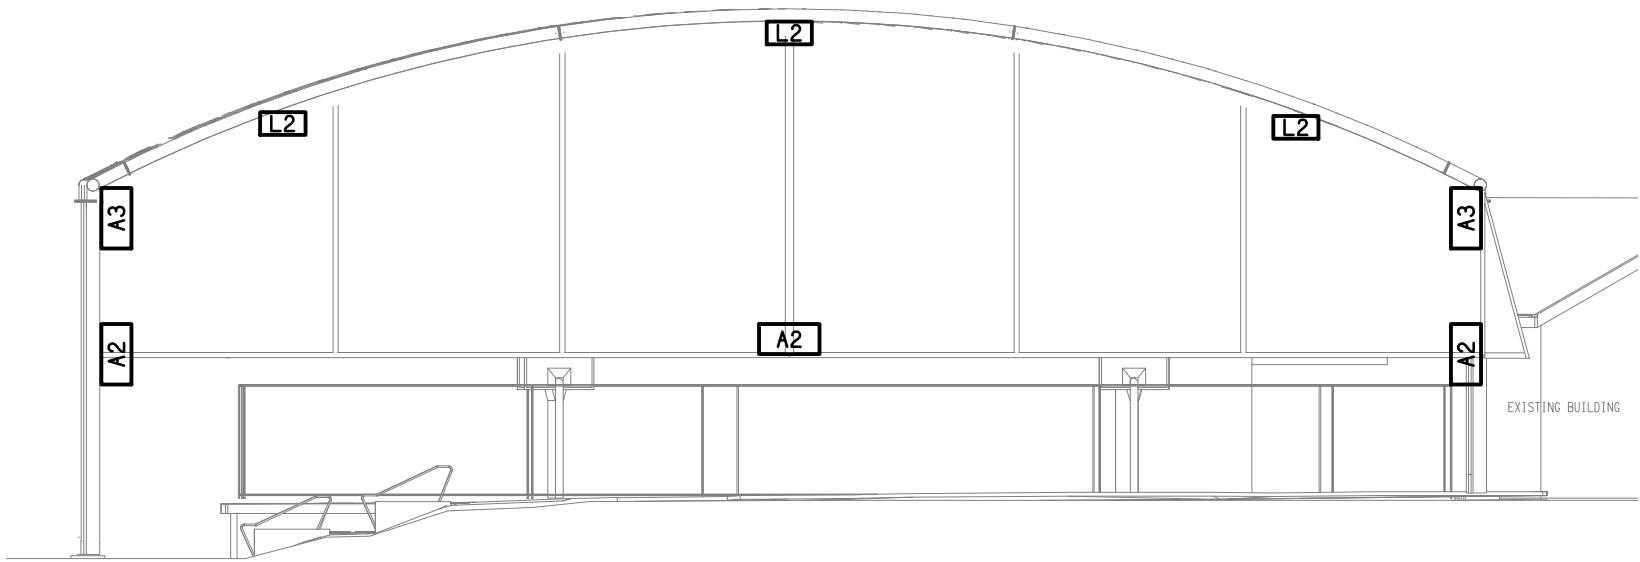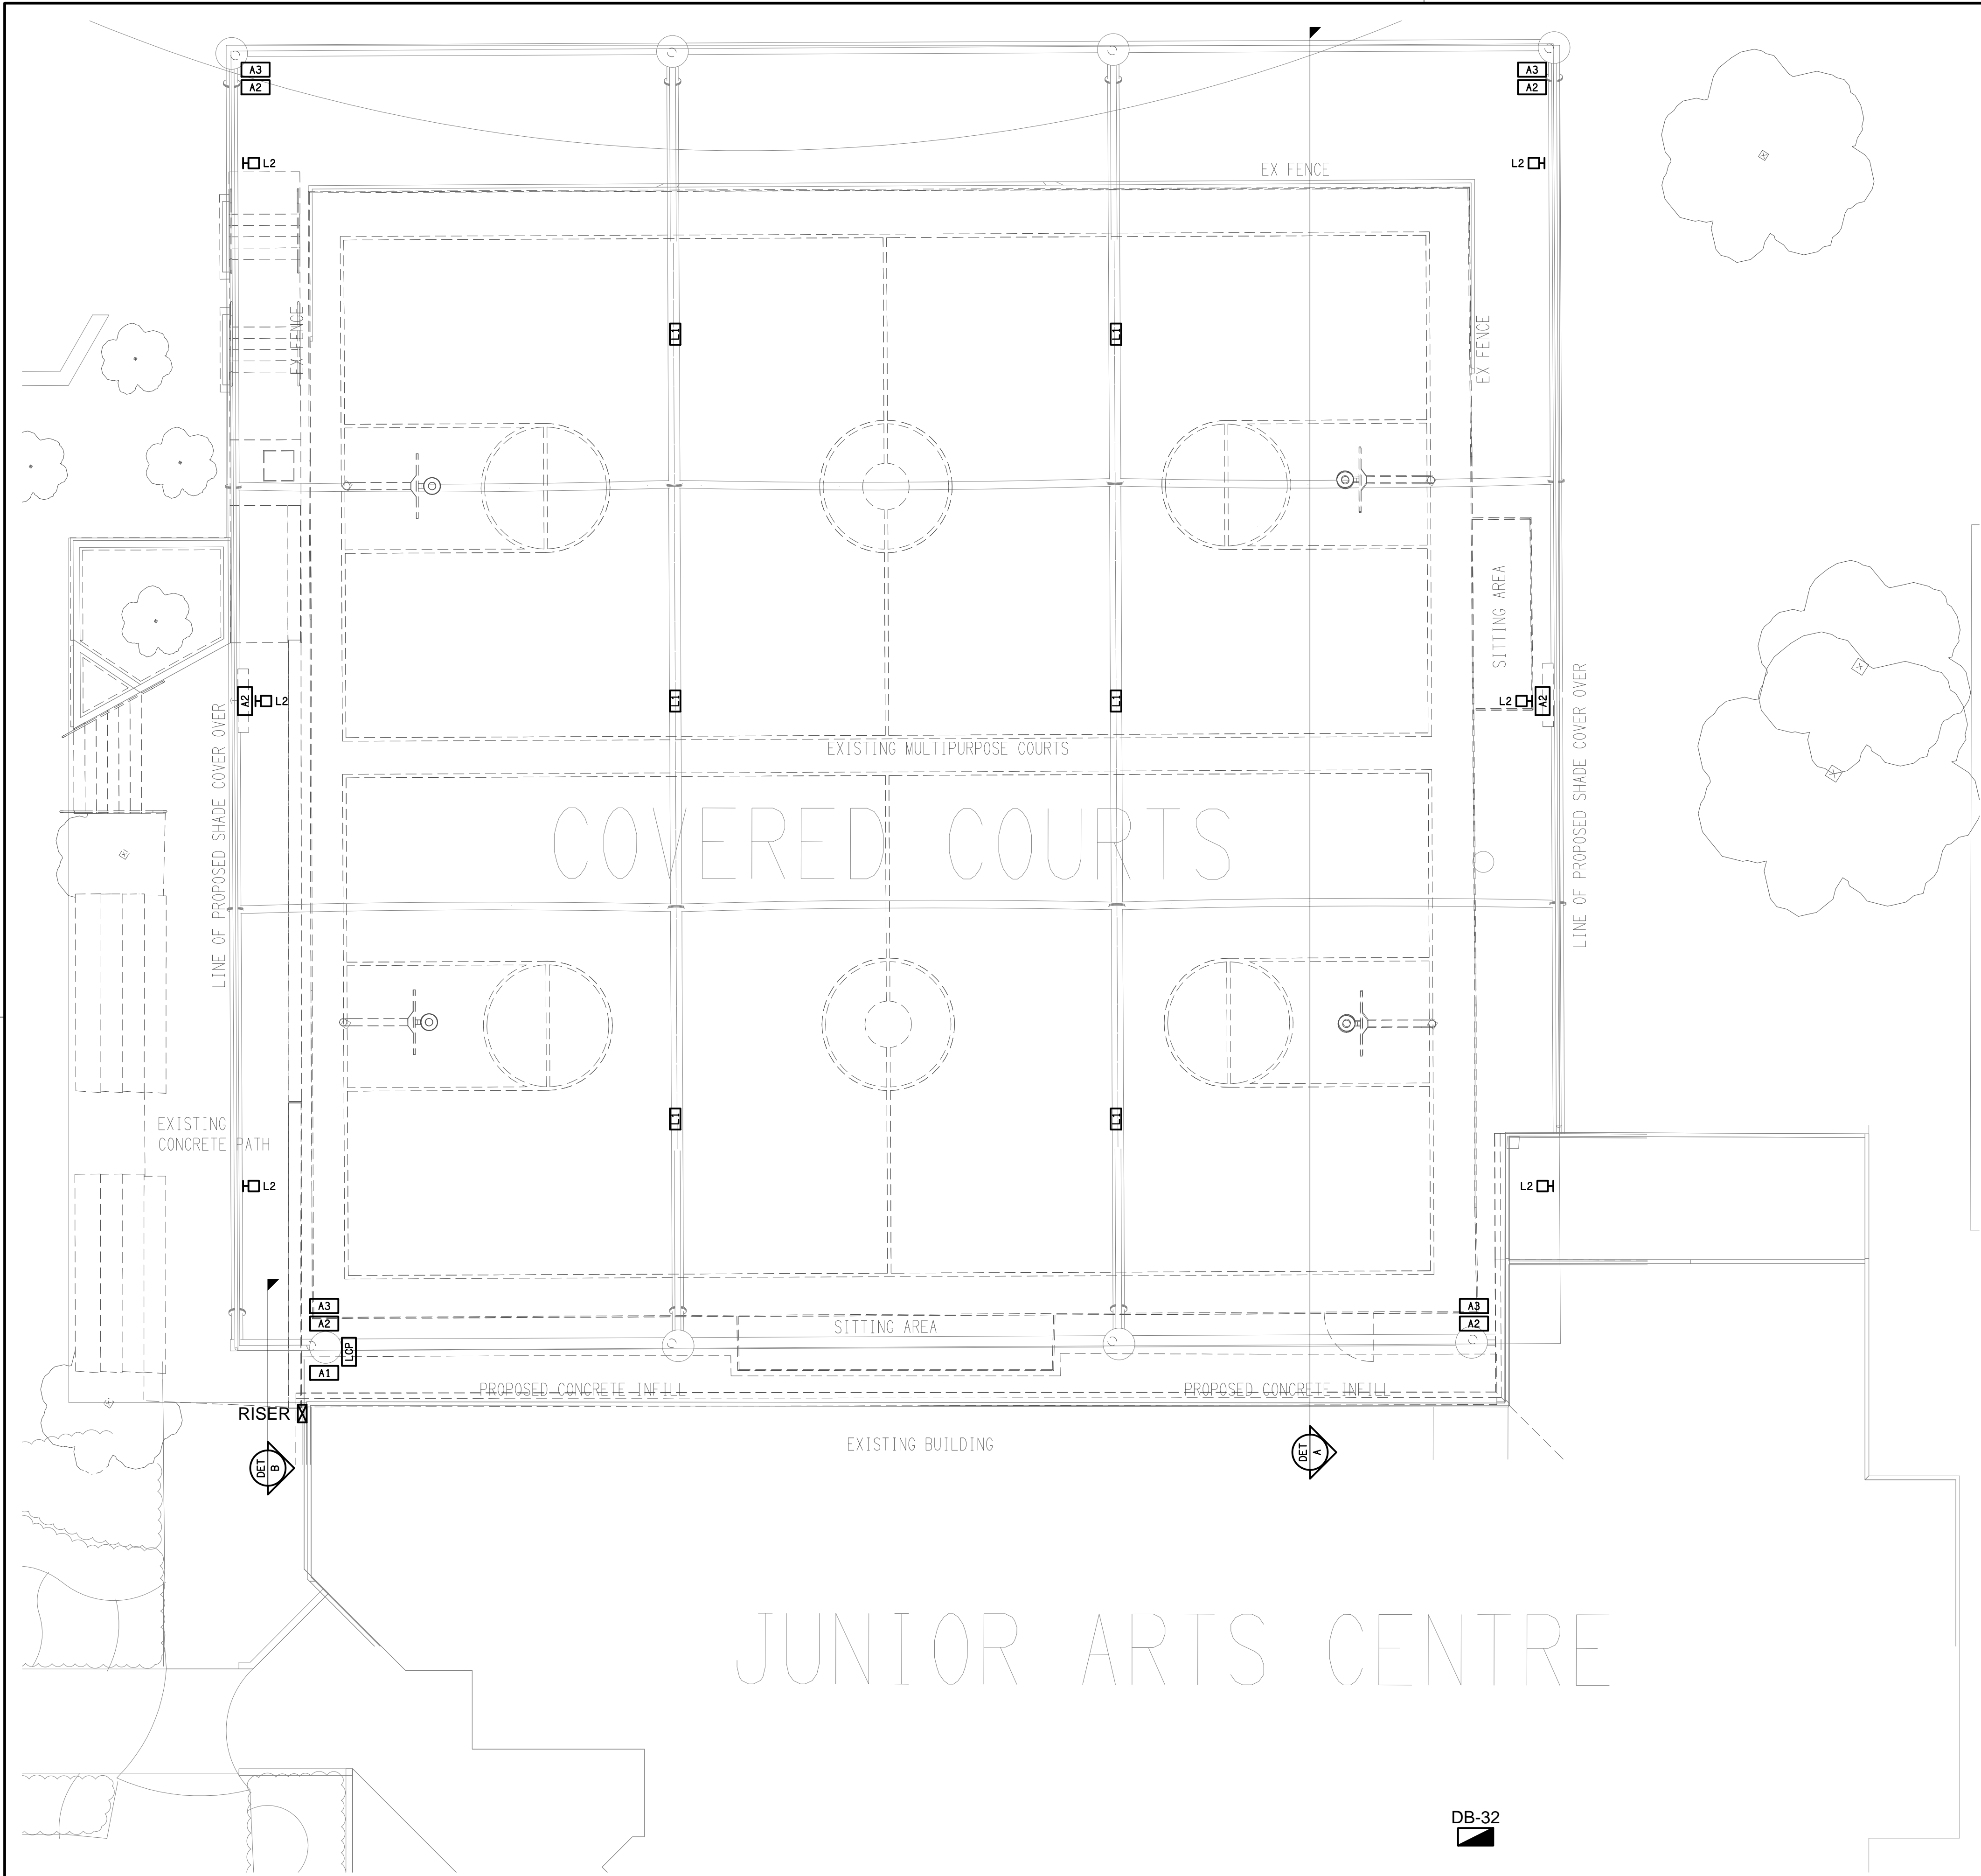

DETAIL A
COVERED COURTS SECTION
SCALE 1: 200

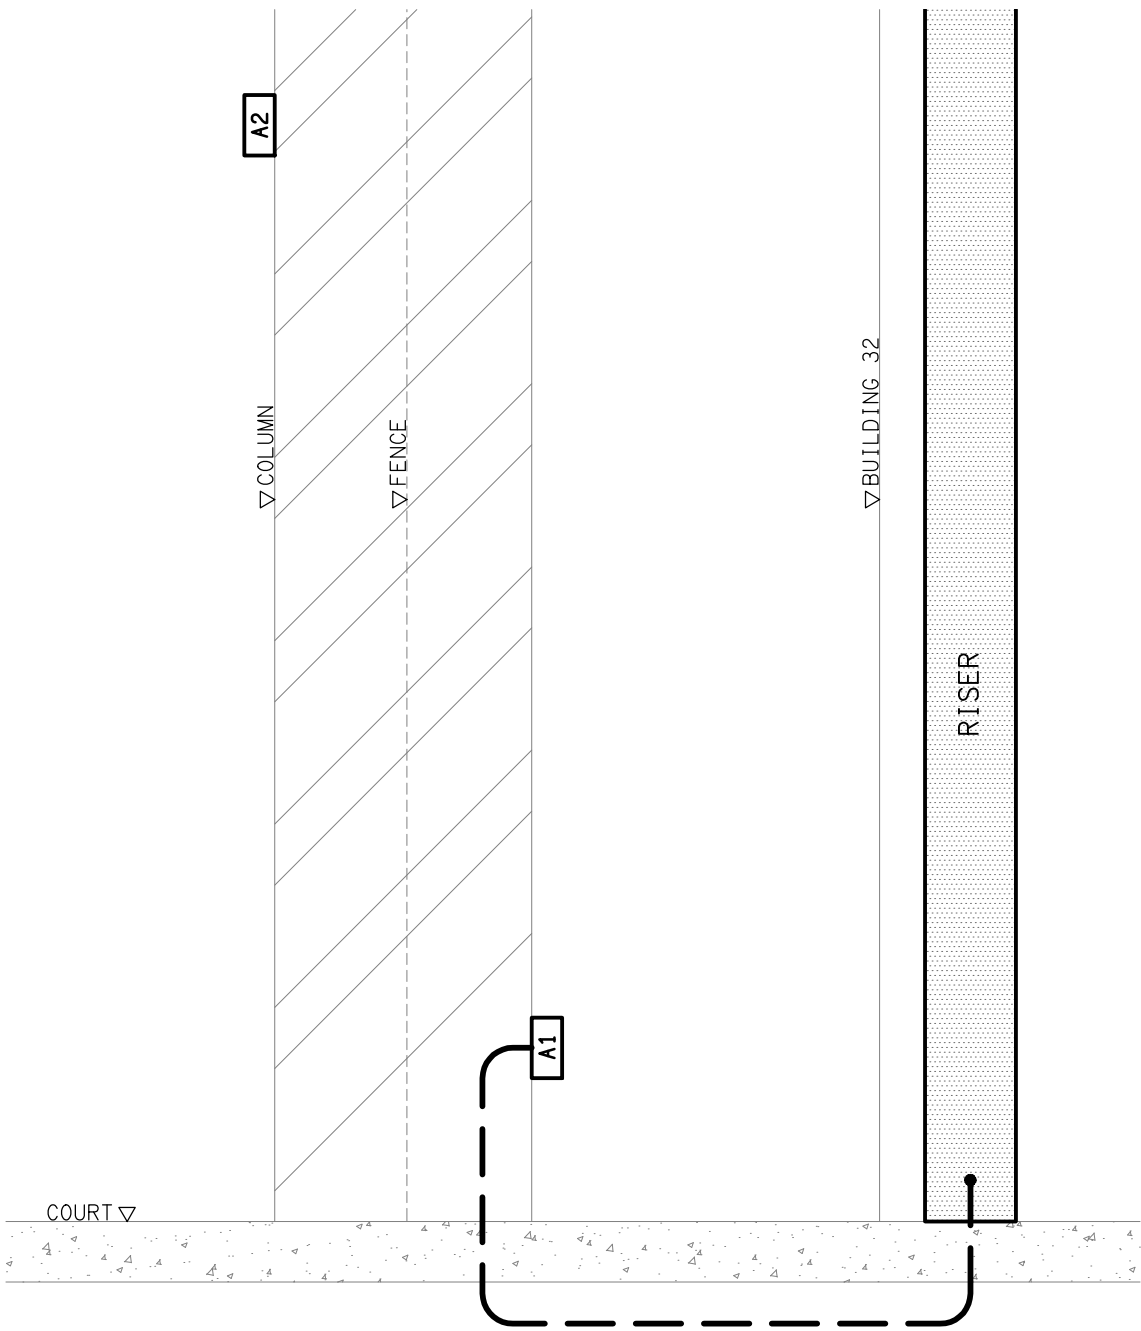

DETAIL B
A1 / A2 / RISER SECTION
NOT TO SCALE

ELECTRICAL DESIGN GROUP BRISBANE
PTY LTD
ACN 092 710 793
TRADING AS:
ELECTRICAL DESIGN GROUP

THE COPYRIGHT OF THIS DRAWING
REMAINS THE PROPERTY OF THE
ELECTRICAL DESIGN GROUP.
USE FIGURED DIMENSIONS
IN PREFERENCE TO SCALE.
ALL DIMENSIONS TO BE
VERIFIED ONSITE.

ELECTRICAL DESIGN GROUP
ELECTRICAL BUILDING SERVICES CONSULTANTS
BRISBANE GOLD COAST

P.O.Box 15, Sherwood Q.4075
Phone: (07) 3278 4375
Email: brisbane@edg.net.au
Web: www.edg.net.au

PROJECT:
ORMISTON COLLEGE - COVERED COURTS
97-127 DUNDAS STREET, ORMISTON

B INFORMATION		03/11/2025
REV:	DESCRIPTION:	DATE:
DRAWING: ELECTRICAL SERVICES FLOOR PLAN		
SCALE: 1:100 UNO	AT A1	PROJECT NO: C2154a
		DRAWING NO: E02
		REVISION: B