


THE COPYRIGHT OF THIS DRAWING REMAINS THE PROPERTY OF THE ELECTRICAL DESIGN GROUP.

USE FIGURED DIMENSIONS IN PREFERENCE TO SCALE.

ALL DIMENSIONS TO BE VERIFIED ONSITE.

ELECTRICAL SERVICES
WITHIN THIS DASH LINED
AREA ARE TO BE REMOVED

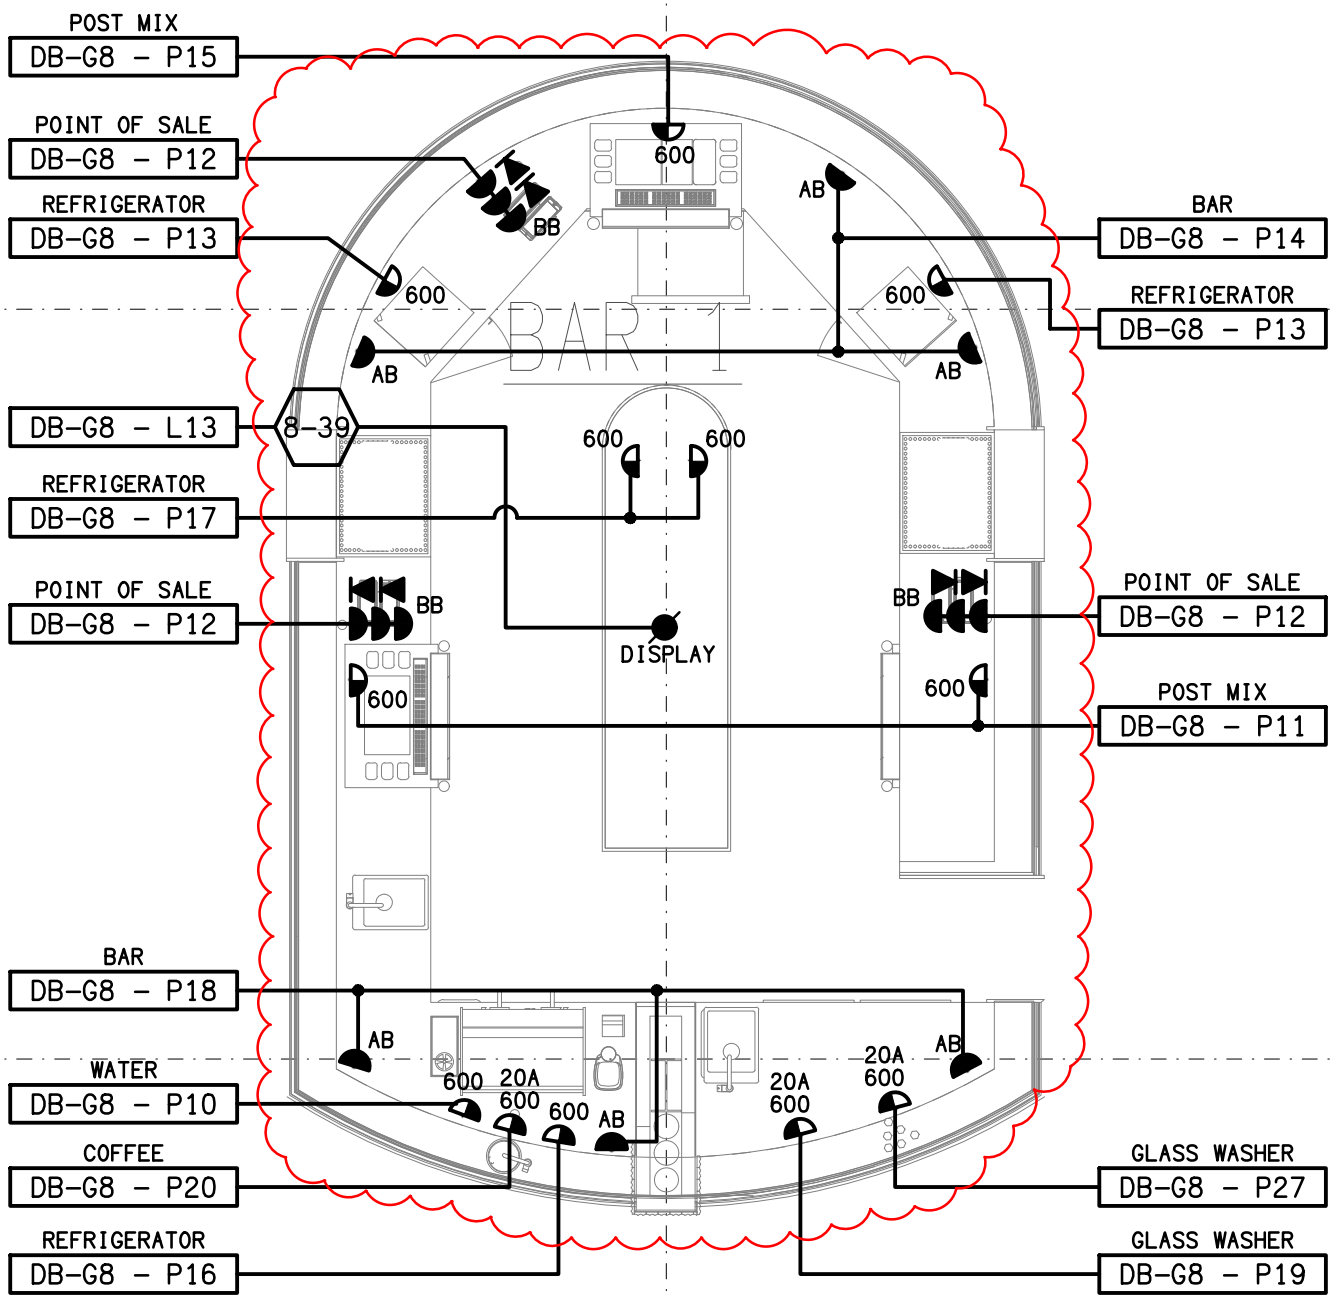

DETAIL A
BISTRO BAR FLOOR PLAN
SCALE 1:50

H	CONSTRUCTION	28/11/2025
REV:	DESCRIPTION:	DATE:

ELECTRICAL DESIGN GROUP
ELECTRICAL BUILDING SERVICES CONSULTANTS

BRISBANE: P.O. Box 15 Sherwood Qld 4075
Phone: (07) 3278 4375
Email: brisbane@edg.net.au
Web: www.edg.net.au

ELECTRICAL DESIGN GROUP BRISBANE
PTY LTD
ACN 092 710 793

TRADING AS:
ELECTRICAL DESIGN
GROUP

PROJECT:
**SUNNYBANK COMMUNITY
SPORTS CLUB**

SITE ADDRESS:
470 McCULLOUGH STREET
SUNNYBANK

SCALE: 1:100 UNO SHEET SIZE: AT A1

DRAWING TITLE:
**ELECTRICAL SERVICES
BISTRO & BAR
FLOOR PLAN**

PROJECT NO: DRAWING NO: REVISION:
C3179a E05 H