


FLOOR PLAN
PROPOSED KITCHEN
SCALE 1: 50

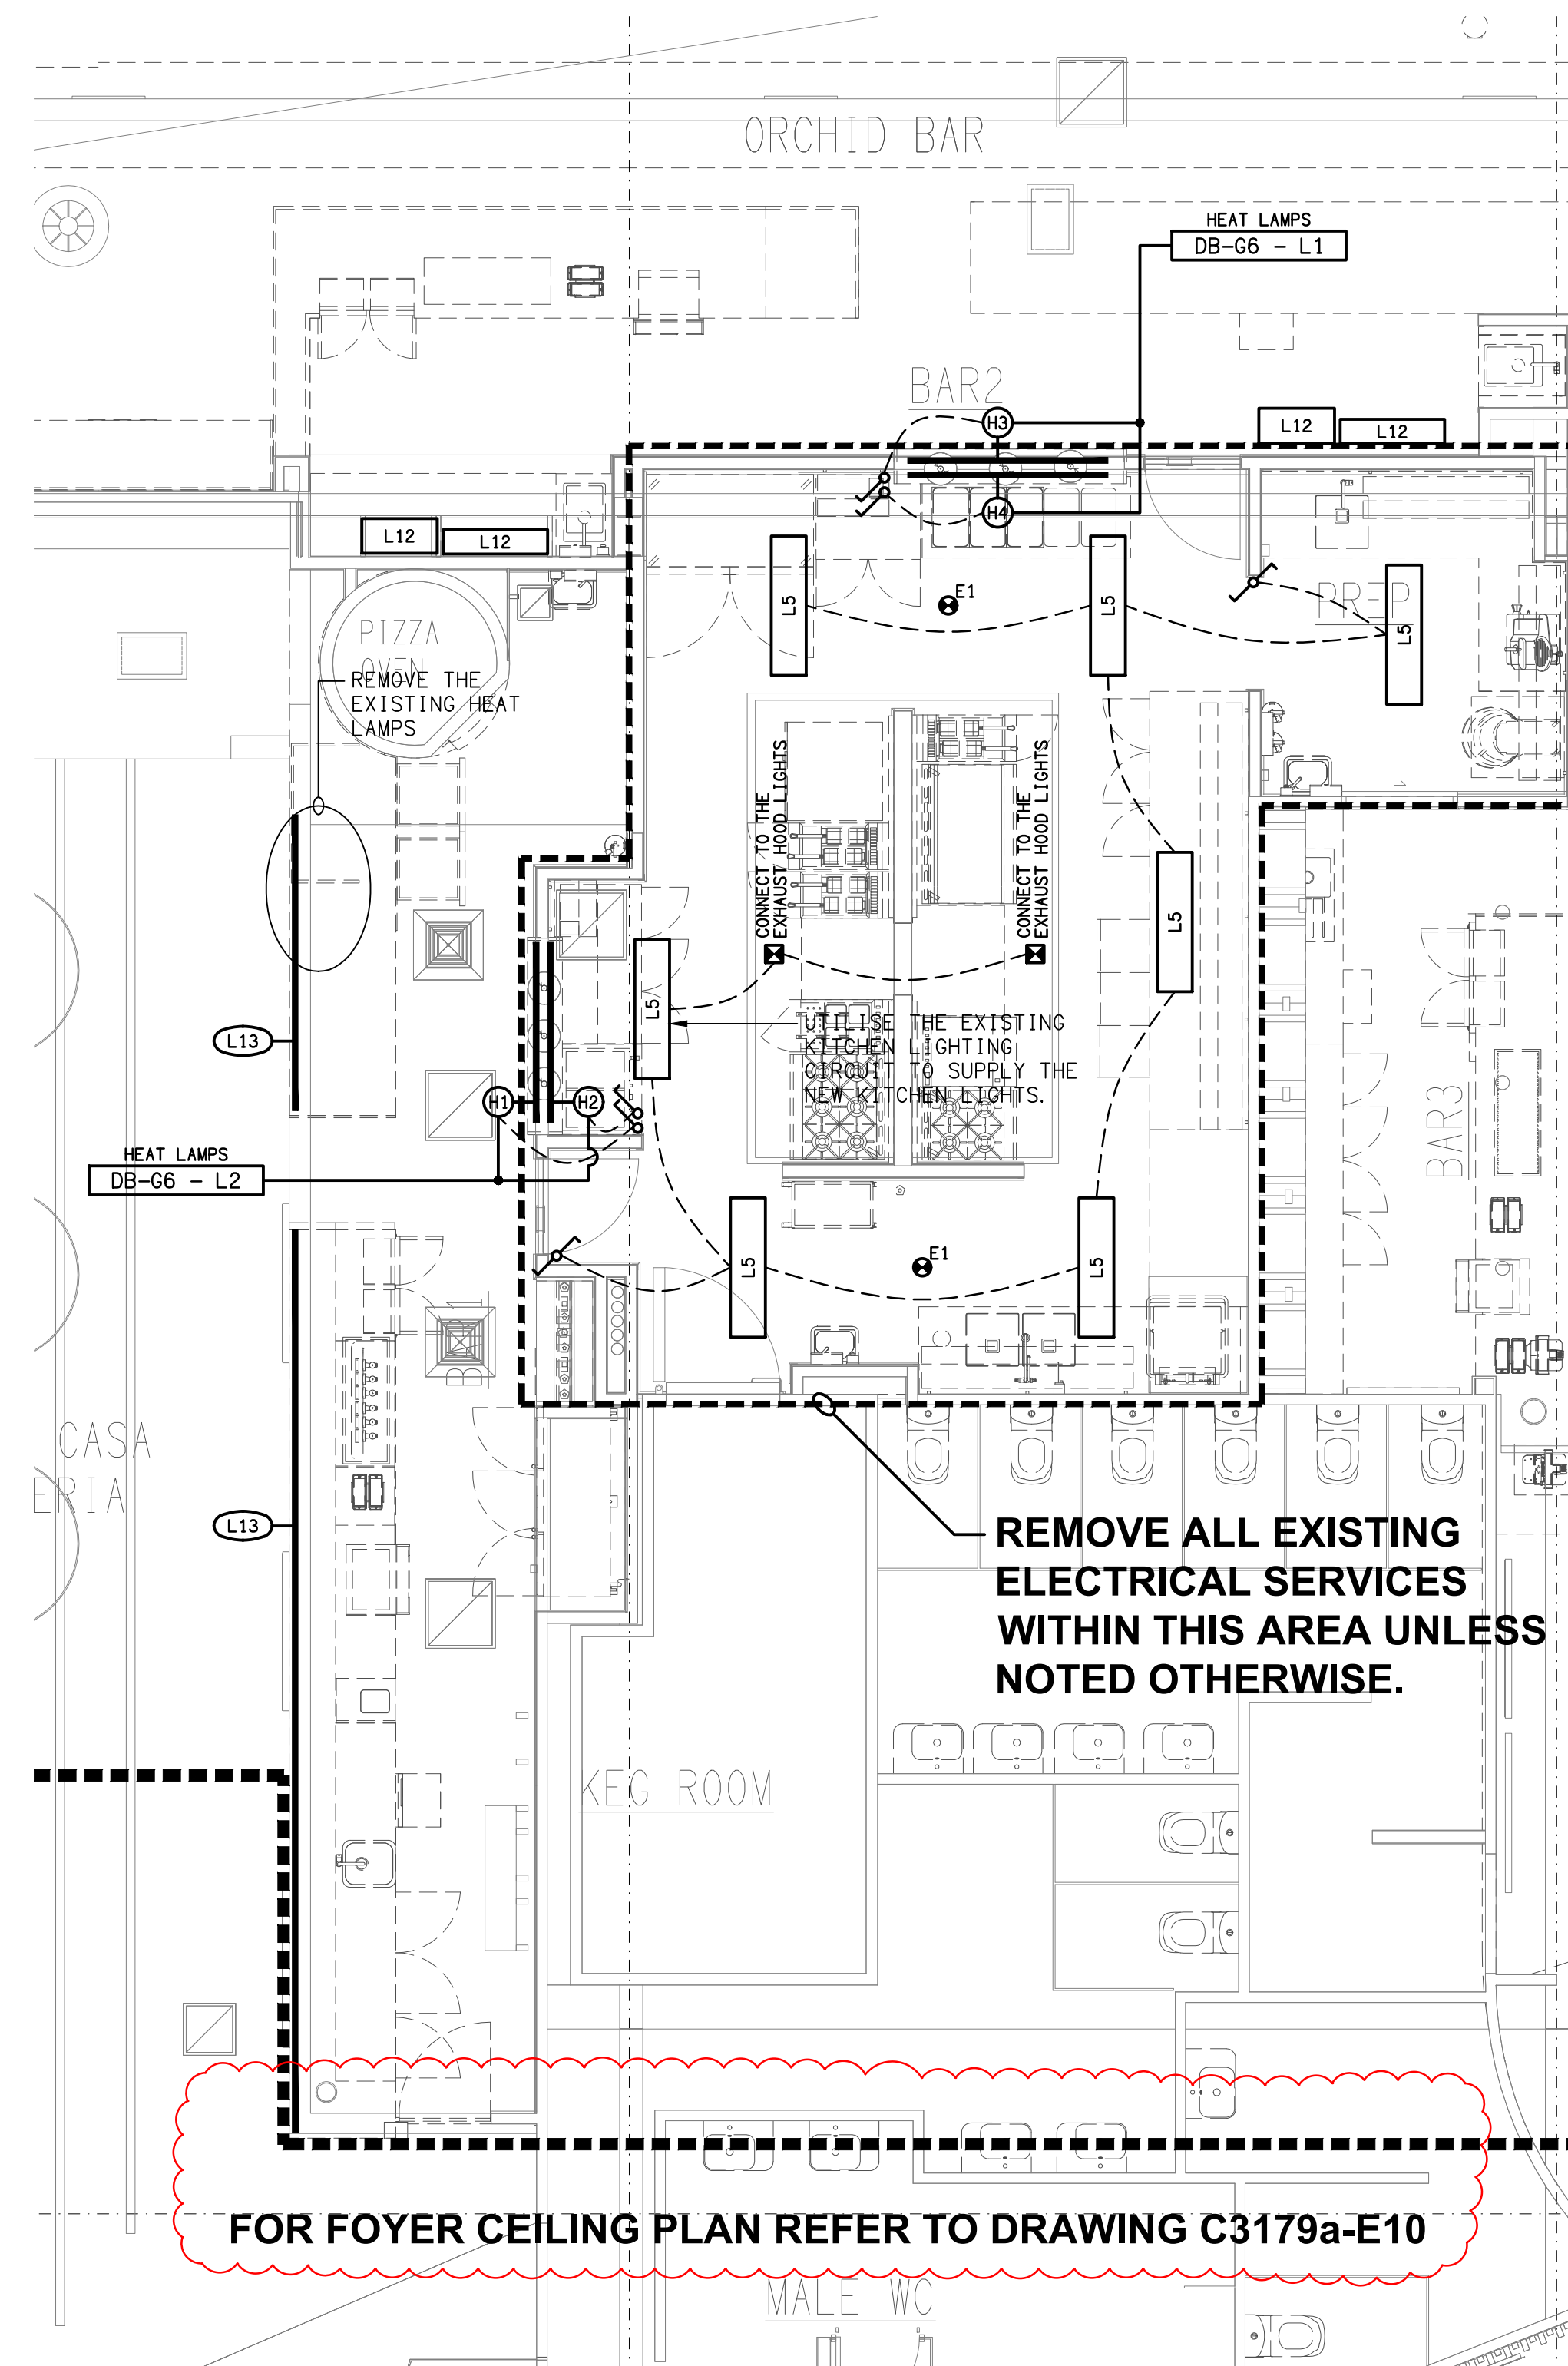

REFLECTED CEILING PLAN
PROPOSED KITCHEN
SCALE 1: 50

THE COPYRIGHT OF THIS DRAWING REMAINS THE PROPERTY OF THE ELECTRICAL DESIGN GROUP.

USE FIGURED DIMENSIONS IN PREFERENCE TO SCALE.

ALL DIMENSIONS TO BE VERIFIED ONSITE.

L	CONSTRUCTION	04/08/2025
REV:	DESCRIPTION:	DATE:

ELECTRICAL DESIGN GROUP
ELECTRICAL BUILDING SERVICES CONSULTANTS

BRISBANE: P.O. Box 15 Sherwood Qld 4075
Phone: (07) 3278 4375
Email: brisbane@edg.net.au
Web: www.edg.net.au

ELECTRICAL DESIGN GROUP BRISBANE PTY LTD
ACN 092 710 793

TRADING AS:
ELECTRICAL DESIGN GROUP

PROJECT:
SUNNYBANK COMMUNITY SPORTS CLUB

SITE ADDRESS:
470 McCULLOUGH STREET
SUNNYBANK

SCALE: 1:50 UNO AT A1

DRAWING TITLE:
**ELECTRICAL SERVICES
GROUND LEVEL
KITCHEN PLANS**

PROJECT NO: DRAWING NO: REVISION:
C3179a E07 L