



DETAIL B
TYPICAL TV 65" OUTLET ELEVATION
NOT TO SCALE

DETAIL C
TYPICAL TV 75" OUTLET ELEVATION
NOT TO SCALE

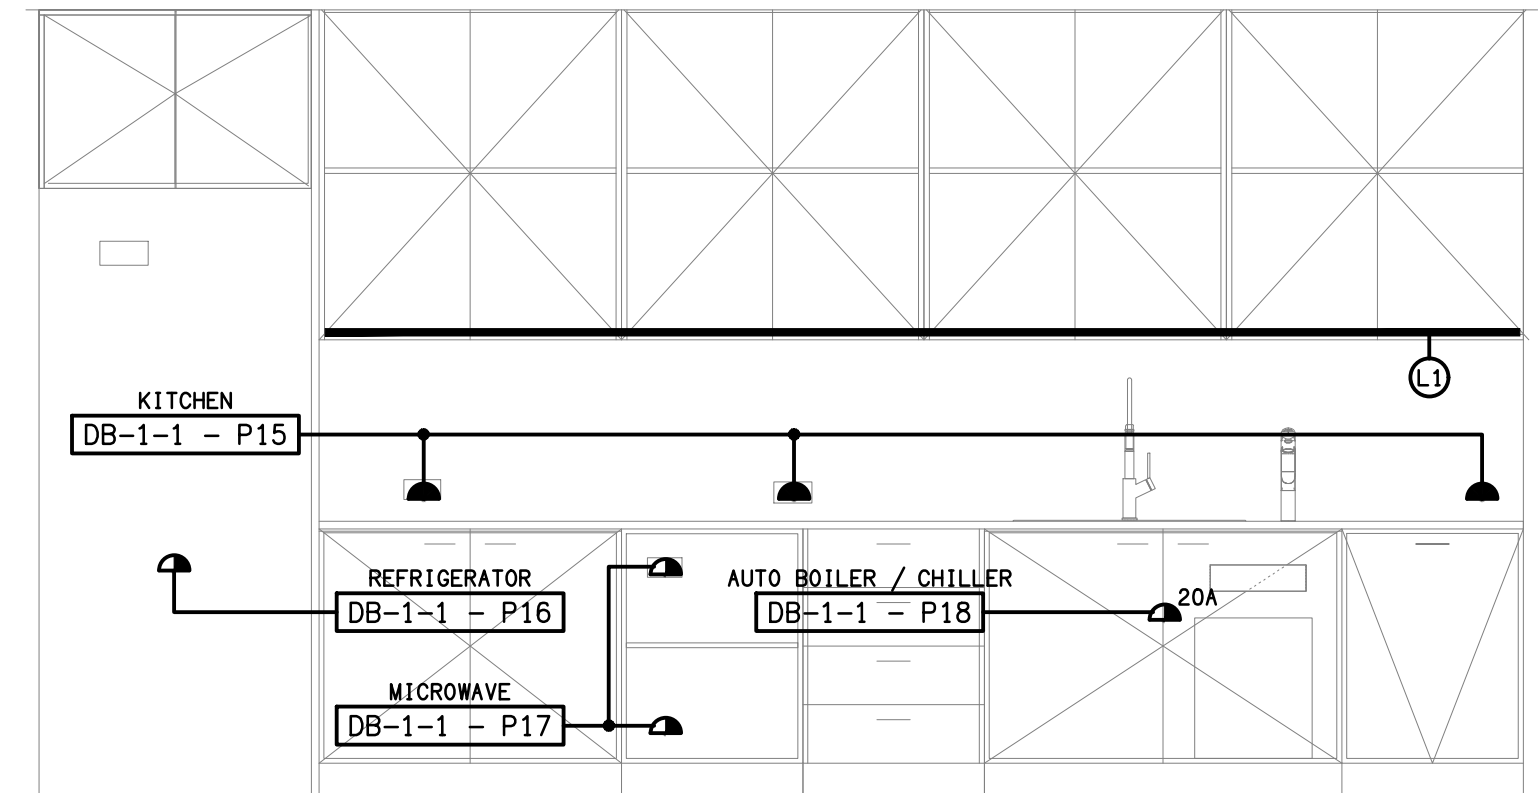

DETAIL A
STAFF KITCHENETTE ELEVATION
SCALE 1:25

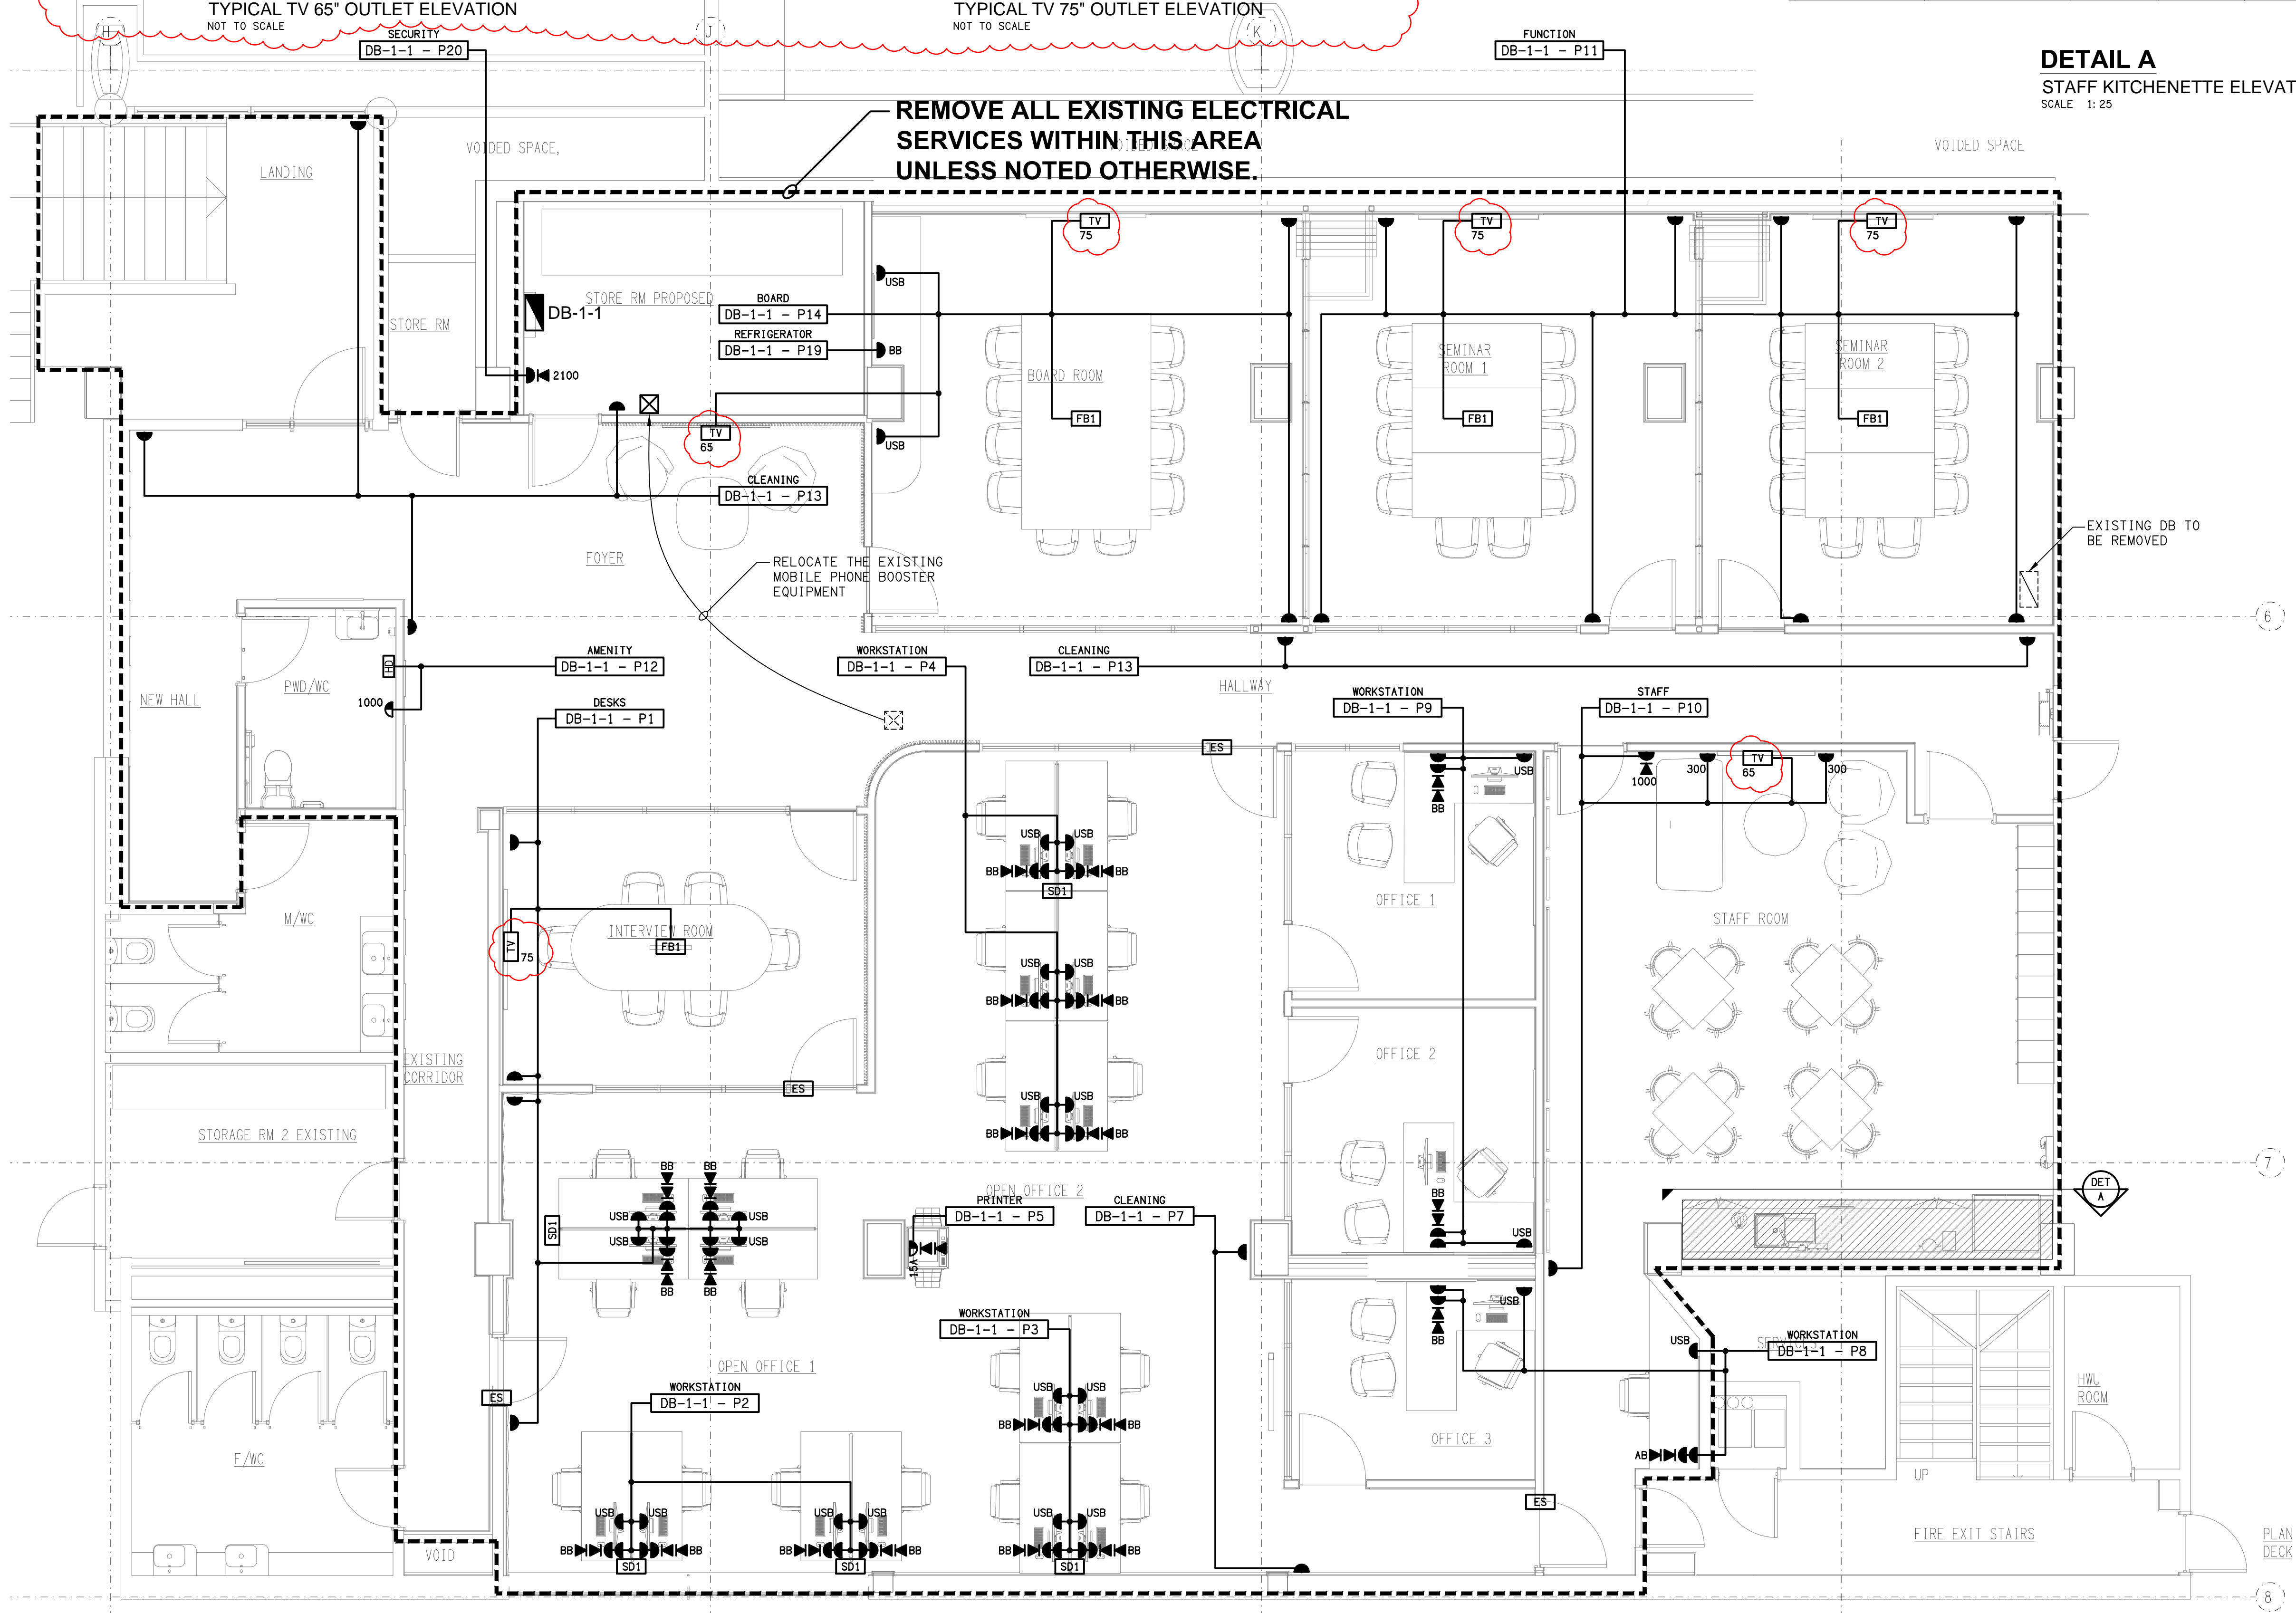

THE COPYRIGHT OF THIS DRAWING REMAINS THE PROPERTY OF THE ELECTRICAL DESIGN GROUP.
USE FIGURED DIMENSIONS IN PREFERENCE TO SCALE.
ALL DIMENSIONS TO BE VERIFIED ONSITE.

J	CONSTRUCTION	11/07/2025
REV:	DESCRIPTION:	DATE:

ELECTRICAL DESIGN GROUP
ELECTRICAL BUILDING SERVICES CONSULTANTS

BRISBANE: P.O. Box 15 Sherwood Qld 4075
Phone: (07) 3278 4375
Email: brisbane@edg.net.au
Web: www.edg.net.au

ELECTRICAL DESIGN GROUP BRISBANE PTY LTD
ACN 092 710 793

TRADING AS:
ELECTRICAL DESIGN GROUP

PROJECT:
SUNNYBANK COMMUNITY SPORTS CLUB

SITE ADDRESS:
470 McCULLOUGH STREET
SUNNYBANK

SCALE: 1:50 UNO
SHEET SIZE: AT A1

DRAWING TITLE:

**ELECTRICAL SERVICES
LEVEL 1 OFFICE
FLOOR PLAN**

PROJECT NO: DRAWING NO: REVISION:

C3179a E08 J