




SCHEMATIC
SWITCH PANEL SP1, SP2 & SP3
NOT TO SCALE

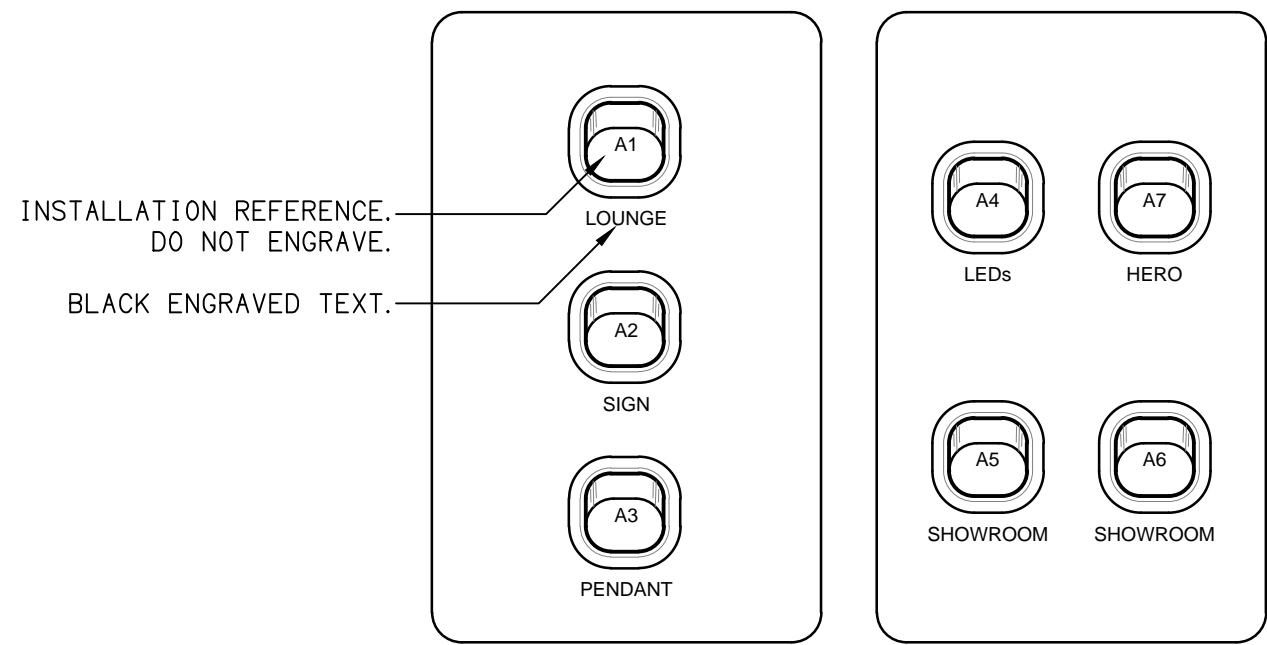


DETAIL
SWITCH PANEL SP1 ELEVATION
NOT TO SCALE

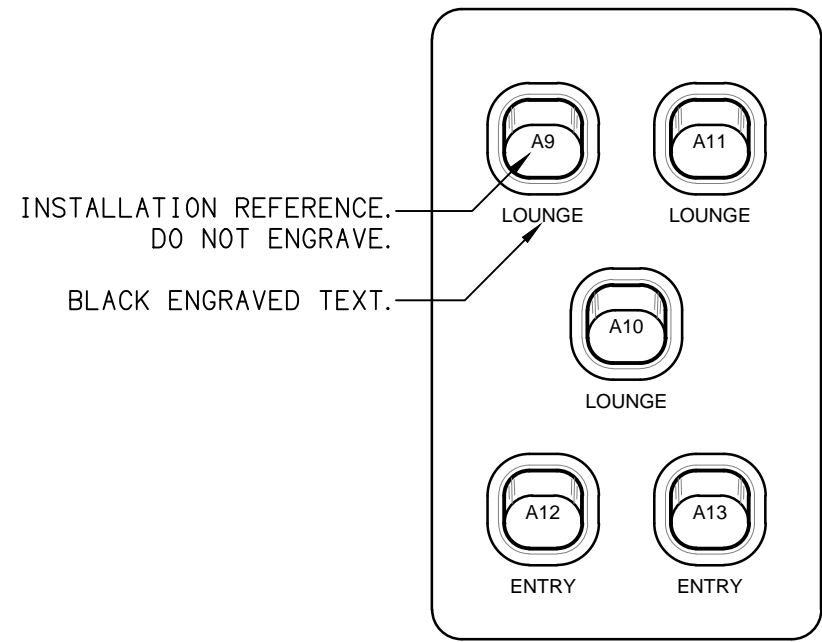


DETAIL
SWITCH PANEL SP2 ELEVATION
NOT TO SCALE

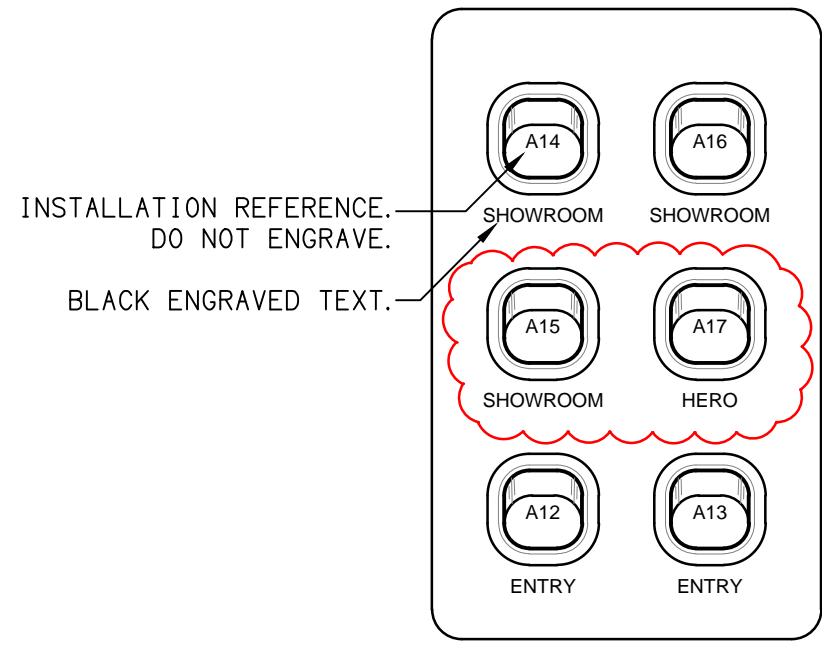

DETAIL
SWITCH PANEL SP3 ELEVATION
NOT TO SCALE

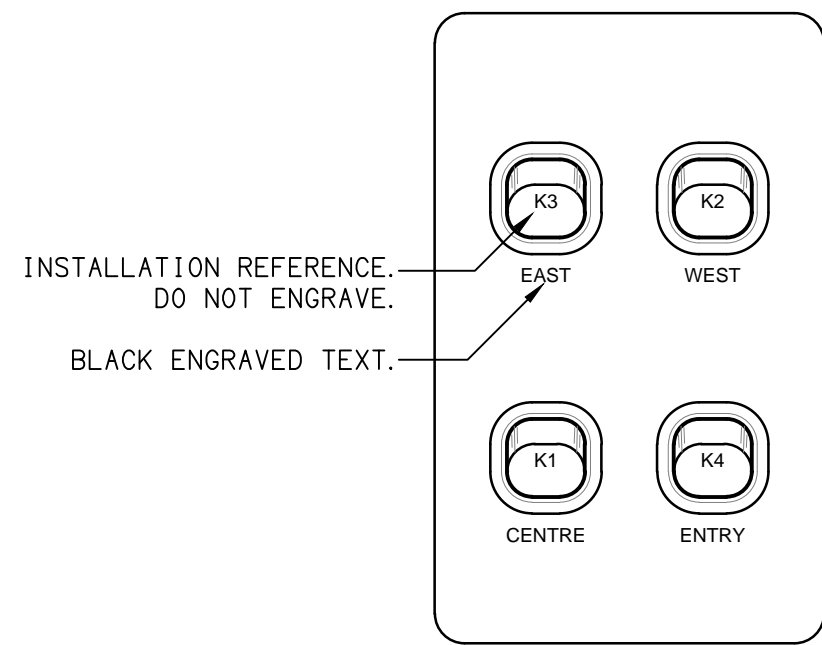

DETAIL
SWITCH PANEL SPK ELEVATION
NOT TO SCALE

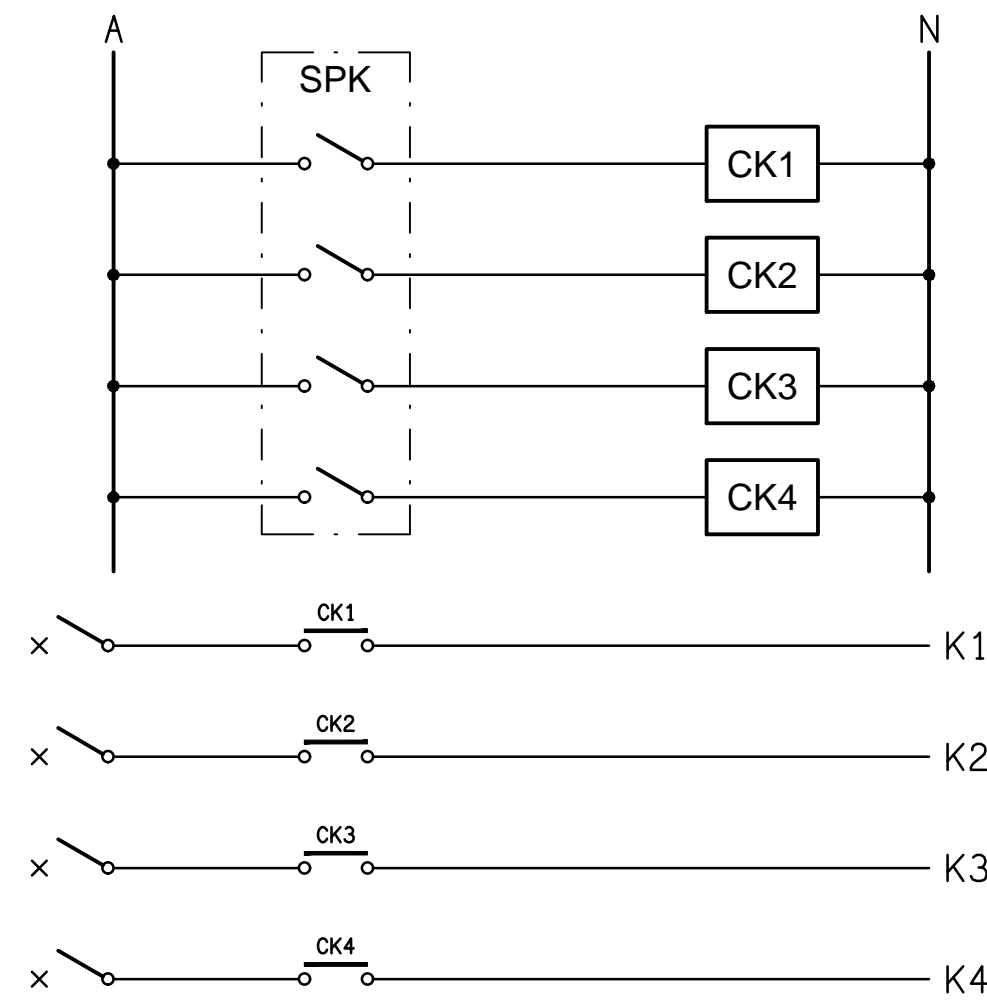

SCHEMATIC
SWITCH PANEL SPK
NOT TO SCALE

ELECTRICAL DESIGN GROUP BRISBANE
PTY LTD
ACN 092 710 793
TRADING AS:
ELECTRICAL DESIGN GROUP

THE COPYRIGHT OF THIS DRAWING
REMAINS THE PROPERTY OF THE
ELECTRICAL DESIGN GROUP.
USE FIGURED DIMENSIONS
IN PREFERENCE TO SCALE.
ALL DIMENSIONS TO BE
VERIFIED ONSITE.

ELECTRICAL DESIGN GROUP
ELECTRICAL BUILDING SERVICES CONSULTANTS
BRISBANE GOLD COAST

P.O. Box 15, Sherwood Q.4075
Phone: (07) 3278 4375
Email: brisbane@edg.net.au
Web: www.edg.net.au

PROJECT:
TOOWONG KIA & MITSUBISHI

601 MILTON ROAD, TOOWONG

D	CONSTRUCTION	06/08/2025
REV.	DESCRIPTION:	DATE:

DRAWING:
ELECTRICAL SERVICES
LIGHTING CONTROL SCHEMATICS & DETAILS

SCALE: NOT TO SCALE	AT A1	PROJECT NO: C3227a	DRAWING NO: E07	REVISION: D
------------------------	-------	------------------------------	---------------------------	-----------------------