




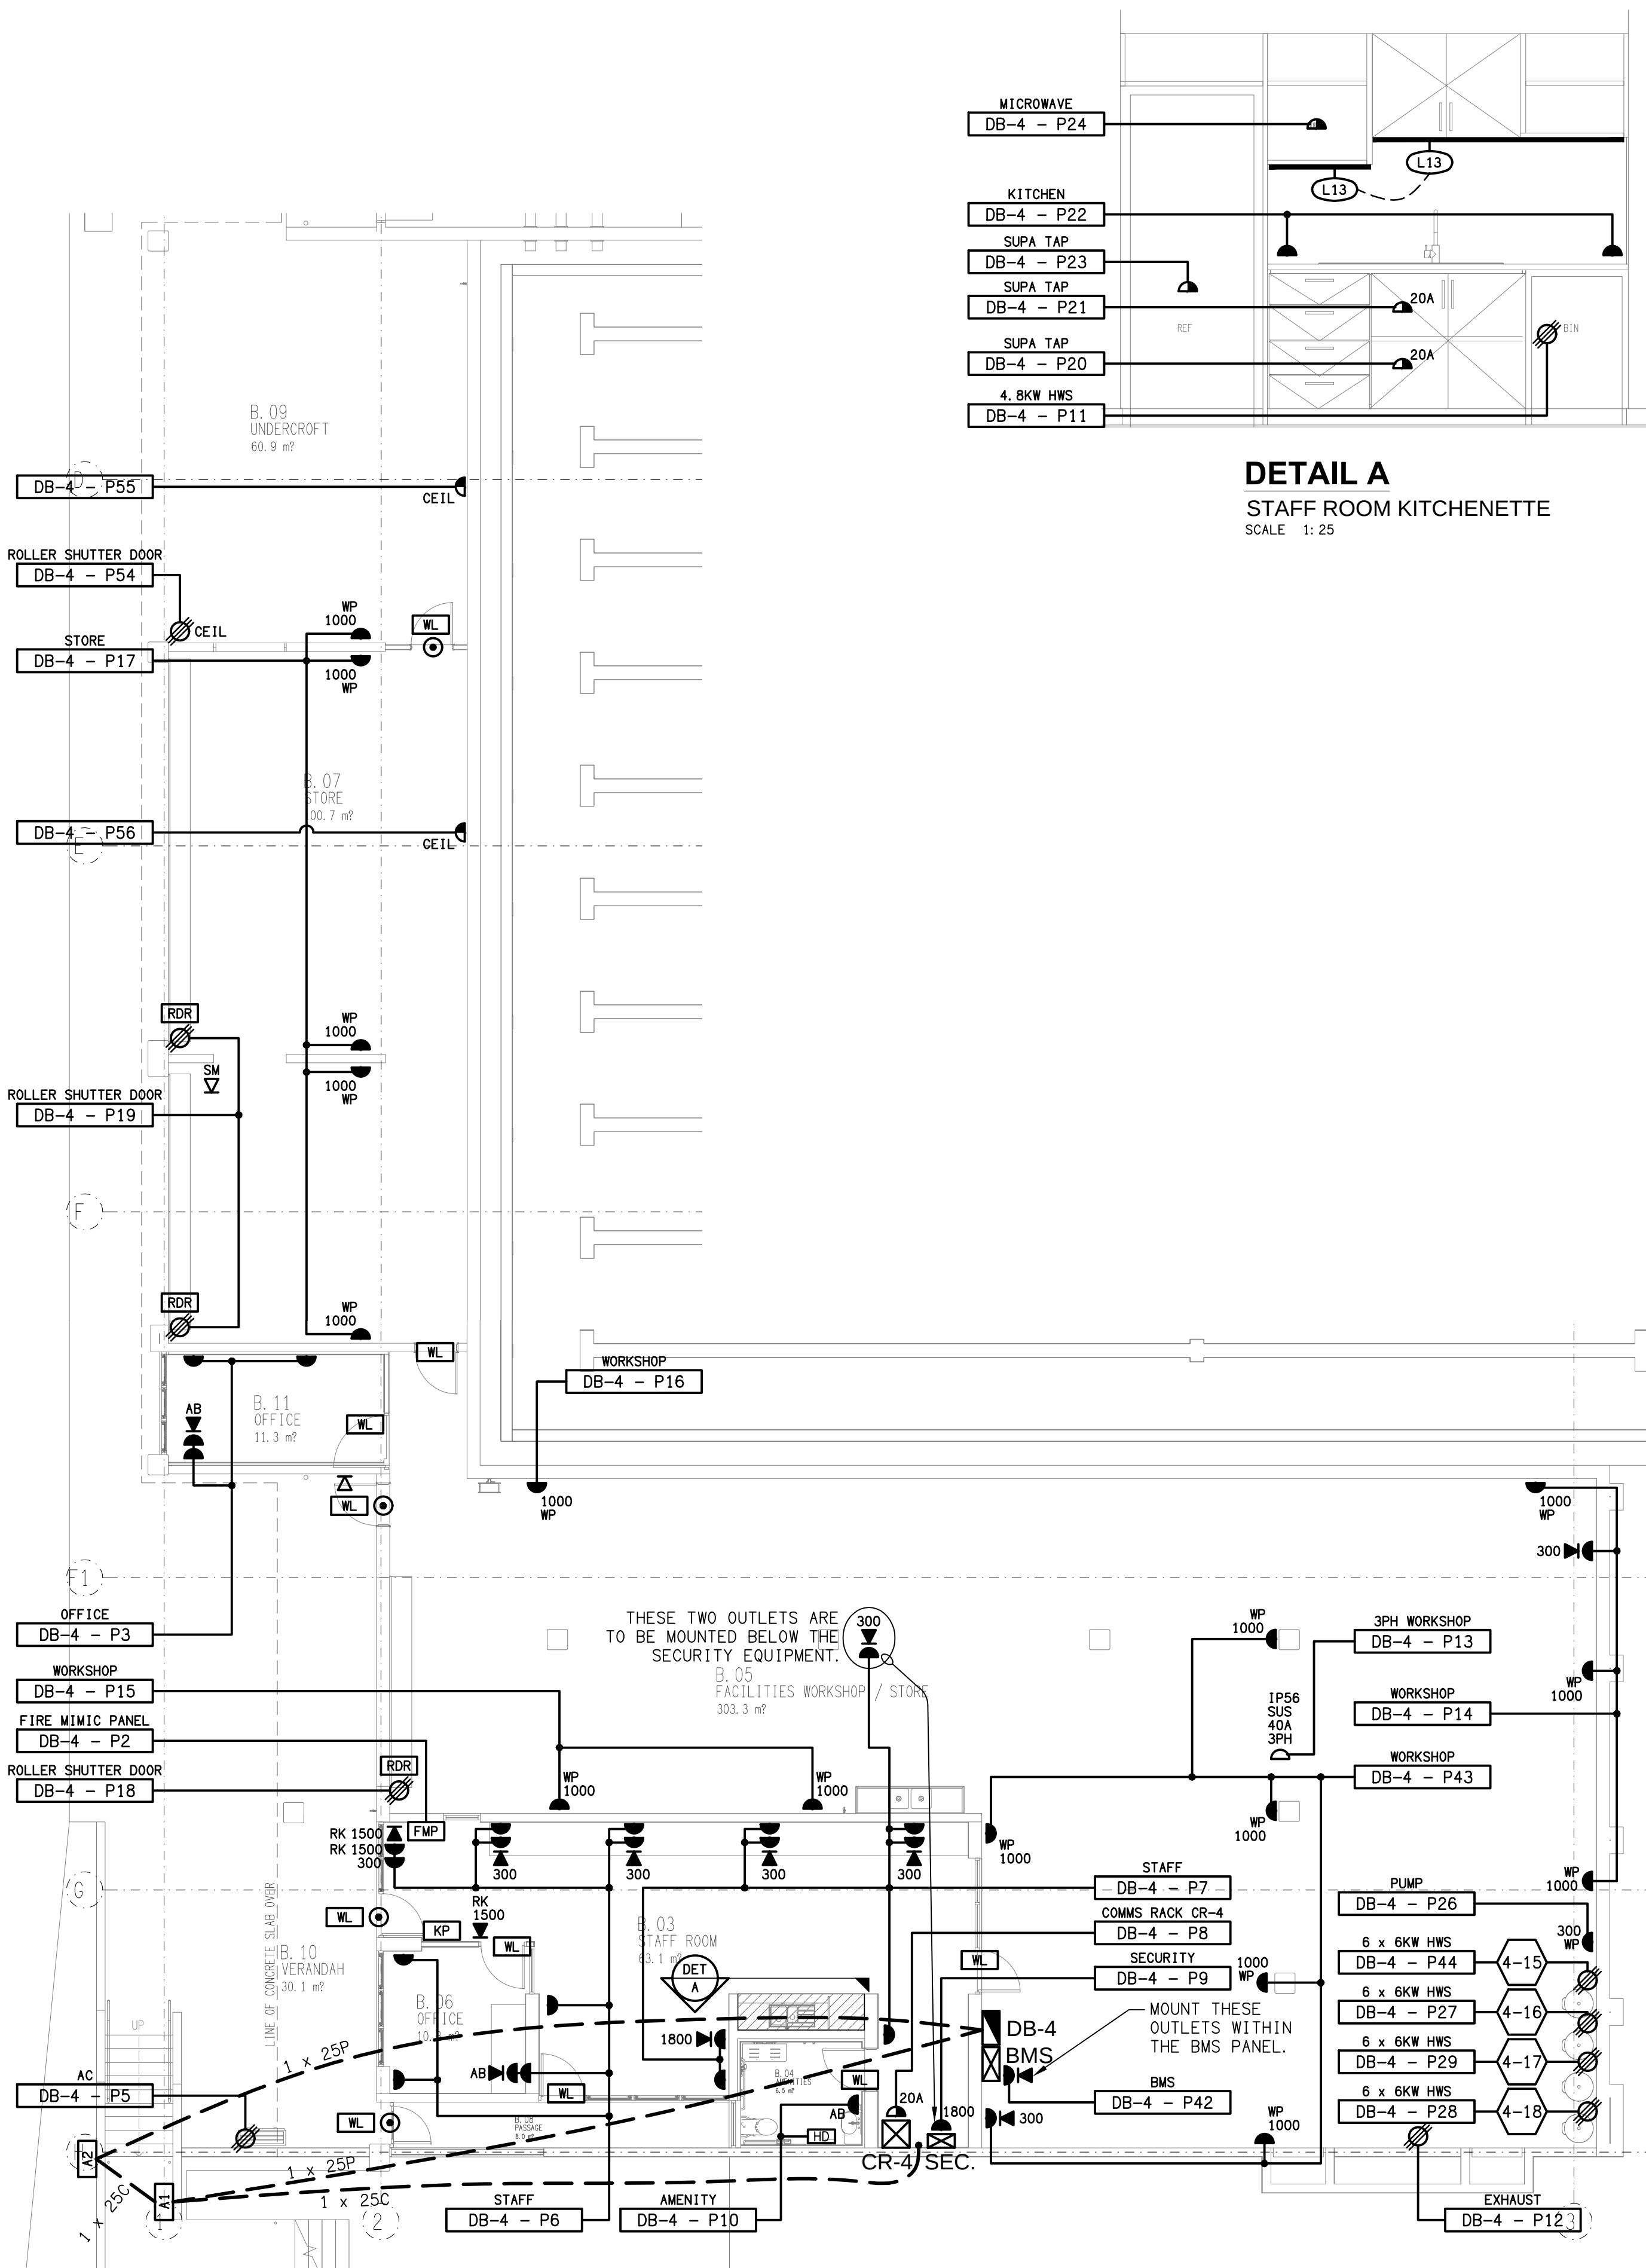

STAFF ROOMS
BASEMENT FLOOR PLAN
SCALE 1: 100

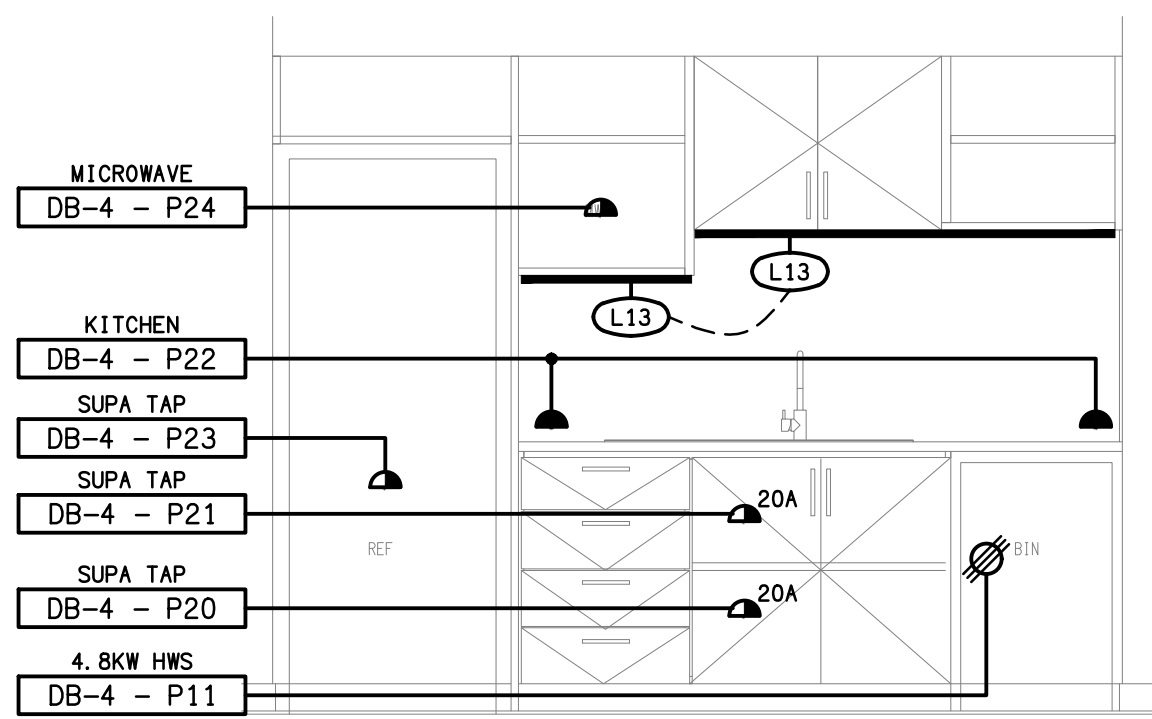

DETAIL A
STAFF ROOM KITCHENETTE
SCALE 1: 25

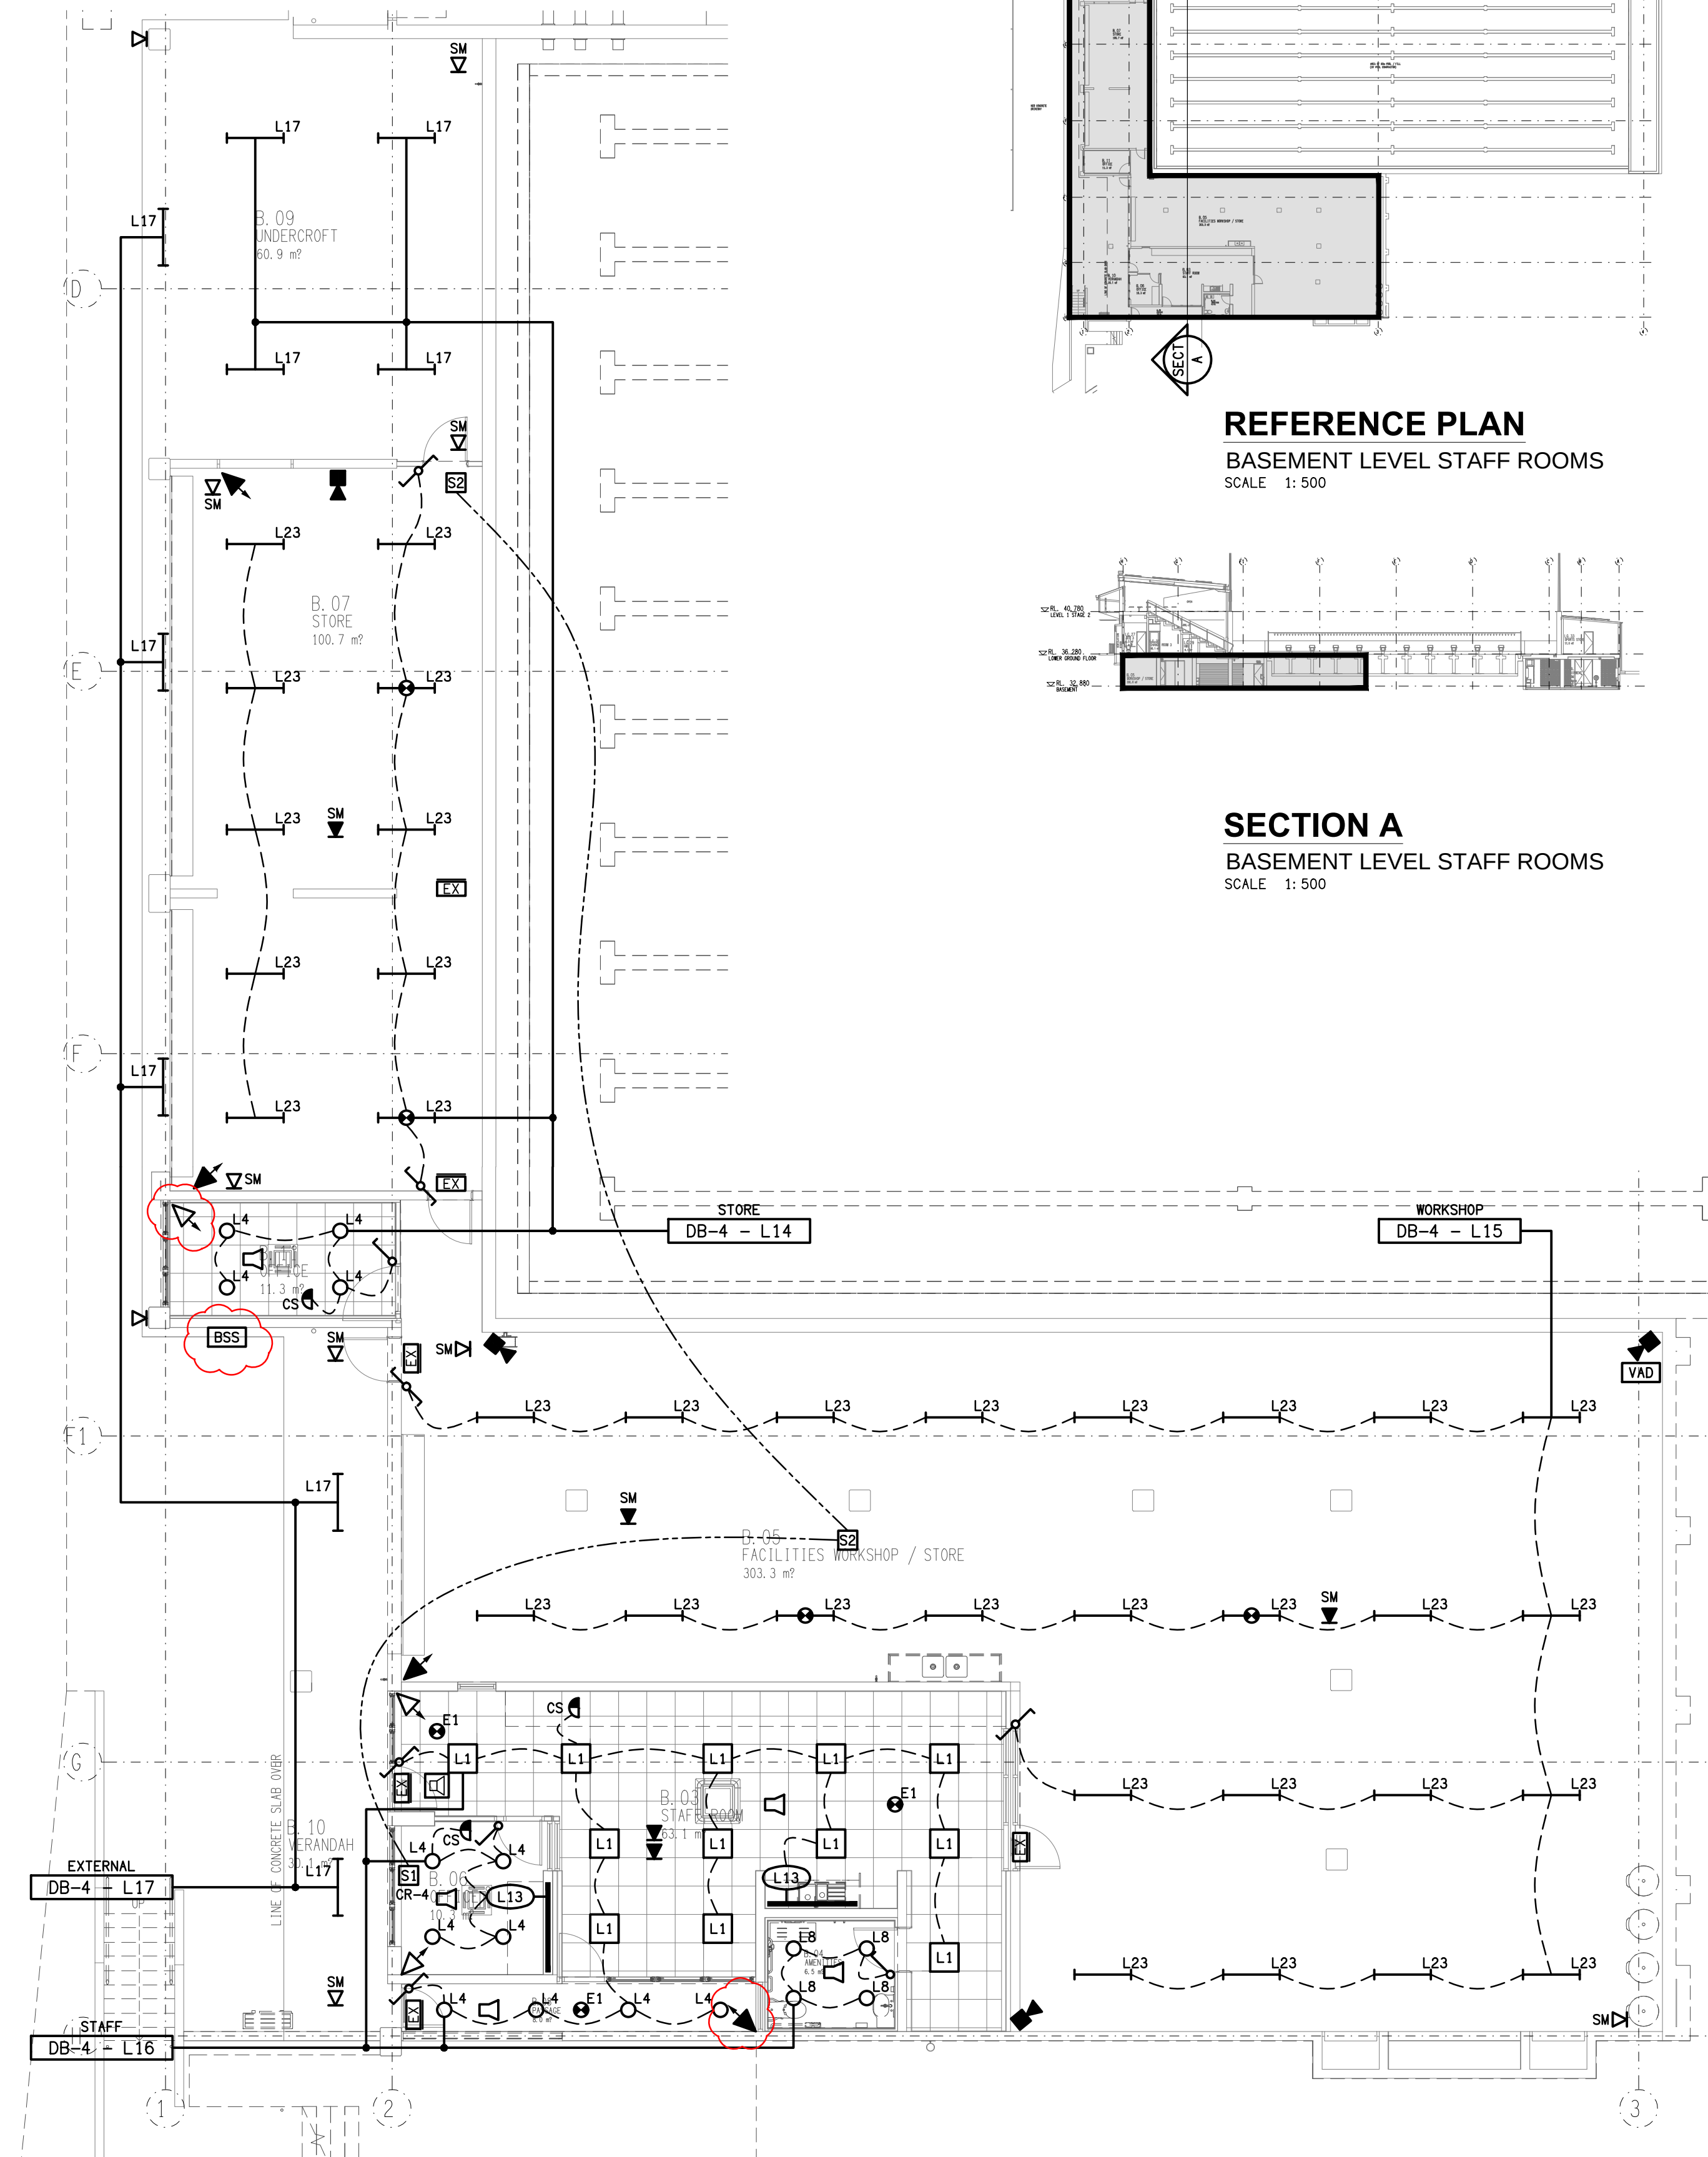

STAFF ROOMS
BASEMENT REFLECTED CEILING PLAN
SCALE 1: 100

REFERENCE PLAN
BASEMENT LEVEL STAFF ROOMS
SCALE 1: 500

SECTION A
BASEMENT LEVEL STAFF ROOMS
SCALE 1: 500

ELECTRICAL DESIGN GROUP BRISBANE
PTY LTD
ACN 092 710 793
TRADING AS:
ELECTRICAL DESIGN GROUP

THE COPYRIGHT OF THIS DRAWING
REMAINS THE PROPERTY OF THE
ELECTRICAL DESIGN GROUP.
USE FIGURED DIMENSIONS
IN PREFERENCE TO SCALE.
ALL DIMENSIONS TO BE
VERIFIED ONSITE.

ELECTRICAL DESIGN GROUP
ELECTRICAL BUILDING SERVICES CONSULTANTS
BRISBANE GOLD COAST

P.O. Box 15, Sherwood Q. 4075
Phone: (07) 3278 4375
Email: brisbane@edg.net.au
Web: www.edg.net.au

PROJECT:
**ST JOHN'S ANGLICAN COLLEGE
FOREST LAKE
AQUATIC CENTRE STAGE 2
COLLEGE AVENUE, FOREST LAKE**

E	TENDER	22/01/2026
REV.	DESCRIPTION:	DATE:

DRAWING:
**ELECTRICAL SERVICES
BASEMENT STAFF ROOM PLANS**

SCALE: 1:100 UNO	AT A1	PROJECT NO: C3230a	DRAWING NO: E05	REVISION: E
---------------------	-------	------------------------------	---------------------------	-----------------------