


**LIGHTING PLAN**  
LEVEL 1 REFLECTED CEILING PLAN  
SCALE 1: 100

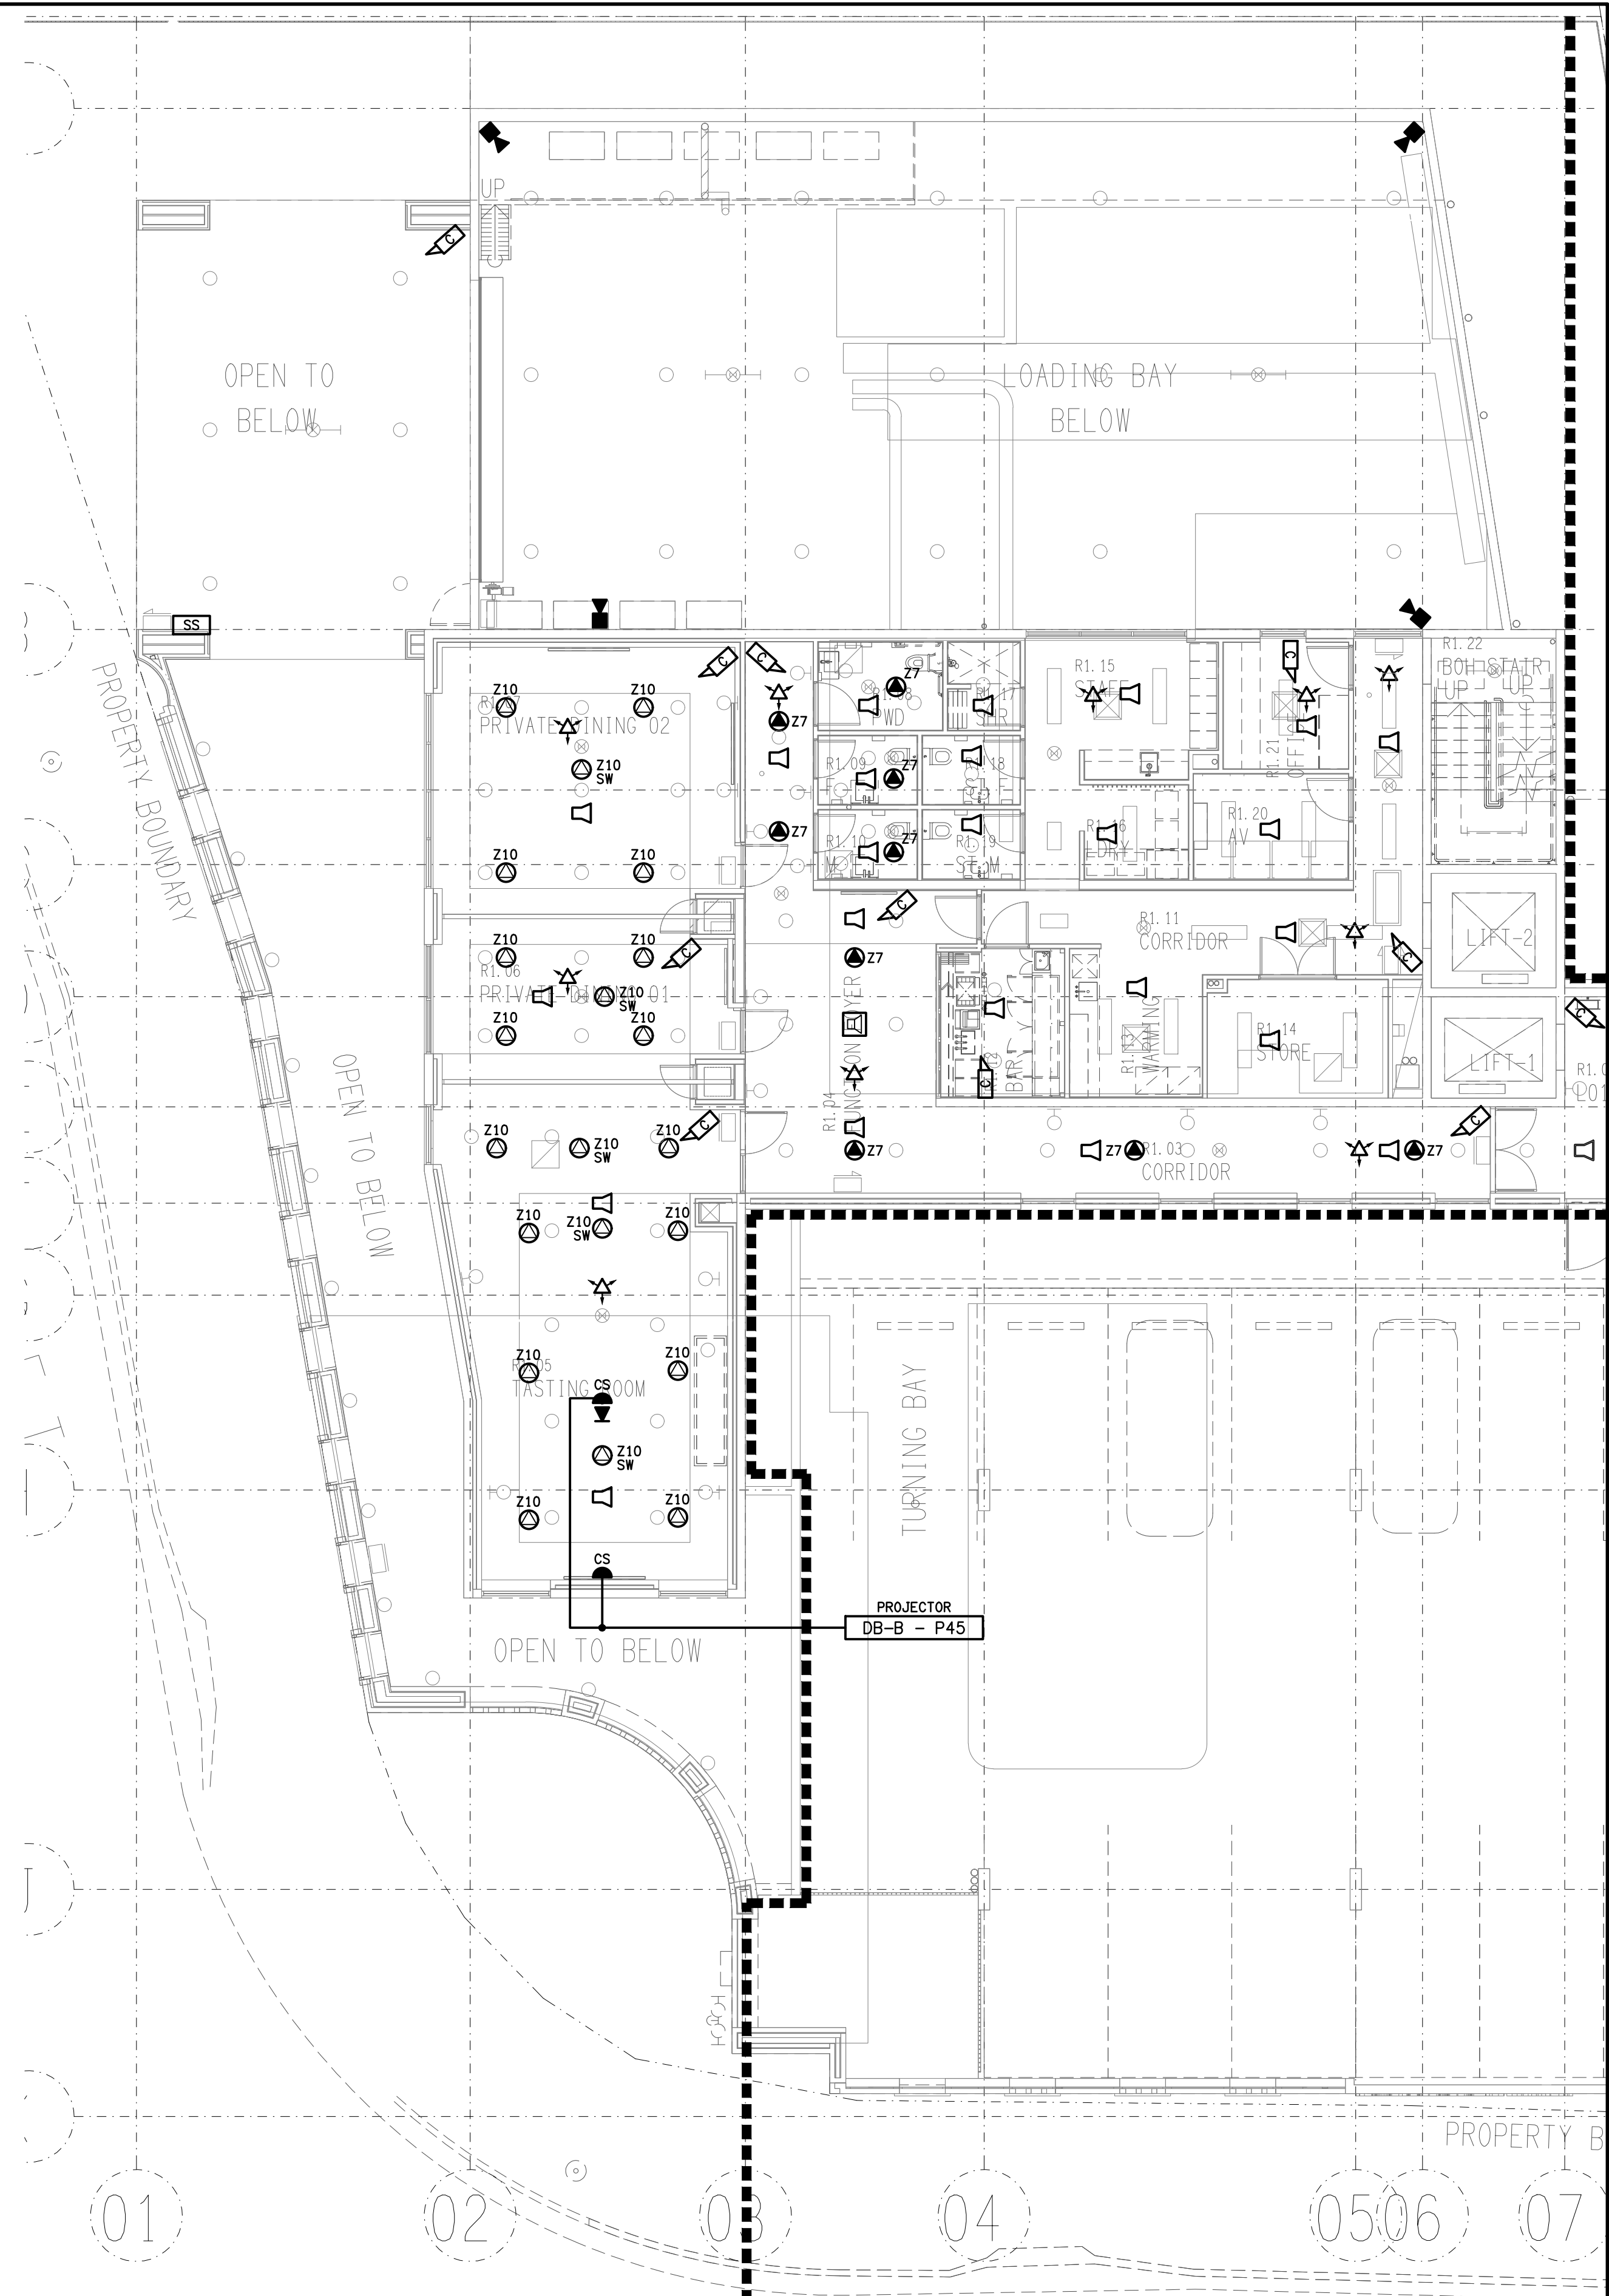

**NON LIGHTING PLAN**  
LEVEL 1 REFLECTED CEILING PLAN  
SCALE 1: 100