


NOTE:
THERE ARE NO HYDRANTS WITHIN 25m OF THE PADMOUNT SUBSTATION TRANSFORMER.


PROPOSED 4800 x 5000 PADMOUNT SUBSTATION TRANSFORMER LOCATION.

CLOSEST COMMUNICATIONS PIT (TELSTRA / NBN) 25m PLUS FROM PADMOUNT SUBSTATION TRANSFORMER.



1 x 100mm DIA WHITE AND 6 x 125mm DIA ORANGE CONDUITS WITHIN THE ENERGEX FOOTPATH ZONE.

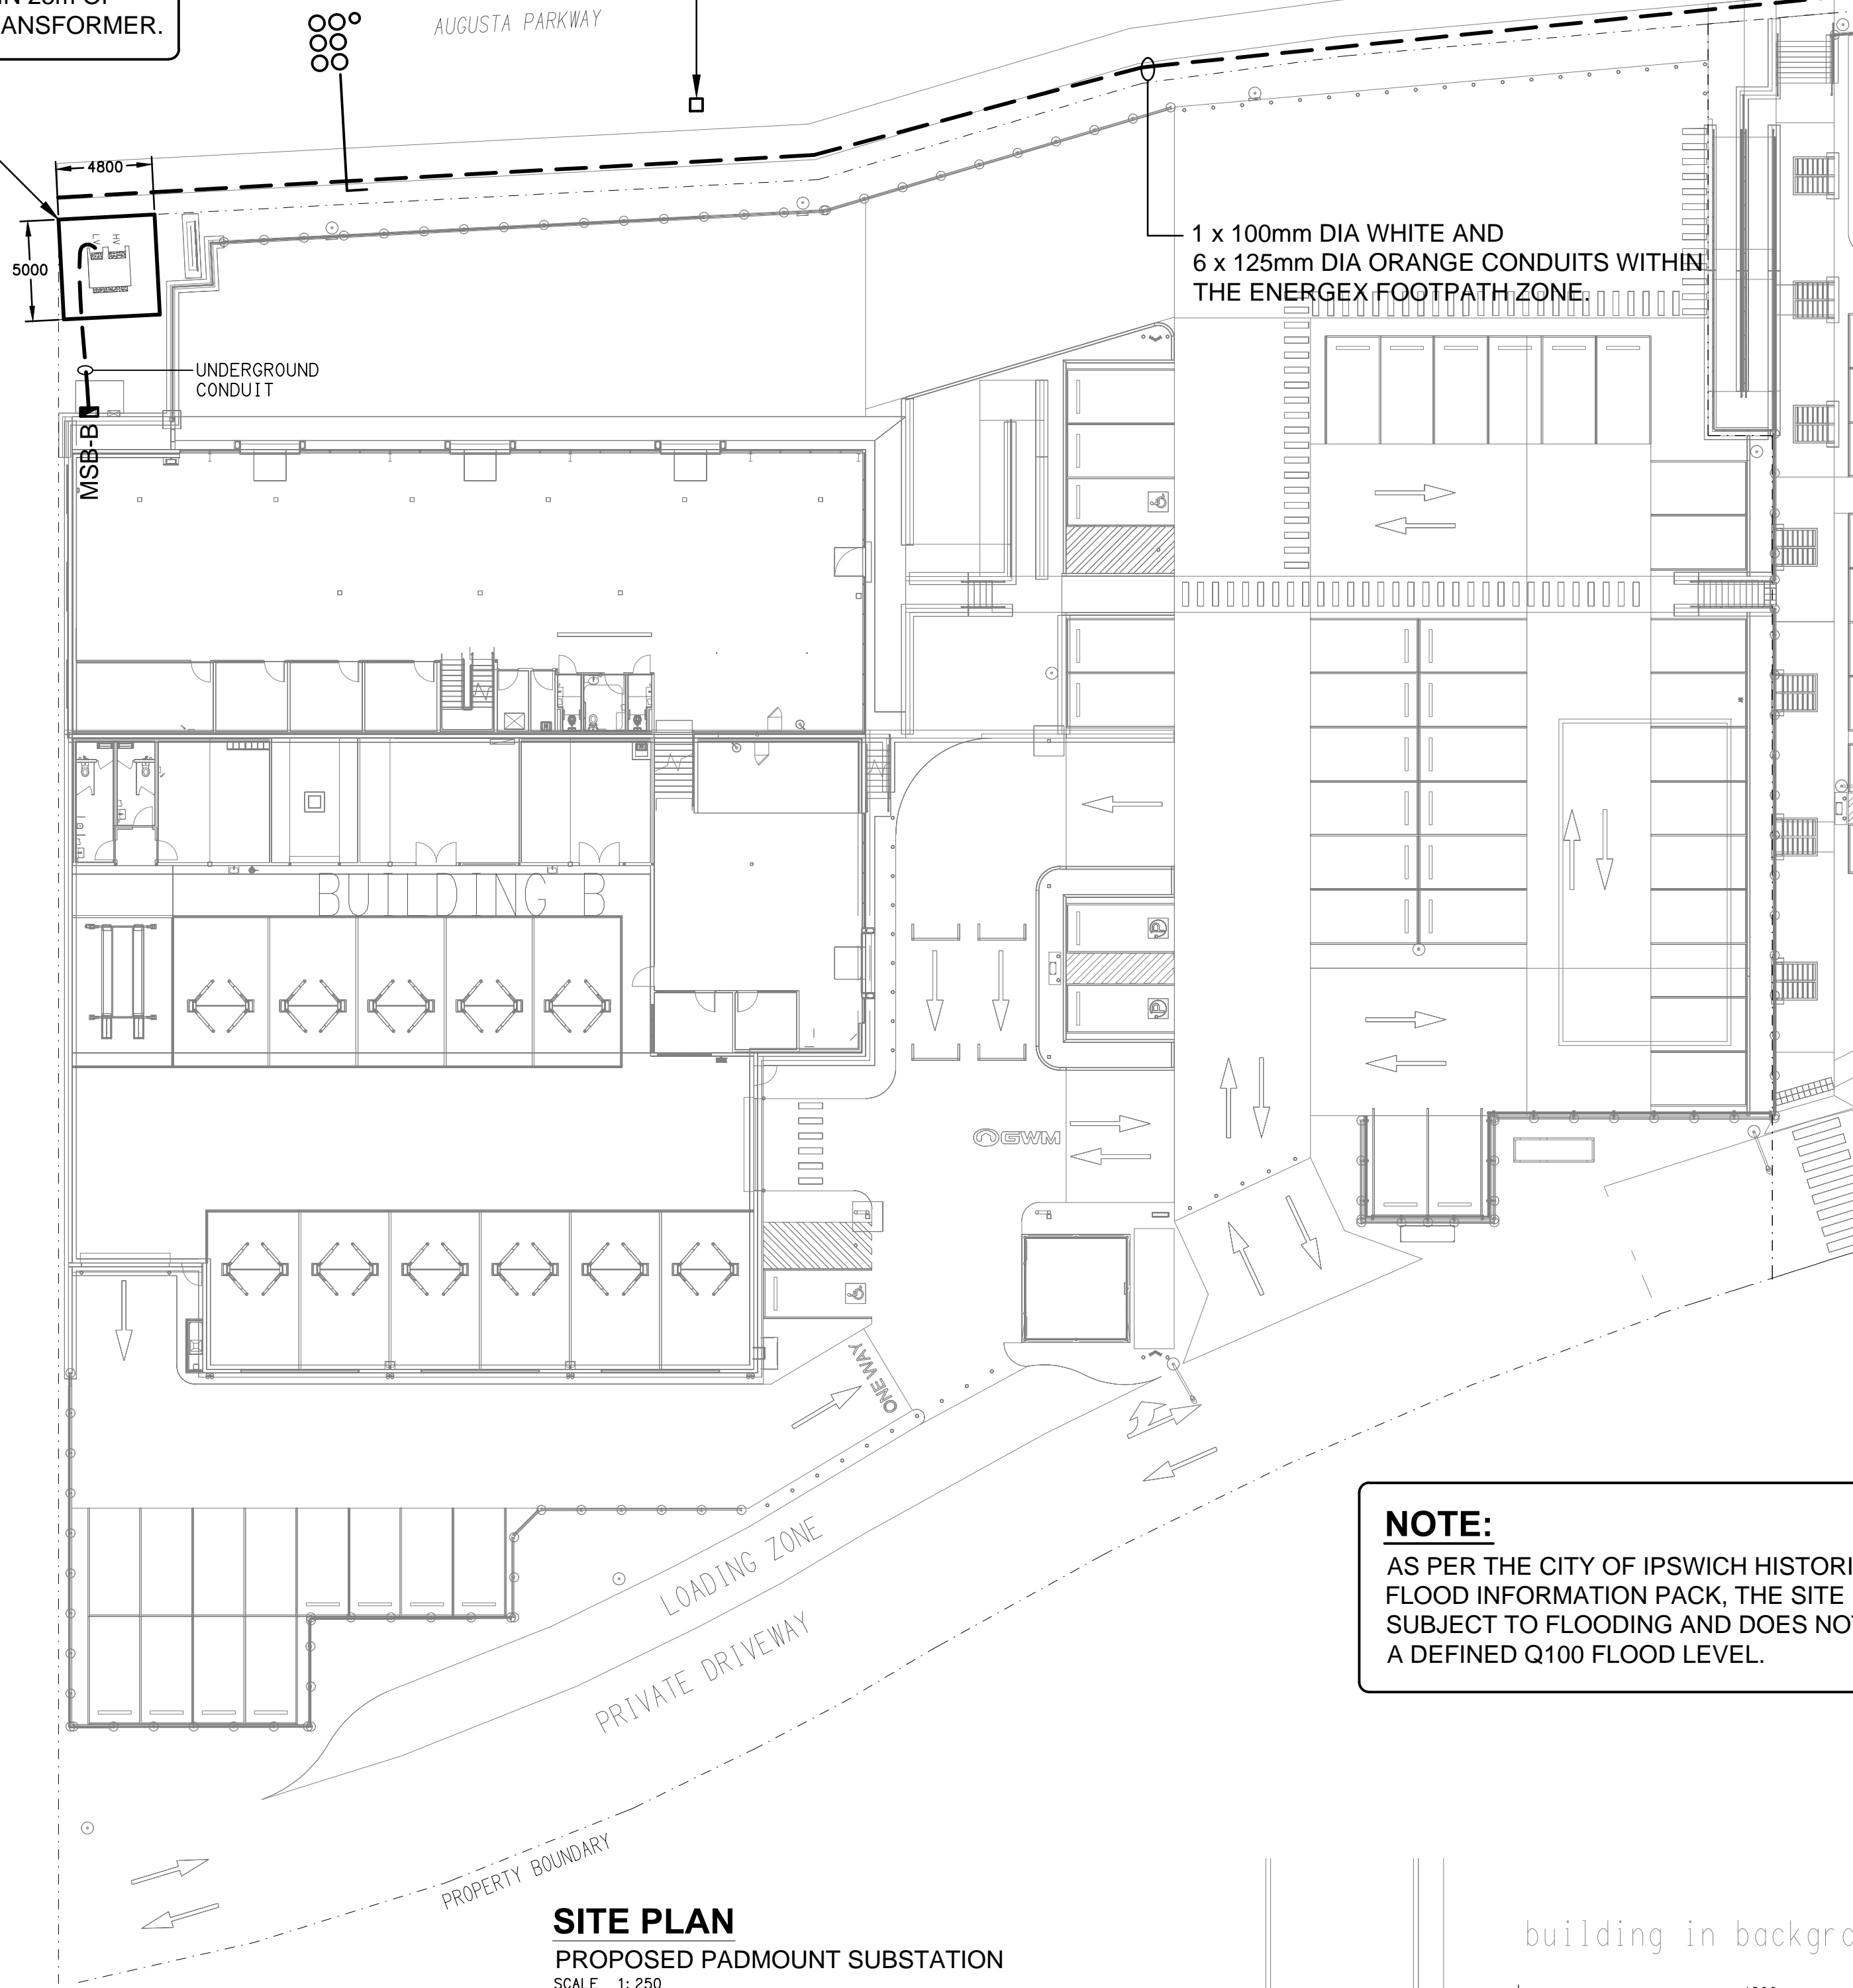

NOTE:
AS PER THE CITY OF IPSWICH HISTORICAL FLOOD INFORMATION PACK, THE SITE IS NOT SUBJECT TO FLOODING AND DOES NOT HAVE A DEFINED Q100 FLOOD LEVEL.

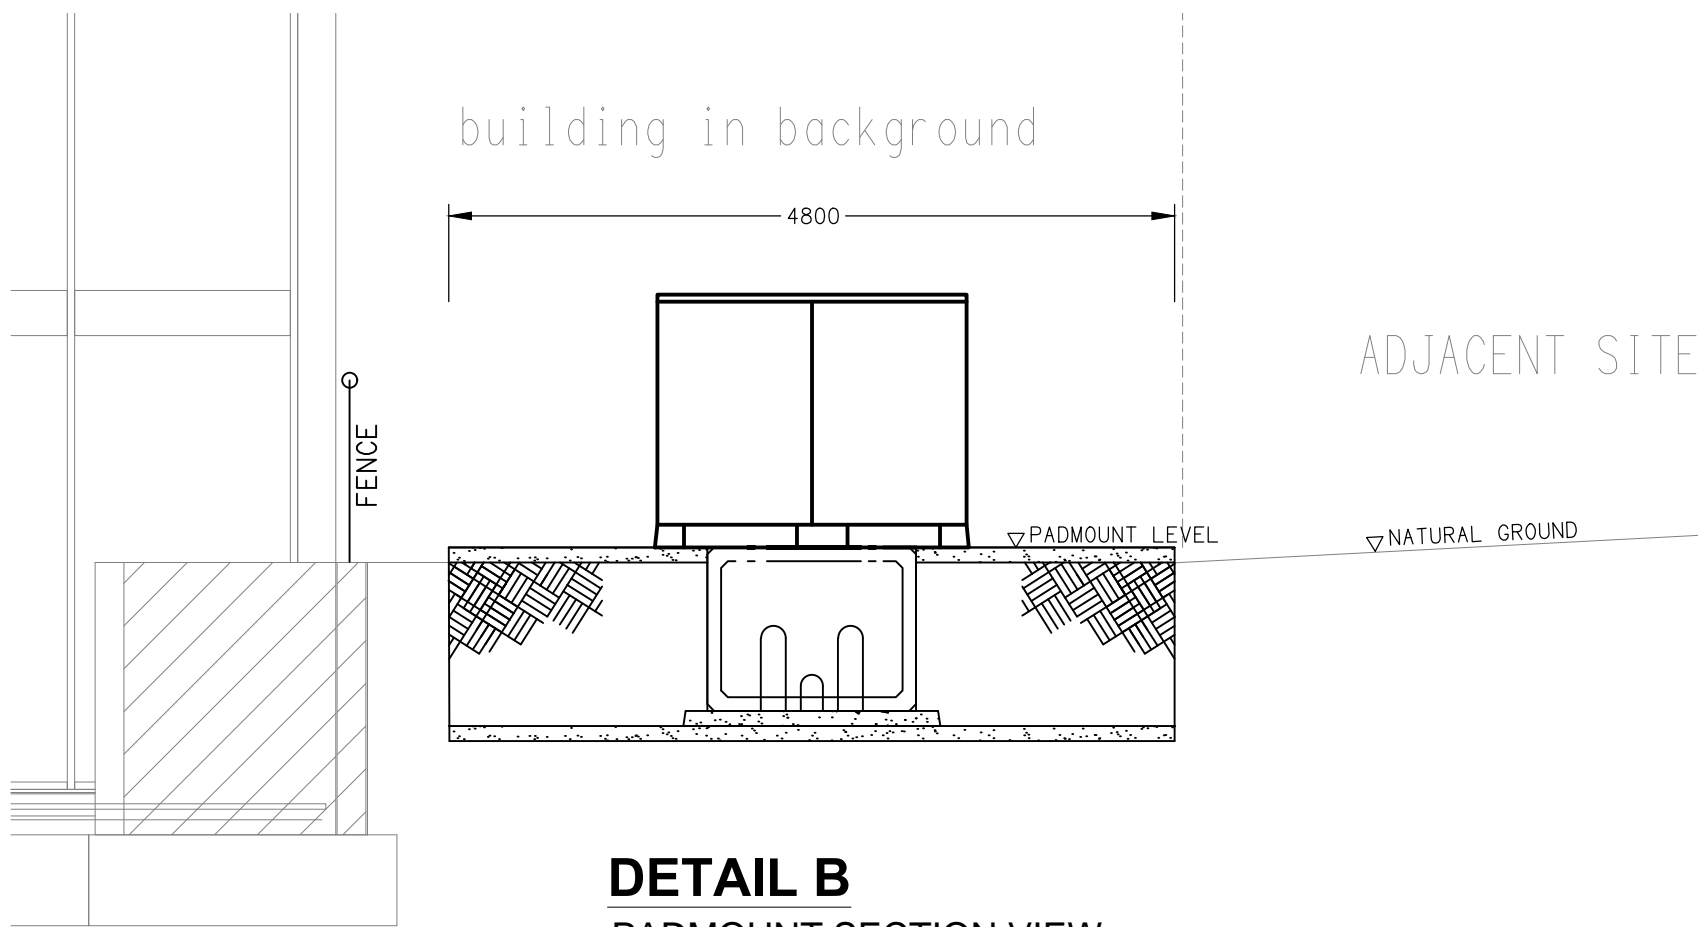

NOTE:
DO NOT RUN PRIVATE SERVICE CABLE THROUGH CULVERT

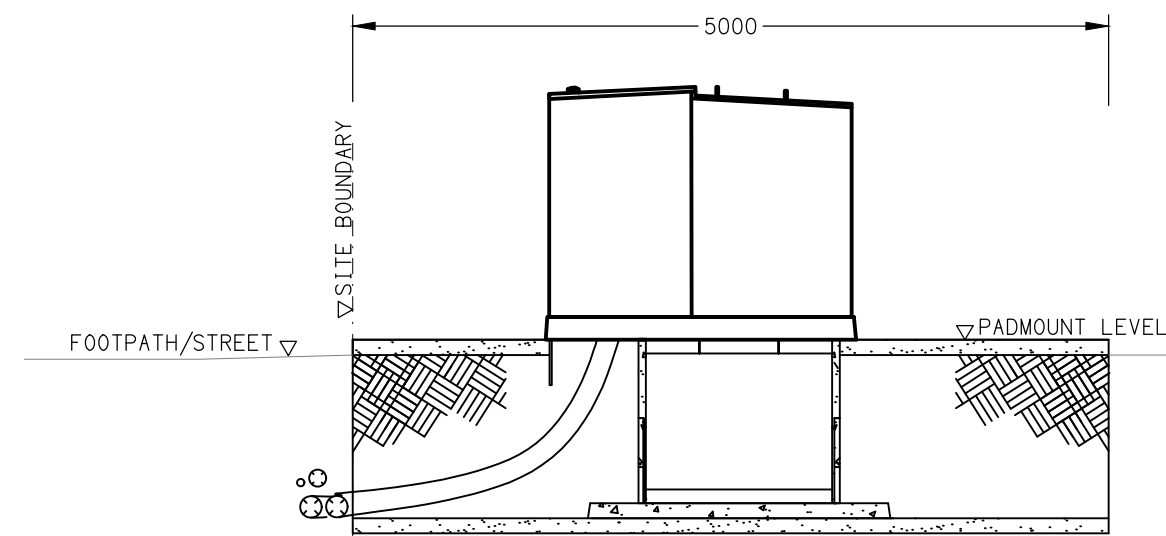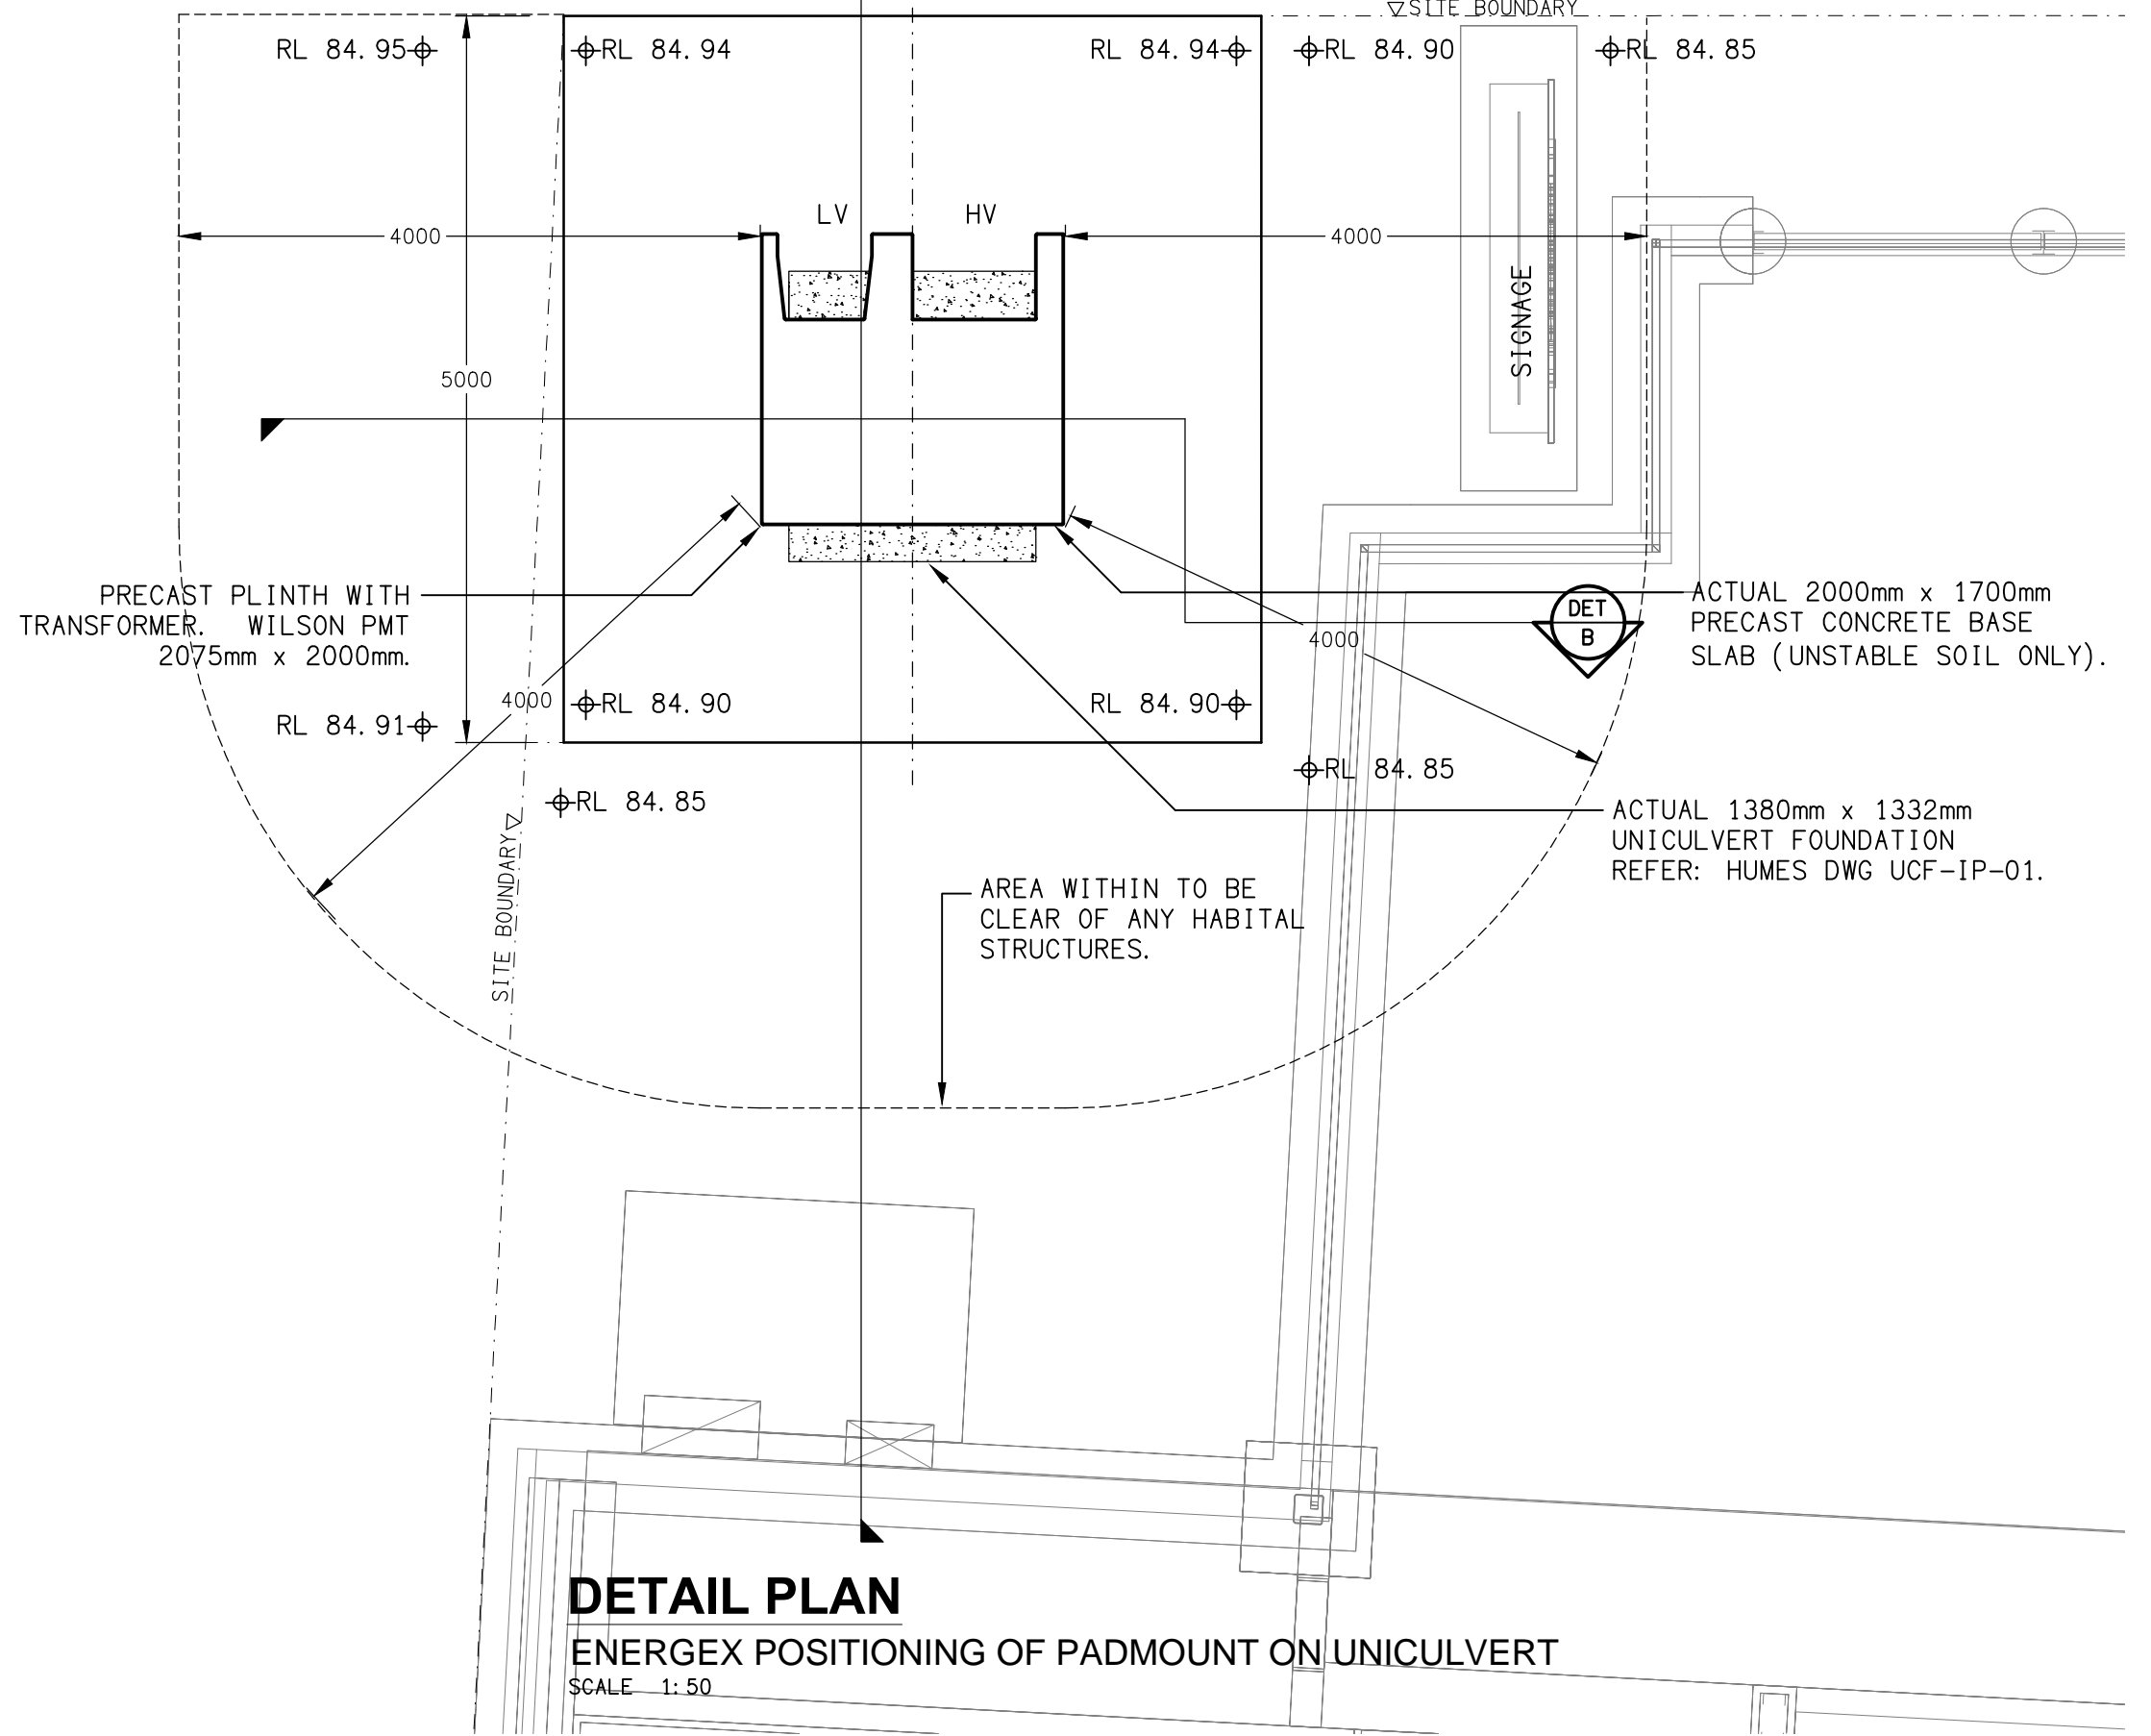

CULVERT INSPECTION REQUIRED BEFORE TRANSFORMER IS DELIVERED
- 5 BUSINESS DAYS PRIOR NOTICE NEEDED.
CONTACT: PAUL HAWKINS PH: 0419 756 501 EMAIL: ProjectCoordinationsesth@energex.com.au

TRANSFORMER WILL NOT BE ENERGISED UNTIL ALL REQUIREMENTS ARE MET.

ELECTRICAL DESIGN GROUP BRISBANE PTY LTD
ACN 092 710 793
TRADING AS:
ELECTRICAL DESIGN GROUP

THE COPYRIGHT OF THIS DRAWING REMAINS THE PROPERTY OF THE ELECTRICAL DESIGN GROUP.
USE FIGURED DIMENSIONS IN PREFERENCE TO SCALE.
ALL DIMENSIONS TO BE VERIFIED ONSITE.



Rohrig (Qld) Pty Ltd
ABN 67 093 753 970
QBSA LIC NO 740842
250 Abbotsford Road, Bowen Hills Qld 4006
PO Box 86 Albion DC Qld 4010
T+61 (7) 3257 4411 F+61 (7) 3257 2211
www.rohrig.com.au

FOR ALL ENERGEX RELATED CONSTRUCTION QUERIES THE ELECTRICAL DESIGN GROUP ON (07) 3278 4375 IS THE FIRST POINT OF CALL.



ELECTRICAL DESIGN GROUP
ELECTRICAL BUILDING SERVICES CONSULTANTS
BRISBANE GOLD COAST

P.O.Box 15, Sherwood Q.4075
Phone: (07) 3278 4375
Email: brisbane@edg.net.au
Web: www.edg.net.au

PROJECT:
LLEWELLYN MOTORS SPRINGFIELD - LOT 32

LOT 32 AUGUSTA PARKWAY, AUGUSTINE HEIGHTS

1	CONSTRUCTION	30/05/2025
REV:	DESCRIPTION:	DATE:

DRAWING: ELECTRICAL SERVICES ENERGEX PADMOUNT SUBSTATION SITE PLAN & DETAILS	PROJECT NO: C3294a	DRAWING NO: EN01	REVISION: 1
SCALE: 1:250 & 1:50	AT A1		