


NOTE:

REFER TO DRAWING C3354a-E05.dwg FOR
ADDITIONAL JOINERY & WALL LIGHTING PLANS

REFER TO DRAWING C3354a-E06.dwg FOR
ADDITIONAL CEILING LED STRIP LIGHTING PLANS

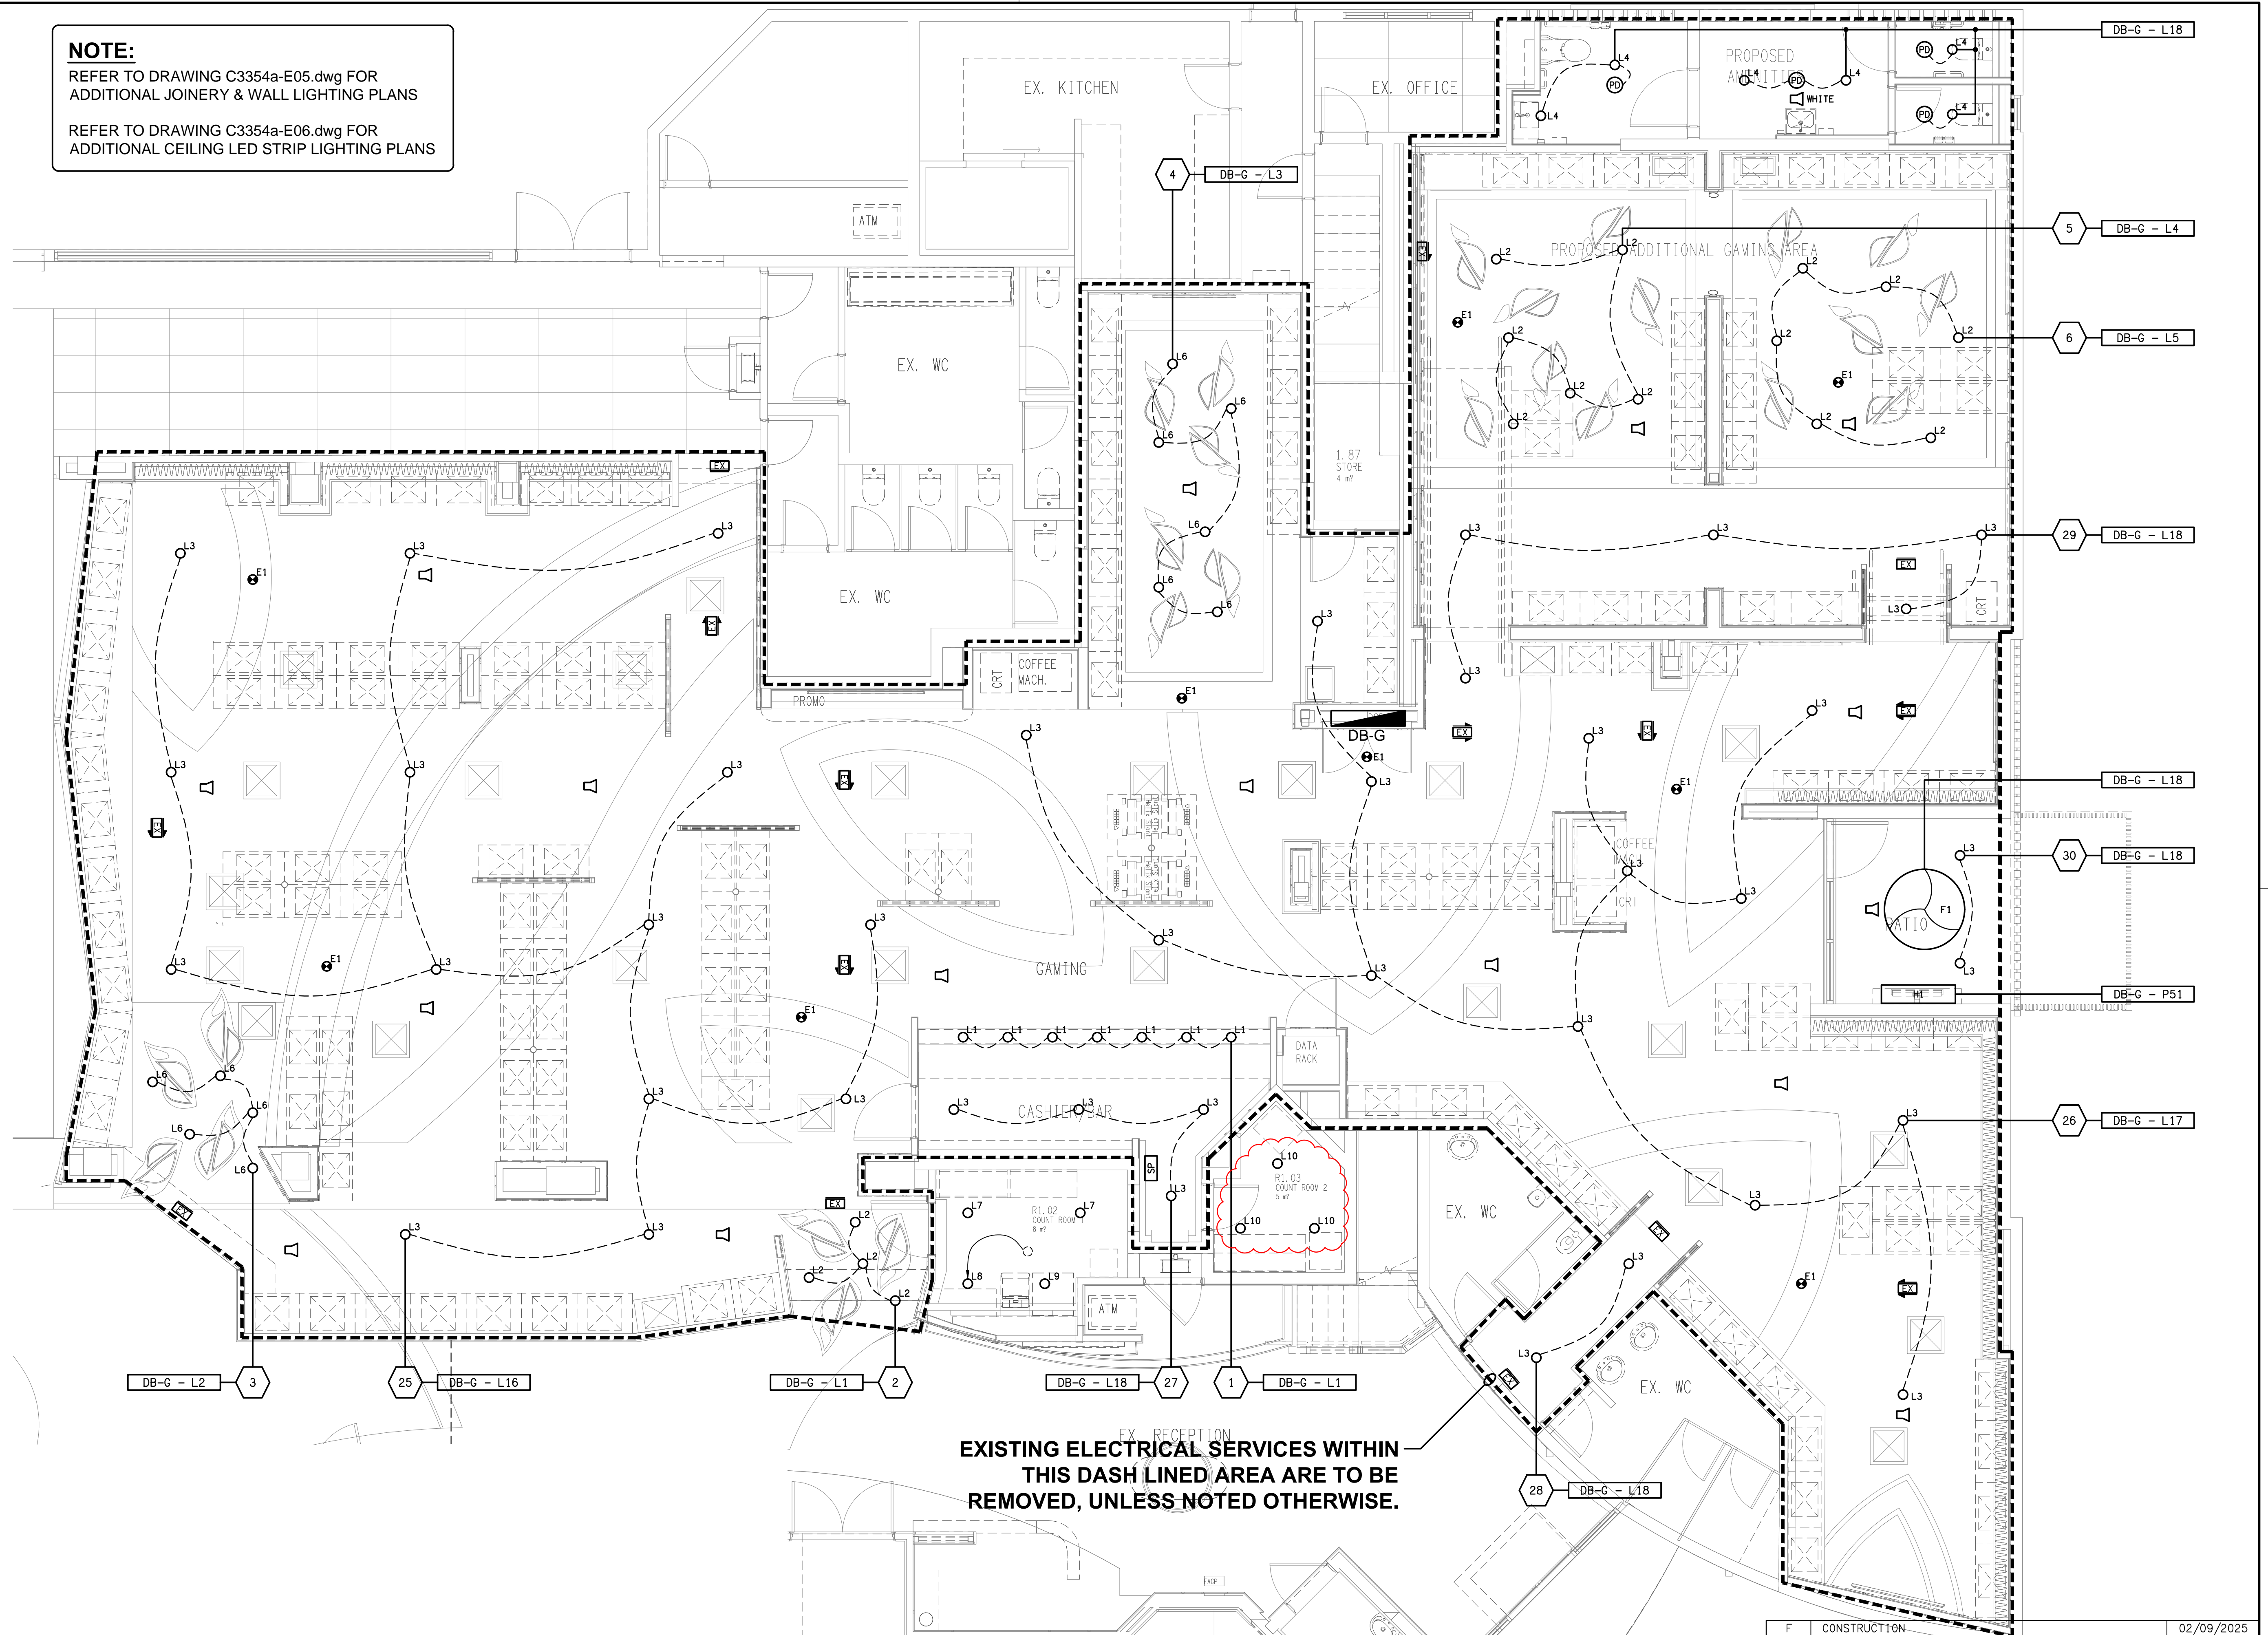

EXISTING ELECTRICAL SERVICES WITHIN
THIS DASH LINED AREA ARE TO BE
REMOVED, UNLESS NOTED OTHERWISE.

ELECTRICAL DESIGN GROUP BRISBANE
PTY LTD
ACN 092 710 793
TRADING AS:
ELECTRICAL DESIGN GROUP

THE COPYRIGHT OF THIS DRAWING
REMAINS THE PROPERTY OF THE
ELECTRICAL DESIGN GROUP.
USE FIGURED DIMENSIONS
IN PREFERENCE TO SCALE.
ALL DIMENSIONS TO BE
VERIFIED ONSITE.

ELECTRICAL DESIGN GROUP
ELECTRICAL BUILDING SERVICES CONSULTANTS
BRISBANE GOLD COAST

P.O. Box 15, Sherwood Q. 4075
Phone: (07) 3278 4375
Email: brisbane@edg.net.au
Web: www.edg.net.au

PROJECT:
**ASPLEY LEAGUES CLUB
GAMING REFURBISHMENT**

29 KIRBY ROAD, ASPLEY

| | | |
|------|--------------|------------|
| F | CONSTRUCTION | 02/09/2025 |
| REV: | DESCRIPTION: | DATE: |

DRAWING:
**ELECTRICAL SERVICES
REFLECTED CEILING PLAN**

SCALE:
1:50 UNO

AT A1

PROJECT NO:
C3354a

DRAWING NO:
E04

REVISION:
F