




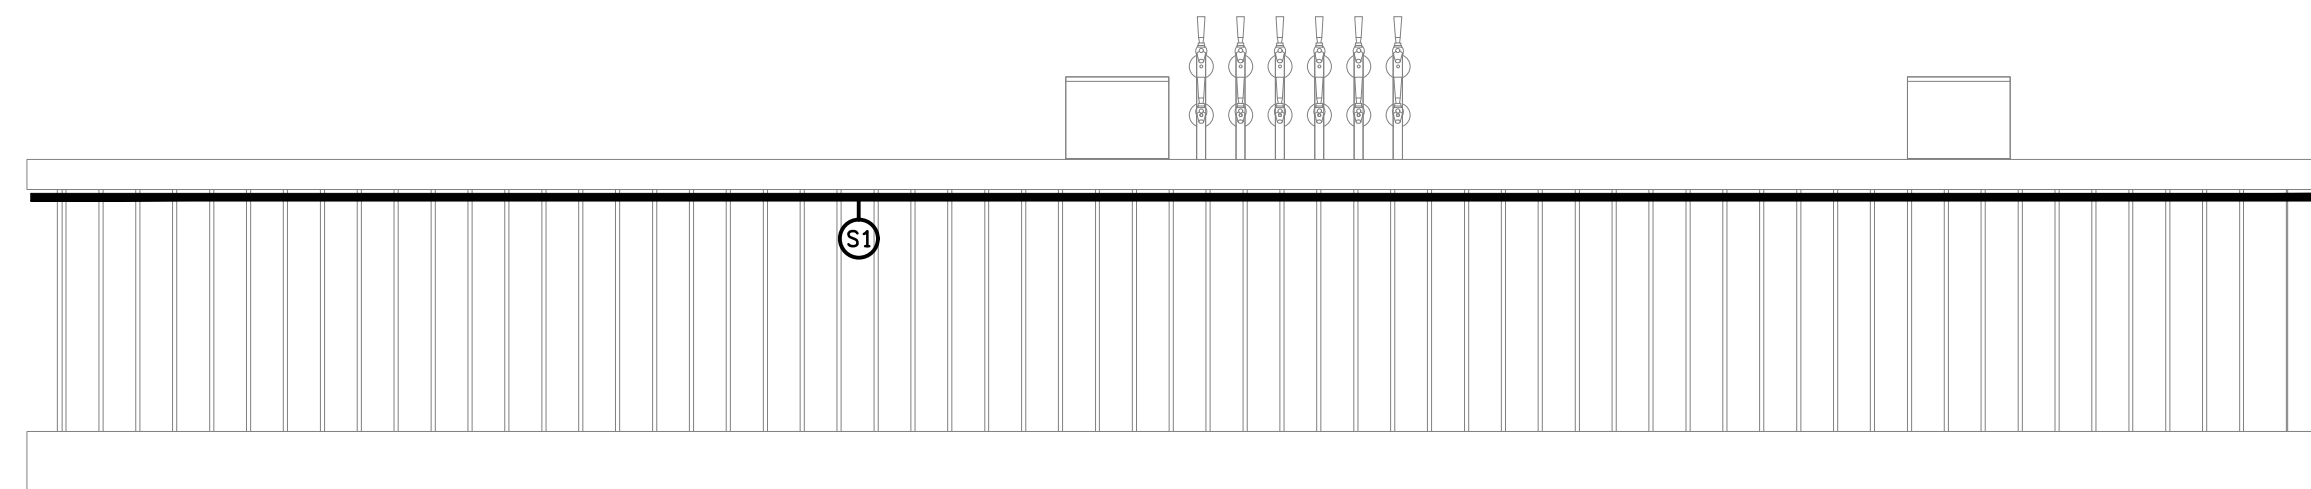


DETAIL B
SPORTS BAR FRONT COUNTER ELEVATION
SCALE 1: 25

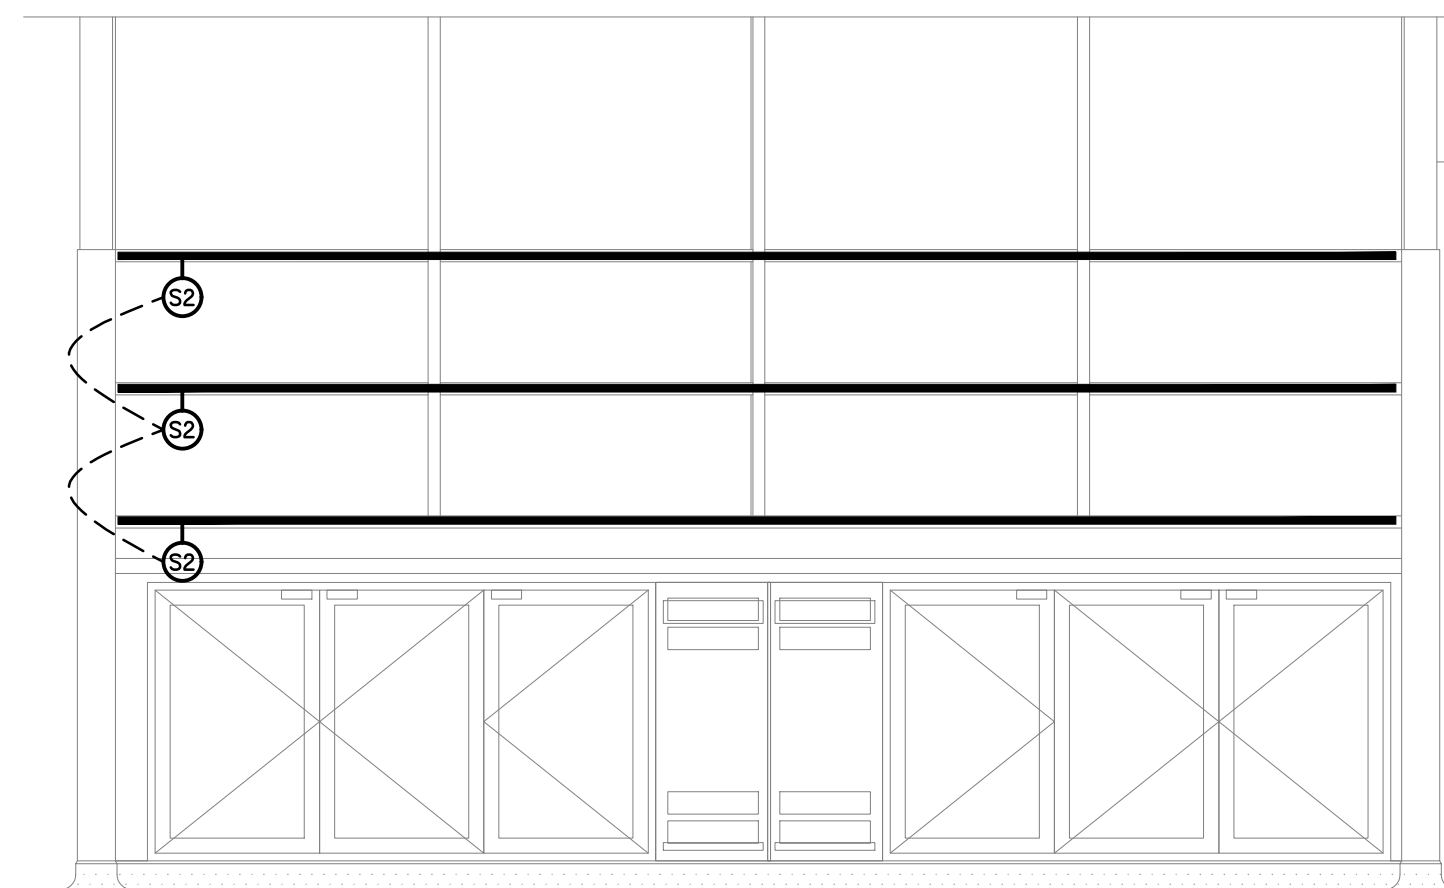

DETAIL C
SPORTS BAR REAR WALL ELEVATION
SCALE 1: 25

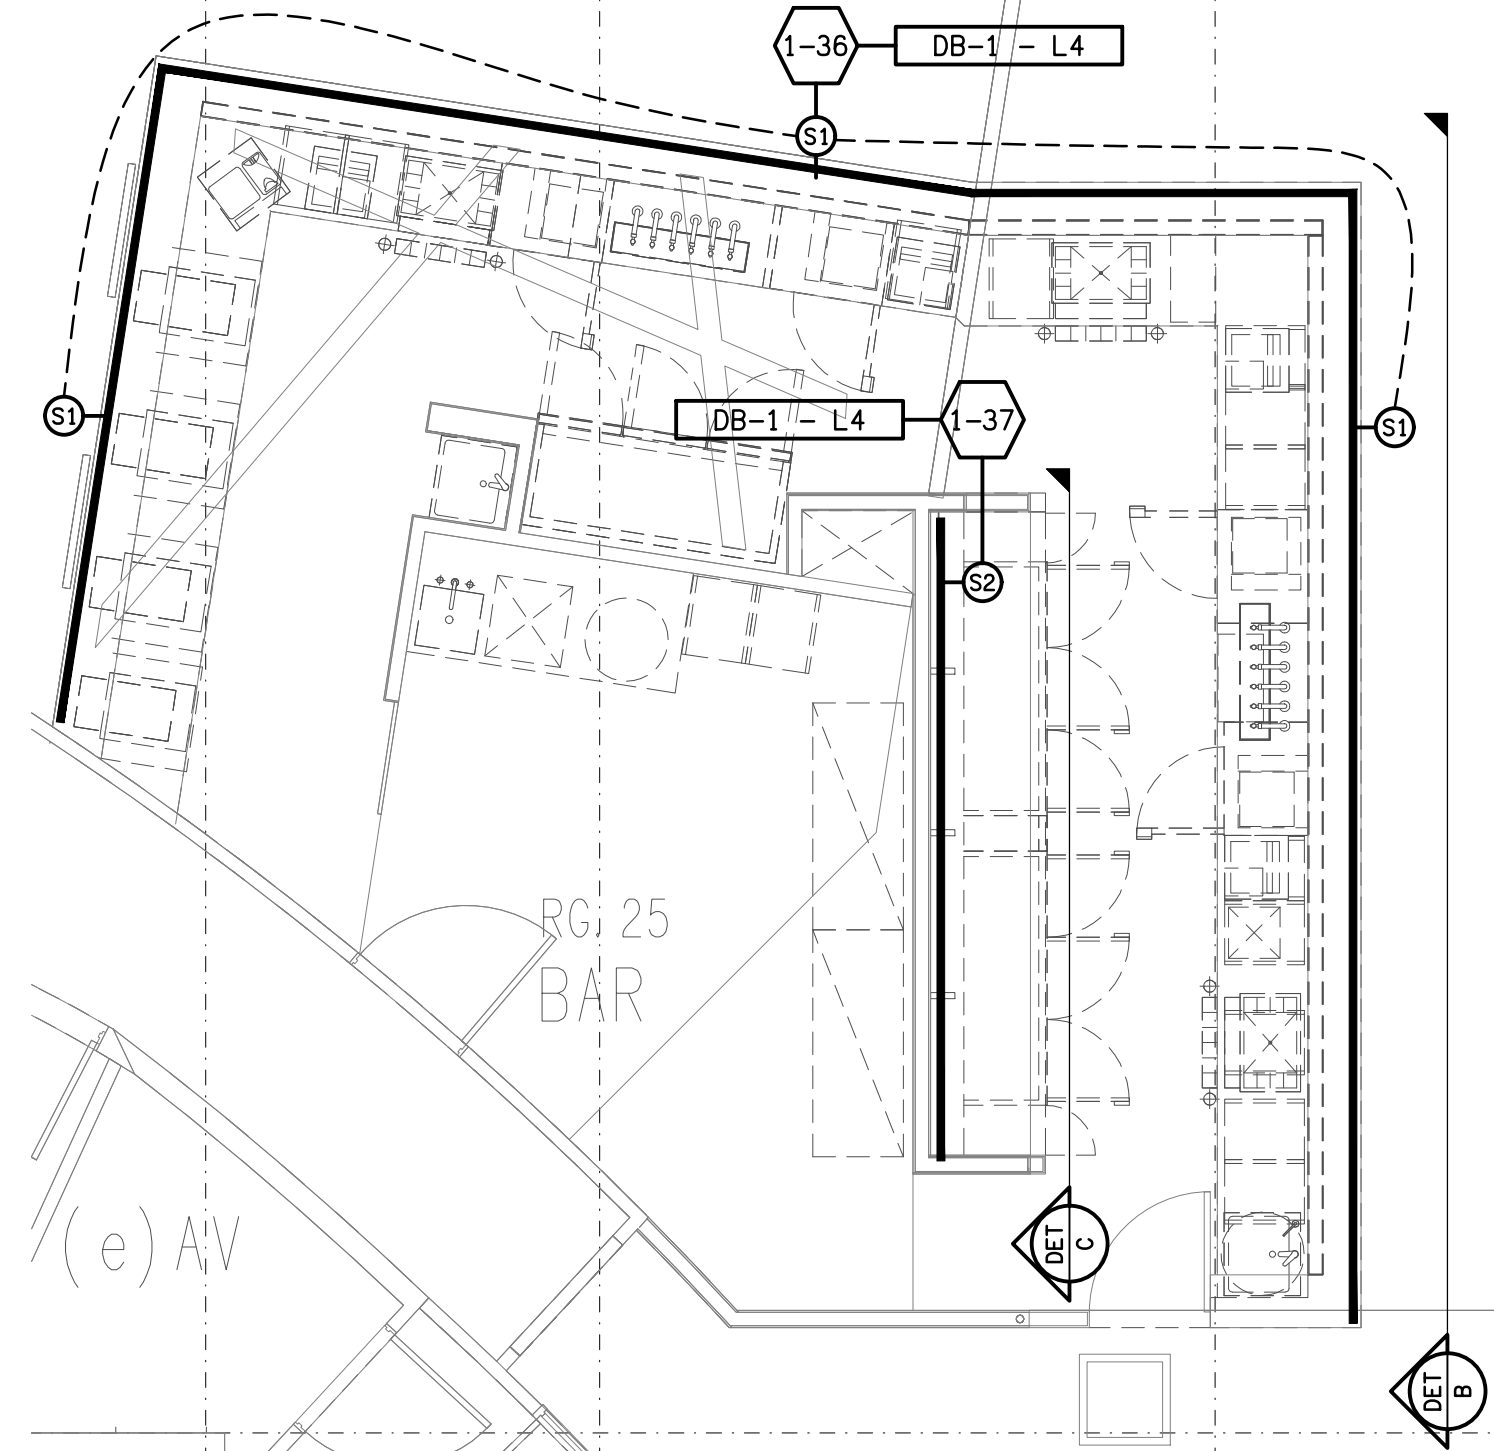

DETAIL A
SPORTS BAR LIGHTING PLAN
SCALE 1: 50

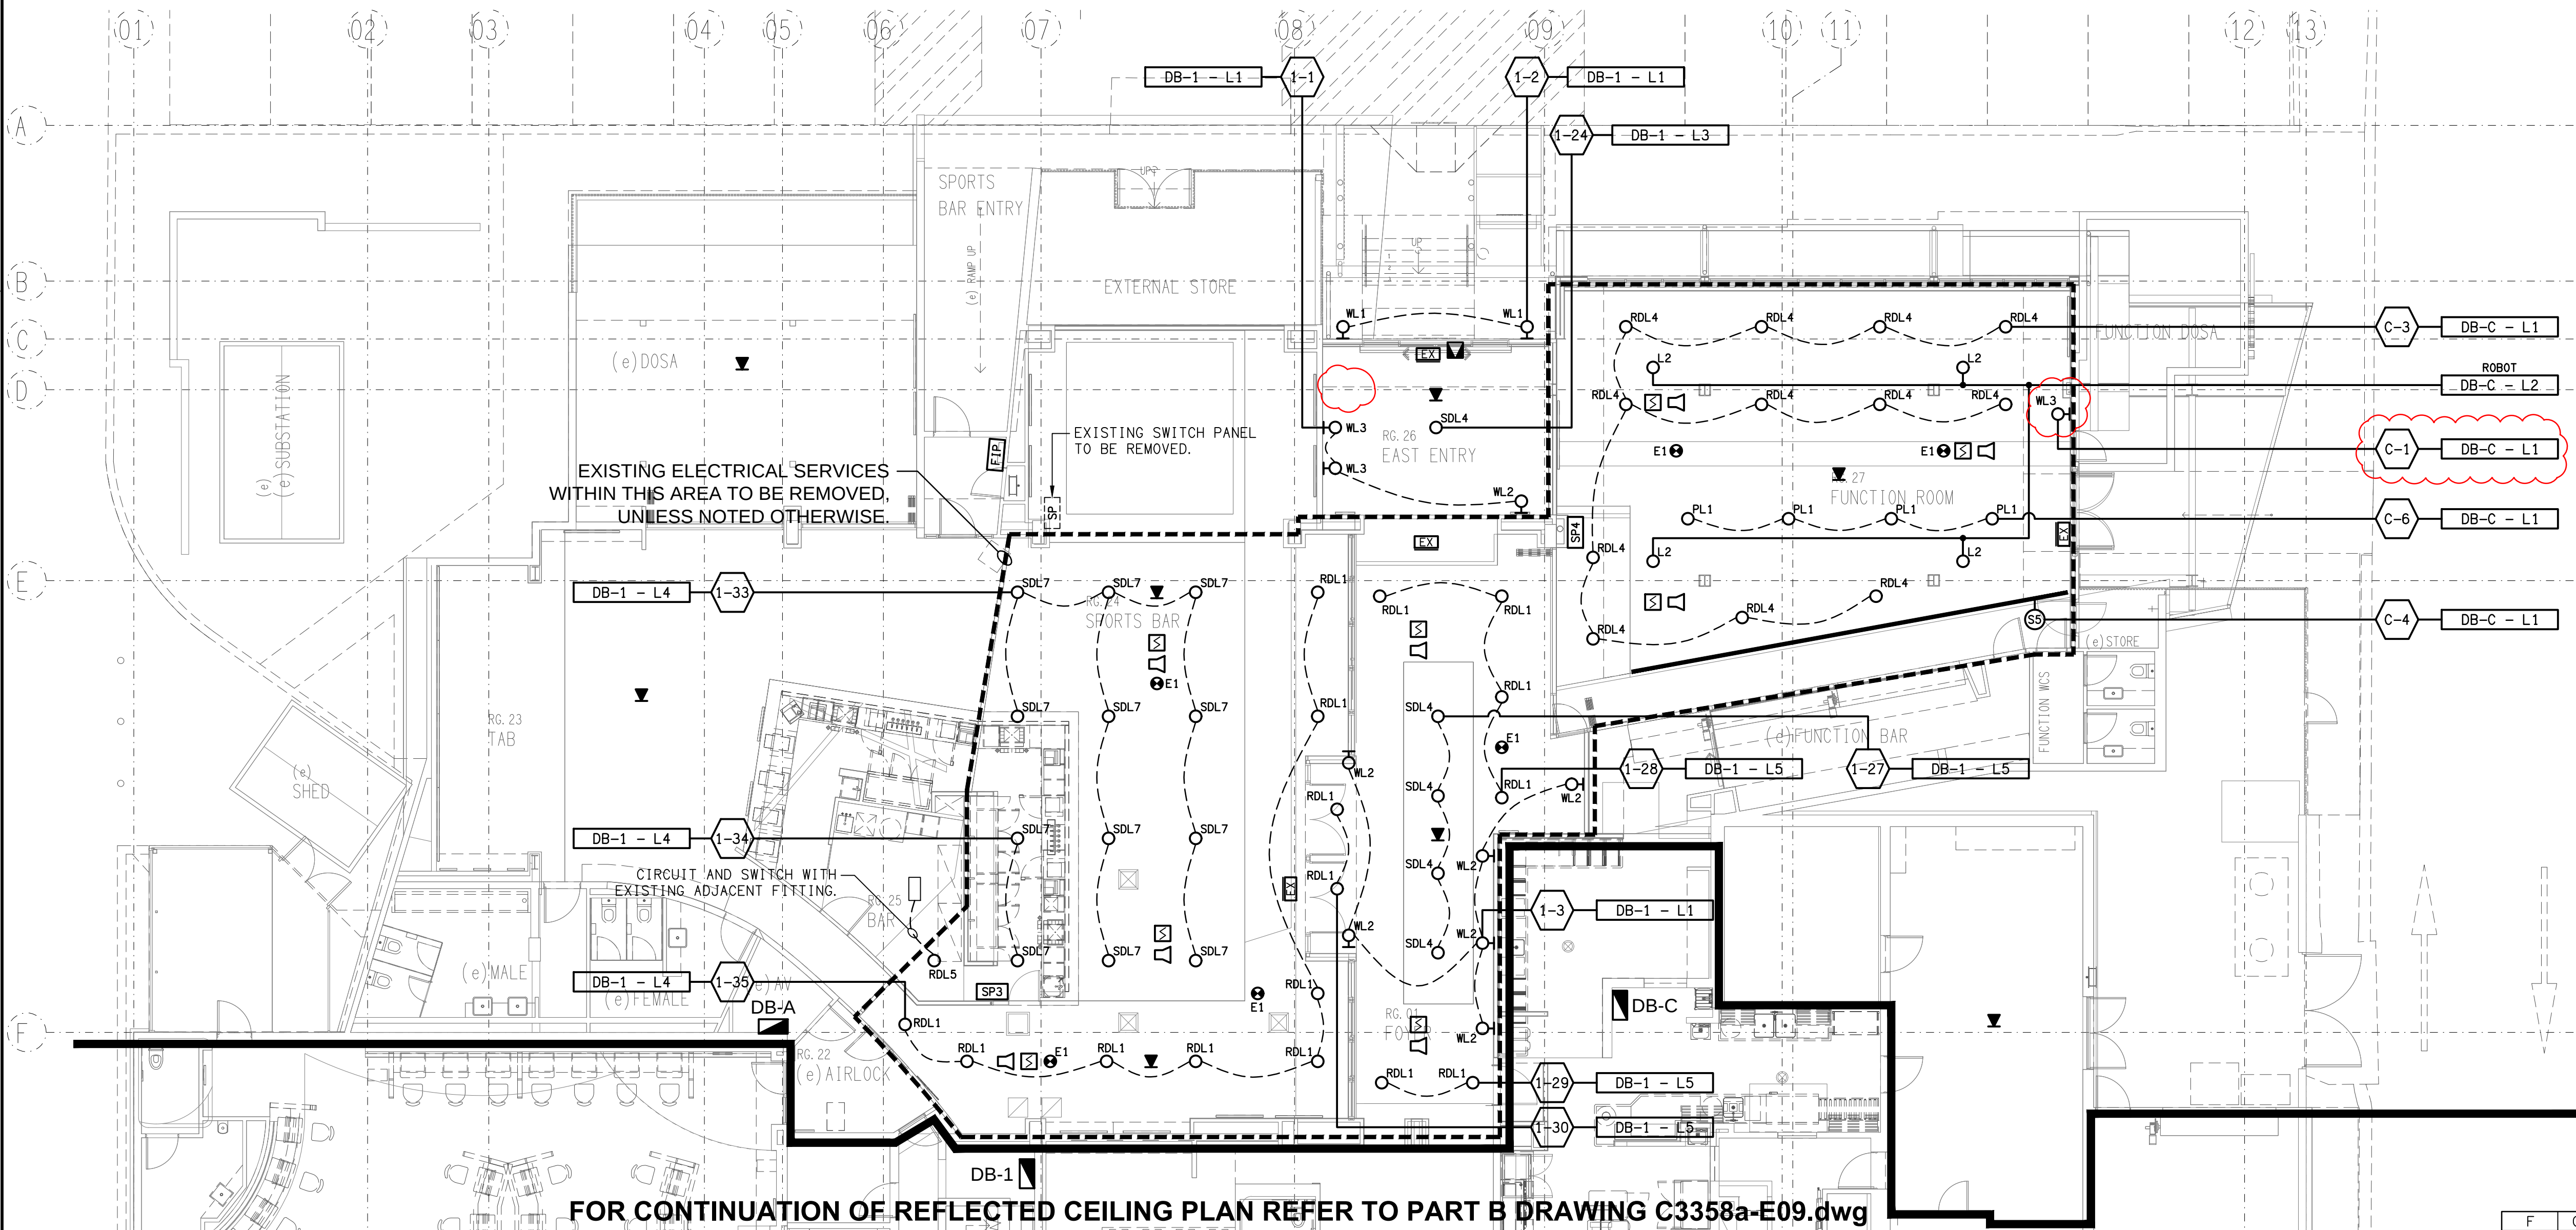

FOR CONTINUATION OF REFLECTED CEILING PLAN REFER TO PART B DRAWING C3358a-E09.dwg