



**DETAIL B**  
SPORTS BAR FRONT COUNTER ELEVATION  
SCALE 1:25

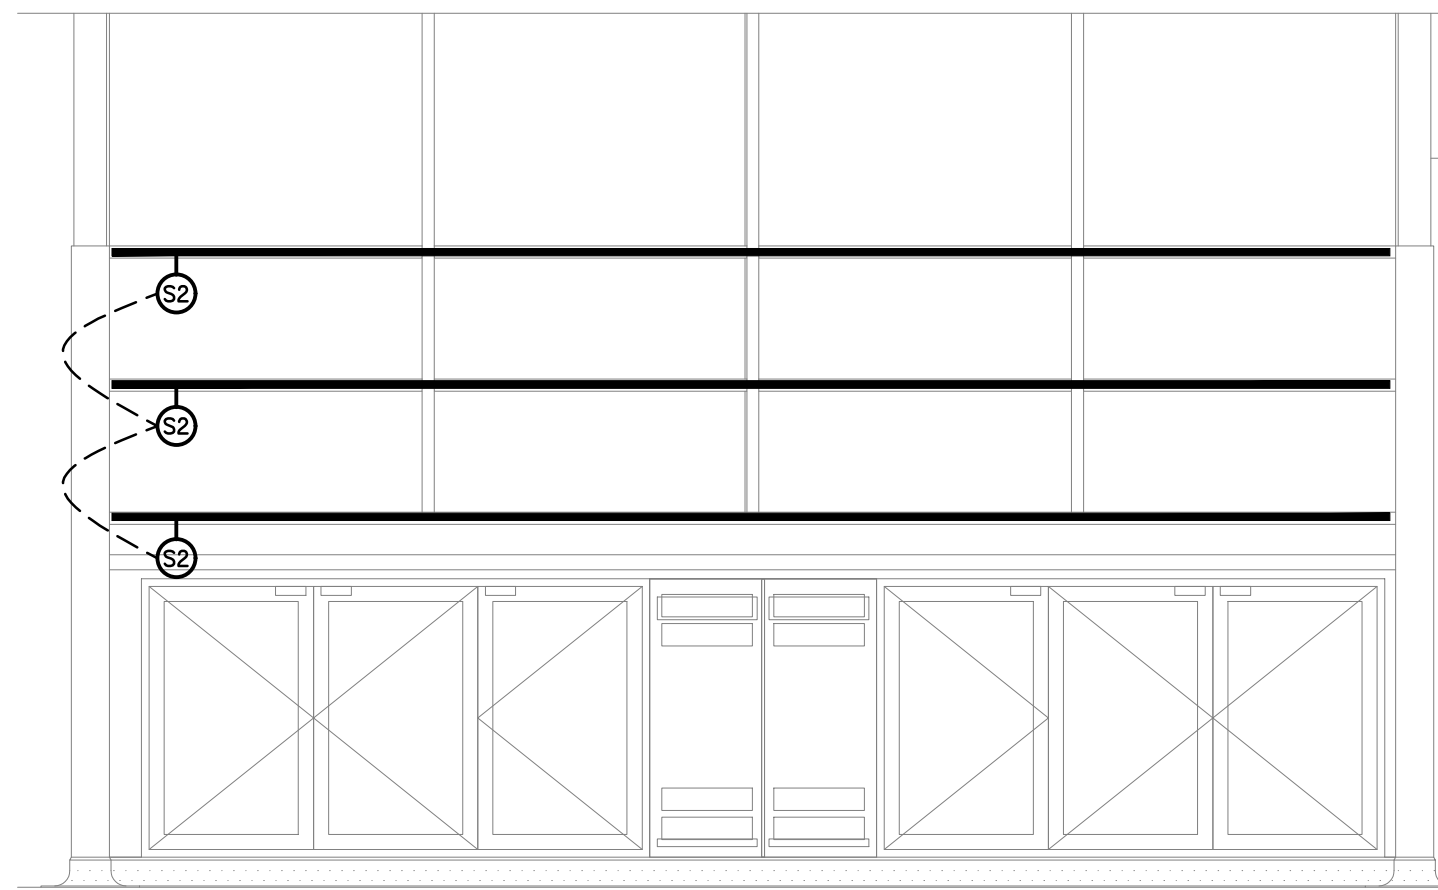

**DETAIL C**  
SPORTS BAR REAR WALL ELEVATION  
SCALE 1:25

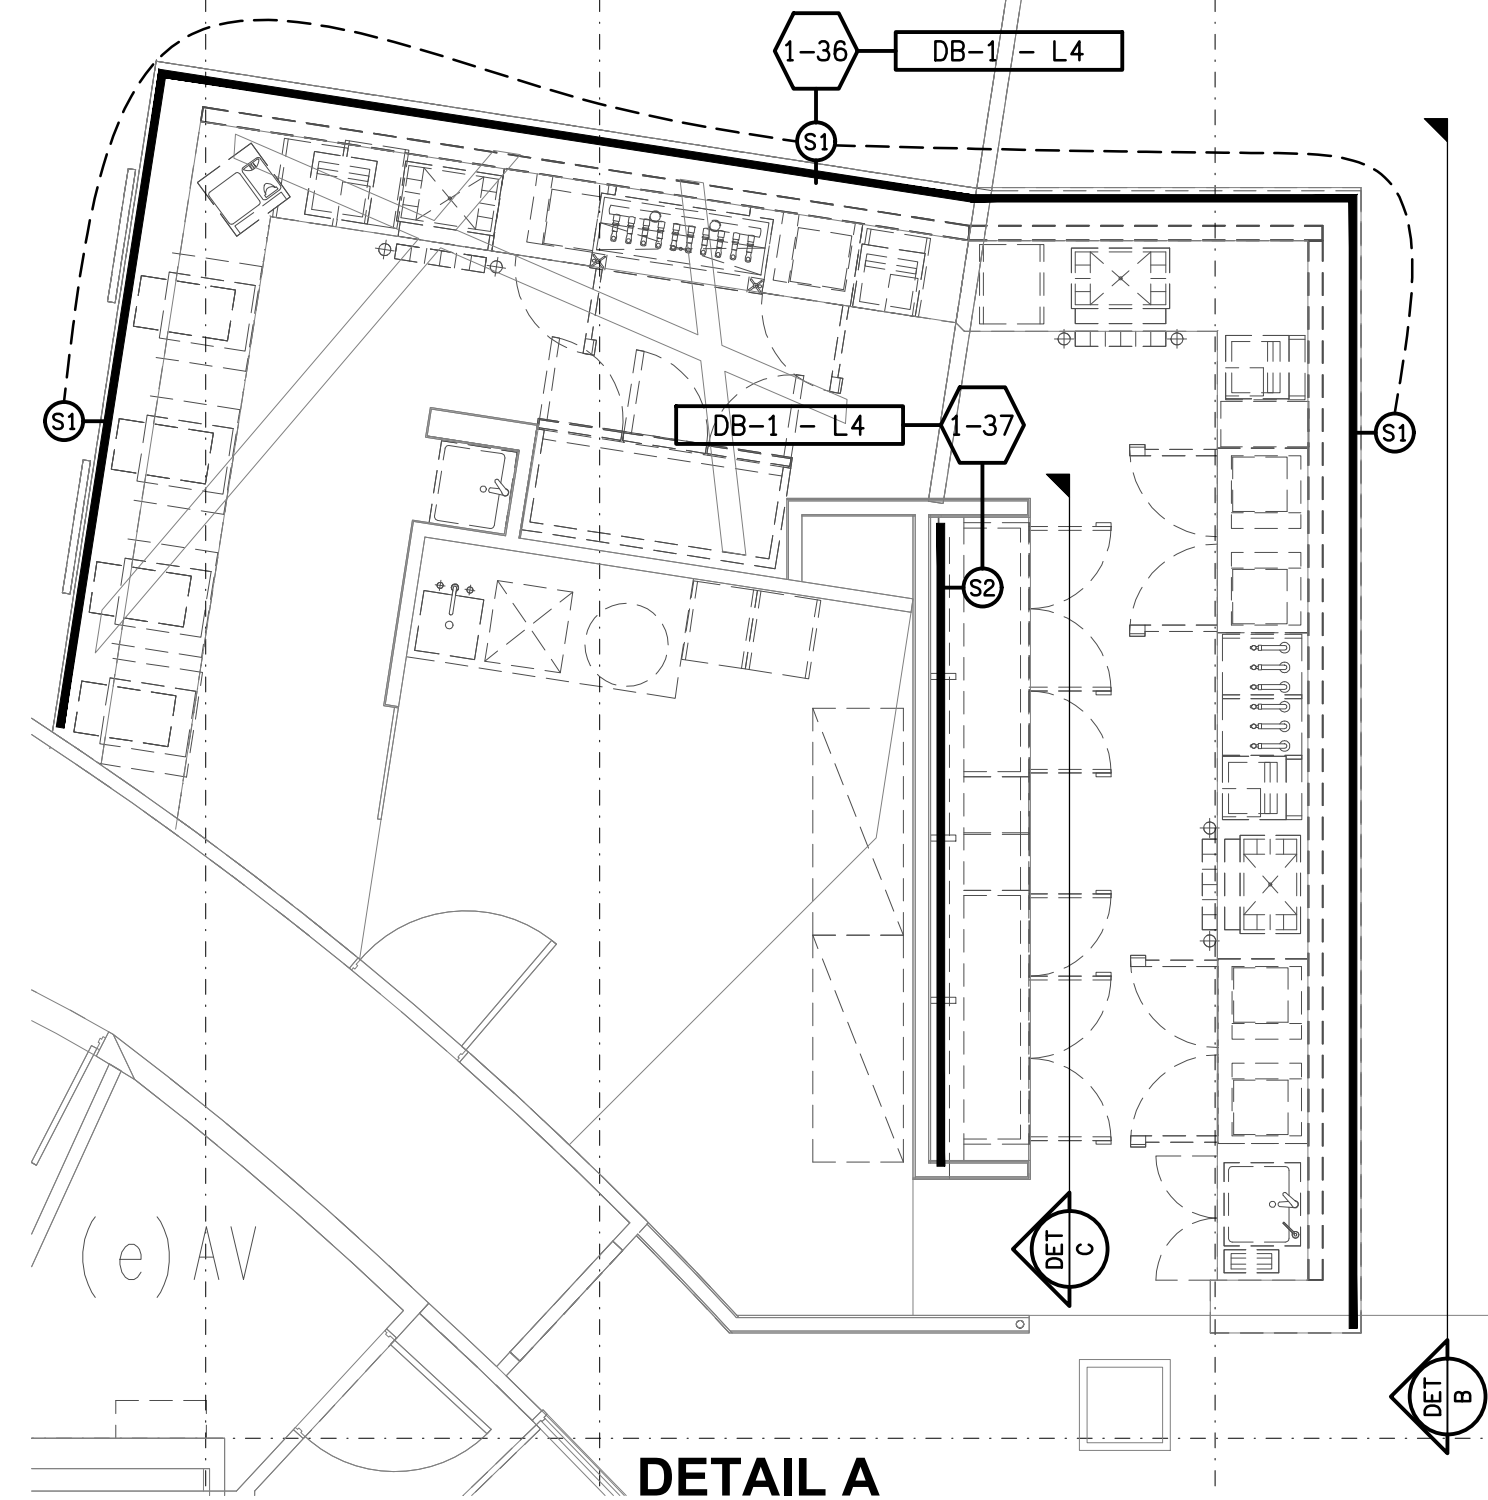

**DETAIL A**  
SPORTS BAR LIGHTING PLAN  
SCALE 1:50

