




CASHIER ROOM
STRIP LIGHTING PLAN
SCALE 1: 50

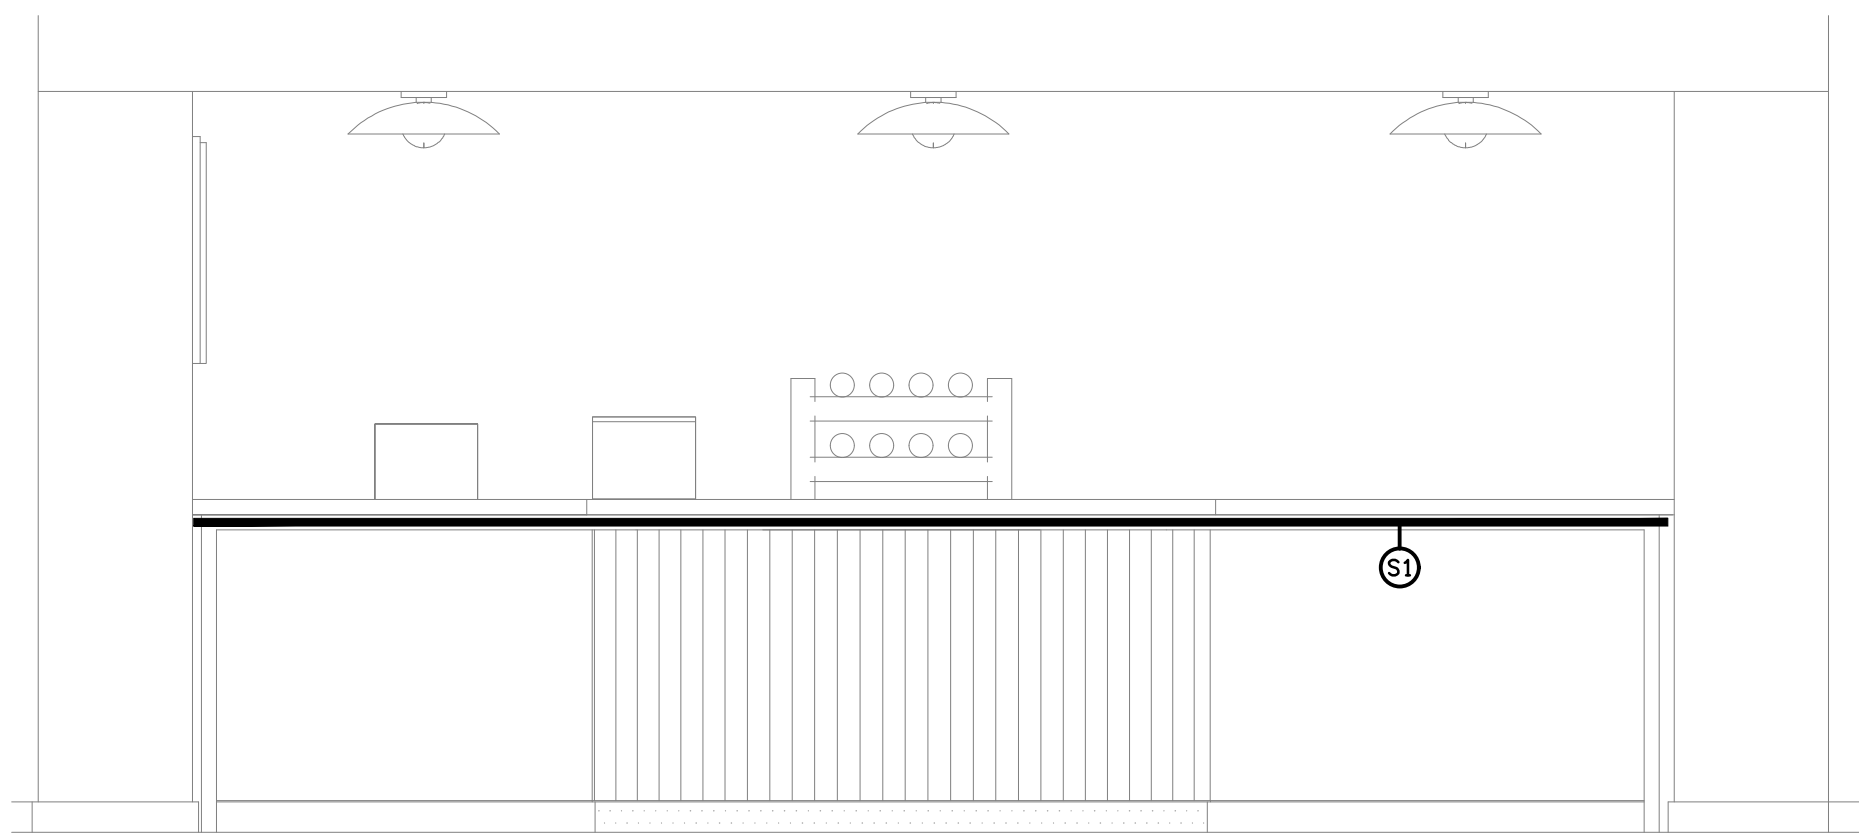


DETAIL A
CASHIER FRONT COUNTER ELEVATION
SCALE 1: 25

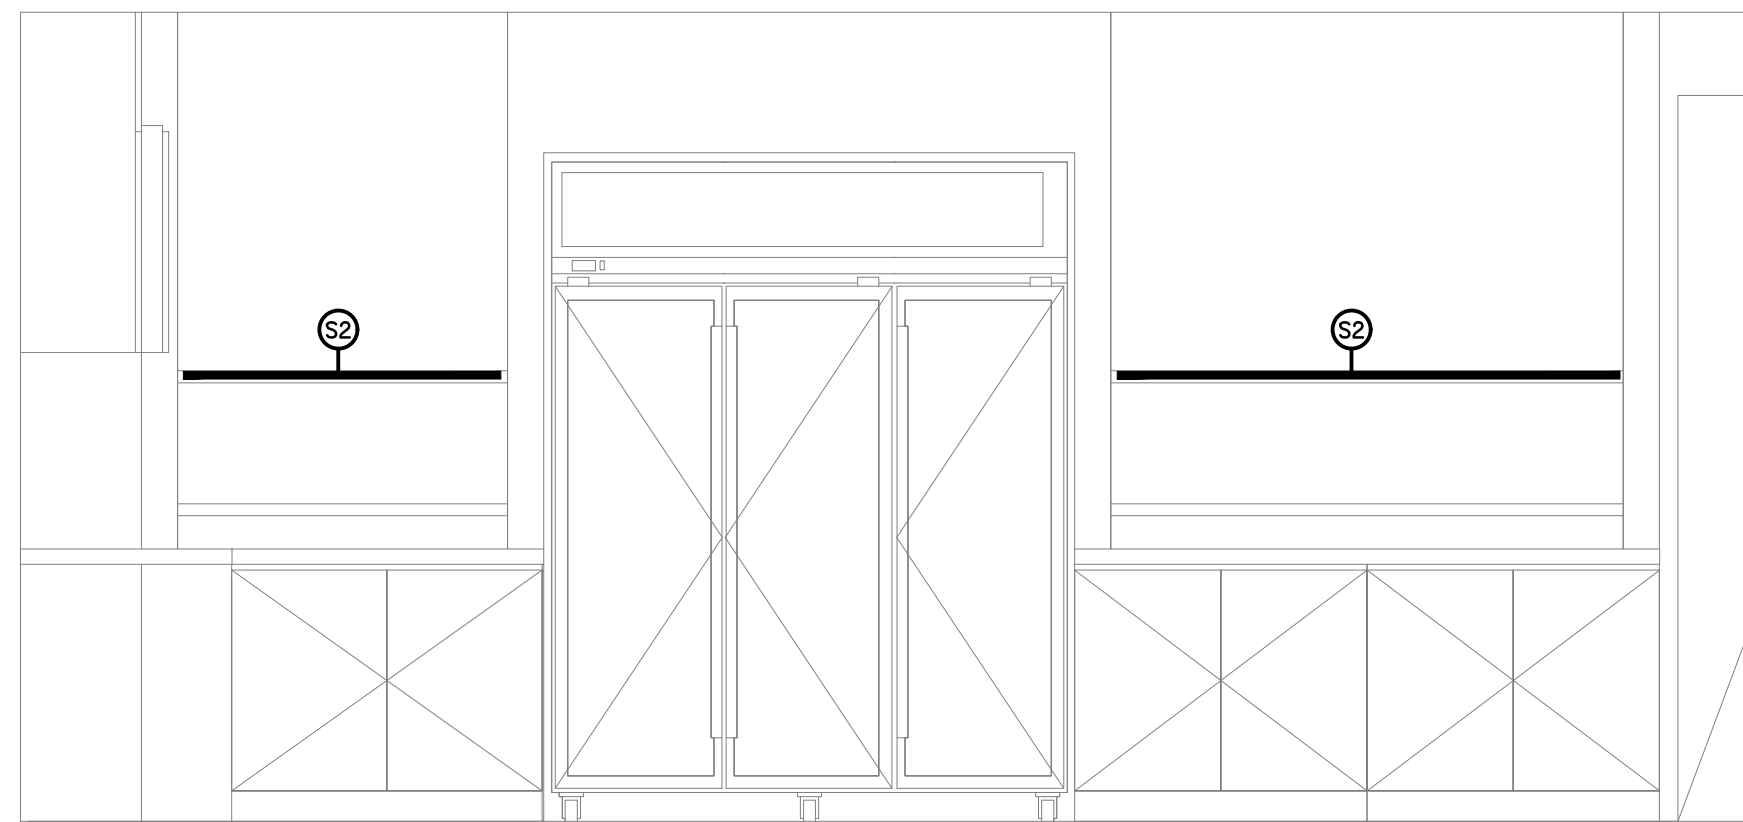

DETAIL B
CASHIER REAR WALL ELEVATION
SCALE 1: 25

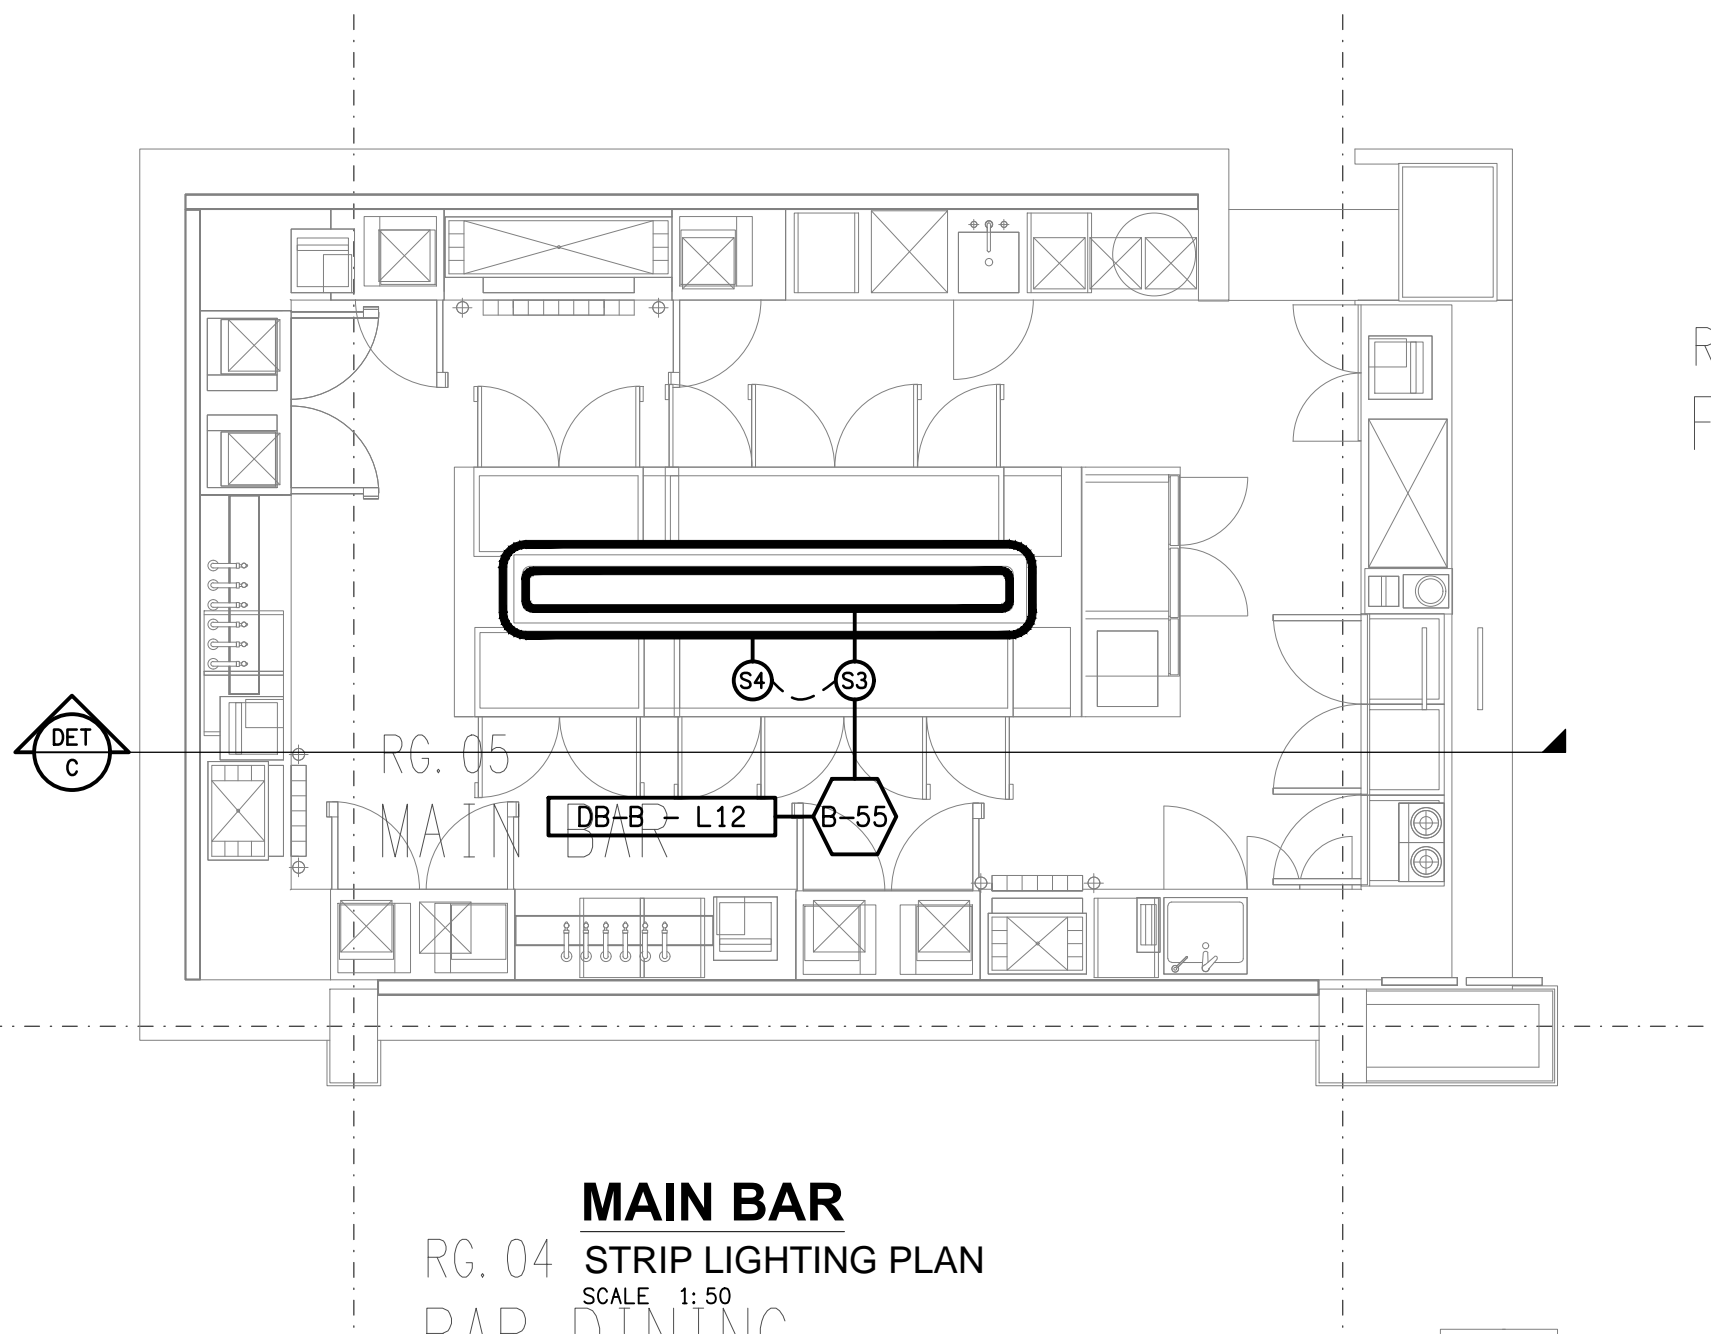

MAIN BAR
STRIP LIGHTING PLAN
SCALE 1: 50

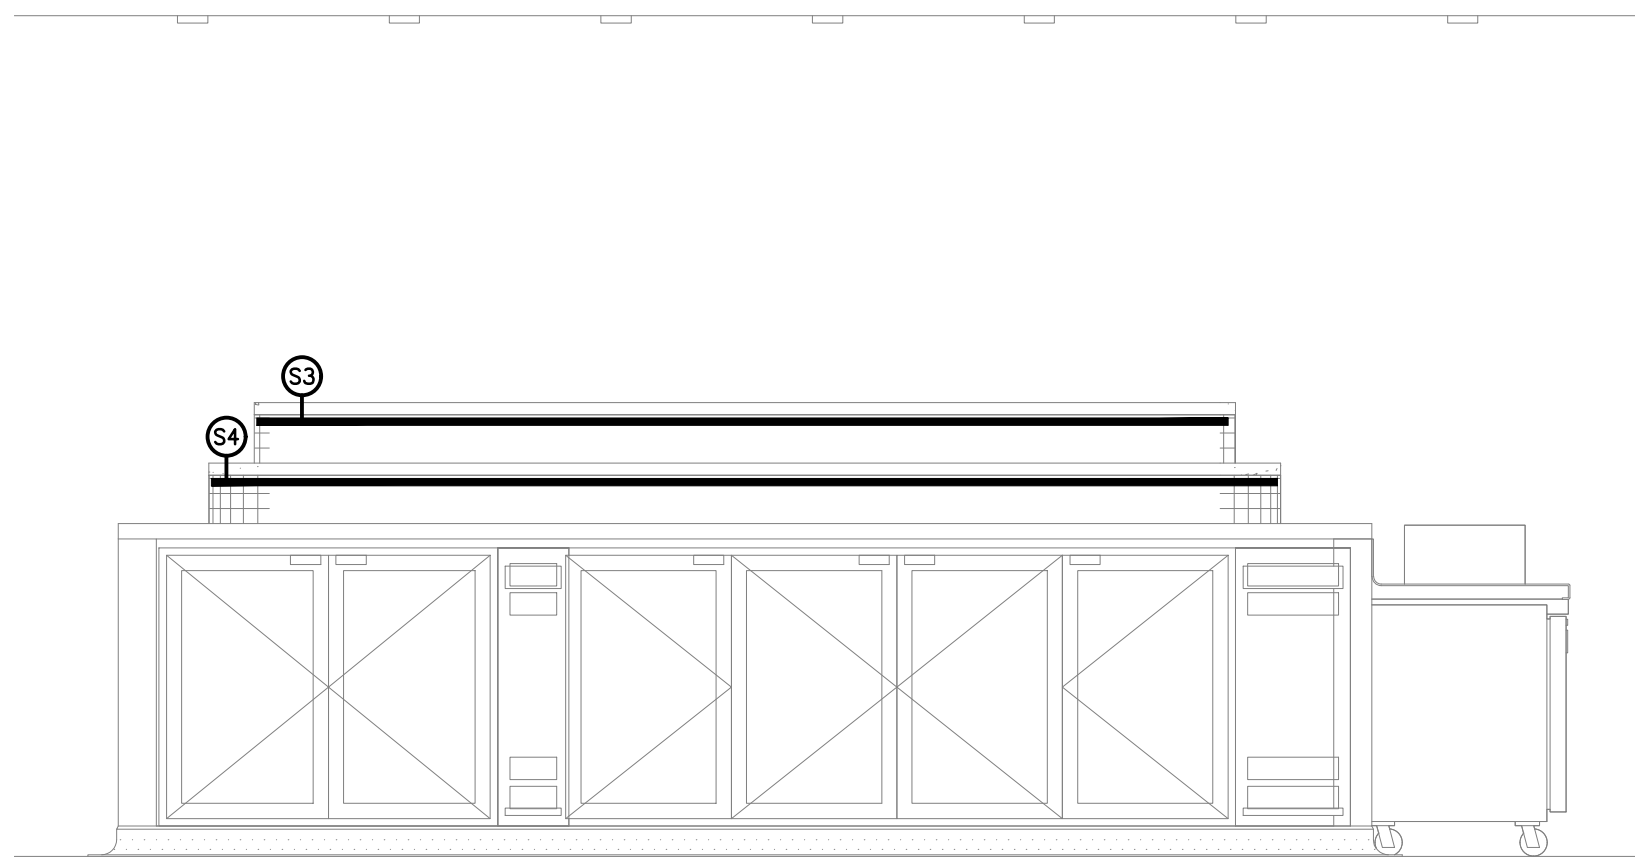

DETAIL C
MAIN BAR DRINKS ISLAND ELEVATION
SCALE 1: 25

ELECTRICAL DESIGN GROUP BRISBANE
PTY LTD
ACN 092 710 793
TRADING AS:
ELECTRICAL DESIGN GROUP

THE COPYRIGHT OF THIS DRAWING
REMAINS THE PROPERTY OF THE
ELECTRICAL DESIGN GROUP.
USE FIGURED DIMENSIONS
IN PREFERENCE TO SCALE.
ALL DIMENSIONS TO BE
VERIFIED ONSITE.

ELECTRICAL DESIGN GROUP
ELECTRICAL BUILDING SERVICES CONSULTANTS
BRISBANE GOLD COAST
P.O.Box 15, Sherwood Q.4075
Phone: (07) 3278 4375
Email: brisbane@edg.net.au
Web: www.edg.net.au

PROJECT:
BRACKEN RIDGE TAVERN
154 BARRETT STREET, BRACKEN RIDGE

C	CONSTRUCTION	13/05/2025
REV:	DESCRIPTION:	DATE:
DRAWING: ELECTRICAL SERVICES PART B JOINERY LIGHTING DETAILS		
SCALE: 1:50 UNO	AT A1	PROJECT NO: C3358a DRAWING NO: E10 REVISION: C