



FLOOR PLAN
CABLE ROUTE LAYOUT
SCALE 1: 100

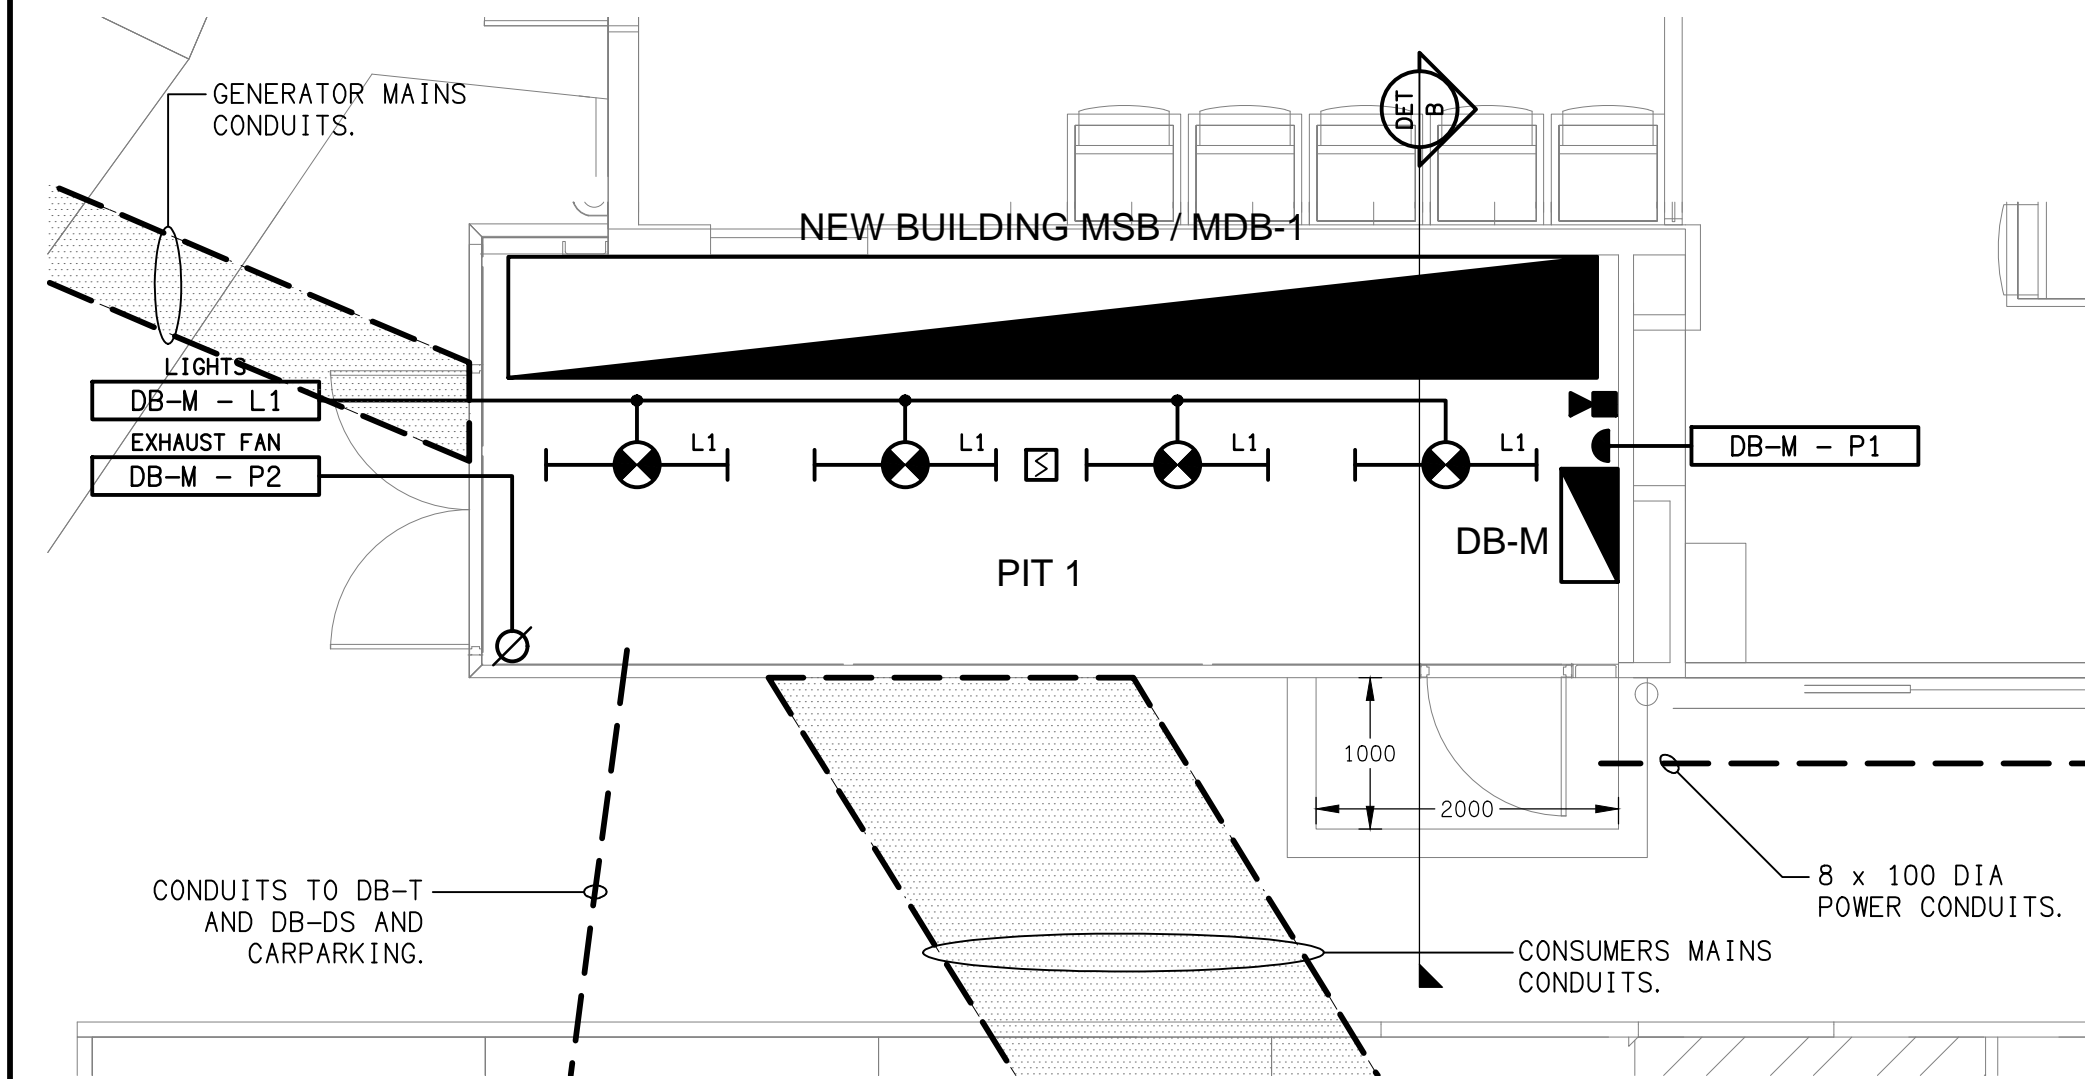

DETAIL A
MDB-1 ROOM PLAN VIEW
SCALE 1: 50

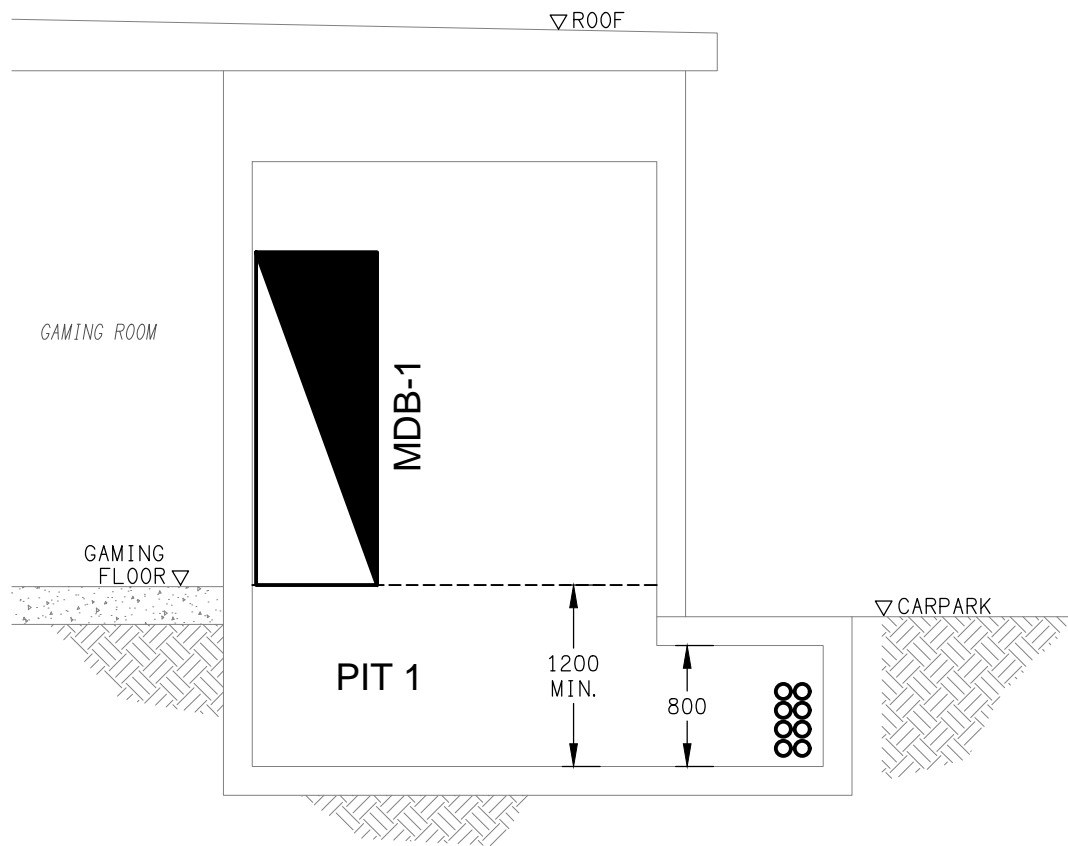

DETAIL B
MDB-1 ROOM SECTION VIEW
SCALE 1: 50