


NOTE:
REFER TO DRAWING C3391a-E06.dwg FOR THE
ADDITIONAL JOINERY & WALL LIGHTING PLAN.

REFER TO DRAWING C3391a-E07.dwg FOR THE
ADDITIONAL CEILING FAN & DECK HEATER PLAN.

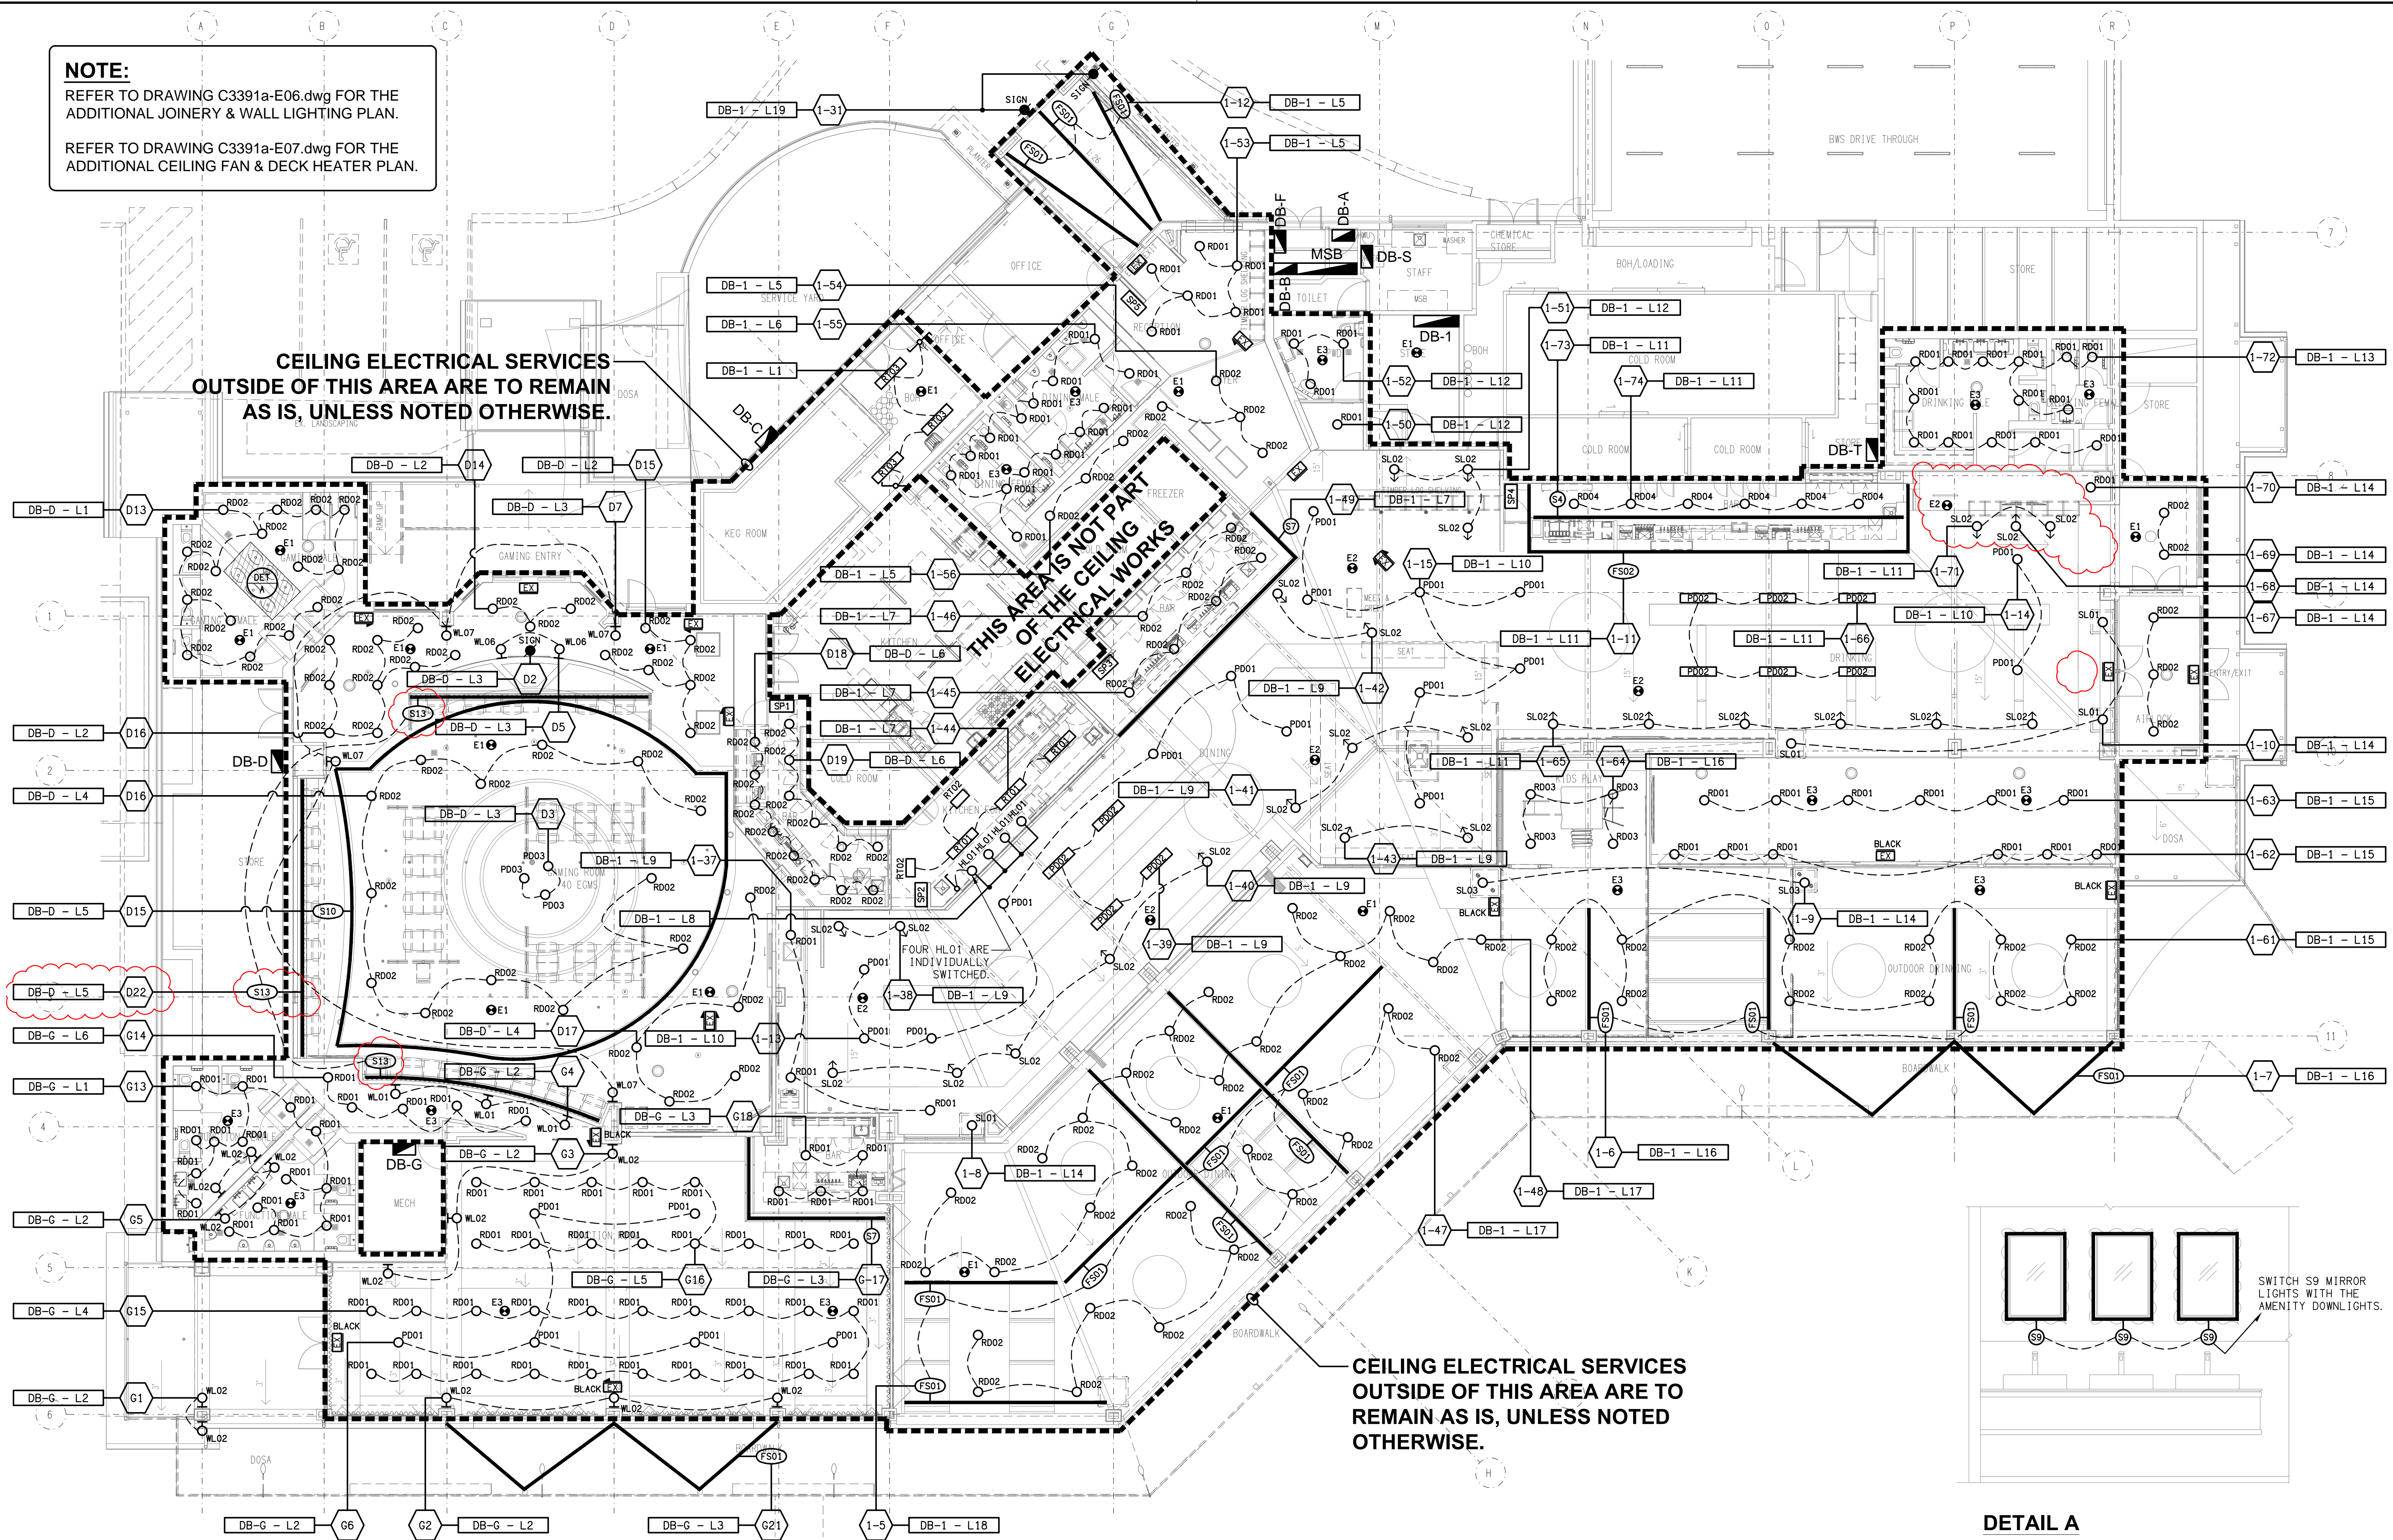

DETAIL A
TYPICAL GAMING VANITY BENCH ELEVATION
SCALE 1: 25