


LEGEND

- ELECTRICAL SERVICES SWITCHBOARD.
- SWITCHBOARD BY OTHERS.
- SINGLE POWER OUTLET.
- DOUBLE POWER OUTLET.
- DOUBLE POWER OUTLET C/W USB CHARGER.
- SPECIAL PURPOSE POWER OUTLET.
- SIGN CONNECTION.
- SINGLE PHASE ISOLATOR.
- ELECTRICAL FLOOR BOX, TYPE AS NOTED.
- LIGHTING CONTROL SWITCH PANEL, TYPE AS NOTED.
- ONE-WAY LIGHT SWITCH.
- CIRCUIT LINE.
- SWITCH LINE.
- POWER CIRCUIT DESIGNATION.
DENOTES DB AND CIRCUIT.
- ELECTRICAL EQUIPMENT AS NOTED.
- RJ45 COMMUNICATIONS OUTLET.
- MATV OUTLET.
- SMOKE DETECTOR.
- SMOKE DETECTOR CONCEALED.
- RECESSED FIRE ALARM SPEAKER.
- E1: GENERAL LED EMERGENCY LIGHT.
- EX: EMERGENCY LED EXIT LIGHT.
- S1: RECESSED LOW GLARE DOWNLIGHT.
- S1a: RECESSED LOW GLARE DOWNLIGHT.
- S2: RECESSED ULTRA LOW GLARE DOWNLIGHT.
- S3: RECESSED ULTRA LOW GLARE DOWNLIGHT.
- PE1: DECORATIVE SUSPENDED PENDANT.
- PE3: DECORATIVE SUSPENDED PENDANT.
- CL3: SUSPENDED CUSTOM EXTRUSION LIGHT FITTING.
- IL1: CONTINUOUS LOOP LED STRIP LIGHT.
- LL1-1: RECESSED CUSTOM LINEAR PROFILE LIGHT FITTING.
- L1: RECESSED DOWNLIGHT.
- L2: 3800 LONG TRACK WITH 4 ADJUSTABLE LIGHT FITTINGS.
- L3: ROD SUSPENDED 4500 DIA ROUND RING PENDANT.
- L4: RECESSED DOWNLIGHT.
- L5: RECESSED DOWNLIGHT LOCATED WITHIN THE EXISTING CUTOUTS.
- L6: CEILING PELMET LED STRIP LIGHT.
- L7: CEILING PELMET LED STRIP LIGHT.
- L8: FEATURE TIMBER CEILING LED STRIP LIGHT.
- L9: RECESSED DOWNLIGHT LOCATED WITHIN THE EXISTING CUTOUTS.


NOTE

ALL ELECTRICAL PENETRATIONS THROUGH THE ROOF SHEETING ARE TO BE IN LINE WITH THE STRUCTURAL OR MECHANICAL SERVICES PENETRATIONS TO AVOID DEDICATED FLASHINGS FOR THE ELECTRICAL SERVICES.

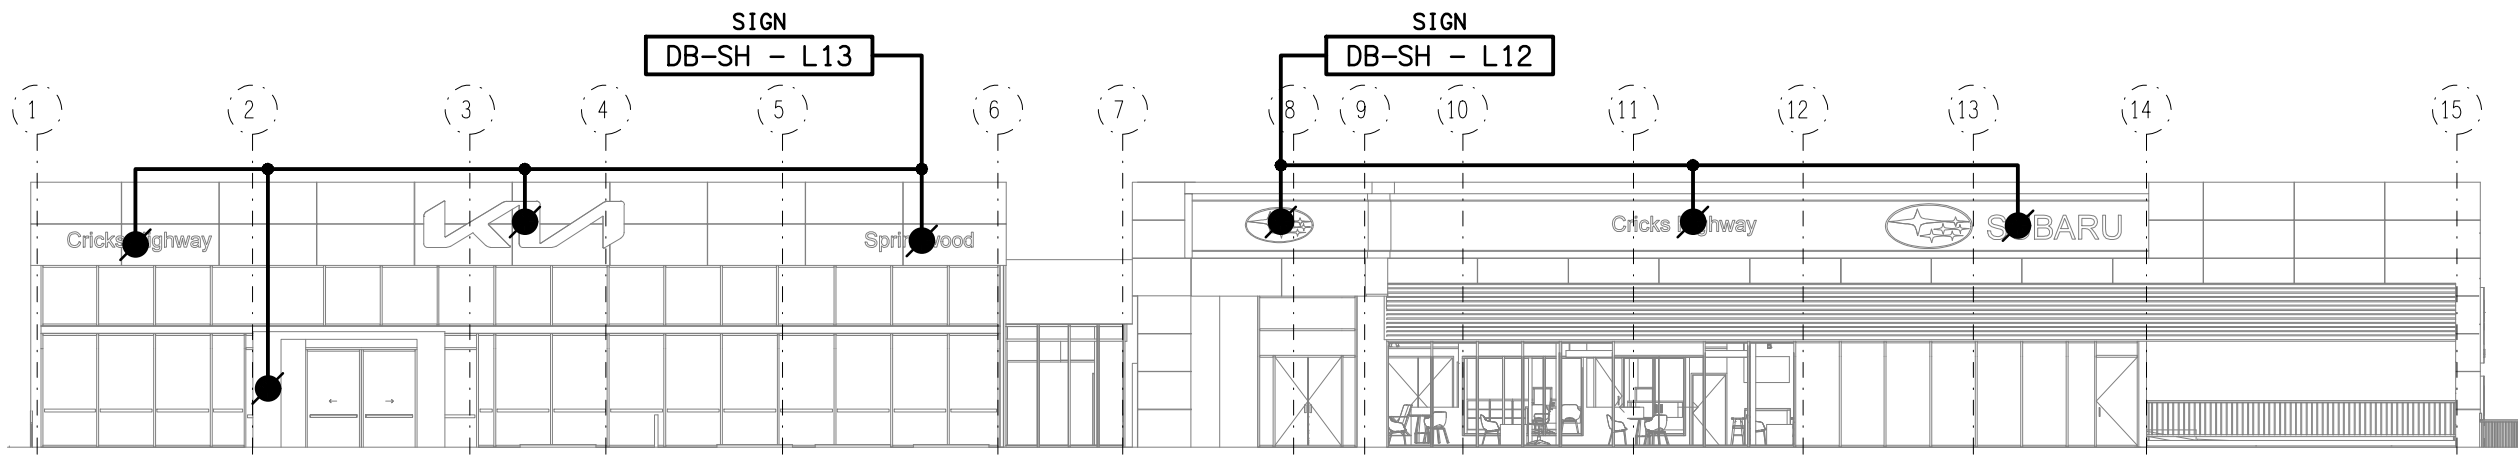

ELEVATION

PACIFIC HIGHWAY SERVICE ROAD SIDE
SCALE 1:200

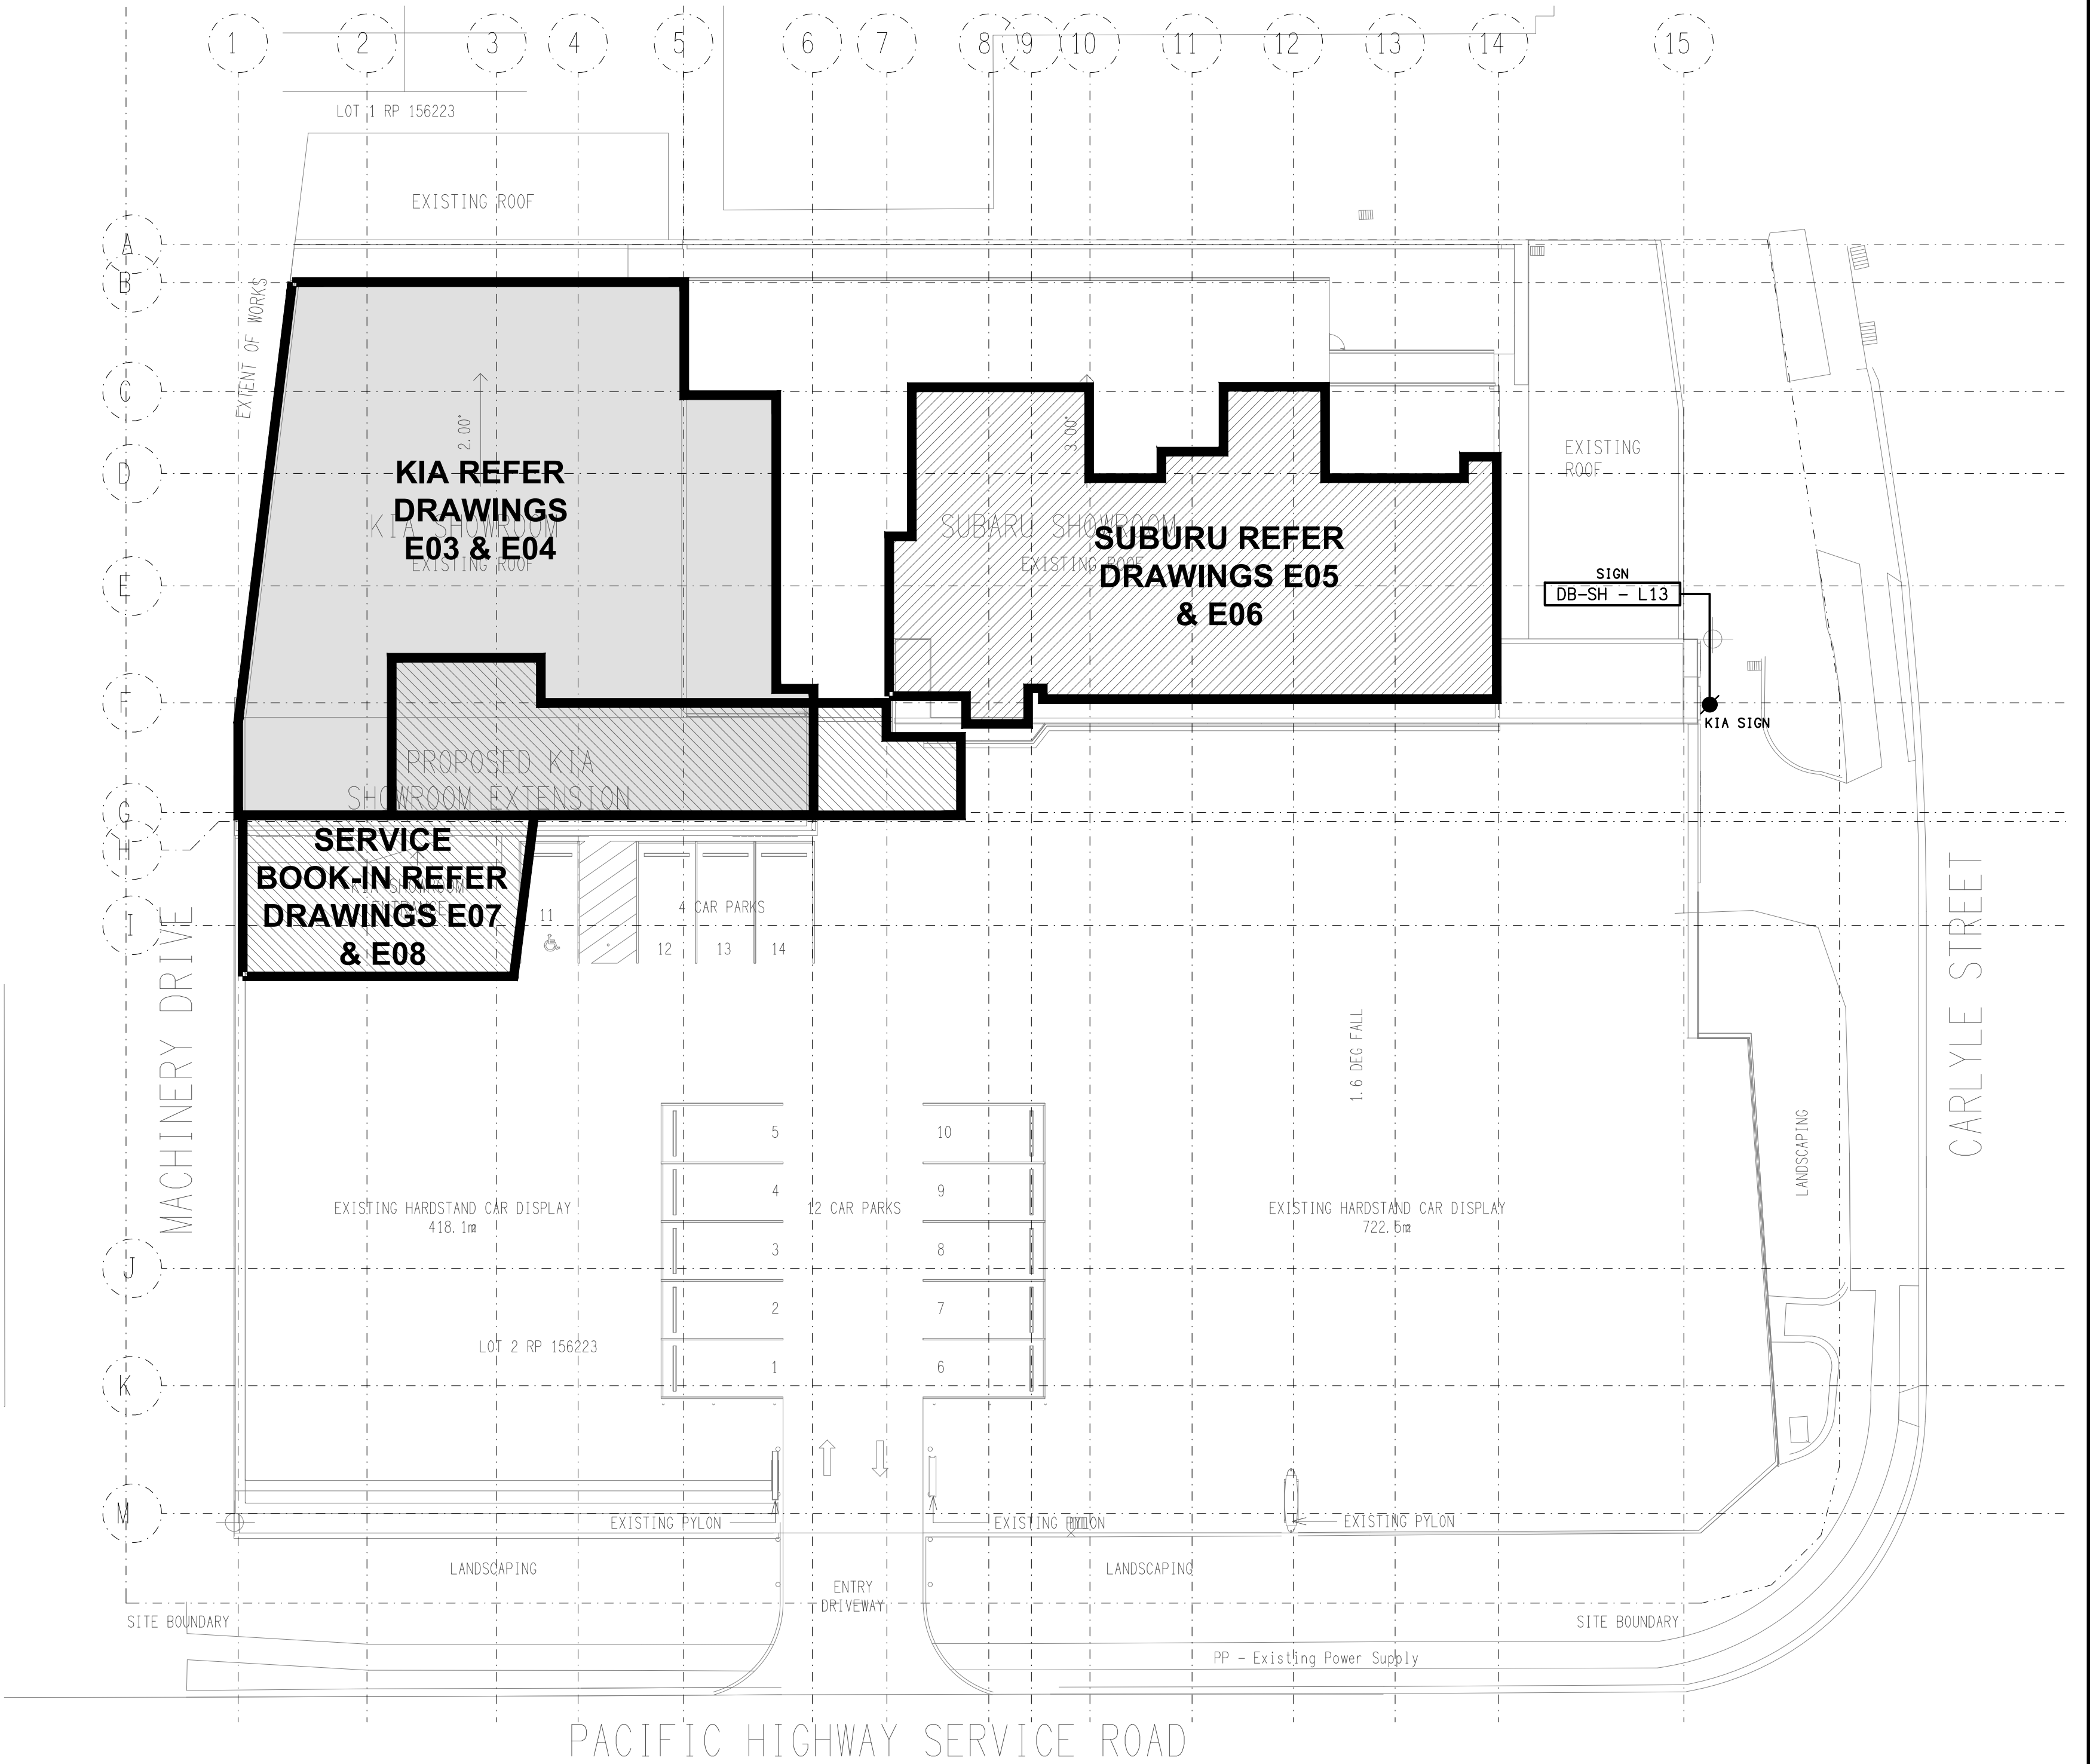


SITE PLAN

KIA & SUBARU SHOWROOMS
SCALE 1:200

SCHEMATIC

RJ45 PINOUT CONFIGURATION
NOT TO SCALE

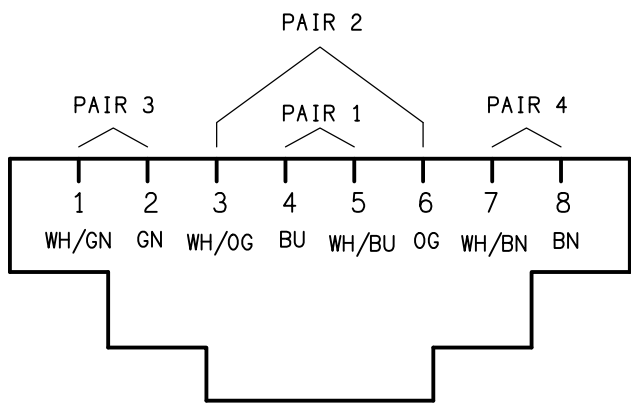

ELECTRICAL DESIGN GROUP BRISBANE
PTY LTD
ACN 092 710 793
TRADING AS:
ELECTRICAL DESIGN GROUP

THE COPYRIGHT OF THIS DRAWING
REMAINS THE PROPERTY OF THE
ELECTRICAL DESIGN GROUP.
USE FIGURED DIMENSIONS
IN PREFERENCE TO SCALE.
ALL DIMENSIONS TO BE
VERIFIED ONSITE.

ELECTRICAL DESIGN GROUP
ELECTRICAL BUILDING SERVICES CONSULTANTS
BRISBANE GOLD COAST

P.O.Box 15, Sherwood Q.4075
Phone: (07) 3278 4375
Email: brisbane@edg.net.au
Web: www.edg.net.au

PROJECT:
AUTOPACT KIA SPRINGWOOD

3477-3483 PACIFIC HIGHWAY, SLACKS CREEK

B	CONSTRUCTION	30/06/2025
REV:	DESCRIPTION:	DATE:

DRAWING:
**ELECTRICAL SERVICES
LEGEND & SITE PLAN**

SCALE:
1:200

AT A1

PROJECT NO:
C3403a

DRAWING NO:
E01

REVISION:
B