


LOCATION PLAN
SERVICE BOOK-IN ELECTRICAL EQUIPMENT
SCALE 1: 200

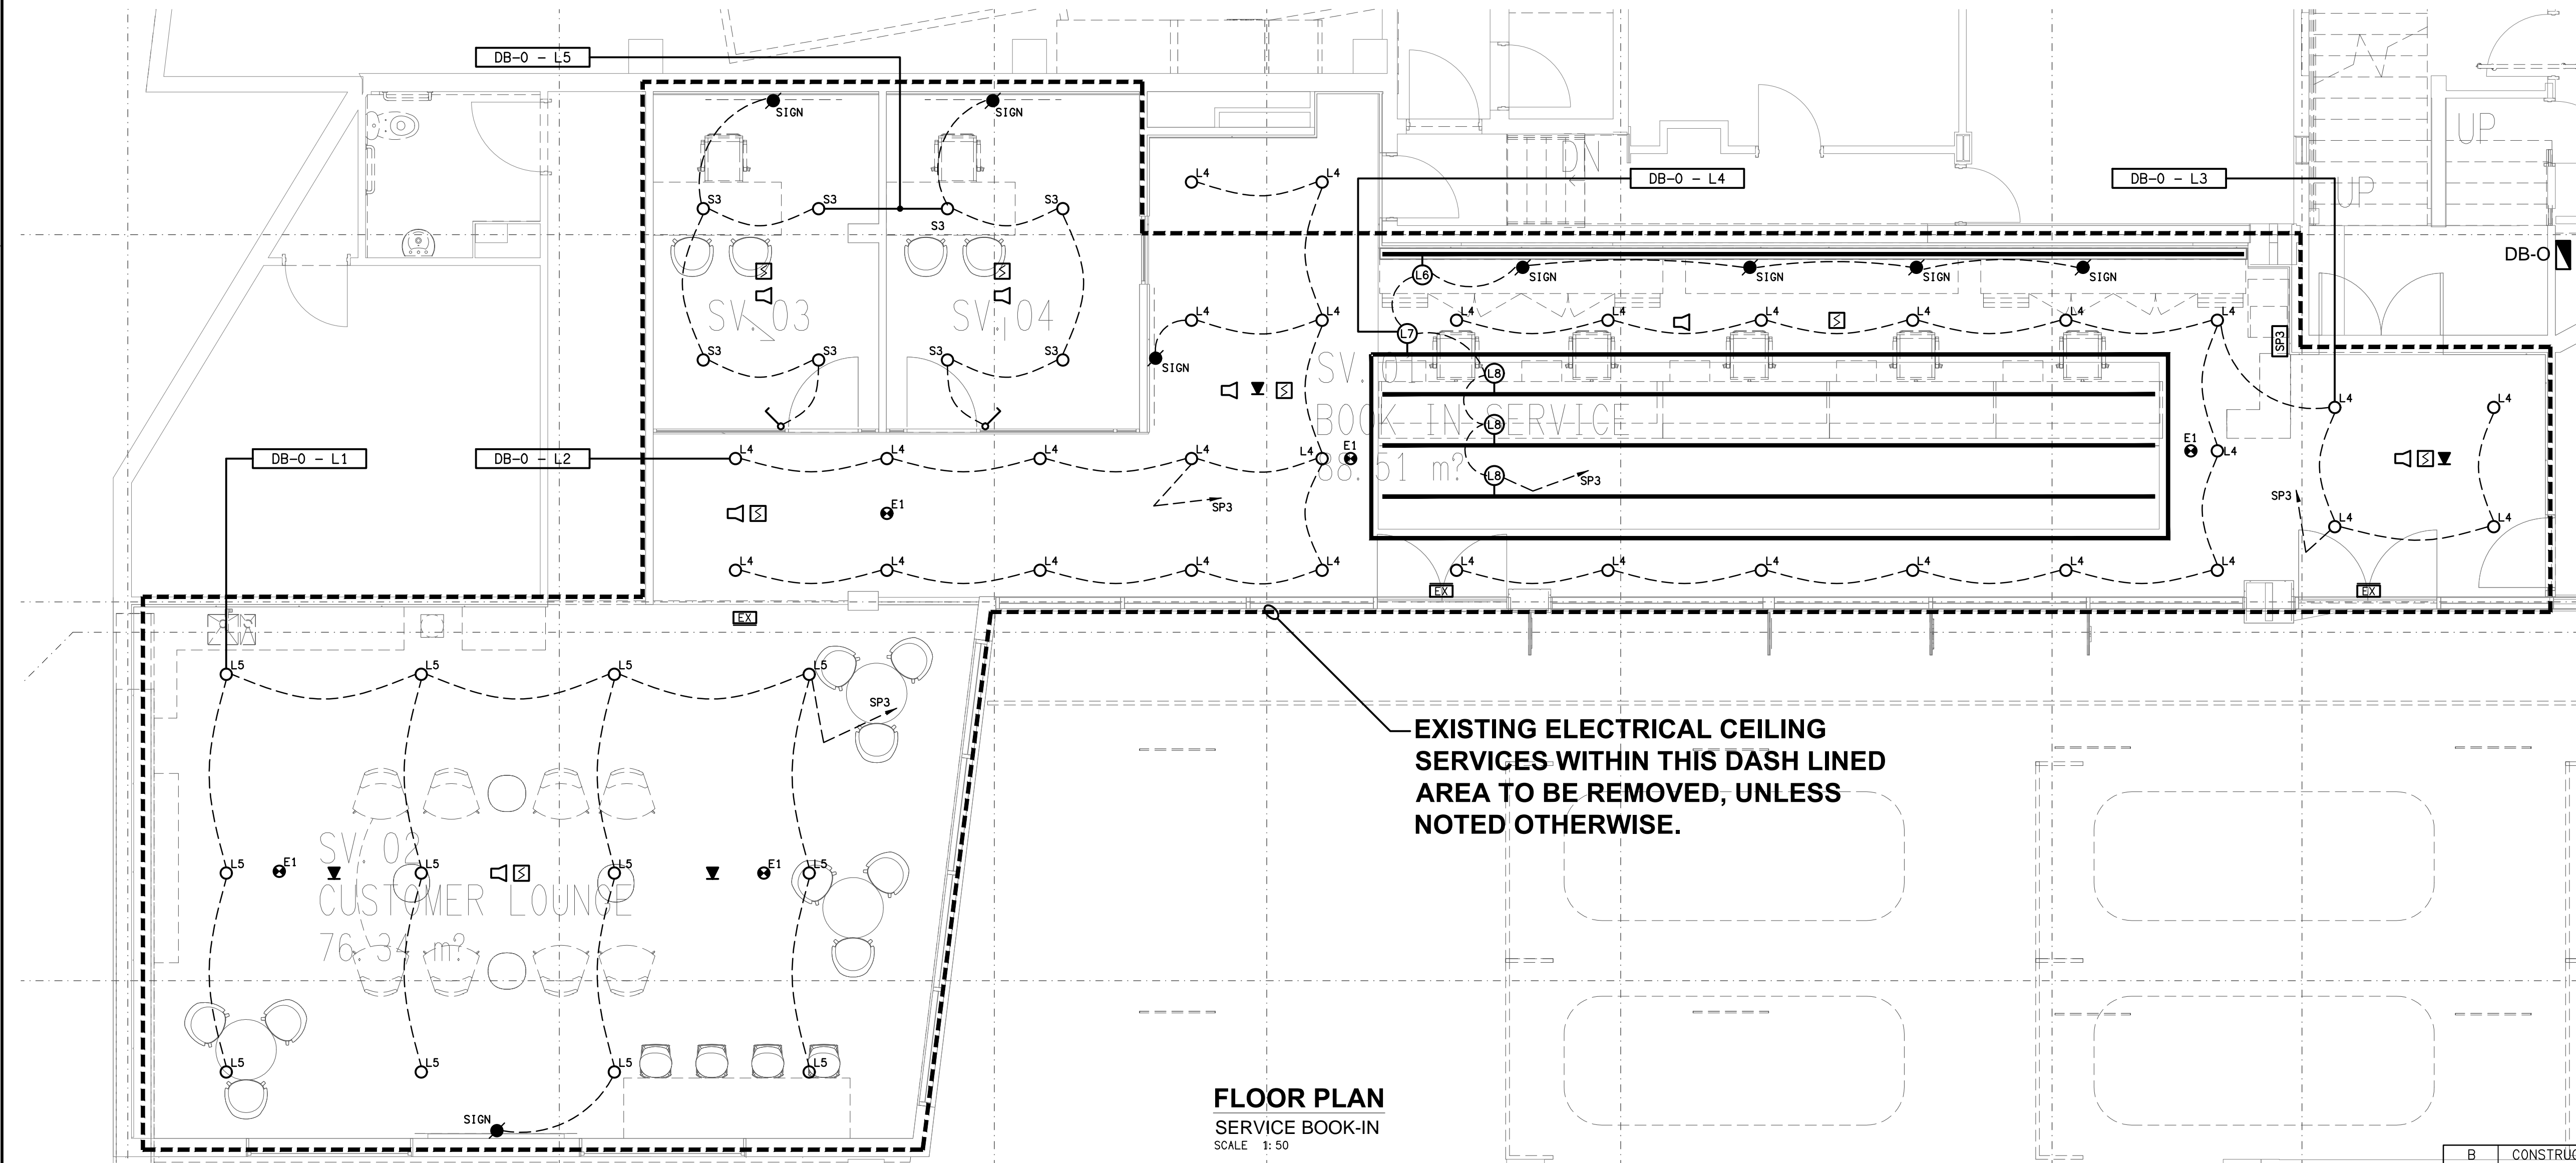

FLOOR PLAN
SERVICE BOOK-IN
SCALE 1: 50

ELECTRICAL DESIGN GROUP BRISBANE
PTY LTD
ACN 092 710 793
TRADING AS:
ELECTRICAL DESIGN GROUP

THE COPYRIGHT OF THIS DRAWING
REMAINS THE PROPERTY OF THE
ELECTRICAL DESIGN GROUP.
USE FIGURED DIMENSIONS
IN PREFERENCE TO SCALE.
ALL DIMENSIONS TO BE
VERIFIED ONSITE.

ELECTRICAL DESIGN GROUP
ELECTRICAL BUILDING SERVICES CONSULTANTS
BRISBANE GOLD COAST
P.O.Box 15, Sherwood Q.4075
Phone: (07) 3278 4375
Email: brisbane@edg.net.au
Web: www.edg.net.au

PROJECT:
AUTOPACT KIA SPRINGWOOD

3477-3483 PACIFIC HIGHWAY, SLACKS CREEK

B	CONSTRUCTION	30/06/2025
REV:	DESCRIPTION:	DATE:

DRAWING:	PROJECT NO:	DRAWING NO:	REVISION:
ELECTRICAL SERVICES SERVICE BOOK-IN REFLECTED CEILING PLAN			
SCALE: 1:50 UNO	AT A1	C3403a E08	B