




PROPOSED
FLOOR PLAN
SCALE 1:100

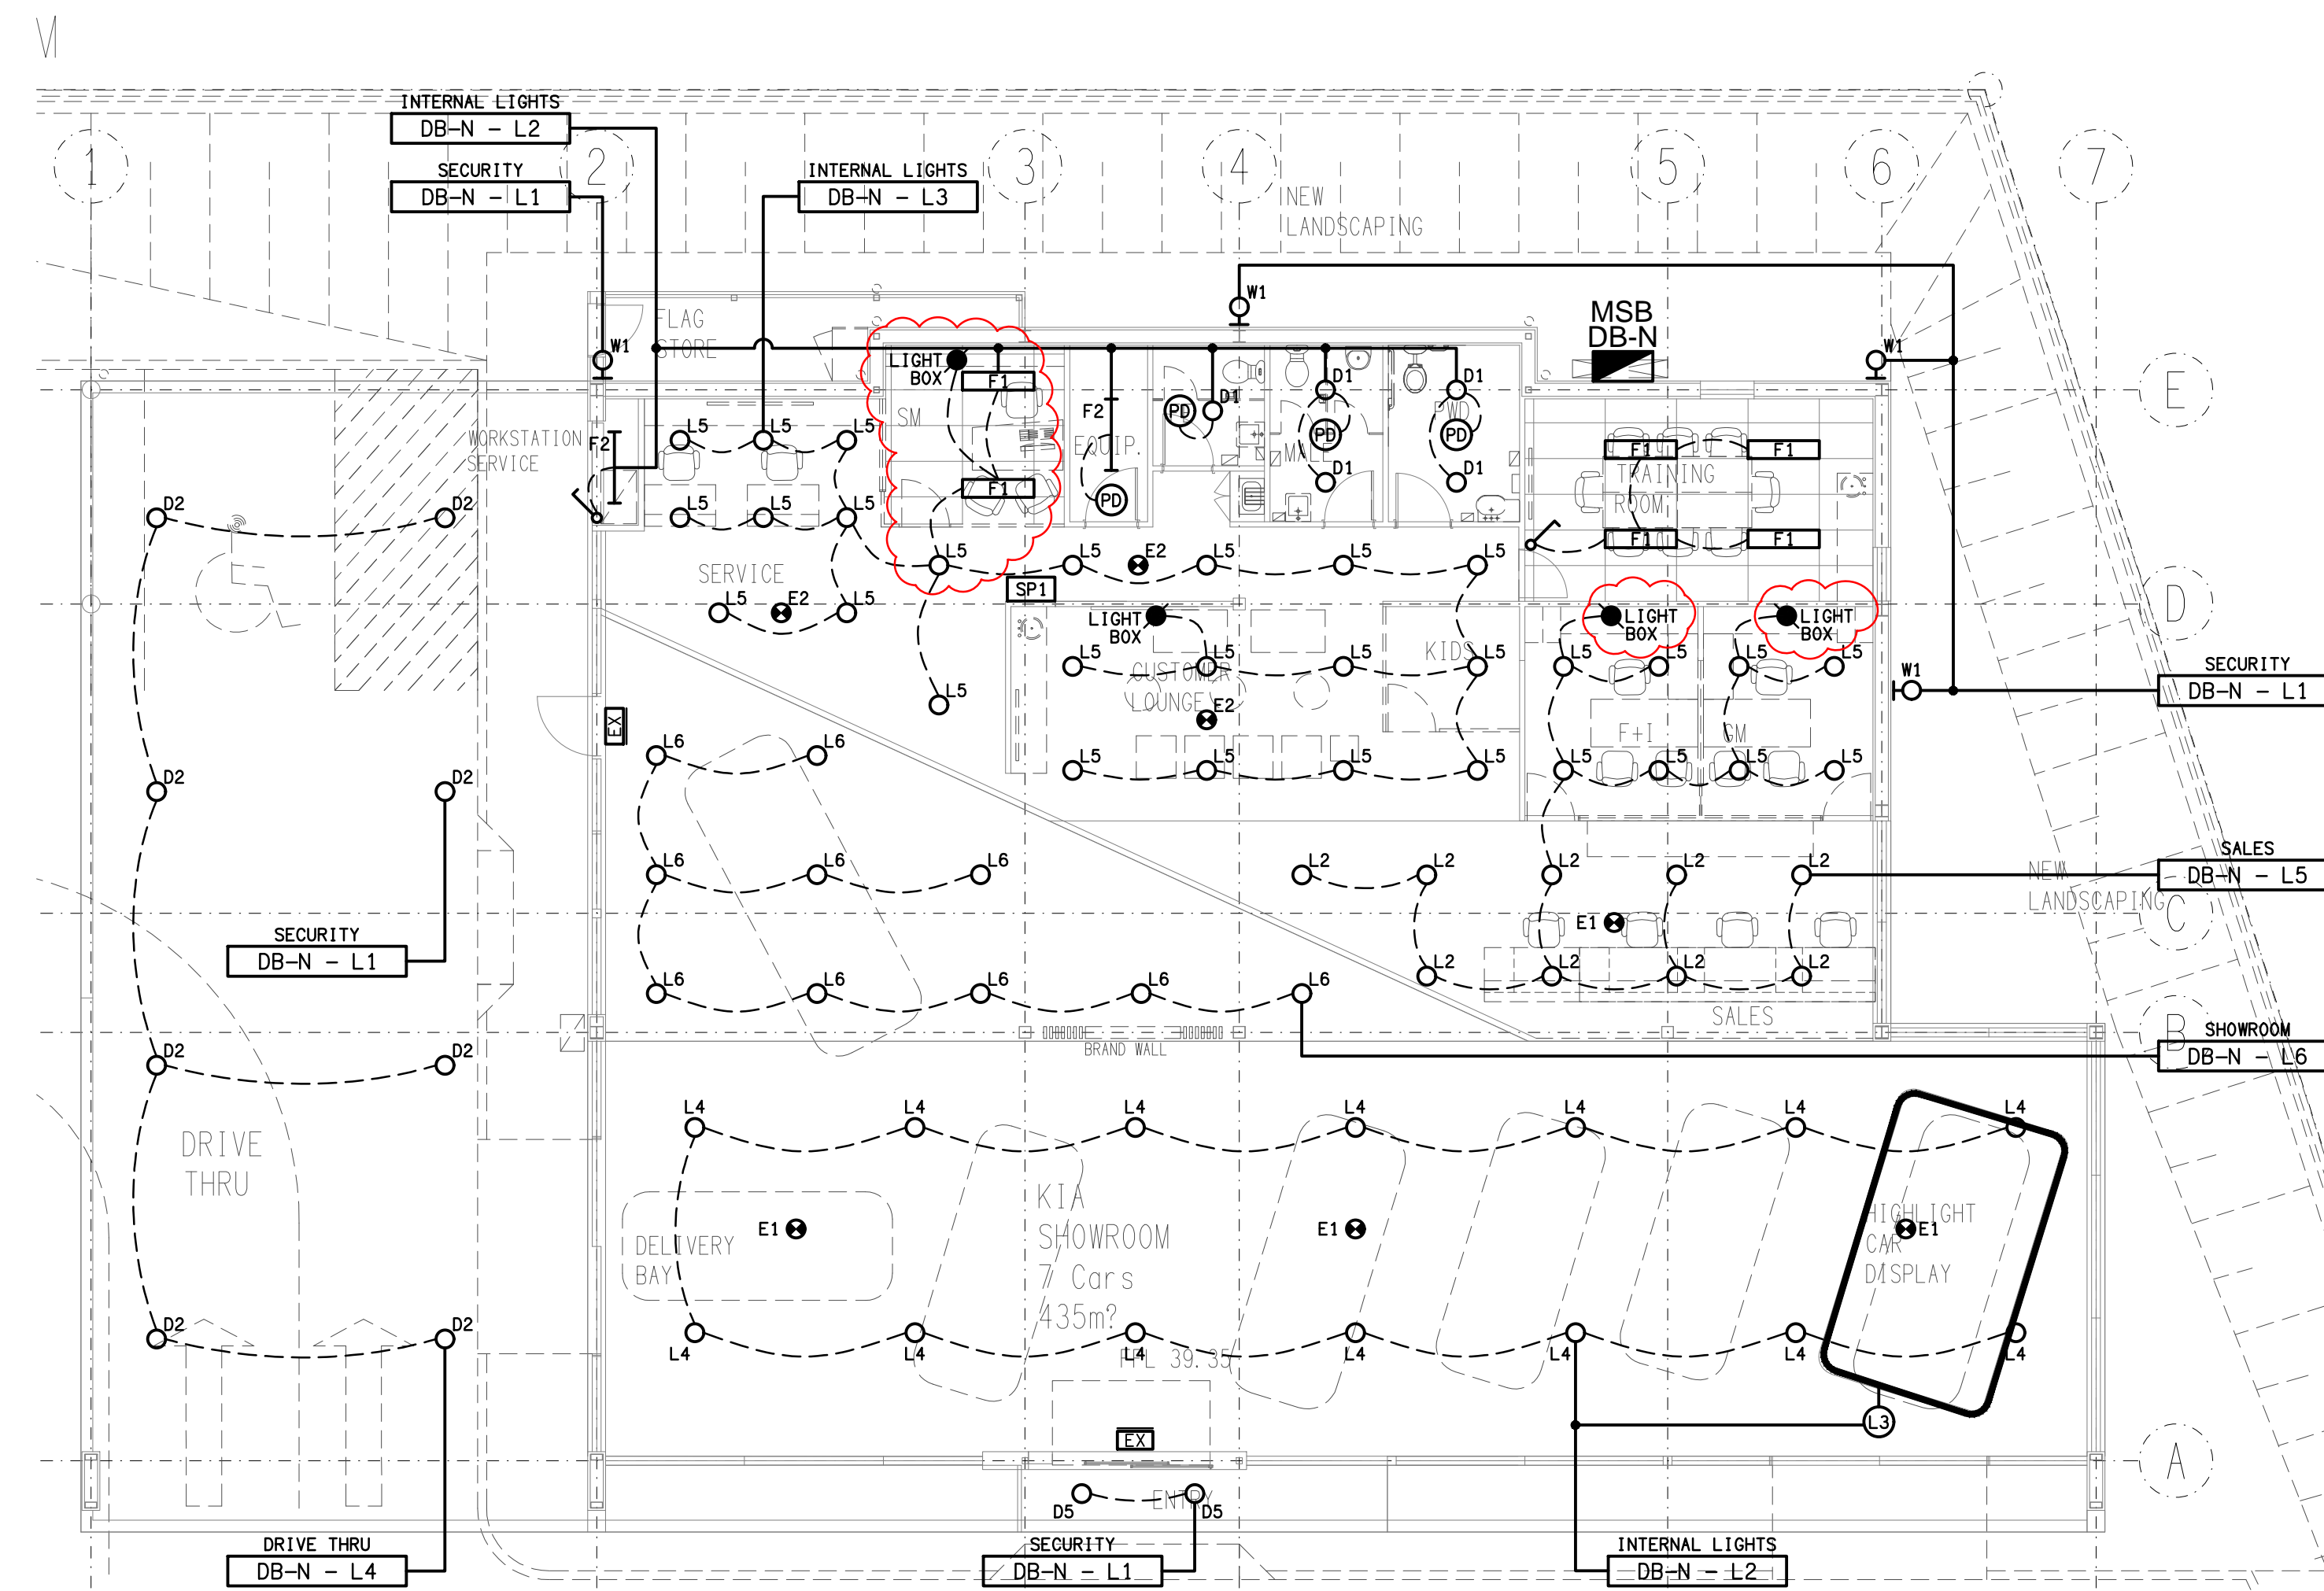

PROPOSED
REFLECTED CEILING PLAN
SCALE 1:100

REV.	DESCRIPTION	DATE
DRAWING: ELECTRICAL SERVICES PROPOSED PLANS		

SCALE: 1:100 UNO AT A1 PROJECT NO: C3454a DRAWING NO: E04 REVISION: F

ELECTRICAL DESIGN GROUP BRISBANE
PTY LTD
ACN 092 710 793

TRADING AS:
ELECTRICAL DESIGN GROUP

THE COPYRIGHT OF THIS DRAWING
REMAINS THE PROPERTY OF THE
ELECTRICAL DESIGN GROUP.

USE FIGURED DIMENSIONS
IN PREFERENCE TO SCALE.

ALL DIMENSIONS TO BE
VERIFIED ONSITE.

ELECTRICAL DESIGN GROUP
ELECTRICAL BUILDING SERVICES CONSULTANTS
BRISBANE GOLD COAST

P.O.Box 15, Sherwood Q.4075
Phone: (07) 3278 4375
Email: brisbane@edg.net.au
Web: www.edg.net.au

PROJECT: MOTORAMA - HILLCREST KIA

74 ANZAC AVENUE, HILLCREST