



ELECTRICAL DESIGN GROUP

ELECTRICAL BUILDING SERVICES CONSULTANTS

P.O. Box 15, SHERWOOD Q. 4075

Phone: (07) 3278 4375

Website: www.edg.net.au Email: brisbane@edg.net.au

C3455a - CAPALABA SPORTS CLUB - MULTI-STOREY CARPARK

C3455a-0001(H).xls


ELECTRICAL SERVICES CONTRACT DOCUMENT SCHEDULE

REVISION H - 30 SEPTEMBER 2025

ISSUING INFORMATION				DATE OF ISSUE								
	DAY	20	02	27	30	05	14	23	30			
	MONTH	02	05	05	05	06	08	09	09			
	YEAR	25	25	25	25	25	25	25	25			
REASON FOR ISSUE				P	P	P	T	T	C	C	C	
A = APPROVAL C = CONSTRUCTION N = COORDINATION P = PRELIMINARY T = TENDER												

DISTRIBUTION				NUMBER OF COPIES								
WWW.EDG.NET.AU				1E	1E	1E	1E	1E	1E	1E	1E	
BSPN ARCHITECTURE				1E	1E	1E	1E	1E	1E	1E	1E	
P = PRINT T = TRACING D = DISC E = EMAIL F = FAX												

DOCUMENTS		TITLE		REVISION								
C3455a-E01.dwg		LEGEND & SITE PLAN		A	B	C	D	E	F	G	H	
C3455a-E02.dwg		GROUND LEVEL PLAN		A	B	C	D	E	F	G	H	
C3455a-E03.dwg		LEVEL 1 PLAN		A	B	C	D		E	F	G	
C3455a-E04.dwg		NOTES		A	B		C		D			
C3455a-0001.xls		CONTRACT DOCUMENT SCHEDULE		A	B	C	D	E	F	G	H	
C3455a-0004.xls		DISTRIBUTION BOARD DB-C SCHEDULE					A		B			

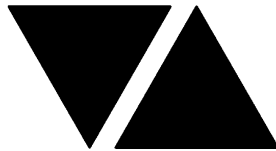

ELECTRICAL DESIGN GROUP

ELECTRICAL BUILDING SERVICES CONSULTANTS

P.O. Box 15, SHERWOOD Q. 4075

Phone: (07) 3278 4375 Fax: (07) 3716 0222

Web Site: www.edg.net.au Email: brisbane@edg.net.au

C3455a - CAPALABA SPORTS CLUB - MULTI-STOREY CARPARK

C3455a-0004(B).xls


DISTRIBUTION BOARD DB-C (GROUND)

REVISION B - 14 AUGUST 2025

							REV
FAULT CURRENT: 6kA UTILISING CASCADING							A
CHASSIS SIZE: 1 x 84 POLES							B
CHASSIS RATING: 250A							A
PHASES: 3							A
MAIN SWITCH: 250A NON AUTO LOAD BREAK							
SUPPLIED FROM: MSB							
SUPPLY CABLE: 4C70							
PROVIDE THE DISTRIBUTION BOARD WITH SURGE PROTECTION AND AN AS2293 TESTING FACILITY. EACH CUBICAL MUST BE AT LEAST 700 WIDE. IN ADDITION TO THE DISTRIBUTION CUBICAL PROVIDE A SECOND FULL HEIGHT CUBICAL SEPERATED INTO TWO EQUAL SECTIONS WITH EACH SECTION HAVING A SEPERATE DOOR AND REMOVABLE MOUNTING PANS.. PROVIDE THE TOP SECTION WITH FOUR FULL WIDTH HORIZONTAL DIN RAILS EVENLY SPACED TO ACCOMMODATE THE CONTROLS SUPPLIED AS PART OF THE CONTRACT WORKS AND FUTURE EV METERING EQUIPMENT. THE BOTTOM CUBICAL IS TO BE PROVIDED FOR THE IRRIGATION CONTRACTOR TO USE. PROVIDE ALL CUBICALS WITH TOP AND BOTTOM CABLE ACCESS C/E GLAND PLATES. REFER TO THE NOTES FOR ADDITIONAL SWITCHBOARD REQUIREMENTS.							A
CIRC	PH	CIRCUIT BREAKER (amps)	CONTROL EQUIPMENT	CABLE SIZE (mm2)	LOCATION	CIRCUIT USE	
P1	3	32 C CURVE		6 + 6 EARTH	GROUND	LIFT	A
P2	1	20	RCBO	2.5	ON GRADE	FIRE PUMP	A
P3							B
P4							B
P5							B
P6	3	63		16.0	LEVEL 1	EV-4	A
P7	3	63		16.0	LEVEL 1	EV-5	A
P8							B
P9	3	20	RCBO	4.0	GROUND	3PH OUTLET	A
P10	3	20	RCBO	4.0	GROUND	3PH OUTLET	A
P11	1	20	RCBO	4.0	GROUND / LEVEL 1	MAINTENANCE	A
P12	1	20	RCBO	4.0	GROUND / LEVEL 1	MAINTENANCE	A
P13	3	20	RCBO	4.0	LEVEL 1	3PH OUTLET	A
P14	3	20	RCBO	4.0	LEVEL 1	3PH OUTLET	A
P15	1	20	RCBO	2.5	GROUND	CR-A	A
P16	3	20	RCBO	4.0	GROUND	PUMP	A
L1	1	20	RCBO	2.5	ON GRADE	CARPARK LIGHTING	A
L2	1	20	RCBO	2.5	GROUND	CARPARK LIGHTING	A
L3	1	20	RCBO	2.5	GROUND	CARPARK LIGHTING	A
L4	1	20	RCBO	2.5	GROUND	CARPARK LIGHTING	A
L5	1	20	RCBO	2.5	GROUND	CARPARK LIGHTING	A
L6	1	20	RCBO	2.5	GROUND	CARPARK LIGHTING	A
L7	1	20	RCBO	2.5	GROUND	CARPARK LIGHTING	A
L8	1	20	RCBO	2.5	GROUND	STAIR / PLANT LIGHTING	A
L9	1	20	RCBO	2.5	GROUND	ENTRY LIGHTING	A
L10	1	20	RCBO	2.5	GROUND	SIGN	A
L11	1	20	RCBO	2.5	GROUND	SIGN	A
L12	1	20	RCBO	2.5	GROUND	SIGN	A
L13	1	20	RCBO	2.5	GROUND	SIGN	A
L14	1	20	RCBO	2.5	LEVEL 1	LOBBY LIGHTING	A
L15	1	20	RCBO	2.5	LEVEL 1	CARPARK LIGHTING	A
L16	1	20	RCBO	2.5	LEVEL 1	CARPARK LIGHTING	A

LEGEND

THE LIGHT FITTING SUPPLIER CONTACT DETAILS MAY BE AVAILABLE ON THE EDG WEBSITE VIA THE FOLLOWING LINK www.edg.net.au/Links/Lighting.htm				
TYPE	LAMPS	DESCRIPTION	COLOUR / ACCESSORY	CATALOGUE No
L1	50W 4000K LED	POLE MOUNTED CARPARK LIGHT C/W INTEGRAL DALI DIMMABLE DRIVER WITH THE FITTING 6M ABOVE THE LEVEL 1 CARPARK DECK. THE POLES ARE TO BE MOUNTED ON THE DECK NOT THE PARAPET. ALL CONDUITS ARE TO HAVE A SPARE DRAW WIRE AND BE SHOWN ON THE AS CONSTRUCTED DOCUMENTS.	BLACK FITTING BLACK POLE	MELEC ML-ROX-50-4K-BK
L2	NO LONGER REQUIRED			
L3	36W LED 4000K	SURFACE MOUNTED IP66 1200 LONG BATTEN C/W INTEGRAL DRIVER AND SENSOR.	LIGHT GREY	EQUAL TO GAMMA ILLUMINATION STORM 1558-CCT-36W + SENSOR
L4	NO LONGER REQUIRED			
L5	52W 5000K LED	SURFACE MOUNTED IP54 CARPARK ENTRY LIGHT C/W INTEGRAL DALI DIMMABLE DRIVER.	BLACK	GAMMA ILLUMINATION VIPA 1390-4K-52W DALI
L6	36W LED 4000K	SURFACE MOUNTED IP66 1200 LONG BATTEN C/W INTEGRAL DALI DIMMABLE DRIVER.	LIGHT GREY	EQUAL TO GAMMA ILLUMINATION STORM 1558-CCT-36W
L7	17W LED 4000K	SURFACE MOUNTED DOWNLIGHT C/W INTEGRAL DALI DIMMABLE DRIVER	WHITE	BEGA 34021
L8	3000K LED 1000 LUMEN / METER	SURFACE MOUNTED IP66 EXTRUSION C/W ALUMINIUM EXTRUSION FIXED BETWEEN THE SLATS TO ILLUMINATE DOWNWARDS AS PER THE ARCHITECTURAL DETAIL. PROVIDE THE L8 FITTINGS WITH A COMMON REMOTE DALI DIMMABLE DRIVER LOCATED IN A CONCEALED ACCESSIBLE POSITION.	BLACK	NPA LIGHTING PR-LINI-1512 WITH BLACK OPAL DIFFUSER + LEDs = LF-DFB-WW-300-12 BW
L9	100W 4000K LED	9M POLE AND CARPARK LIGHT C/W INTEGRAL DALI DIMMABLE DRIVER. ALL CONDUITS ARE TO HAVE A SPARE DRAW WIRE AND BE SHOWN ON THE AS CONSTRUCTED DOCUMENTS.	BLACK FITTING BLACK POLE	MELEC ML-ROX-100-4K-BK
L10	22W 4000K LED	WALL MOUNTED IP65 DOWNLIGHT C/W INTEGRAL DALI DIMMABLE DRIVER	BLACK	GAMMA ILLUMINATION RODIO 1806-4K-22W
L11	22W LED 4000K	IP66 RECESSED DOWNLIGHT C/W INTEGRAL DALI DIMMABLE DRIVER	WHITE	GAMMA ILLUMINATION 1493-4K-22W DALI
L12	36W LED 4000K	SURFACE WALL MOUNTED IP66 BATTEN C/W INTEGRAL DRIVER.	LIGHT GREY	EQUAL TO GAMMA ILLUMINATION STORM 1558-CCT-36W
EX	LED	EXIT LIGHT: MAINTAINED WEATHER PROOF 24M VIEWING DISTANCE EXIT LIGHT C/W DIFFUSERS & DIRECTIONAL ARROWS AS SHOWN. CEILING OR WALL MOUNT BETWEEN 2100mm & 2700mm AFFL IF THERE IS NO VERTICAL SURFACE TO MOUNT THE FITTING ON WITHIN THIS RANGE CONFIRM THE MOUNTING HEIGHT WITH THE ENGINEER. AS2293 CLASSIFICATION C0-D1.25- C90-D2	WHITE	EQUAL TO CLEVERTRONICS LWELED
EMERGENCY PACK		LIGHT FITTINGS THAT ARE DESIGNATED AS BEING PROVIDED WITH AN EMERGENCY PACK ARE TO BE PROVIDED WITH AN INTEGRAL AS2293 EMERGENCY PACK. THE FITTINGS ARE TO BE NON MAINTAINED WITH ALL LAMPS SWITCHED AS PER THE LIGHTING CONTROL FOR THAT SPACE UNLESS NOTED OTHERWISE. REFER TO THE SPECIFICATION FOR FURTHER DETAILS OF THE CONFIGURATION AND SWITCHING OF EMERGENCY LIGHTS.		
WEATHERPROOF LIGHT SWITCH (WP)		IP56 LIGHT SWITCH MOUNTED AT 1000 AFFL.	-	CLIPSAL 56 SERIES
WEATHERPROOF POWER OUTLET (WP)		IP54 WEATHERPROOF SINGLE / DOUBLE POWER OUTLET AS NOTED ON DRAWING C/W COVER FLAP OVER SOCKET. MOUNT AT MINIMUM 1100mm AFFL U.N.O. RATING 10A U.N.O.	-	CLIPSAL WSCF227F
3-PHASE 20A POWER OUTLET		IP66, 3-PHASE, 20A POWER OUTLET MOUNTED AT 1000 AFFL UNLESS NOTED OTHERWISE.	-	CLIPSAL 56C320F-GY
SIGNAGE CONNECTION		COORDINATE THE LOCATION AND CONNECTION WITH THE SIGN CONTRACTOR ENSURING THE GPO / ISOLATORS ARE PROVIDED WITH APPROPRIATE WEATHER PROTECTION AND ARE CONCEALED FROM VIEW.		
SINGLE-PHASE ISOLATOR		SINGLE-PHASE WEATHERPROOF ISOLATOR. MOUNT AT 1350mm AFFL U.N.O. RATING 20A U.N.O. CONNECT TO EQUIPMENT VIA FLEXIBLE CONDUIT.	-	CLIPSAL WHT20
THREE-PHASE ISOLATOR		THREE-PHASE WEATHERPROOF ISOLATOR. MOUNT AT 1350mm AFFL U.N.O. RATING 20A U.N.O. CONNECT TO EQUIPMENT VIA FLEXIBLE CONDUIT.	-	CLIPSAL WHT35
COMMUNICATIONS RACK CR-C		CARPARK COMMUNICATIONS RACK AS PER THE NOTES. PROVIDE DETAILS FOR APPROVAL.		
EV CHARGING BOARD, TYPE AS NOTED.		ELECTRIC VEHICLE CHARGING DISTRIBUTION BOARD AS PER THE NOTES. PROVIDE A SHOP DRAWING FOR APPROVAL.		
DB-C		CARPARK DISTRIBUTION BOARD DB-C AS PER THE DB-C SCHEDULE, DB-C SCHEMATIC AND NOTES. PROVIDE A SHOP DRAWING OF DB-C FOR APPROVAL.		
MSB		MAIN SWITCHBOARD TO BE PROVIDED WITH A NEW MCCB TO SUPPLY DB-C. UPDATED THE MSB LABELS AT PRACTICAL COMPLETION.		
A1	CONDUIT ACCESS A1	PROVIDE A CONCEALED 25 DIA COMMUNICATIONS CONDUIT FROM THE POLE TO CR-C WITH AN ACCESSIBLE DRAW IN BOX EVERY 40M AND OR EVERY 3 X 90 DEG BENDS TO THE CCTV CONTRACTOR TO USE. PROVIDE THE CONDUIT WITH A SPARE DRAW WIRE.		
A2	CONDUIT ACCESS A2	PROVIDE A CONCEALED 25 DIA COMMUNICATIONS CONDUIT FROM A FLUSH CEILING DRAW IN BOX TO CR-C WITH AN ACCESSIBLE DRAW IN BOX EVERY 40M AND OR EVERY 3 X 90 DEG BENDS TO THE CCTV CONTRACTOR TO USE. PROVIDE THE CONDUIT WITH A SPARE DRAW WIRE.		
A3	CONDUIT ACCESS A3	PROVIDE A CONCEALED 32 DIA POWER CONDUIT FROM A FLUSH CEILING DRAW IN BOX TO DB-C WITH AN ACCESSIBLE DRAW IN BOX EVERY 40M AND OR EVERY 3 X 90 DEG BENDS TO FACILITATE A FUTURE RSD POWER SUPPLY. PROVIDE THE CONDUIT WITH A SPARE DRAW WIRE.		
A4	CONDUIT ACCESS A4	PROVIDE A CONCEALED 25 DIA COMMUNICATIONS CONDUIT FROM A FLUSH CEILING DRAW IN BOX TO CR-C WITH AN ACCESSIBLE DRAW IN BOX EVERY 40M AND OR EVERY 3 X 90 DEG BENDS TO FACILITATE A FUTURE TV CAT 6 CABLE. PROVIDE A CONCEALED 32 DIA POWER CONDUIT FROM A FLUSH CEILING DRAW IN BOX TO DB-C WITH AN ACCESSIBLE DRAW IN BOX EVERY 40M AND OR EVERY 3 X 90 DEG BENDS TO FACILITATE A FUTURE TV POWER SUPPLY. PROVIDE THE CONDUITS WITH A SPARE DRAW WIRE.		
A5	CONDUIT ACCESS A5	PROVIDE A CONCEALED 32 DIA POWER CONDUIT AND A 25 DIA COMMUNICATIONS CONDUIT FROM FLUSH FLOOR DRAW IN BOXES TO THE LOCAL EV CHARGING DB WITH AN ACCESSIBLE DRAW IN BOX EVERY 40M AND OR EVERY 3 X 90 DEG BENDS TO FACILITATE A FUTURE EV CHARGER POWER SUPPLY. PROVIDE THE CONDUITS WITH A SPARE DRAW WIRE.		
A6	CONDUIT ACCESS A6	PROVIDE A CONCEALED 32 DIA POWER CONDUIT FROM A FLUSH WALL DRAW IN BOX TO CR-C TO FACILITATE A FUTURE DURESS BUTTUN. PROVIDE THE CONDUIT WITH A SPARE DRAW WIRE.		
HORN SPEAKER		PROVIDE A 30W 100VOLT MULTI TAP IP66 HORN SPEAKER ON THE CEILING OR ON THE ADJACENT POLE AT 3,000AFFL. PROVIDE THE HORN WITH AN ADJUSTABLE MOUNTING BRACKET. CONNECT EACH HORN VIA A CONCEALED DEDICATED CABLE TO THE PA AMPLIFIER IN CR-C.		

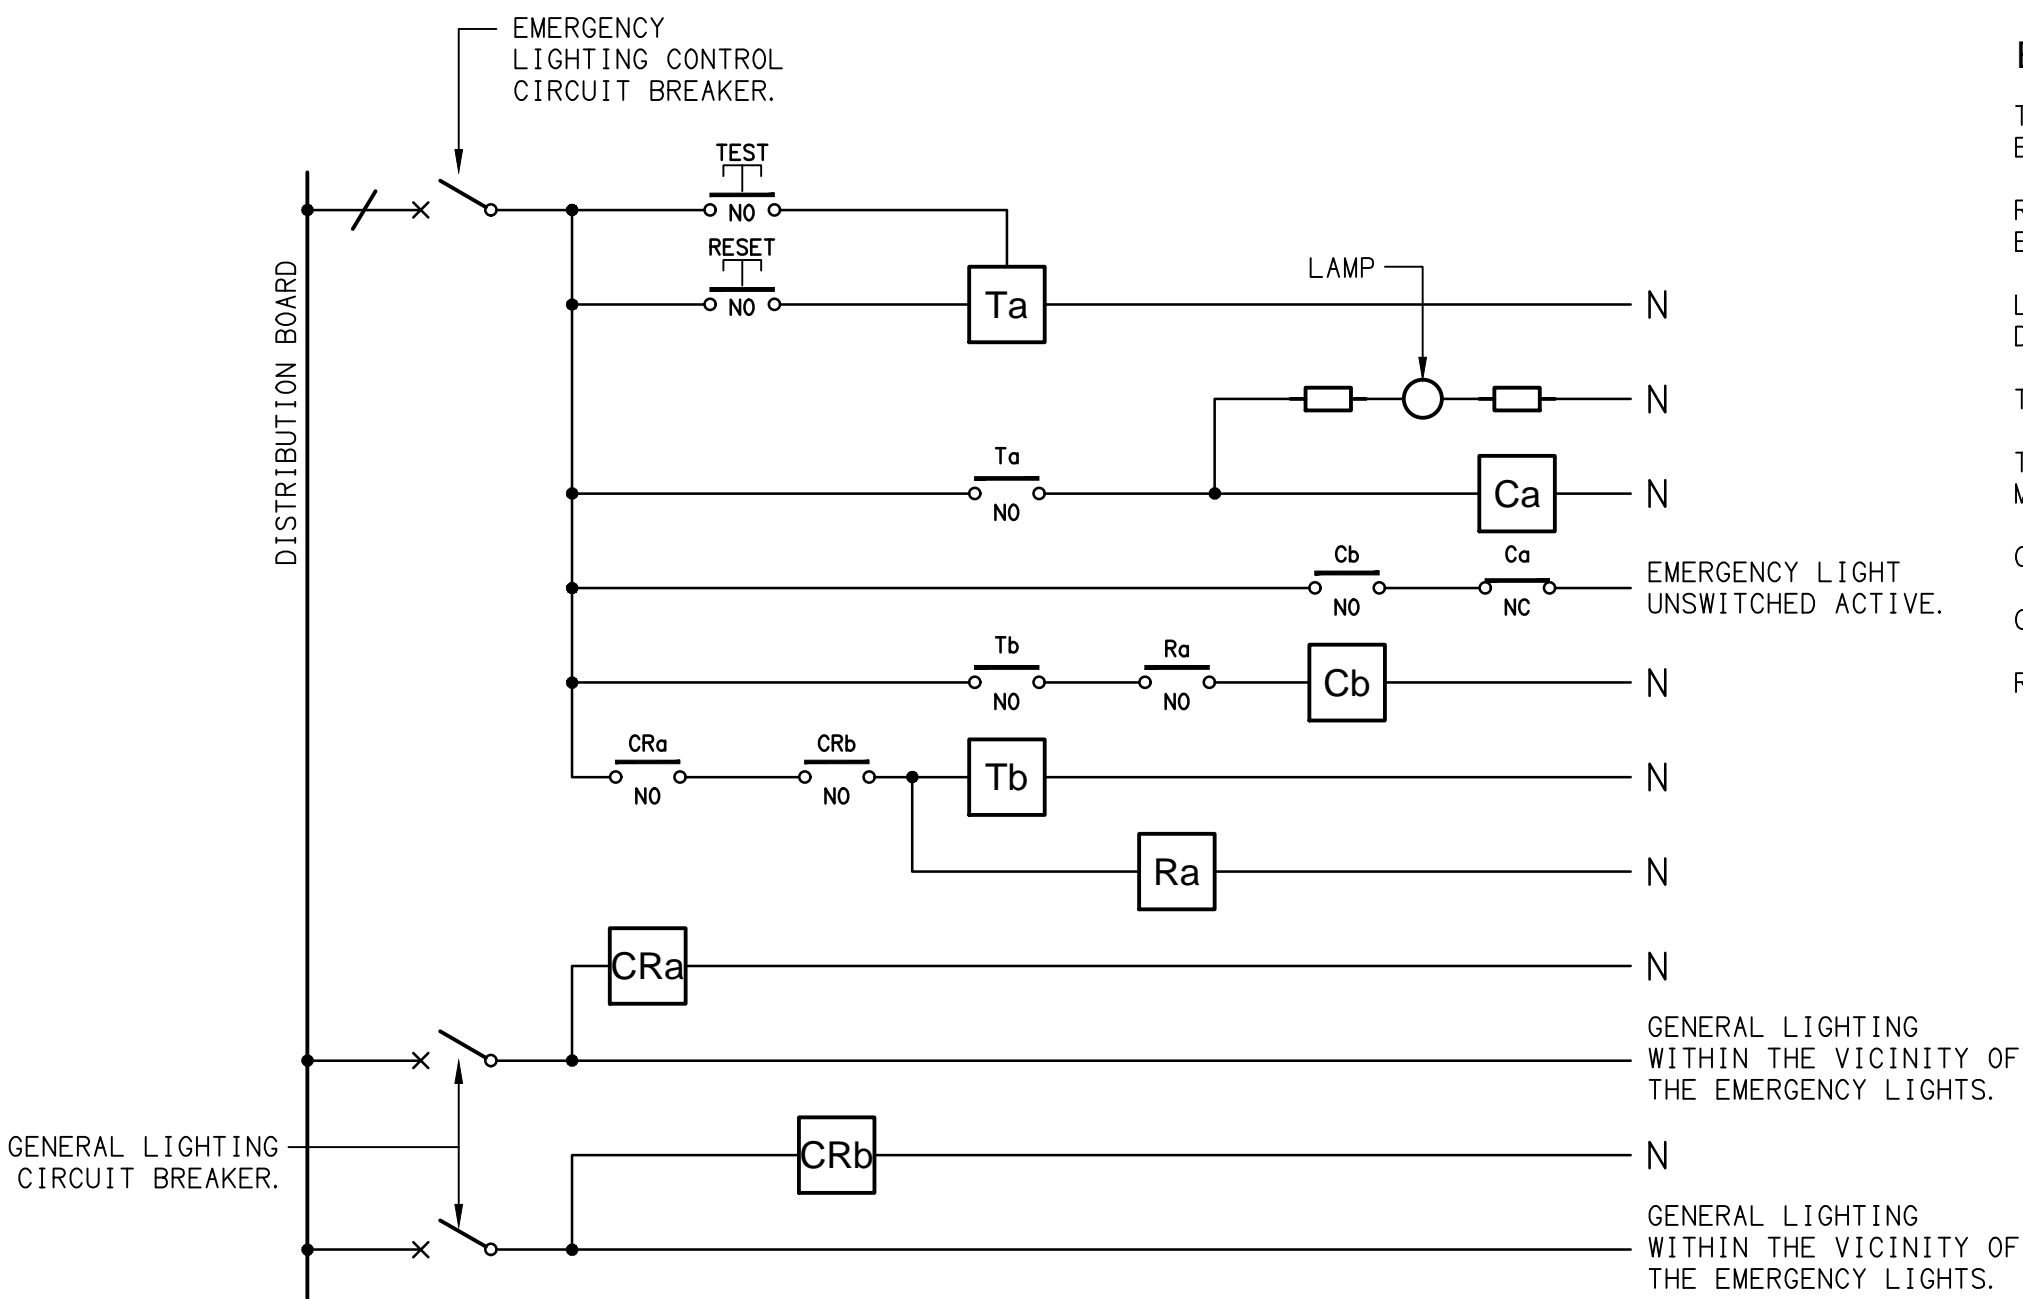

EQUIPMENT:

TEST - TEST PUSH BUTTON MOUNTED ON THE DISTRIBUTION BOARD ESCUTCHEON.

RESET - RESET PUSH BUTTON MOUNTED ON THE DISTRIBUTION BOARD ESCUTCHEON.

LAMP - AMBER TEST INDICATING LAMP MOUNTED ON THE DISTRIBUTION BOARD ESCUTCHEON.

Ta - ADJUSTABLE 0-3 HOUR TIMED RELAY.

Tb - 15 MINUTE RUN-ON TIMER TO OPERATE UPON THE RETURN OF MAINS POWER.

Cx - CONTACTOR x.

CRx - CONTROL RELAY x.

Rx - RELAY x.

LEGEND


TYPE	DESCRIPTION	COLOUR / ACCESSORY	CATALOGUE No
E1	EMERGENCY LIGHT: RECESSED NON-MAINTAINED EMERGENCY LIGHT. AS2293 CLASSIFICATION C0-D40 - C90-D40.	WHITE	CLEVERTRONICS CLIFE
E2	EMERGENCY LIGHT: SURFACE MOUNTED NON-MAINTAINED EMERGENCY LIGHT. AS2293 CLASSIFICATION C0-D40 - C90-D40.	WHITE	CLEVERTRONICS CLIFE-SM

NOTES

1. THE EMERGENCY LIGHT UNSWITCHED ACTIVE / GENERAL LIGHTING SWITCHED ACTIVE CIRCUIT ARRANGEMENT AND CONTROL IS TYPICAL FOR ALL CIRCUITS SUPPLYING EMERGENCY LIGHTS.
2. PROVIDE ADDITIONAL CONTROL RELAYS (CRx) CONFIGURED AS PER CRa AND CRb FOR ALL ADDITIONAL LIGHTING CIRCUITS THAT SUPPLY LIGHTS IN THE VICINITY OF THE EMERGENCY LIGHTS.

SCHEMATIC

EMERGENCY LIGHTING
NOT TO SCALE

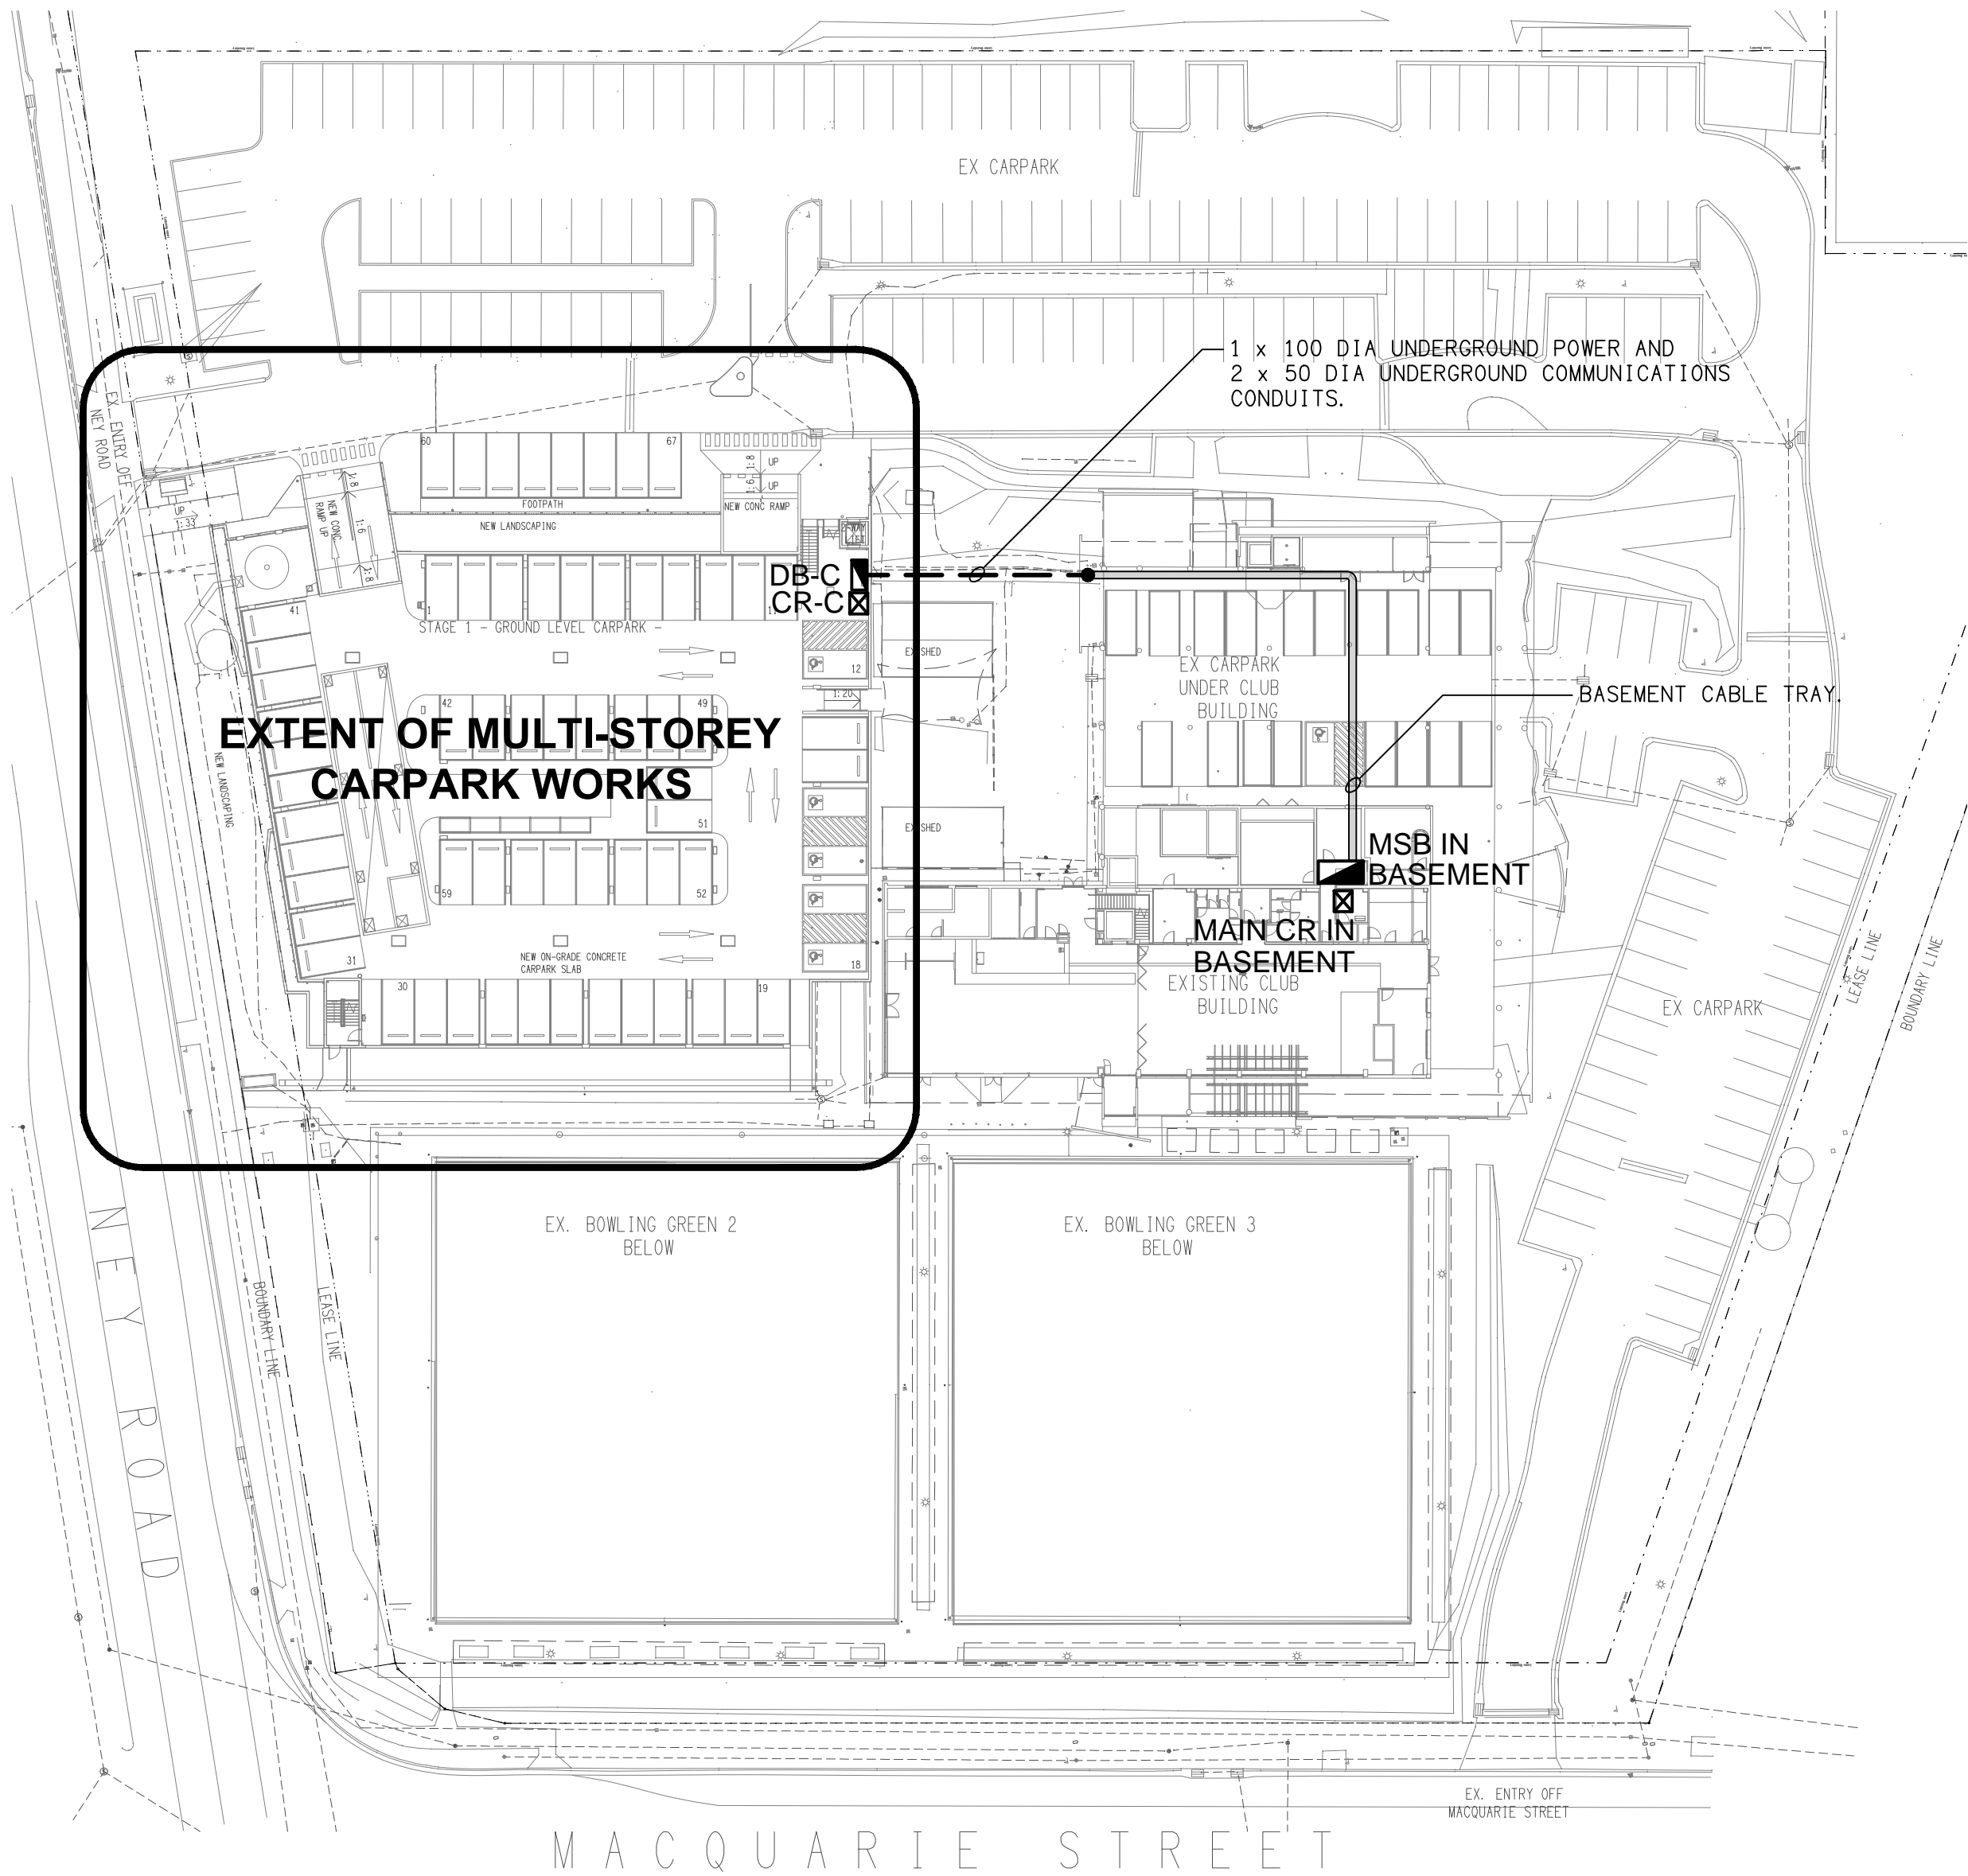

SITE PLAN

EXTENT OF MULTI-STOREY CARPARK WORKS
SCALE 1:500

THE COPYRIGHT OF THIS DRAWING REMAINS THE PROPERTY OF THE ELECTRICAL DESIGN GROUP.

USE FIGURED DIMENSIONS IN PREFERENCE TO SCALE.

ALL DIMENSIONS TO BE VERIFIED ONSITE.

H	CONSTRUCTION	30/09/2025
REV:	DESCRIPTION:	DATE:

ELECTRICAL DESIGN GROUP
ELECTRICAL BUILDING SERVICES CONSULTANTS

BRISBANE: P.O. Box 15 Sherwood Qld 4075
Phone: (07) 3278 4375
Email: brisbane@edg.net.au
Web: www.edg.net.au

ELECTRICAL DESIGN GROUP BRISBANE PTY LTD
ACN 092 710 793

TRADING AS:
ELECTRICAL DESIGN GROUP

PROJECT:

**CAPALABA SPORTS CLUB
MULTI-STOREY CARPARK**

SITE ADDRESS:

113 NEY ROAD, CAPALABA

SCALE: SHEET SIZE:

1:500 UNO AT A1

DRAWING TITLE:

**ELECTRICAL SERVICES
LEGEND & SITE PLAN**


PROJECT NO: DRAWING NO: REVISION:

C3455a E01 H

THE COPYRIGHT OF THIS DRAWING REMAINS THE PROPERTY OF THE ELECTRICAL DESIGN GROUP.

USE FIGURED DIMENSIONS IN PREFERENCE TO SCALE.

ALL DIMENSIONS TO BE VERIFIED ONSITE.

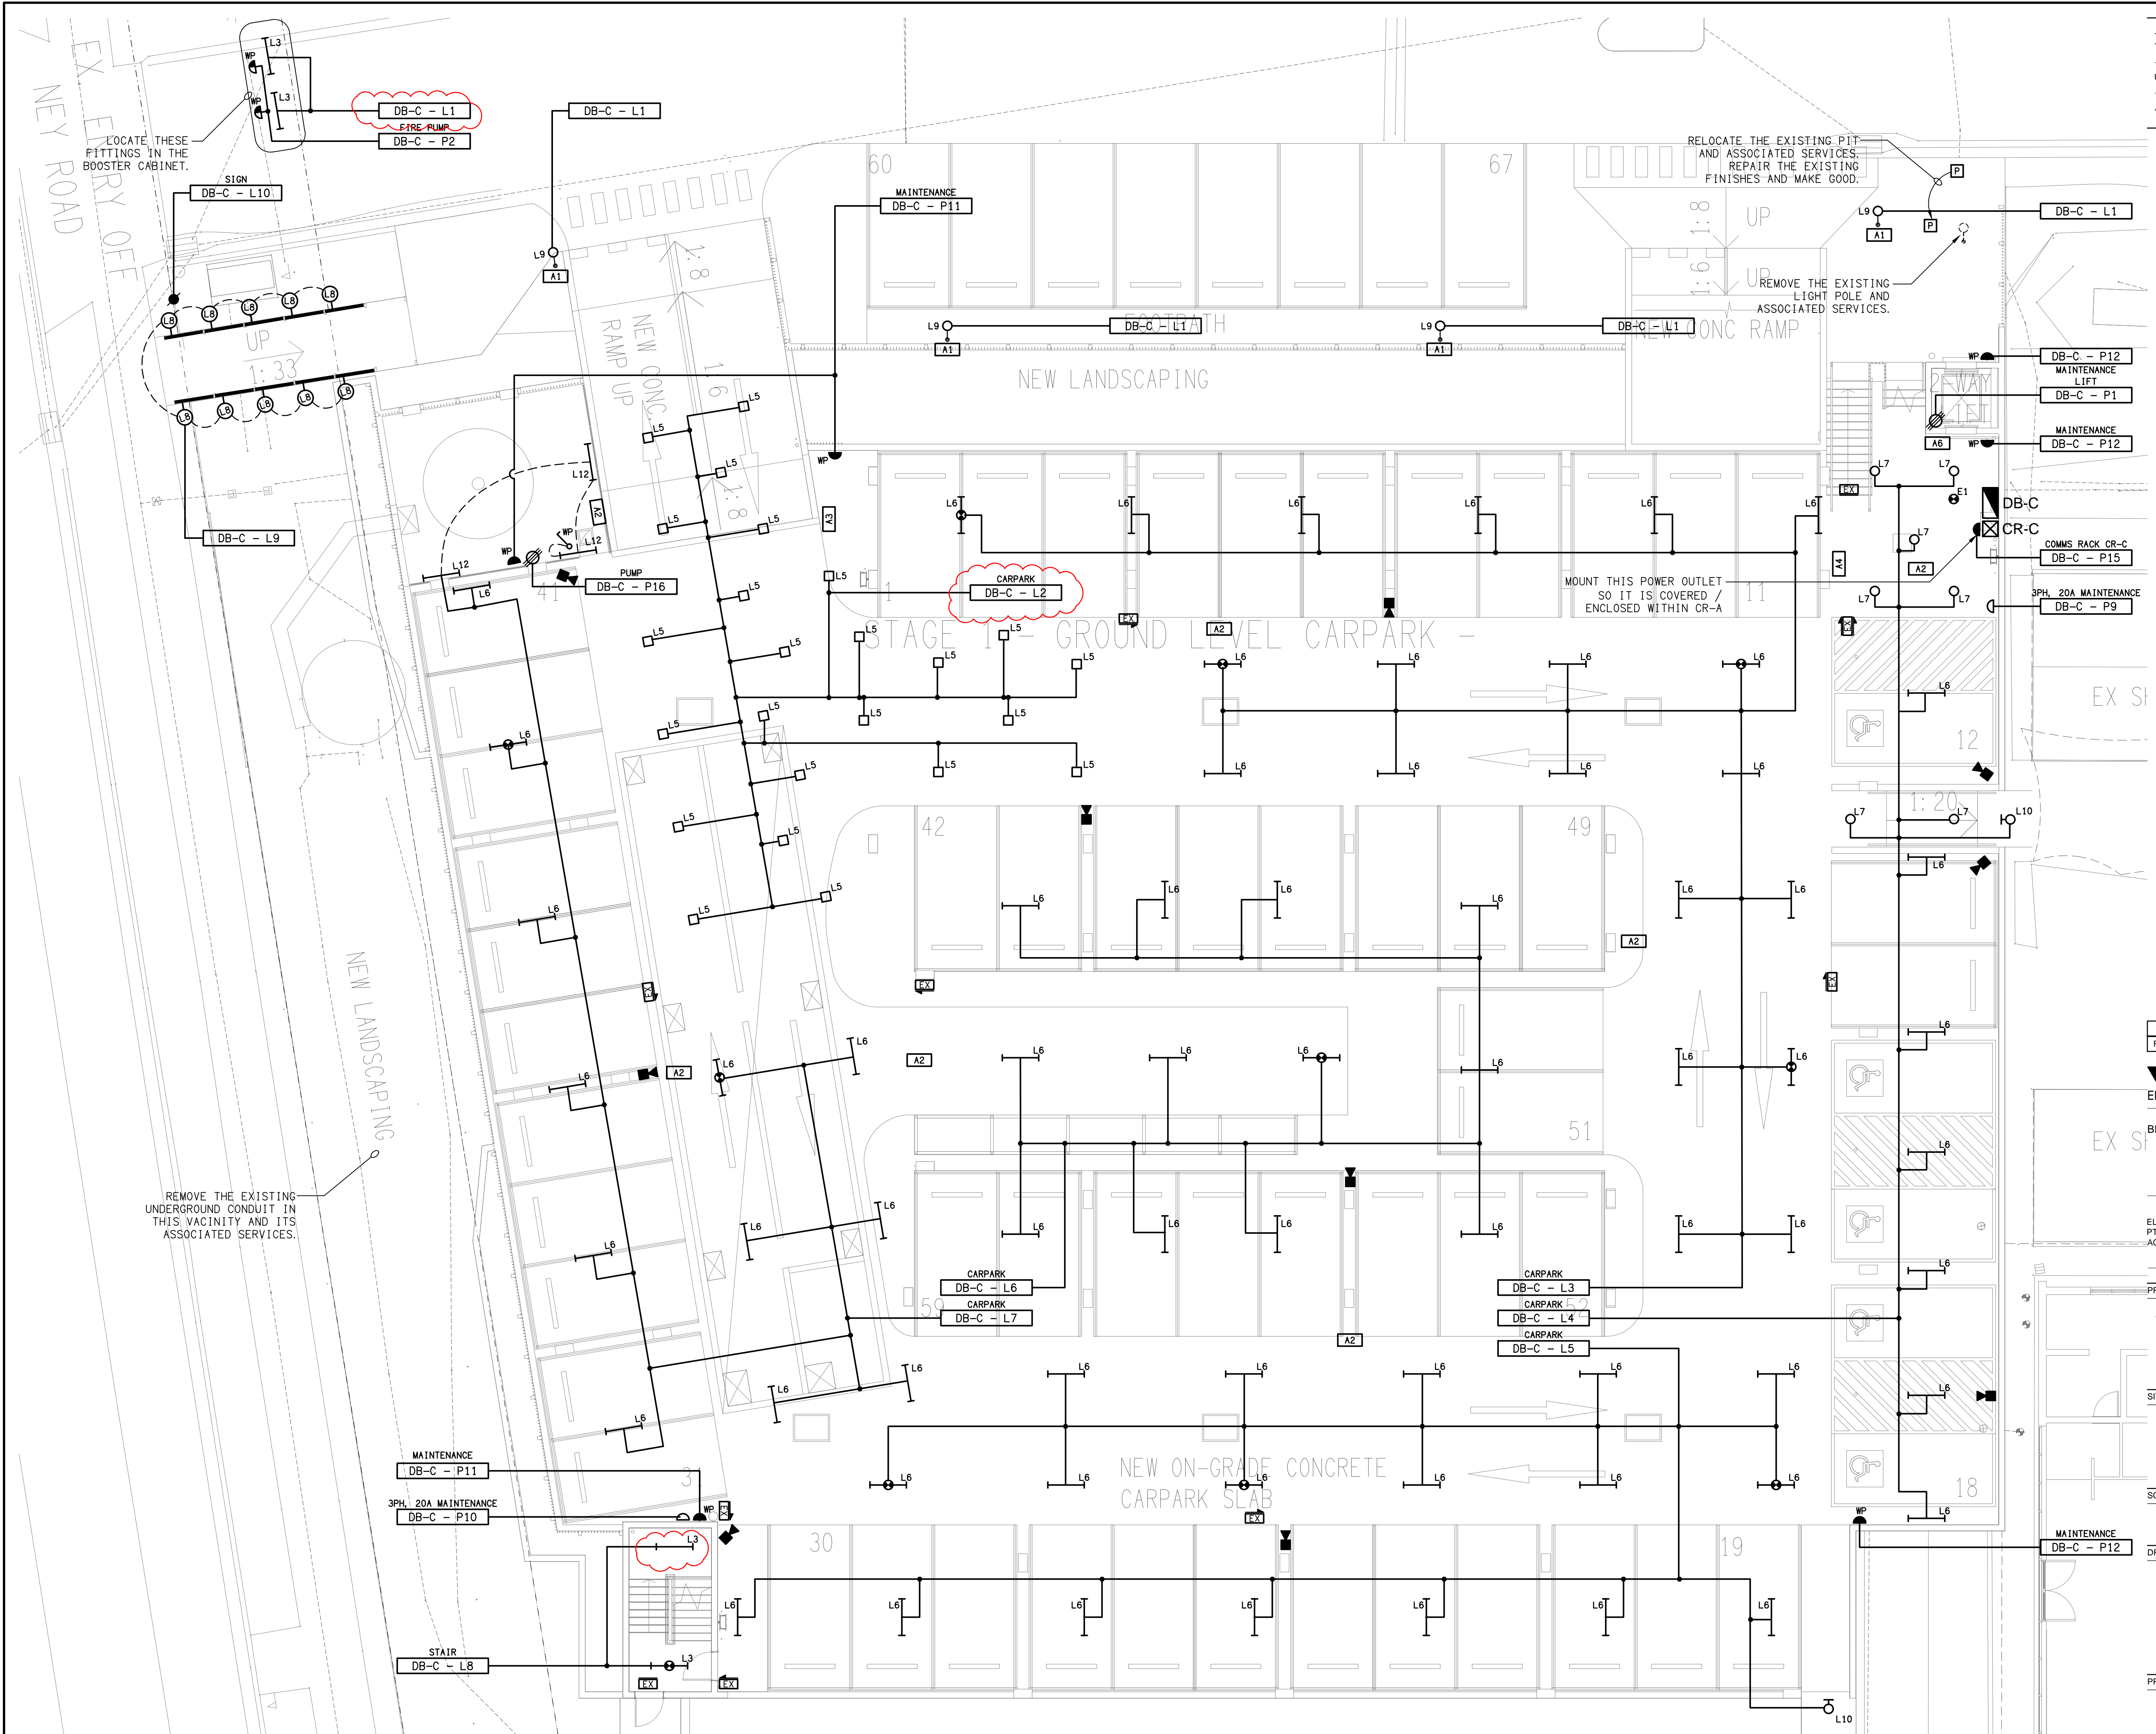

H	CONSTRUCTION	30/09/2025
REV:	DESCRIPTION:	DATE:

ELECTRICAL DESIGN GROUP
ELECTRICAL BUILDING SERVICES CONSULTANTS

BRISBANE: P.O. Box 15 Sherwood Qld 4075
Phone: (07) 3278 4375
Email: brisbane@edg.net.au
Web: www.edg.net.au

ELECTRICAL DESIGN GROUP BRISBANE PTY LTD
ACN 092 710 793

PROJECT:
**CAPALABA SPORTS CLUB
MULTI-STOREY CARPARK**

SITE ADDRESS:
113 NEY ROAD, CAPALABA

SCALE: 1:100 UNO
SHEET SIZE: AT A1

DRAWING TITLE:
**ELECTRICAL SERVICES
GROUND LEVEL PLAN**

PROJECT NO: DRAWING NO: REVISION:

C3455a E02 H

ALL DIMENSIONS TO BE VERIFIED ONSITE.



NOTES

1. EXTENT OF WORKS

THE ELECTRICAL SERVICES SUB-CONTRACT INCLUDES BUT IS NOT LIMITED TO THE FOLLOWING:

- SUPPLY AND INSTALLATION OF ALL COMPONENTS FORMING PART OF THE ELECTRICAL SERVICES.
- CO-ORDINATION.
- INSPECTIONS.
- TESTING AND COMMISSIONING.
- MAINTENANCE.
- CABLING, CABLE SUPPORT SYSTEMS AND ACCESS.
- POWER DISTRIBUTION.
- LIGHTING.
- COMMUNICATIONS CABLING.
- PUBLIC ADDRESS.
- CABLE ACCESS.
- ALL MINOR COMPONENTS AND INCIDENTAL WORKS NOT SPECIFICALLY REFERRED TO, HOWEVER NECESSARY TO COMPLETE THE ELECTRICAL SERVICES INSTALLATION SUCH THAT IT IS HANDED OVER COMPLETE, OPERATIONAL AND FIT FOR THE INTENDED USE.

PRIOR TO COMMENCING WORK CONSULT SITE MANAGEMENT FOR ANY HAZARDOUS MATERIAL AND OR ASBESTOS REGISTERS AS WELL AS UNDERTAKE A THOROUGH INSPECTION OF THE SITE TO IDENTIFY ANY POTENTIAL HAZARDOUS MATERIALS, ASBESTOS AND HEALTH OR SAFETY RISKS. ADVISE THE CONTRACTOR OF ANY POTENTIAL HAZARDOUS MATERIALS, ASBESTOS AND HEALTH OR SAFETY RISKS IF IDENTIFIED AND DO NOT COMMENCE WORK UNTIL AN APPROPRIATE MANAGEMENT PLAN HAS BEEN DEVELOPED AND AGREED TO BY ALL PARTIES.

SUPPLY ALL LABOUR, MATERIALS, EQUIPMENT, AND ALL OTHER ITEMS, WHETHER MENTIONED IN DETAIL OR NOT, REQUIRED FOR THE SATISFACTORY COMPLETION OF THE ELECTRICAL SERVICES INSTALLATION, LEAVING IN FULL WORKING ORDER TO THE SATISFACTION OF THE PROJECT MANAGER.

ACCEPT FULL RESPONSIBILITY FOR LIASING, ARRANGING AND CO-ORDINATION ALL WORKS THAT HAVE AN EFFECT ON OR WILL BE AFFECTED BY THE ELECTRICAL SERVICES.

RELOCATE ALL EXISTING ELECTRICAL SERVICES THAT ARE IN HE AREA OF THE WORKS THAT NEED TO REMAIN. REMOVE ALL OF THE EXISTING ELECTRICAL SERVICES THAT BECOME REDUNDANT DUE TO THE WORKS.

2. WORKMANSHIP

ENSURE THAT THE WORK IS PERFORMED BY THE HOLDER OF A CURRENT ELECTRICAL SUB CONTRACTOR LICENSE. ENSURE THE INSTALLATION AND ALL COMPONENTS, FIXTURES, FITTINGS, OUTLETS AND CABLES ARE SUPPLIED AND INSTALLED TO A HIGH STANDARD THROUGHOUT, AND INSTALLED IN A NEAT AND TRADESMAN LIKE MANNER, TO THE CURRENT INDUSTRY STANDARDS. ENSURE ALL MATERIALS AND COMPONENTS OF A SIMILAR TYPE ARE OF THE SAME MANUFACTURER AND INSTALLED IN A UNIFORM MANNER.

IT IS THE ELECTRICAL SUB CONTRACTOR'S RESPONSIBILITY TO ENSURE THAT THE INSTALLATION IS FIT FOR PURPOSE AND IS PROVIDED AS A COMPLETE WORKING INSTALLATION. IT IS THE ELECTRICAL SUB CONTRACTOR'S RESPONSIBILITY TO PROVIDE ALL COMPONENTS, FITTINGS, FIXTURES, SYSTEMS, PROGRAMMING ETC IRRESPECTIVE OF THE LEVEL DETAILED IN THE DOCUMENTS SUCH THAT THE INSTALLATION IS PROVIDED AS A COMPLETE WORKING INSTALLATION.

CONCEAL ALL WIRING AND CONDUITS. EXPOSED CABLING OR CONDUITS ARE NOT ACCEPTABLE. ENSURE ALL COMPONENTS, EQUIPMENT AND MATERIALS SUPPLIED ARE NEW, UNUSED, DESIGNED AND SELECTED TO ENSURE SATISFACTORY OPERATION UNDER VARYING ATMOSPHERIC, CLIMATIC, HUMID TROPICAL CONDITIONS WITHOUT DISTORTION AND DETERIORATION IN ANY PART AFFECTING EFFICIENCY AND RELIABILITY OF THE SYSTEMS. DESIGN AND SELECT ALL EQUIPMENT TO PROVIDE THE NECESSARY SAFETY TO HUMAN LIFE AND PROPERTY DURING OPERATION AND MAINTENANCE WITH PARTICULAR ATTENTION GIVEN TO ELECTRICAL SAFETY AND SEGREGATION PRECAUTIONS.

CHECK THE FINISHED PAINTWORK AROUND THE AREA OF EACH INSTALLATION AND TOUCH UP ALL DAMAGED PARTS AND FINISHES AFTER THE INSTALLATION OF THE ELECTRICAL SERVICES.

ALL WORKS ARE TO BE CARRIED OUT IN ACCORDANCE WITH THE BUILDER'S PROGRAM. ENSURE ALL FINAL LOCATIONS OF OUTLETS AND FITTINGS ARE CO-ORDINATED ONSITE WITH THE ARCHITECT AND ALL OTHER SERVICES, TO THE APPROVAL OF THE PROJECT MANAGER. ALLOW TO CO-ORDINATE THE FINAL LOCATION OF ALL EQUIPMENT, FITTINGS, & OUTLETS, SUCH THAT THEY ARE INSTALLED IN ACCORDANCE WITH THE AS3000 RESTRICTED ZONES, AND ARE NOT COVERED INAPPROPRIATELY.

ENSURE THAT ALL METAL SURFACES ARE SUITABLY PROTECTED AGAINST CORROSION, AND THAT ALL PLASTIC MATERIALS ARE UV STABILISED.

PROVIDE ALL MATERIALS AS NEW, AND OF THE HIGHEST CLASS AVAILABLE FOR THEIR RESPECTIVE TYPES. ENSURE ALL ASPECTS OF THE WORK ARE OF A HIGH STANDARD THROUGHOUT, AND INSTALLED IN A NEAT AND TRADESMAN LIKE MANNER, TO THE CURRENT INDUSTRY STANDARDS.

3. STANDARDS

IRRESPECTIVE OF INFORMATION CONTAINED IN THE ELECTRICAL SERVICES DOCUMENTS OR IN INSTRUCTIONS, IT IS THE ELECTRICAL SUB CONTRACTOR'S RESPONSIBILITY TO ENSURE ALL ELECTRICAL SERVICES WORKS ARE INSTALLED IN ACCORDANCE WITH THE REQUIREMENTS OF THE FOLLOWING. REFER ANY DISCREPANCIES BETWEEN THE REQUIREMENTS OF THE FOLLOWING AND/OR THE ELECTRICAL SERVICES DOCUMENTS AND INSTRUCTIONS TO THE ARCHITECT FOR CLARIFICATION PRIOR TO THE PLACING OF ORDERS, FABRICATION OR INSTALLATION OF THE ITEMS/METHODS IN DISCREPANCY.

- NCC BUILDING CODE OF AUSTRALIA.
- ELECTRICITY ACT.
- ELECTRICAL SAFETY ACT.
- AS/NZS3000.
- AS3008.
- WORKPLACE HEALTH AND SAFETY ACT.
- TELECOMMUNICATIONS ACT.
- ACMA REQUIREMENTS.

4. AUTHORITIES

ENSURE ALL OF THE ELECTRICAL SERVICES COMPLY WITH THE REQUIREMENTS OF ALL REGULATORY AUTHORITIES HAVING JURISDICTION OVER THE SITE INCLUDING BUT NOT LIMITED TO THE FOLLOWING:

- ACMA.
- LOCAL COUNCIL.
- LOCAL SUPPLY AUTHORITY.
- STATE GOVERNMENT DEPARTMENT OF ENVIRONMENT AND HERITAGE.
- QLD GOVERNMENT, DIVISION OF WORKPLACE, HEALTH AND SAFETY.
- QLD FIRE AND RESCUE AUTHORITY.

5. CABLES

UNLESS OTHERWISE SPECIFIED, INSTALL AND TERMINATE CABLES IN ACCORDANCE WITH THE MANUFACTURERS' RECOMMENDATIONS. DETERMINE THE FINAL ROUTES TO SUIT THE BUILDING STRUCTURE AND SITE CONDITIONS. UNLESS NOTED OTHERWISE, PROVIDE ALL 240 VOLT POWER AND LIGHTING WIRING AS 2.5mm² TWIN & EARTH STRANDED COPPER CONDUCTORS, PVC INSULATED 0.6/1kv V75 GRADE TO AS3174, PROTECTED BY A 20 AMP CIRCUIT BREAKER. ALL CONDUIT AND FITTINGS TO BE RIGID UPVC TO AS2053, UNLESS NOTED OTHERWISE.

NOTES

6. POWER DISTRIBUTION

THE POWER DISTRIBUTION COMPONENT OF THIS CONTRACT INCLUDES PROVIDING A NEW DISTRIBUTION BOARD DB-C TO ACCOMMODATE THE NEW CARPARK CIRCUITS. PROVIDE A NEW 160 AMP MCCB IN THE MSB TO SUPPLY DB-C VIA A NEW 40+E 70MM CU XLPE/PVC SUBMAIN. THE POWER DISTRIBUTION COMPONENT OF THIS CONTRACT INCLUDES, BUT IS NOT LIMITED TO THE FOLLOWING EXTENT OF WORK:

- POWER DISTRIBUTION.
- MSB MCCB AND UPDATED LABELLING.
- DISTRIBUTION BOARD DB-C AND A WEATHERPROOF HAT SECTION.
- DB-C SUBMAIN.
- ELECTRIC VEHICLE CHARGING DISTRIBUTION BOARDS EV-4 AND EV-5.
- EARTHING.
- REMOVAL OF EXISTING REDUNDANT CIRCUITS.
- CIRCUITS.
- ISOLATORS AND OUTLETS.
- TESTING AND COMMISSIONING.
- PROVIDE THE SPARE CONDUITS AS NOTED.

PROVIDE THE DISTRIBUTION BOARDS AS FOLLOWS:

- WALL MOUNTED.
- IP66 FORM 1.
- LIGHT GREY ENCLOSURE WHITE ESCUTCHEON.
- 3 POINT 92268 KEY LOCKABLE FLUSH HANDLES ON ALL DOORS.
- LIFT OFF HINGES ON ALL DOORS AND ESCUTCHEONS.
- 1/4 TURN LATCHES AND D HANDLES ON ALL ESCUTCHEONS.
- ALL SWITCHGEAR TO BE SCHNEIDER OR NHP/ TERASAKI.
- PROVIDE SHOP DRAWINGS FOR APPROVAL.
- ALL COMPONENTS ARE TO BE LABELLED WITH NON-STICK LABELS.

REFER TO THE DISTRIBUTION BOARD DB-C SCHEDULE FOR ADDITIONAL DB-C REQUIREMENTS AND DETAILS OF THE DB-C CIRCUITS.

PROVIDE THE DB-C WITH AN REMOVABLE HAT SECTION THE FULL WIDTH AND DEPTH OF DB-C FROM THE TOP OF THE SWITCHBOARD TO THE CEILING ABOVE AND FROM THE BOTTOM OF THE SWITCHBOARD TO THE FLOOR TO COVER THE ASSOCIATED CONDUITS. PROVIDE THE HAT SECTION WITH SUPPORT AND OR STIFFING OS IT DOES NOT FLEX IF CASUALLY TOUCHED.

PROVIDE THE EV CHARGING DISTRIBUTION BOARDS WITH THE FOLLOWING ADDITIONAL REQUIREMENTS:

- FULL WIDTH SPARE DIN RAIL.
- 100 AMP THREE PHASE.
- 30 POLE.
- 100 AMP LOAD BREAK NON AUTO MAIN SWITCH.
- LABEL THE DIN RAIL SPACE "FUTURE INSTALLATION OF METERING EQUIPMENT".

PROVIDE AN ELECTRIC VEHICLE CHARGING CONTROL SYSTEM AS PER J9D4 OF THE NCC BCA 2022 THAT HAS THE ABILITY TO MANAGE AND SCHEDULE CHARGING OF ELECTRIC VEHICLES IN RESPONSE TO TOTAL DEMAND OF THE DB-C SUPPLY.

SUBMIT DETAILS OF THE ELECTRIC VEHICLE CHARGING CONTROL SYSTEM FOR APPROVAL.

INTERFACE THE ELECTRIC VEHICLE CHARGING CONTROL SYSTEM TO EACH OF THE EV CHARGING DISTRIBUTION BOARDS.

ENSURE THAT POWER IS MAINTAINED TO THE REMAINING PARTS OF THE SITE THAT ARE NOT PART OF THE WORKS BETWEEN 8.00AM AND 2.00AM. ANY INTERRUPTIONS TO THE POWER SUPPLY MUST BE LIMITED TO LESS THAN FOUR HOURS AND THE CLUB MUST BE PROVIDED WITH TWO WEEKS NOTICE PRIOR TO THE INTERRUPTION.

7. LIGHTING

THE LIGHTING INSTALLATION IS TO BE DALI DIMMABLE AND ALL SIGNAGE IS SWITCHED VIA AN EXTENSION OF THE CLUBS EXISTING PHILIPS DYNALITE LIGHTING CONTROL SYSTEM. THE DYNALITE CONTROLLERS ARE TO BE DIN RAIL MOUNTED WITHIN DB-A. PROVIDE THE CARPARK WITH A PHILIPS DYNALITE LIGHT LEVEL SENSOR TO AUTOMATICALLY CONTROL THE CARPARK ENTRY LIGHTS IN ACCORDANCE WITH AS 1680. CONFIGURE THE OPERATION OF THE REMAINING CARPARK LIGHTING AS DIRECTED ON SITE BY THE SUPERINTENDENT. PHASE CUT DIMMING AND DALI TO PHASE CUT CONVERTERS ARE NOT ACCEPTABLE.

ALL OF THE LIGHT FITTINGS, LAMPS AND ACCESSORIES ARE TO BE PROVIDED AS PART OF THIS CONTRACT. THE LIGHTING COMPONENT OF THIS CONTRACT INCLUDES, BUT IS NOT LIMITED TO THE FOLLOWING EXTENT OF WORK:

- LIGHTING.
- LIGHT FITTINGS AND ACCESSORIES.
- EARTHING OF THE LIGHTING INSTALLATION.
- PHILIPS DYNALITE LIGHTING CONTROL.
- LIGHTING SUBCIRCUITS.
- TESTING AND COMMISSIONING.

PROVIDE A SINGLE POINT EMERGENCY LIGHTING SYSTEM THAT COMPLIES WITH THE LATEST ISSUE OF ALL PARTS AS2293 AND THE RELEVANT PARTS OF THE NCC BCA. INSTALL EMERGENCY LIGHT FITTINGS NOMINATED AS MAINTAINED WITH THE LAMP PERMANENTLY ON SUPPLIED VIA AN UNSWITCHED ACTIVE MAINS SUPPLY WHEN THE MAINS SUPPLY IS AVAILABLE. WHEN THE MAINS SUPPLY IS NOT AVAILABLE, THE LAMP IS TO REMAIN ON SUPPLIED BY THE EMERGENCY PACK. SINGLE LAMP MAINTAINED EMERGENCY LIGHTS ARE NOT SWITCHED WITH THE LOCAL GENERAL AREA LIGHTING. (THE LAMP IS ALWAYS ON.)

INSTALL EMERGENCY LIGHT FITTINGS NOMINATED AS NON-MAINTAINED AS FOLLOWS:

- IF THE FITTING IS NOT BEING SWITCHED, THE LAMP IS TO REMAIN OFF WHEN THE MAINS SUPPLY IS AVAILABLE. WHEN THE MAINS SUPPLY IS NOT AVAILABLE THE LAMP IS TO BE SWITCHED ON SUPPLIED BY THE EMERGENCY PACK. UNSWITCHED SINGLE LAMP NON-MAINTAINED EMERGENCY LIGHTS ARE NOT SWITCHED WITH THE LOCAL GENERAL AREA LIGHTING. (THE LAMP IS ON ONLY WHEN THE MAINS SUPPLY IS NOT AVAILABLE.)
- IF THE FITTING IS BEING SWITCHED, THE LAMP IS TO BE SUPPLIED AND CONTROLLED WITH THE LOCAL GENERAL AREA LIGHTING WHEN THE MAINS SUPPLY IS AVAILABLE. WHEN THE MAINS SUPPLY IS NOT AVAILABLE THE LAMP IS TO BE SWITCHED ON, SUPPLIED BY THE EMERGENCY PACK. (THE LAMP IS ON WHEN TURNED ON WITH THE LOCAL GENERAL LIGHTING OR THE MAIN SUPPLY IS NOT AVAILABLE.)

INSTALL EMERGENCY LIGHTS SUCH THAT THE STATUS INDICATOR L.E.D. IS CLEARLY VISIBLE AND THE TEST BUTTONS ARE READILY ACCESSIBLE. LABEL EACH CIRCUIT BREAKER WHICH CONTROLS THE UNSWITCHED ACTIVE TO EXIT LIGHTS WITH A LABEL FIXED ADJACENT; ENGRAVED PLASTIC LAMINATE, GREEN BACKGROUND WITH WHITE CHARACTERS: -

WARNING
INTERRUPTING SUPPLY WILL DISCHARGE
EMERGENCY LIGHTING BATTERIES

PROVIDE WRITTEN EVIDENCE OF THE INITIAL COMMISSIONING AND TESTING AND TESTING FOR THE DURATION OF THE MAINTENANCE PERIOD IN ACCORDANCE WITH AS 2293.2.

THIS EVIDENCE IS TO BE IN THE FORM OF A LOG BOOK SIMILAR TO THE GENERAL LIGHTING SERVICE PTY LTD "EMERGENCY LIGHTING MAINTENANCE LOG BOOK AND MANUAL" WHICH IS TO BE PROVIDED BY THE ELECTRICAL SUB-CONTRACTOR AND HAVE ALL ENTRIES FULLY COMPLETED AND BE PRESENTED FOR INSPECTION AT PRACTICAL COMPLETION. THE LOG BOOK IS TO BE RETAINED BY THE ELECTRICAL SUB-CONTRACTOR FOR THE DURATION OF THE MAINTENANCE PERIOD, AND THE SIX MONTHLY TEST AND MAINTENANCE RESULTS ENTERED. THE LOG BOOK IS TO BE PRESENTED FOR APPROVAL AT FINAL COMPLETION (EXPIRY OF THE MAINTENANCE PERIOD) AND WILL BE FORWARDED TO THE OPERATOR FOR THEIR USE.

PROVIDE MAINTENANCE OF THE EMERGENCY AND EXIT LIGHTING INSTALLATION INCLUDING RECORDS IN ACCORDANCE WITH THE LATEST ISSUE OF ALL PARTS AS2293 AND THE RELEVANT PARTS OF THE NCC BCA. PROVIDE THE EMERGENCY LIGHTING SYSTEM WITH A SUPPLY SENSING AND TESTING FACILITY MOUNTED IN DB-3 IN ACCORDANCE WITH AS 2293.1.

NOTES

8. LIGHT POLES

PROVIDE POLES WITH A TAMPER RESISTANT ACCESS PANEL WITHIN THE POLE BASE AND BASE PLATE THAT INCORPORATE A MINIMUM OF FOUR HOLD DOWN BOLTS. PROVIDE POLES AND INSITU CONCRETE FOOTINGS DESIGNED SPECIFICALLY TO SUIT THE LOCAL CONDITIONS AND BE ABLE TO WITHSTAND WIND GUSTS OF 150KM/H. THE DESIGN OF THE POLE AND THE FOOTING IS TO BE UNDERTAKEN BY A RESISTED STRUCTURAL ENGINEER. PROVIDE A CERTIFICATE FROM THE STRUCTURAL ENGINEER INDICATING THE POLES AND FOOTINGS MEET THE SPECIFIED DESIGN CRITERIA. PROVIDE DETAILED DRAWINGS OF ALL POLES AND FOOTINGS FOR APPROVAL. PROVIDE A FUSED CONNECTION WITHIN EACH POLE LOCATED BEHIND THE POLE BASE ACCESS PANEL. CONNECT THE POLE TO THE ELECTRICAL EARTH VIA A LUG FIXED TO A STUD WELDED TO THE POLE LOCATED WITHIN THE POLE LOCATED BEHIND THE POLE BASE ACCESS PANEL. TRIM THE HOLD DOWN BOLTS SUCH THAT THEY DO NOT PROTRUDE MORE THAN 15MM ABOVE THE NUT. TREAT THE TRIMMED HOLD DOWN BOLT AGAINST CORROSION AND ENSURE IT DOES NOT CONTAIN SHARP EDGES THAT REPRESENT A HAZARD. ENSURE THE BASE PLATE IS BETWEEN 50 AND 100MM ABOVE THE FINISHED LANDSCAPE LEVEL. PROVIDE A NEAT SMOOTH FINISHED CONCRETE GROUT FILL UNDER THE BASE PLATE ENSURING ANY SPLATTER IS IMMEDIATELY WASHED OFF THE BASE PLATE AND POLE. EXTEND THE CONDUIT INTO THE POLE 50MM ABOVE THE BASE PLATE.

PROVIDE POLES THAT COMPLY WITH AS/NZS 1170.0 STRUCTURAL DESIGN ACTIONS PART 0: GENERAL PRINCIPLES - IMPORTANCE LEVEL 1 WITH A DESIGN WORKING LIFE OF 50 YEARS.

DESIGN THE POLES TO A WIND LOADING AS PER AS/NZS 1170.0 STRUCTURAL DESIGN ACTIONS PART 0: GENERAL PRINCIPLES. THE FRACTION OF CRITICAL DAMPING IS TO BE TAKEN AS 0.05 (ULTIMATE) AND 0.01 (SERVICEABILITY) FOR POLES WITH MORE THAN TWO- (2) OVERLAPS AND 0.02 (ULTIMATE) AND 0.005 (SERVICEABILITY) FOR ALL OTHERS. THE NATURAL FREQUENCY OF THE POLE IS TO BE CALCULATED CONSIDERING VARYING DIAMETERS AND THICKNESS OVER THE HEIGHT OF THE POLE AND USING A 1.1 SAFETY FACTOR FOR THE MASS AT THE TOP OF THE POLE. ENSURE POLE DEFLECTION AT SERVICEABILITY WIND SPEEDS HAVE A DEFLECTION LESS THAN 6.7%.

ENSURE ALL WELDS ARE BY A CONTINUOUS AUTOMATIC GAS SHIELDED ELECTRIC ARC PROCESS COMPLYING WITH THE RELEVANT PARTS OF AS/NZS 1554 STRUCTURAL STEEL WELDING. ENSURE THE LONGITUDINAL SEAM WELDS ON POLE SECTIONS CONFORMS TO GP STANDARDS WHILE BASEPLATE AND SPIGOT WELDS MUST CONFORM TO SP STANDARDS AS MENTIONED IN AS/NZS 1554. WELD SIZES ARE TO BE VERIFIED BY A QUALIFIED STRUCTURAL ENGINEER AND SPECIFIED IN THE ENGINEERING REPORT AND ON WORKSHOP DRAWINGS.

PROVIDE ALL POLES WITH A GALVANISED FOUNDATION BOLT ASSEMBLY COMPLETE WITH POSITIONING TEMPLATE AND TWO- (2) NUTS AND WASHERS PER BOLT PROVIDED TO SUIT THE POLE BASEPLATE. FOUNDATION BOLTS MUST BE MANUFACTURED FROM DEFORMED REINFORCING BARS WITH A NOMINAL YIELD STRESS OF 500 MPA. PROVIDE BOLTS THREADED IN ACCORDANCE WITH AS1275-1985 METRIC SCREW THREADS F8.8 FASTENERS AND FITTED WITH CLASS 5 NUTS IN ACCORDANCE WITH AS/NZS 1112-150 METRIC HEXAGON NUTS. FOUNDATION BOLTS MUST BE TIED TO A SUITABLE REINFORCING CAGE. THE LENGTH OF EACH FOUNDATION BOLT MUST ALLOW FOR THE LENGTH OF THE THREAD ABOVE GROUND, A MINIMUM OF 100MM COVER AND A DEVELOPMENT LENGTH IN ACCORDANCE WITH AS3600-1994 CONCRETE STRUCTURES, TABLE 13.1.2.2(A). THE UNDERSIDE OF THE BASEPLATE IS TO BE GROUTED.

THE SECTION CAPACITY OF THE POLE IS TO BE ANALYSED OVER A MINIMUM OF 100 INCREMENTS ACCORDING TO AS4100 STEEL STRUCTURES AND AS/NZS 4600 COLD-FORMED STEEL STRUCTURES. LUMINARIES ARE TO BE ACCESSED BY EXTERNAL MACHINERY E.G. CHERRY PICKERS. CLIMBING RUNGS AND MAINTENANCE PLATFORMS ARE NOT REQUIRED.

THE POLE AND ALL STEEL ACCESSORIES ARE TO BE POWDER COATED BLACK HOT DIP GALVANIZED AFTER FABRICATION IN ACCORDANCE WITH AS/NZS 4680 HOT-DIP GALVANIZED (ZINC) COATINGS ON FABRICATED FERROUS ARTICLES.

THE POLES ARE TO BE SANDED AFTER GALVANIZING AND PREHEATED TO 220°C TO DRIVE OFF ANY TRAPPED GAS UNDER THE GALVANIZED SURFACE. A ZINC RICH PRIME COAT INTERPON POLYZINC 660 OR EQUIVALENT SHALL BE APPLIED TO WITHIN 60mm AND 80mm WITHIN FOUR HOURS OF PREHEATING AND GREEN CURED TO 200°C FOR 3 MINUTES. PRIME COAT SHALL BE LIGHTLY SANDED BEFORE APPLICATION OF TOP COAT. COLOUR TOPCOAT SHALL BE A RIPPLE, HIGH BUILD FINISH TO WITHIN 50µM AND 70µM. ENSURE ALL MANUFACTURING TOLERANCES ARE IN ACCORDANCE WITH AS 1798 LIGHTING POLES AND BRACKET ARMS PREFERRED DIMENSIONS. IN PARTICULAR THE POLES SHALL BE CHECKED FOR COMPLIANCE WITH THE STRAIGHTNESS REQUIREMENTS OF THIS STANDARD: 0.3% OF HEIGHT.

ASSEMBLY AND ERECTION ARE TO BE CARRIED OUT ONLY BY QUALIFIED RIGGING PERSONNEL. GROUT THE UNDERSIDE OF ALL POLE BASEPLATES WITHIN SEVEN- (7) DAYS OF INSTALLING THE POLE.

9. COMMUNICATIONS CABLING

THE COMMUNICATIONS CABLING COMPONENT OF THIS CONTRACT INCLUDES A NEW COMMUNICATIONS RACK CR-C CONNECTED TO THE CLUBHOUSES MAIN EXISTING COMMUNICATIONS RACK VIA A NEW GEL FILLED UNDERGROUND 12 CORE OM4 OPTICAL FIBRE CABLE WITH LC CONNECTORS. A NEW FIBOT IS TO BE PROVIDED IN THE CLUBHOUSES MAIN EXISTING COMMUNICATIONS RACK AND IN CR-C.

THE COMMUNICATIONS CABLING COMPONENT OF THIS CONTRACT INCLUDES, BUT IS NOT LIMITED TO THE FOLLOWING EXTENT OF WORK:

- COMMUNICATIONS RACK CR-C.
- FIBOTS.
- OM4 OPTICAL FIBRE CABLE.
- LABELLING.
- TESTING AND COMMISSIONING.
- PROVIDE THE SPARE CONDUIT AS NOTED.

PROVIDE CR-C IN ACCORDANCE WITH THE FOLLOWING:

- HINGED / SWING FRAME WALL MOUNTED.
- 24RU 600 DEEP.
- TWO VENTILATION FANS MOUNTED IN THE TOP PANEL.
- SOLID LOCKABLE DOOR AND SIDES.
- VENTILATED BASE THAT CAN ONLY BE REMOVED ONCE THE DOOR IS UNLOCKED.
- FRONT AND REAR VERTICAL MOUNTING RAILS.
- 2 No 8x10 AMP POWER RAILS MOUNTED ON THE REAR VERTICAL MOUNTING RAILS (ONE TOP AND ONE BOTTOM). CONNECT THE POWER RAILS TO THE DOUBLE GPO. ENSURE THE DOUBLE GPO ASSOCIATED WITH CR-A IS ENCLOSED WITHIN THE RACK WHEN IT IS CLOSED.
- PROVIDE THE RACK WITH AN REMOVABLE HAT SECTION 600 WIDE X 150 DEEP FROM THE TOP OF THE RACK TO THE CEILING ABOVE TO COVER THE ASSOCIATED COMMUNICATIONS CONDUITS.
- MOUNT CR-C AS HIGH AS PRACTICAL.
- PROVIDE SHOP DRAWINGS OR DETAILED BROCHURES OF CR-C AND ALL COMPONENTS FOR APPROVAL.

10. PUBLIC ADDRESS

THE PUBLIC ADDRESS COMPONENT OF THIS CONTRACT INCLUDES EXTENDING THE CLUBS EXISTING PUBLIC ADDRESS SYSTEM INTO THE NEW CARPARK WITH A NEW 250W AMPLIFIER MOUNTED IN CR-C. THE AMPLIFIER IS TO MATCH THE EXITING MANUFACTURER USED IN THE CLUBHOUSE. CONNECT THE AMPLIFIER TO THE CLUBHOUSES EXISTING PUBLIC ADDRESS SYSTEM WHICH IS TO BE UPGRADED ACCORDINGLY TO ALLOW THE CARPARK TO BE INCLUDED AS A DEDICATED ZONE OR COMBINED WITH OTHER ZONES. PROVIDE HORNS ON THE CEILING OR ON THE LIGHT POLES THROUGH THE CARPARK. THE PUBLIC ADDRESS COMPONENT OF THIS CONTRACT INCLUDES, BUT IS NOT LIMITED TO THE FOLLOWING EXTENT OF WORK:


- AMPLIFIER.
- INTERFACE TO THE EXISTING PUBLIC ADDRESS SYSTEM.
- UPGRADING THE EXISTING PUBLIC ADDRESS SYSTEM AS NECESSARY.
- SPEAKER CABLING.
- HORN SPEAKERS.
- LABELLING.
- TESTING AND COMMISSIONING.

THE COPYRIGHT OF THIS DRAWING REMAINS THE PROPERTY OF THE ELECTRICAL DESIGN GROUP.		
USE FIGURED DIMENSIONS IN PREFERENCE TO SCALE.		
ALL DIMENSIONS TO BE VERIFIED ONSITE.		

NOTES

11. ABBREVIATIONS

- A - AMP CURRENT RATING
- AB - MOUNT ABOVE BENCH.
- AFFL - ABOVE FINISHED FLOOR LEVEL.
- BB - MOUNT BELOW BENCH.
- BH - MOUNT ON BULKHEAD.
- CEIL - MOUNT ON CEILING.
- CS - MOUNT WITHIN CEILING SPACE.
- C/W - COMPLETE WITH
- RCBO - CIRCUIT PROTECTED VIA A 30mA RESIDUAL CURRENT DEVICE
- INTEGRAL TO THE CIRCUIT BREAKER. 3-PHASE
- RCBO TO BE 4-POLE.
- REF - REFRIGERATOR.
- SUS - MOUNT SUSPENDED FROM CEILING.
- UNO - UNLESS NOTED OTHERWISE.
- WP - WEATHERPROOF TO IP56 UNO.
- 500 - NUMBER DENOTES MOUNTING HEIGHT AFFL.

D	CONSTRUCTION	14/08/2025
REV:	DESCRIPTION:	DATE:
<div><div></div><div>ELECTRICAL DESIGN GROUP</div></div> <div>ELECTRICAL BUILDING SERVICES CONSULTANTS</div>		
<div><div>BRISBANE:</div><div>P.O. Box 15 Sherwood Qld 4075 Phone: (07) 3278 4375 Email: brisbane@edg.net.au Web: www.edg.net.au</div></div>		
<div><div><div>ELECTRICAL DESIGN GROUP BRISBANE PTY LTD ACN 092 710 793</div><div>TRADING AS: ELECTRICAL DESIGN GROUP</div></div></div>		
PROJECT:		
CAPALABA SPORTS CLUB MULTI-STOREY CARPARK		
SITE ADDRESS:		
113 NEY ROAD, CAPALABA		
SCALE:		
NOT TO SCALE AT A1		
DRAWING TITLE:		
ELECTRICAL SERVICES NOTES		
PROJECT NO:	DRAWING NO:	REVISION:
C3455a E04 D		