


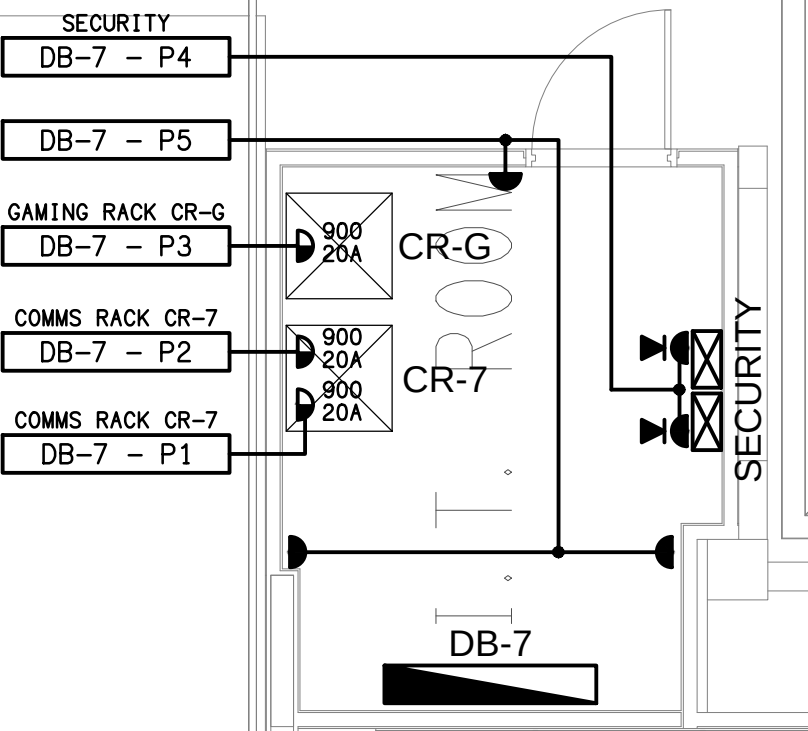


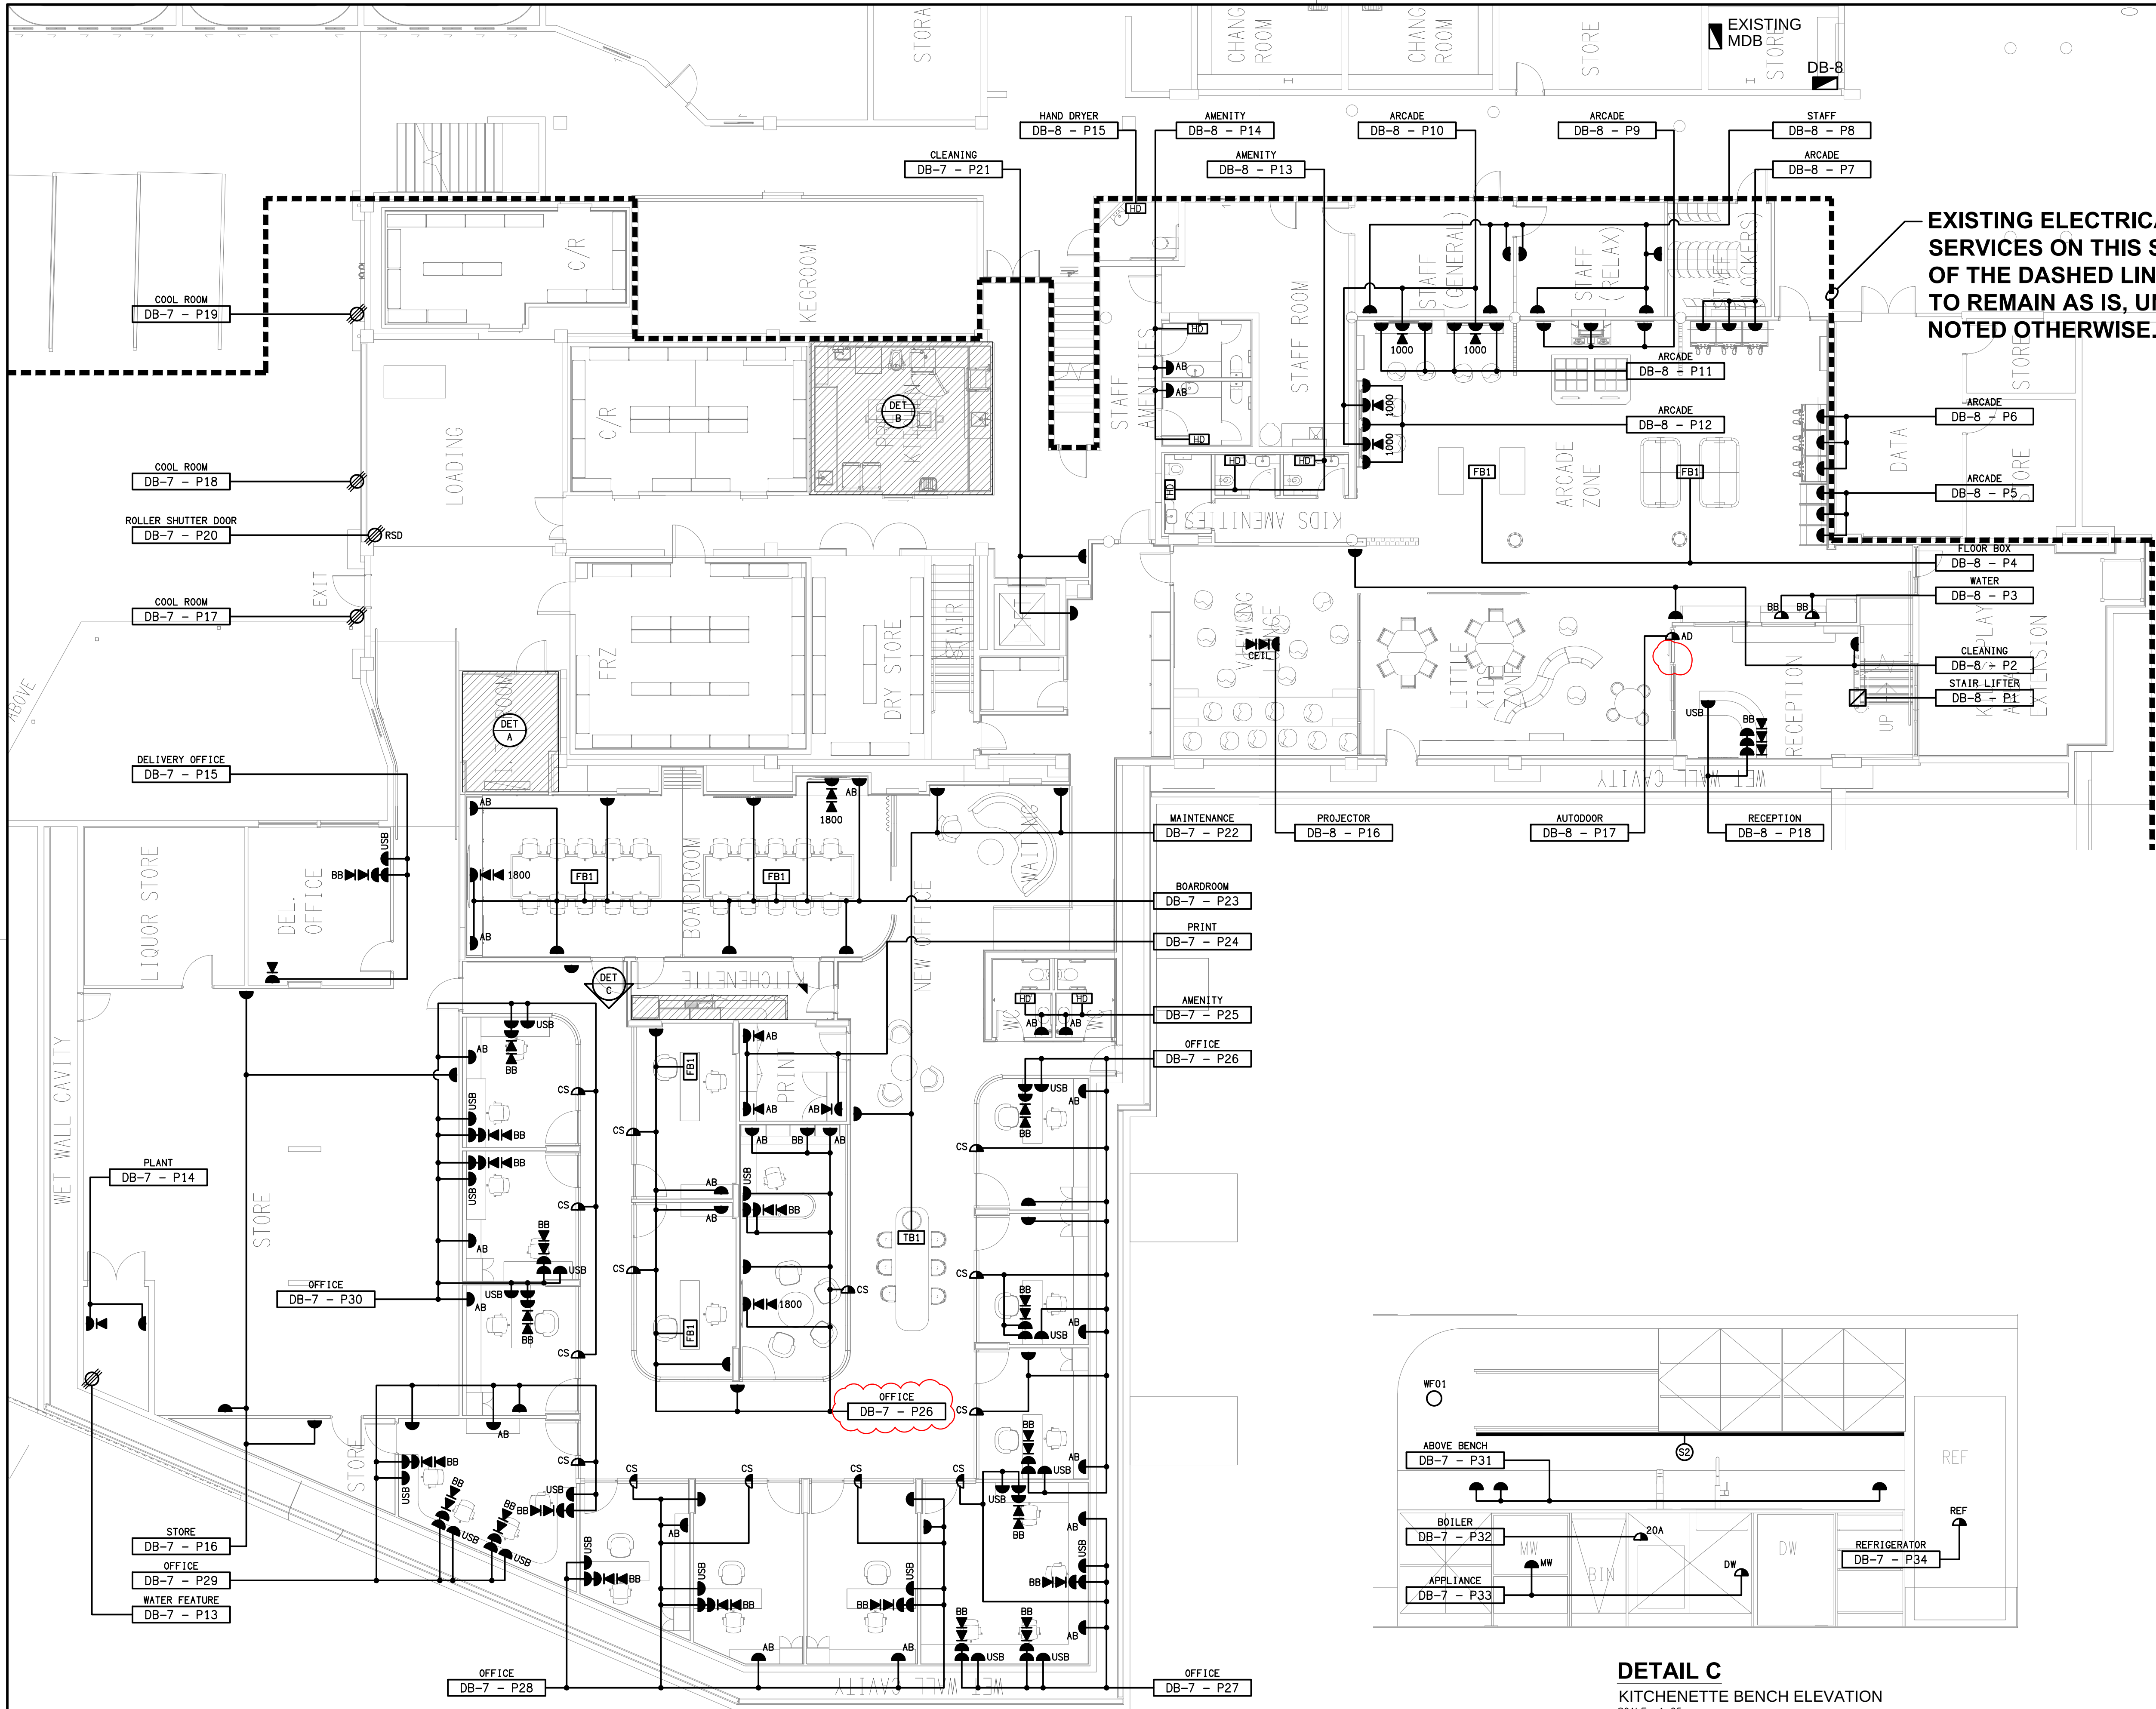

DETAIL A
IT ROOM FLOOR PLAN
SCALE 1:50

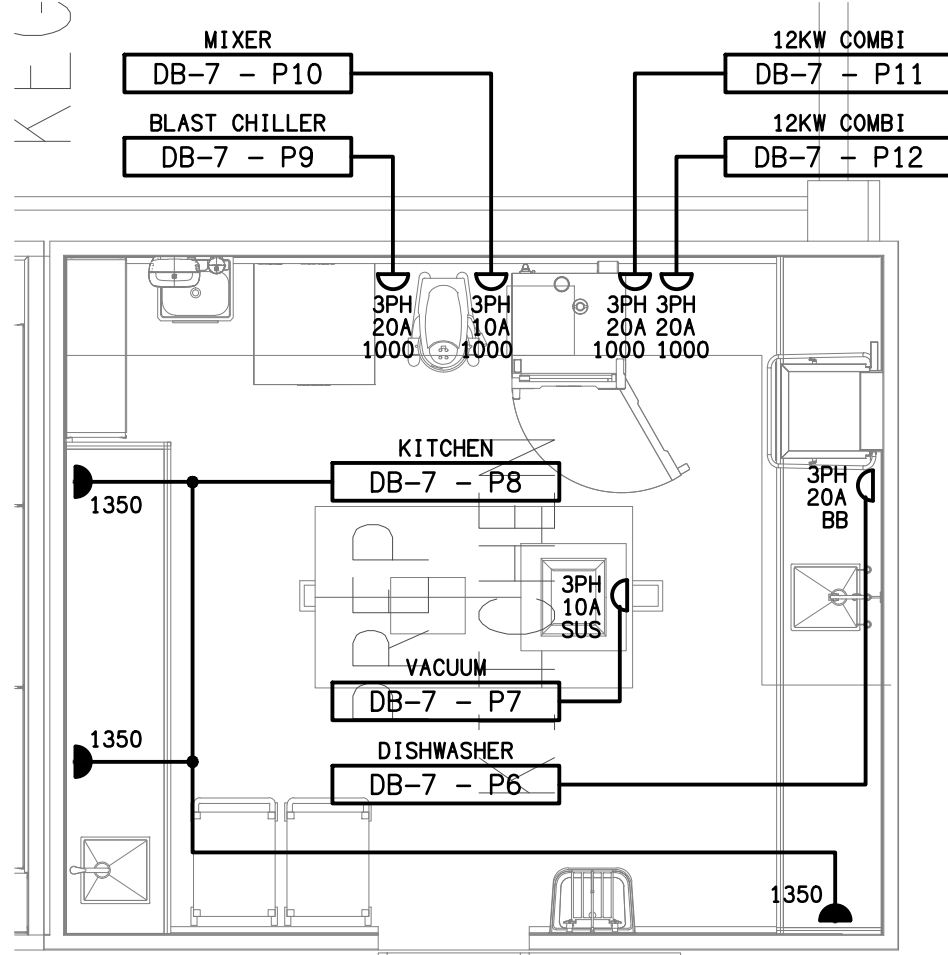

DETAIL B
PREP KITCHEN FLOOR PLAN
SCALE 1:50

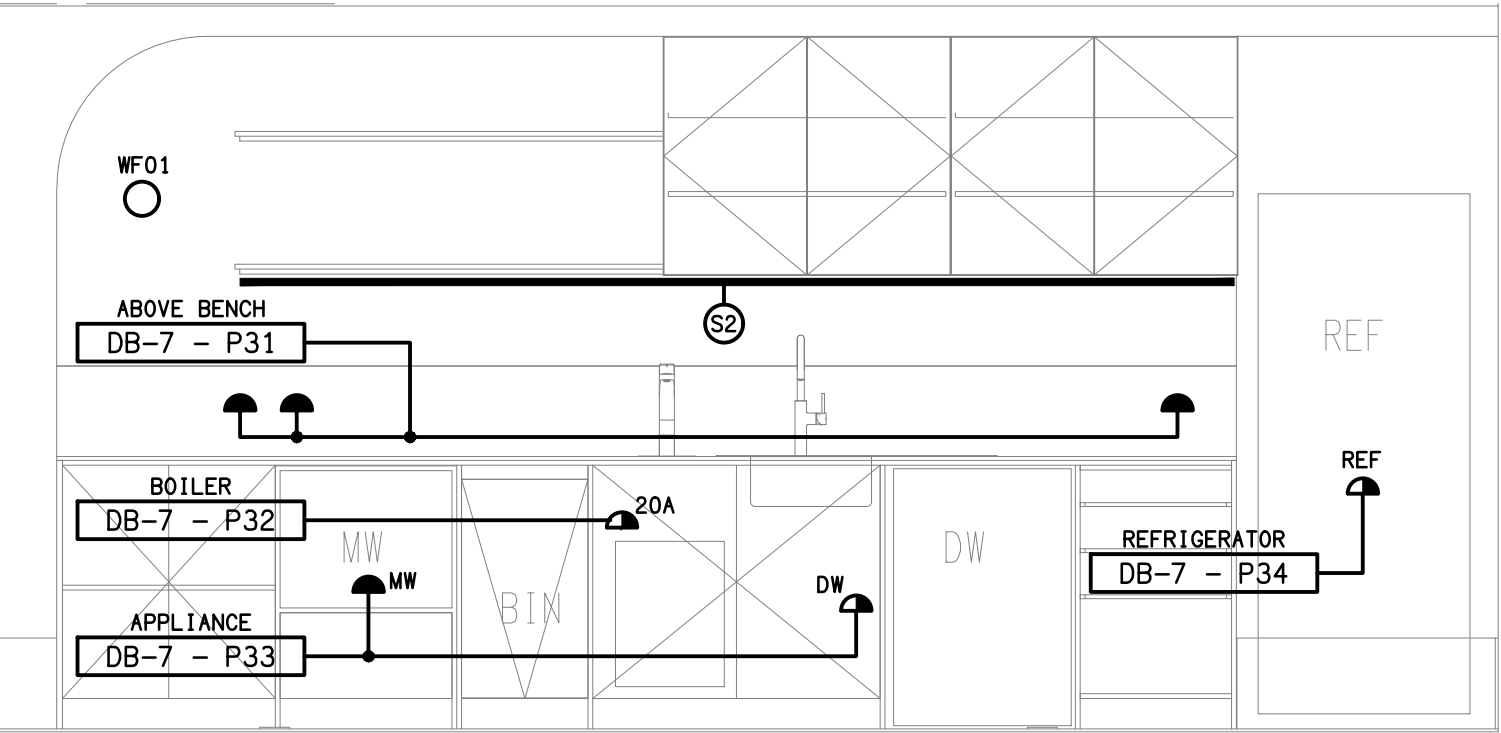

DETAIL C
KITCHENETTE BENCH ELEVATION
SCALE 1:25

ELECTRICAL DESIGN GROUP BRISBANE
PTY LTD
ACN 092 710 793
TRADING AS:
ELECTRICAL DESIGN GROUP

THE COPYRIGHT OF THIS DRAWING
REMAINS THE PROPERTY OF THE
ELECTRICAL DESIGN GROUP.
USE FIGURED DIMENSIONS
IN PREFERENCE TO SCALE.
ALL DIMENSIONS TO BE
VERIFIED ON SITE.

ELECTRICAL DESIGN GROUP
ELECTRICAL BUILDING SERVICES CONSULTANTS
BRISBANE GOLD COAST

P.O. Box 15, Sherwood Q. 4075
Phone: (07) 3278 4375
Email: brisbane@edg.net.au
Web: www.edg.net.au

PROJECT:
THE LION RICHLANDS - STAGE 2

133 PINE ROAD, RICHLANDS

C	TENDER	17/07/2026
REV:	DESCRIPTION:	DATE:

DRAWING:
ELECTRICAL SERVICES
BASEMENT LEVEL FLOOR PLAN

SCALE:
1:100 UNO

AT A1

PROJECT NO:
C3457a

DRAWING NO:
E05

REVISION:
C