



**NOTE:**  
REFER TO DRAWING C3457a-E12.dwg FOR  
ADDITIONAL CEILING STRIP LIGHTING PLAN.  
  
REFER TO DRAWING C3457a-E13.dwg FOR  
ADDITIONAL JOINERY & WALL LIGHTING PLAN.

REFER TO DETAIL A FOR THE  
PLANT DECK PLAN ABOVE.

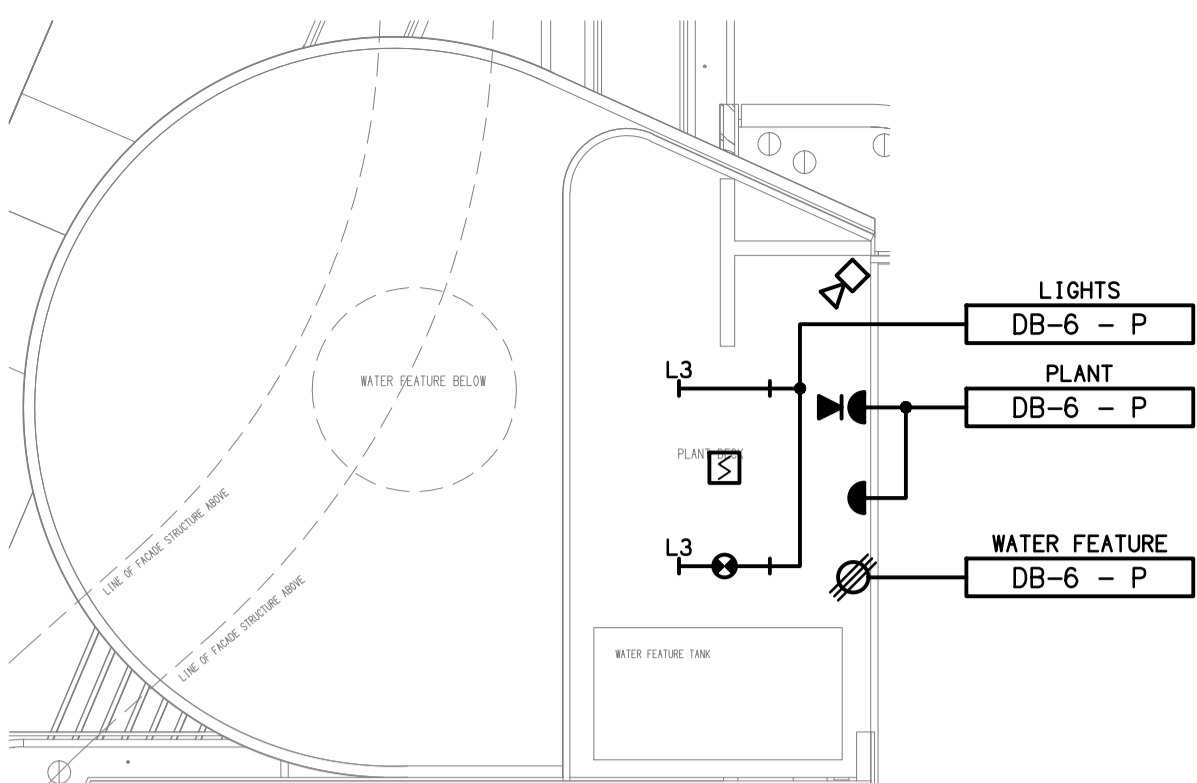

**DETAIL A**  
CANTILEVER PLANT DECK PLAN  
SCALE 1: 100

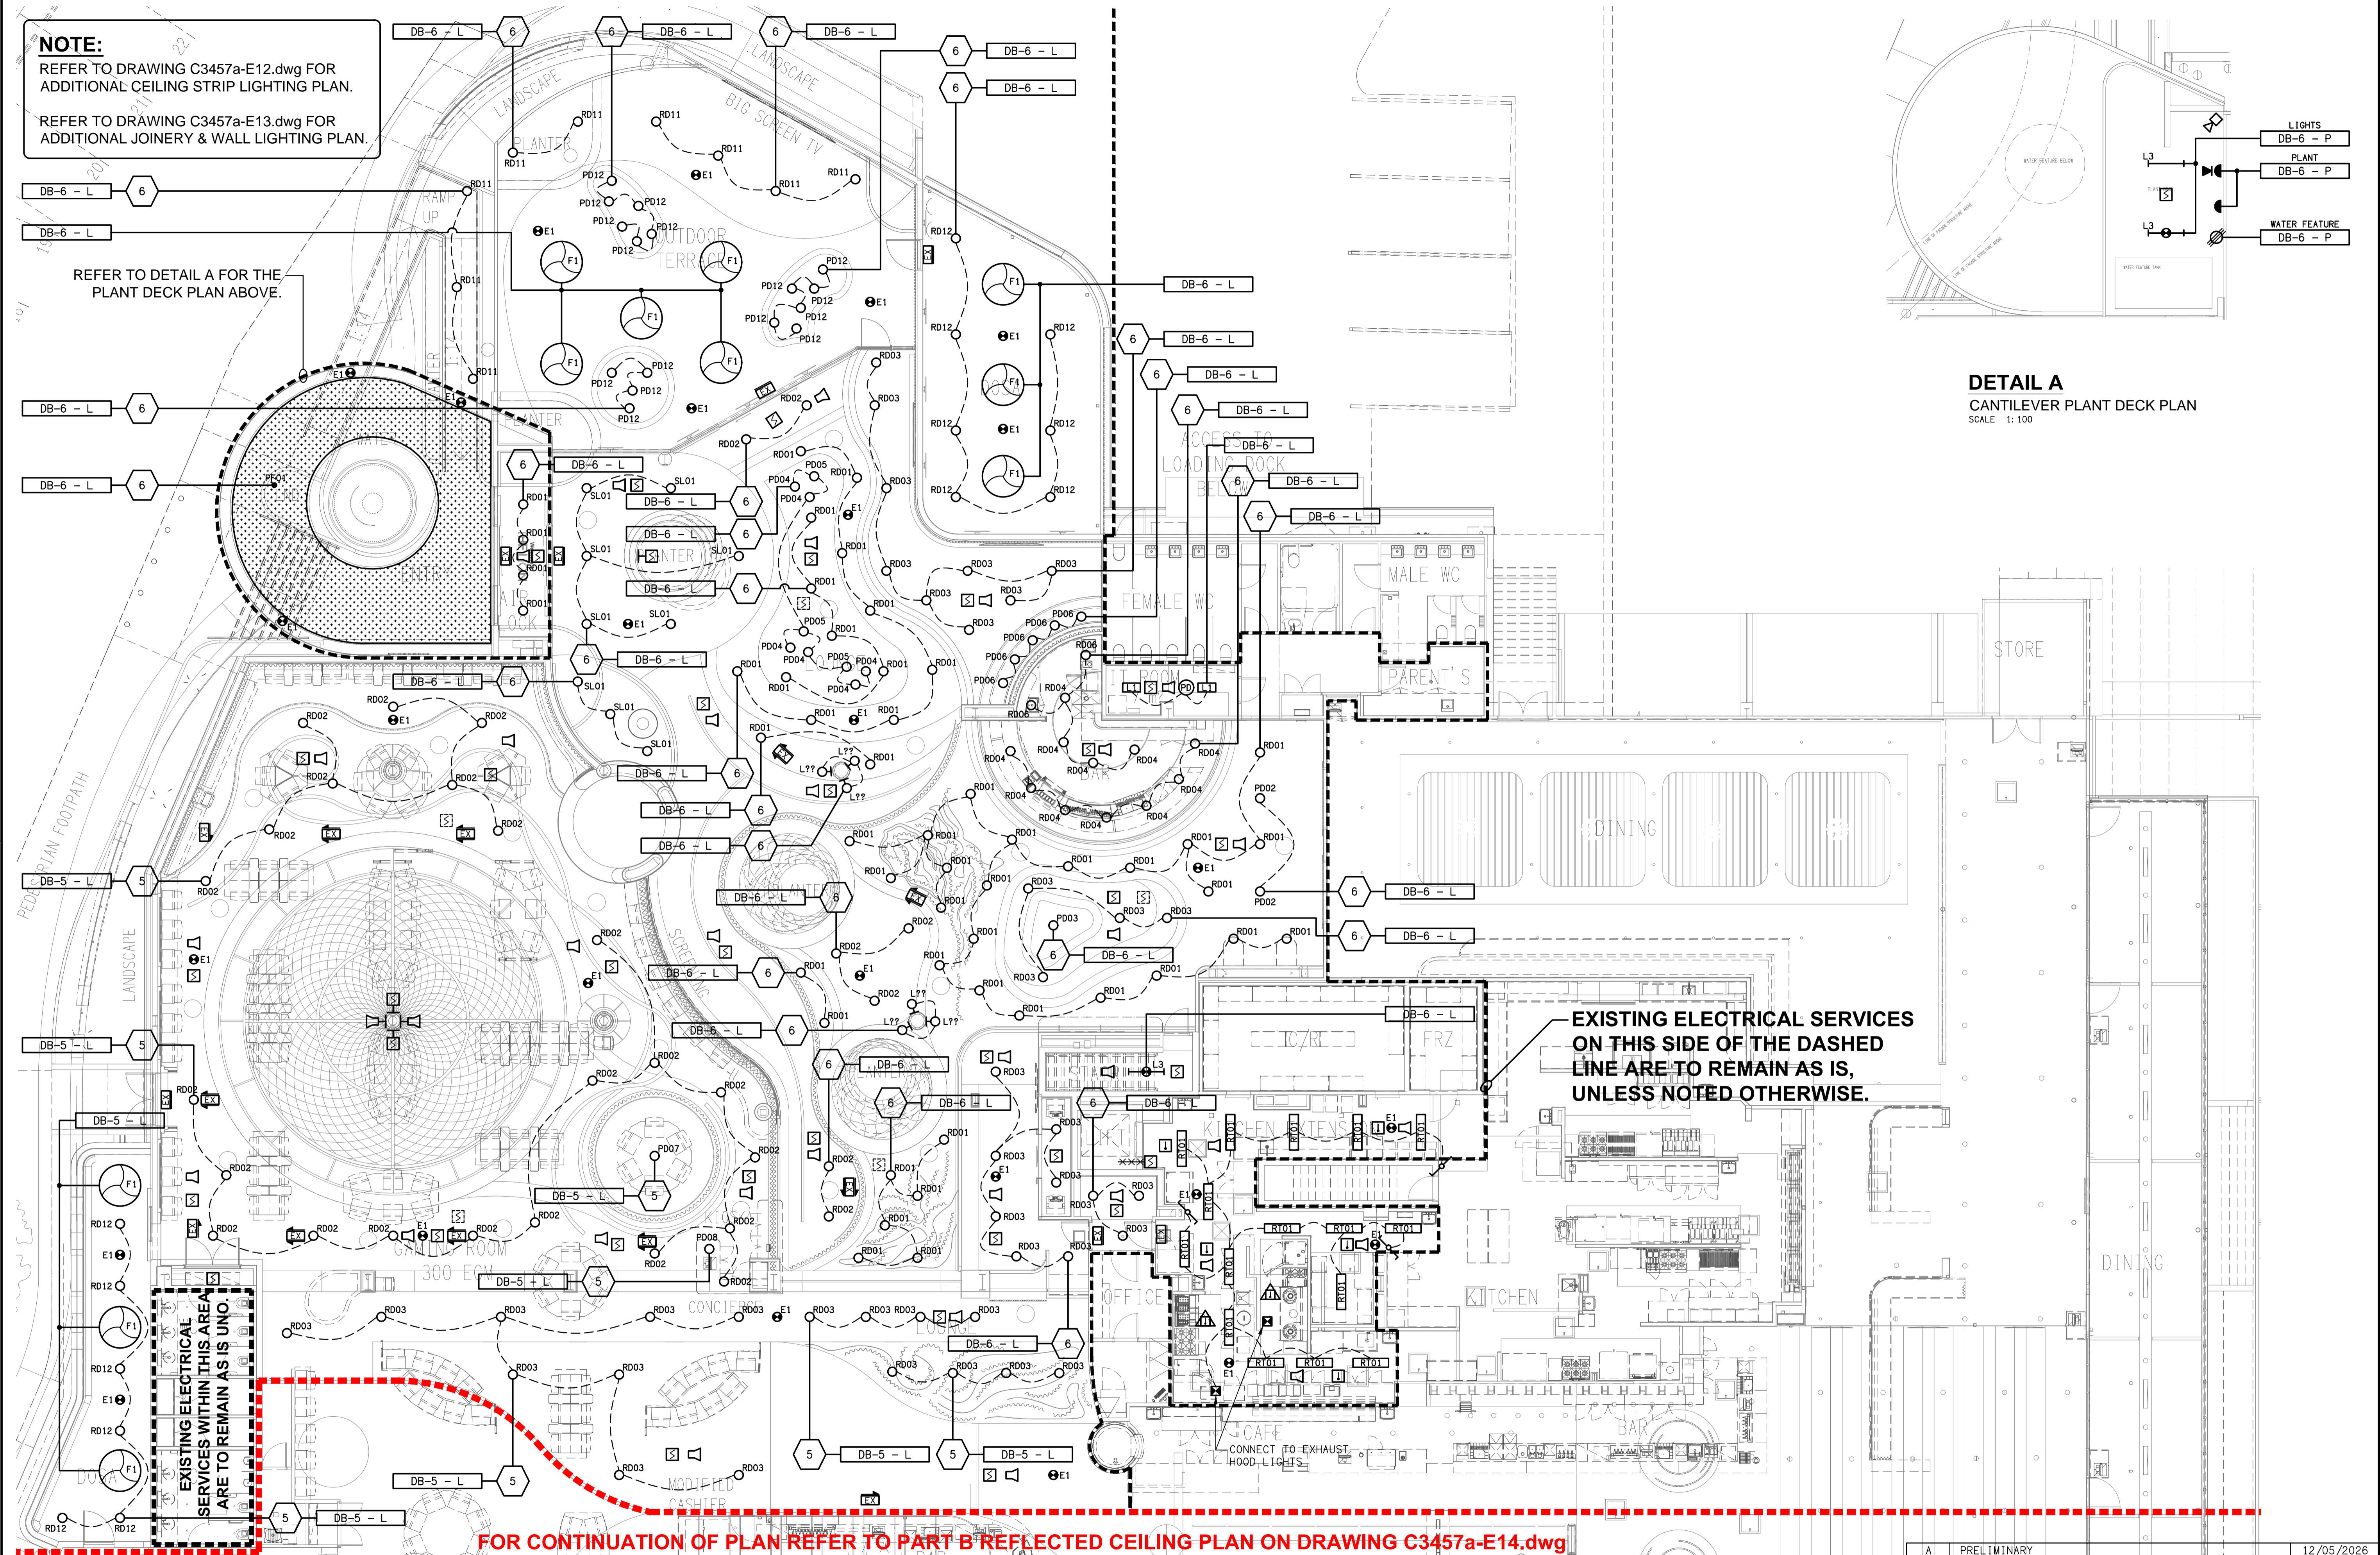

FOR CONTINUATION OF PLAN REFER TO PART B REFLECTED CEILING PLAN ON DRAWING C3457a-E14.dwg