



DETAIL A
TAB & KENO WALL ELEVATION
SCALE 1: 50

NOTE:
THE LIGHTING CONTROL CHANNELS THAT CONTROL THE DB-C CIRCUITS ARE TO CONTAIN FACILITY IN DB-G TO ALLOW THE GAMING ELECTRICIAN TO CONNECT THE CIRCUITS TO THE CONTROLLERS IN DB-G.

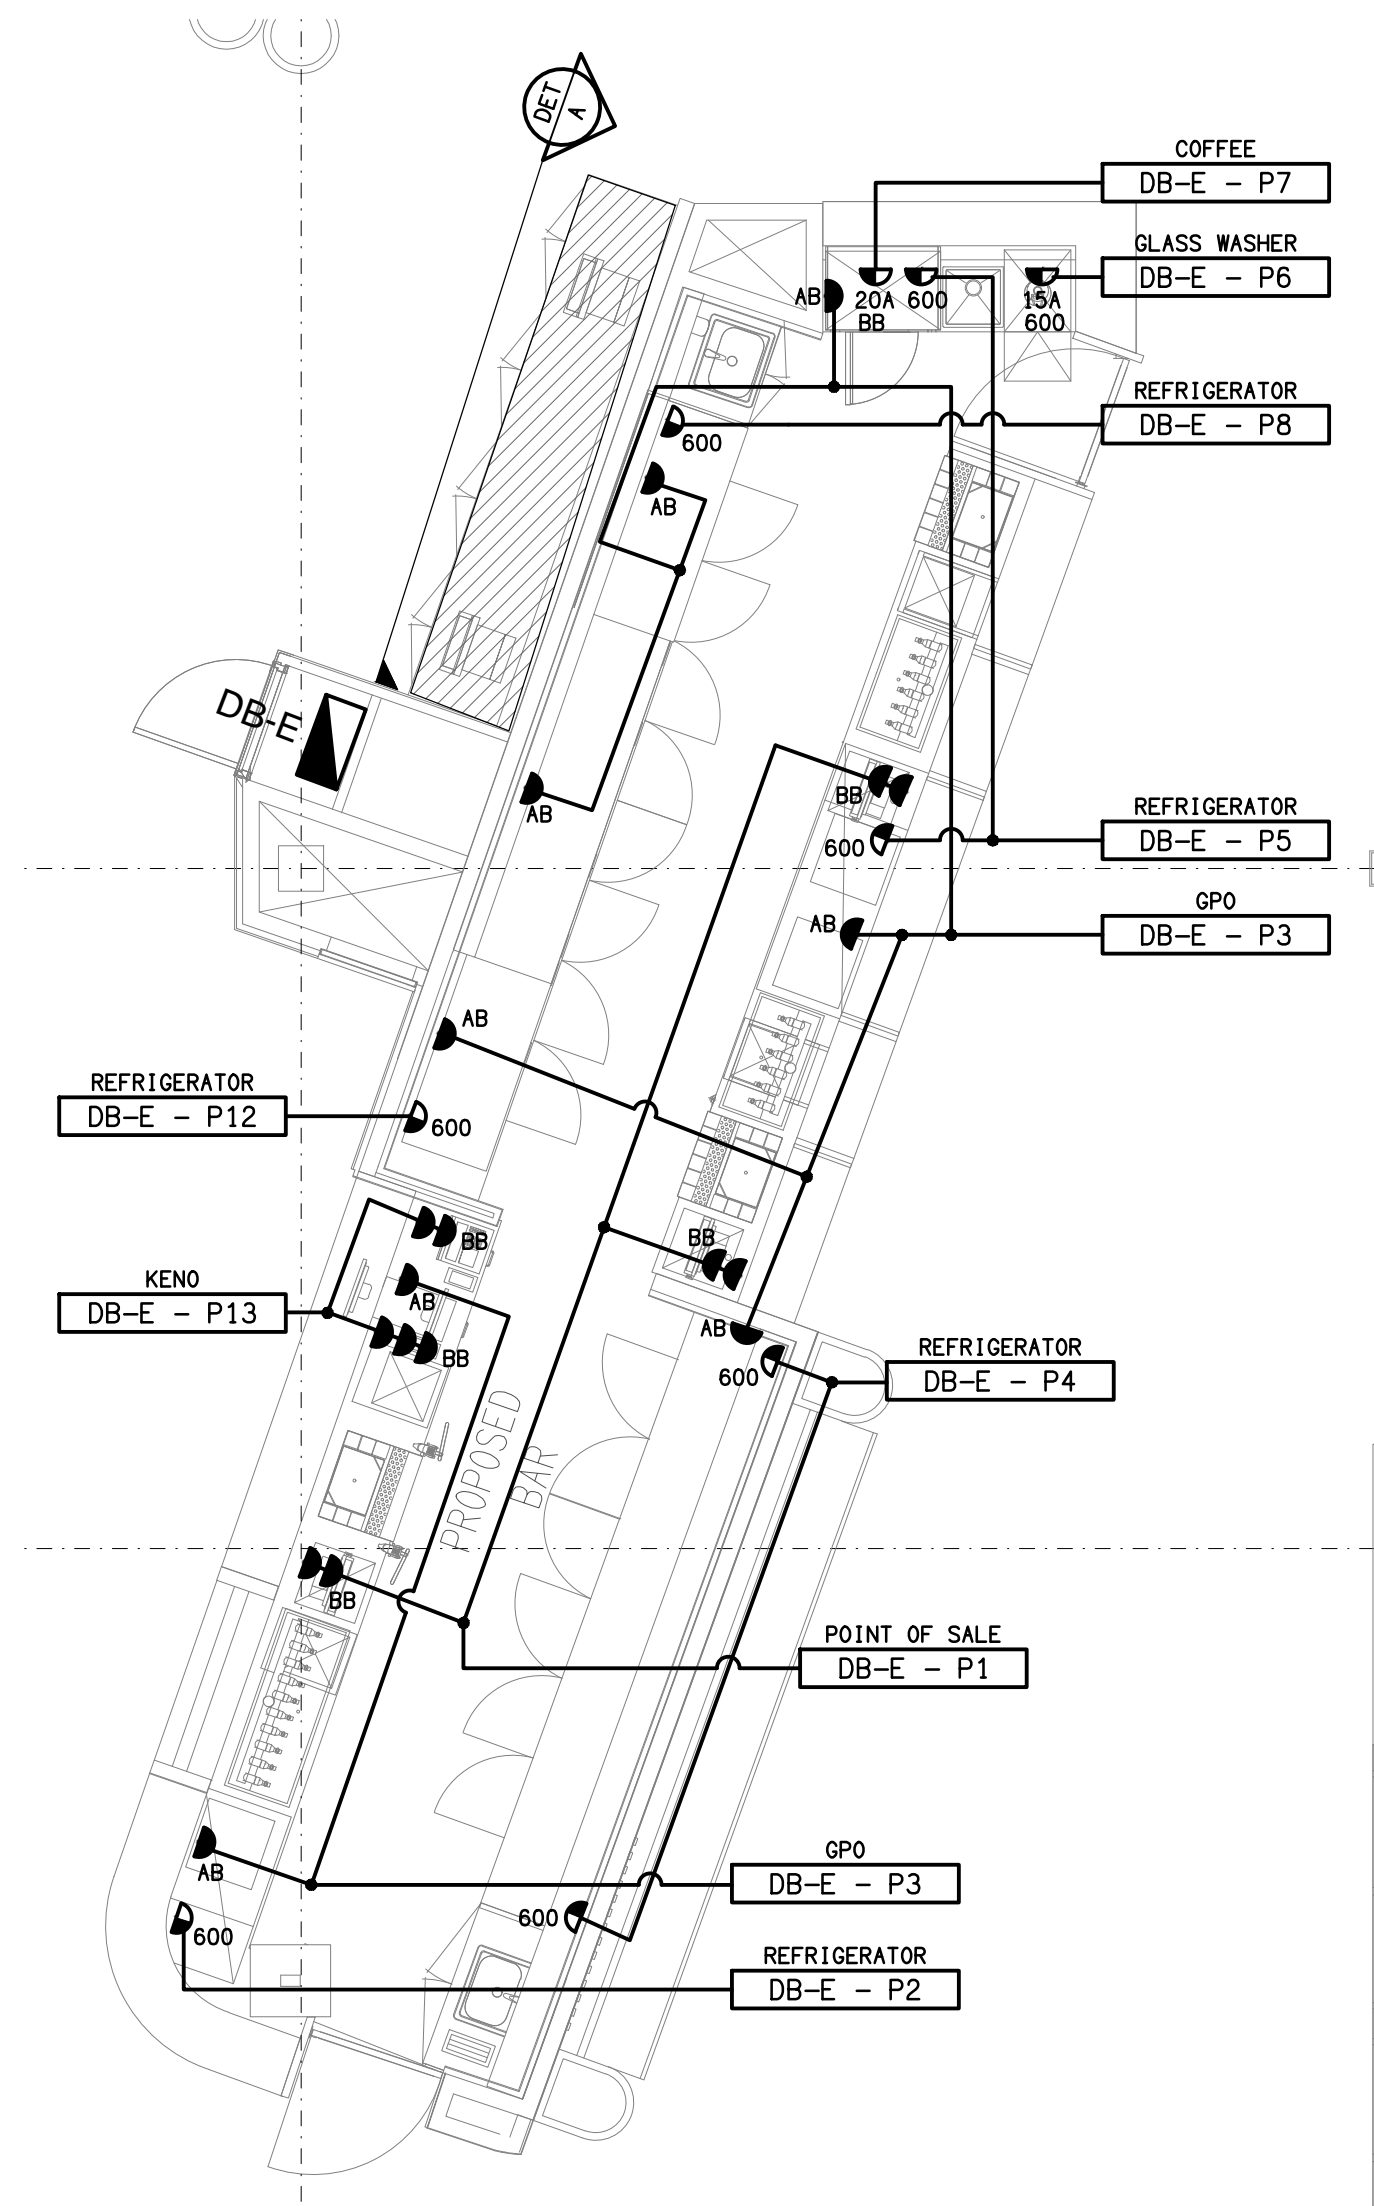

SPORTS BAR
FLOOR PLAN
SCALE 1: 50

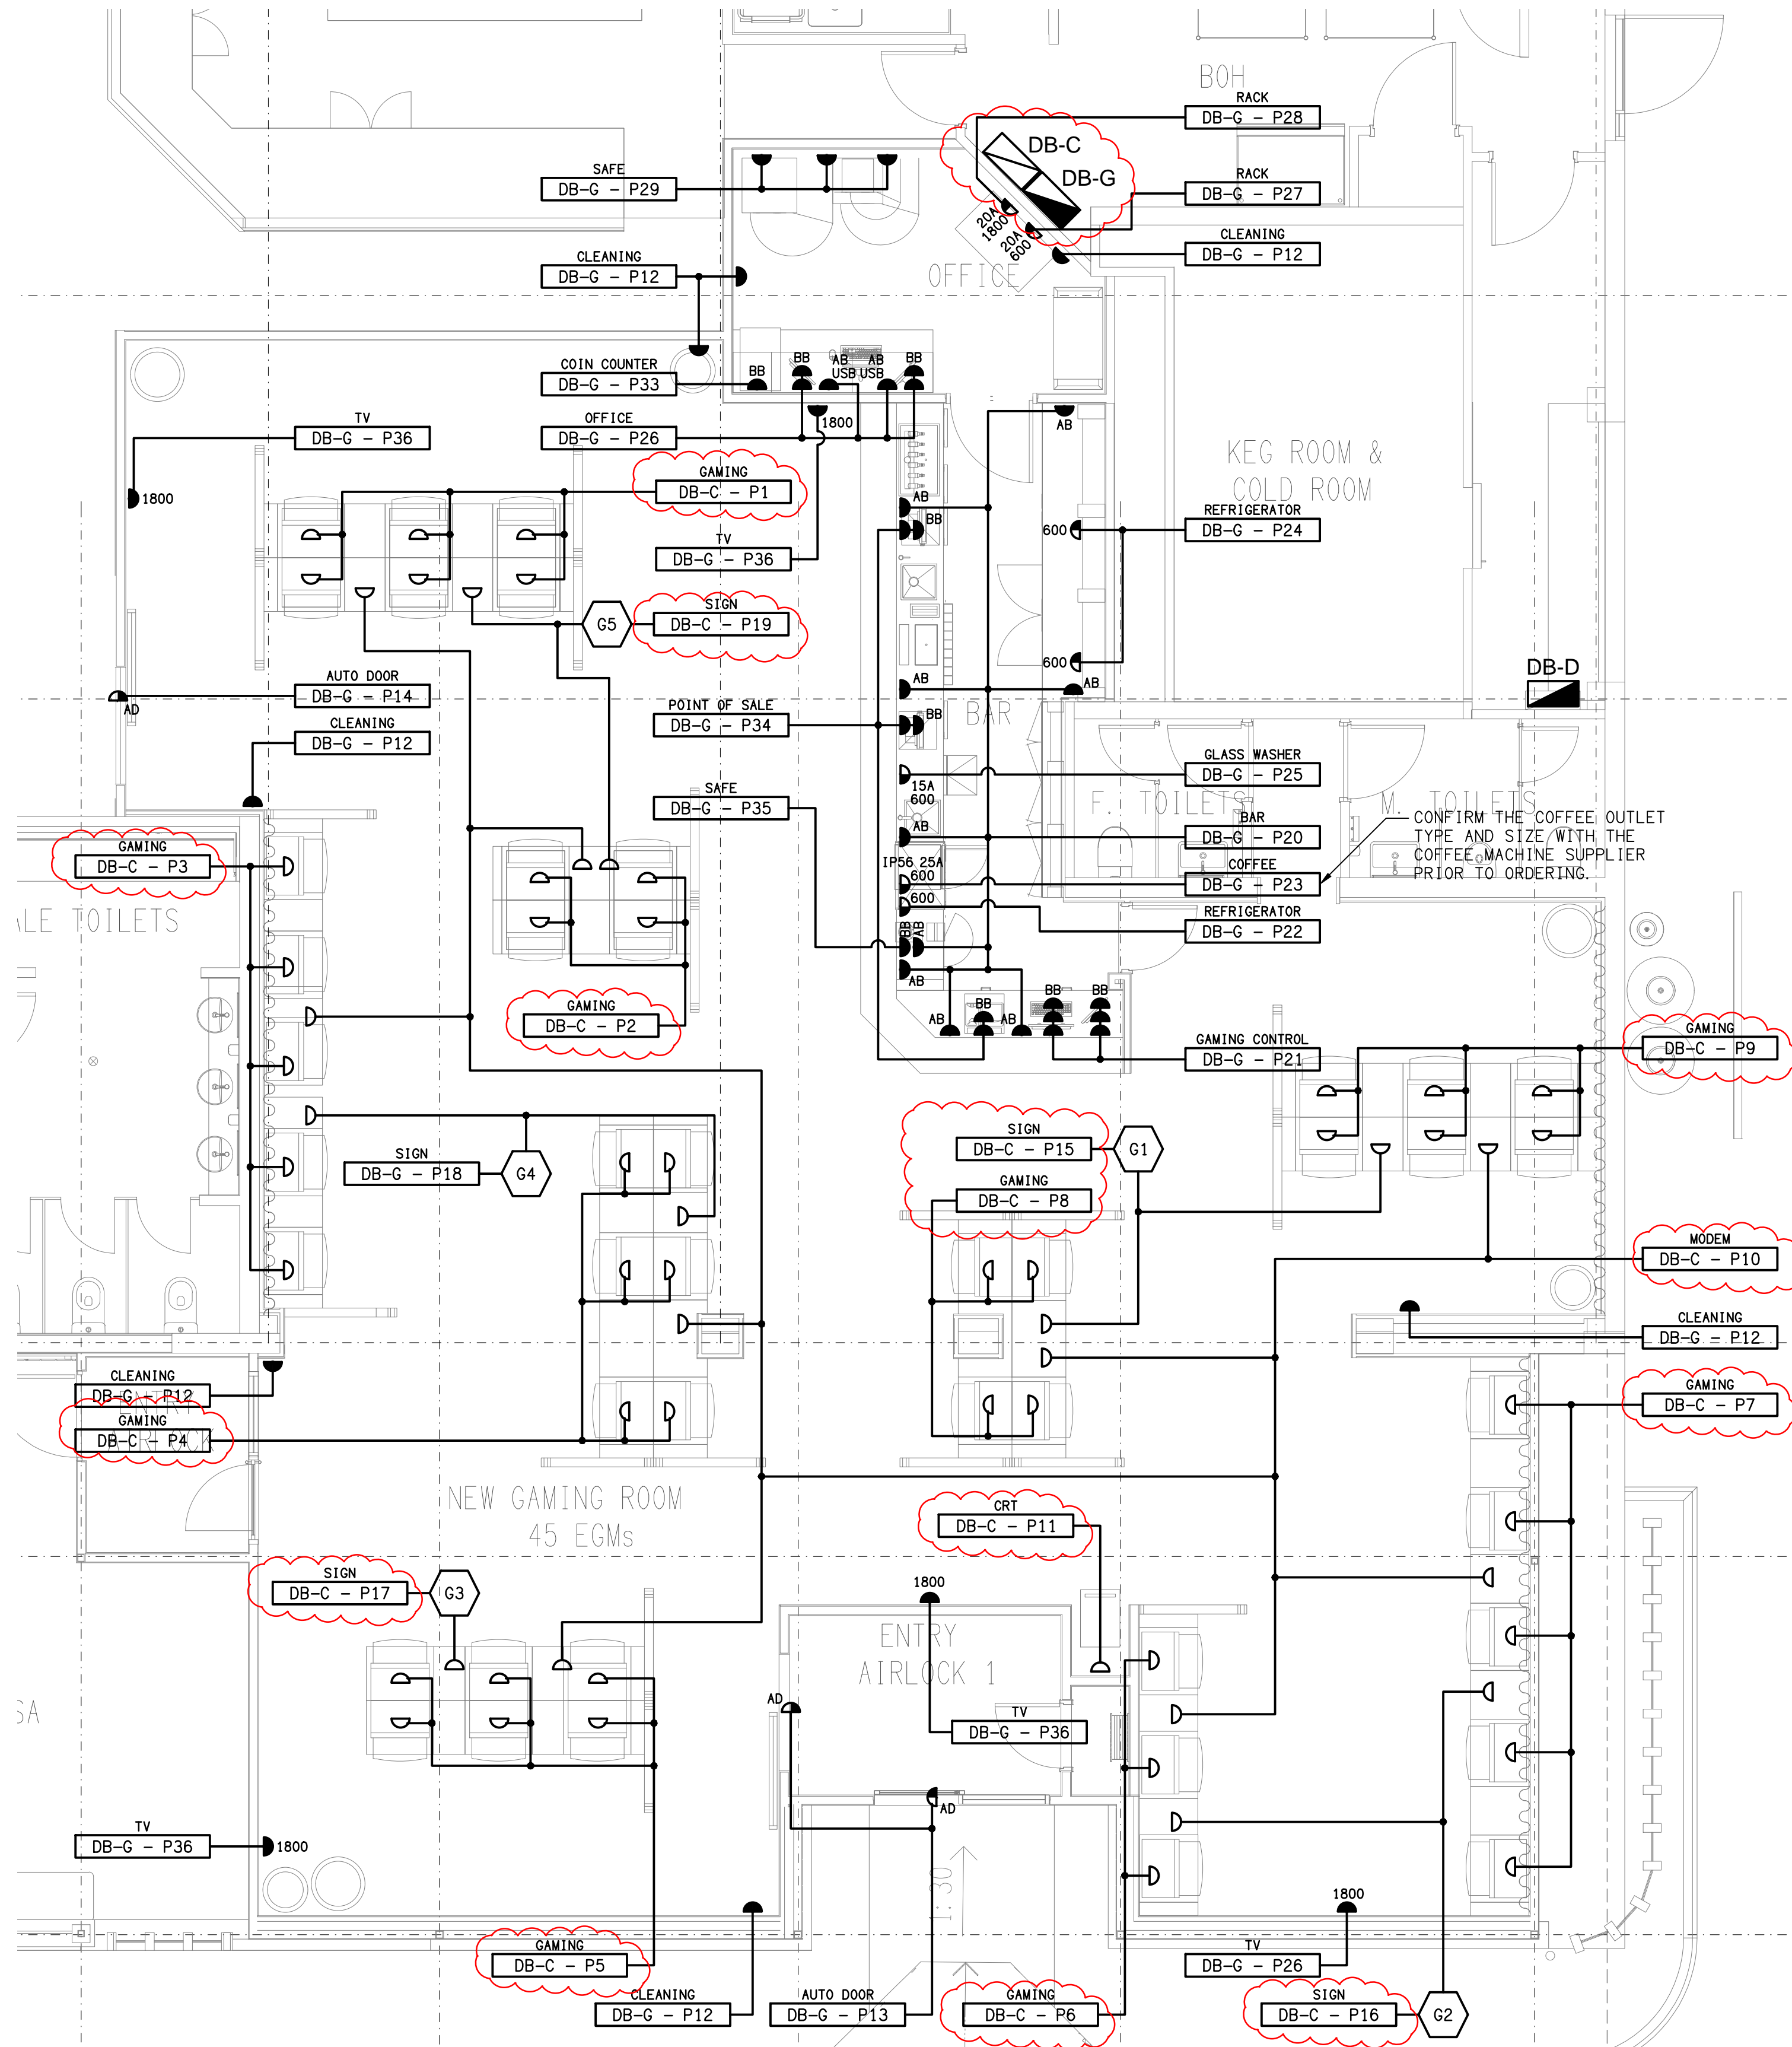

GAMING ROOM
FLOOR PLAN
SCALE 1: 50

THE COPYRIGHT OF THIS DRAWING REMAINS THE PROPERTY OF THE ELECTRICAL DESIGN GROUP.

USE FIGURED DIMENSIONS IN PREFERENCE TO SCALE.

ALL DIMENSIONS TO BE VERIFIED ONSITE.

E	CONSTRUCTION	14/10/2025
REV:	DESCRIPTION:	DATE:

ELECTRICAL DESIGN GROUP
ELECTRICAL BUILDING SERVICES CONSULTANTS

BRISBANE: P.O. Box 15 Sherwood Qld 4075
Phone: (07) 3278 4375
Email: brisbane@edg.net.au
Web: www.edg.net.au

ELECTRICAL DESIGN GROUP BRISBANE PTY LTD
ACN 092 710 793

PROJECT: **GOLDEN BEACH TAVERN CALOUNDRA**

SITE ADDRESS: **32 BOWMAN ROAD, CALOUNDRA QUEENSLAND**

SCALE: 1:50 SHEET SIZE: AT A1

DRAWING TITLE:

ELECTRICAL SERVICES
GAMING ROOM & BAR
FLOOR PLANS

PROJECT NO: DRAWING NO: REVISION:

C3470a E04 E