


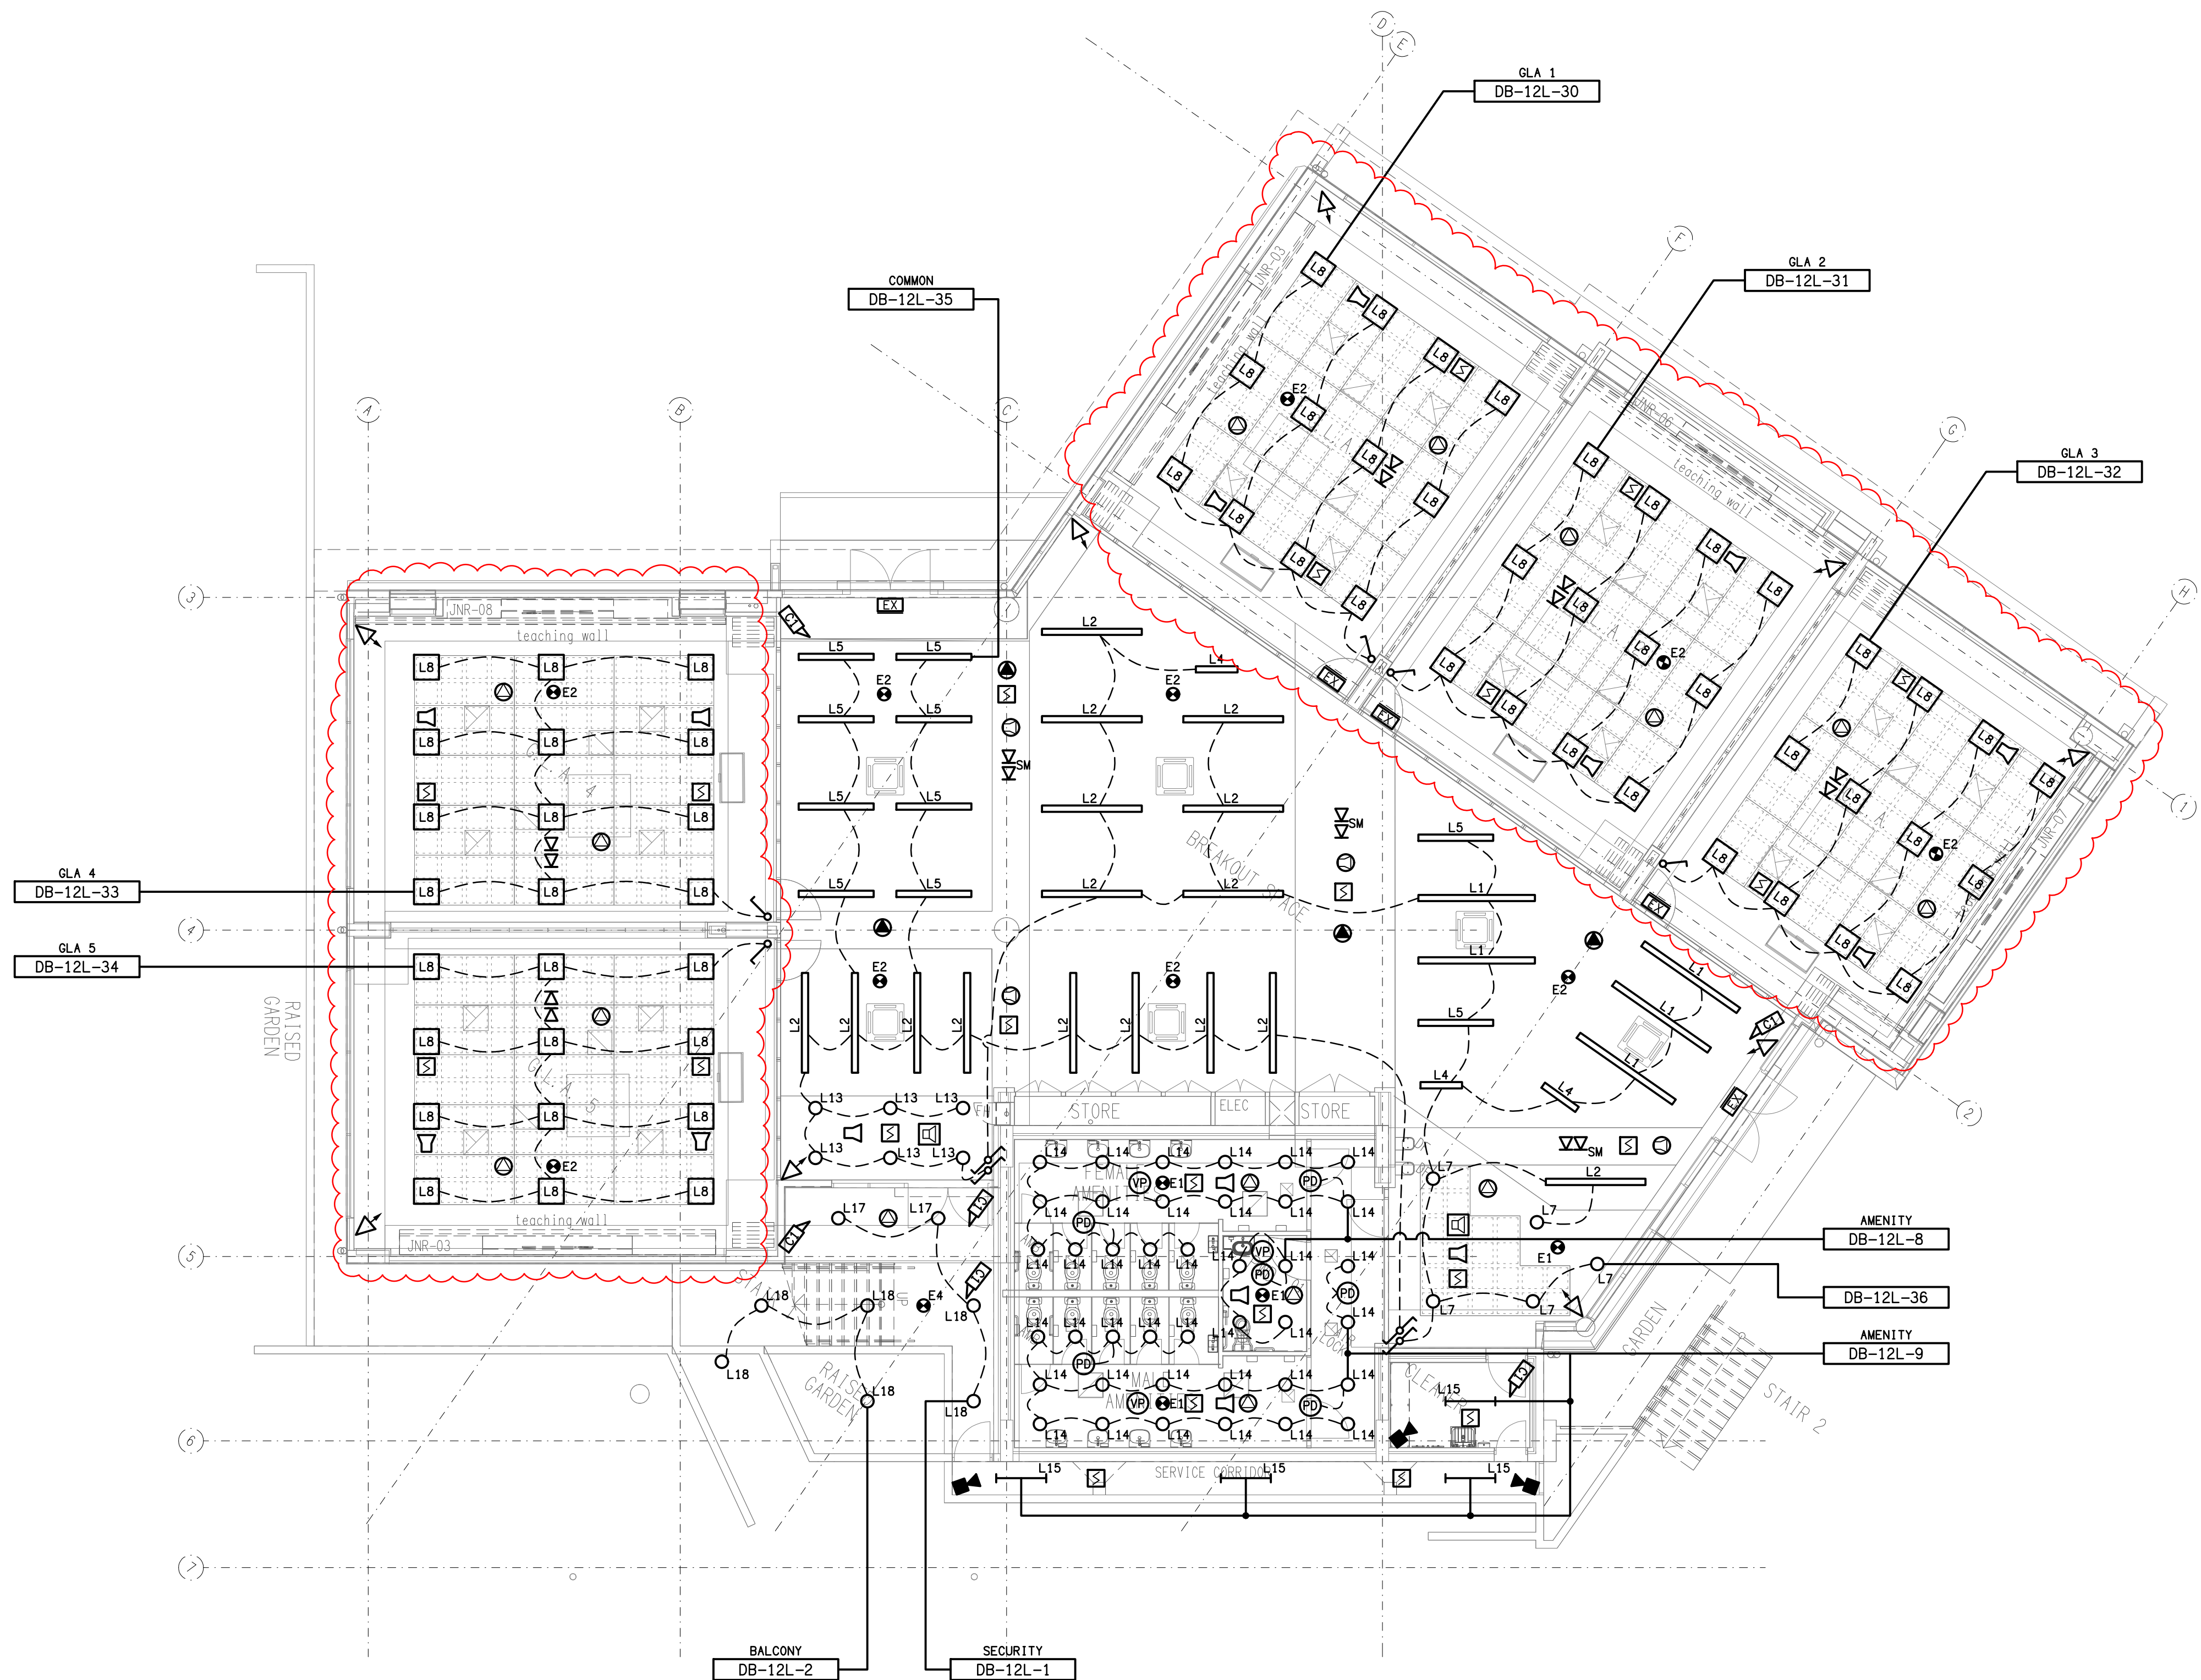

ELECTRICAL DESIGN GROUP BRISBANE
PTY LTD
ACN 092 710 793
TRADING AS:
ELECTRICAL DESIGN GROUP

THE COPYRIGHT OF THIS DRAWING
REMAINS THE PROPERTY OF THE
ELECTRICAL DESIGN GROUP.
USE FIGURED DIMENSIONS
IN PREFERENCE TO SCALE.
ALL DIMENSIONS TO BE
VERIFIED ONSITE.

ELECTRICAL DESIGN GROUP
ELECTRICAL BUILDING SERVICES CONSULTANTS
BRISBANE GOLD COAST

P.O. Box 15, Sherwood Q. 4075
Phone: (07) 3278 4375
Email: brisbane@edg.net.au
Web: www.edg.net.au

PROJECT:
KINGS CHRISTIAN COLLEGE
CHAMBERS FLAT, SENIOR SCHOOL CHA12

38-112 ANZAC AVENUE, CHAMBERS FLAT

F	CONSTRUCTION	20/07/2026
REV.	DESCRIPTION:	DATE:

DRAWING: ELECTRICAL SERVICES GROUND LEVEL REFLECTED CEILING PLAN	PROJECT NO: C3474a	DRAWING NO: E06	REVISION: F
SCALE: 1:100	AT A1		