



**FLOOR PLAN**  
LEVEL 1  
SCALE 1: 100

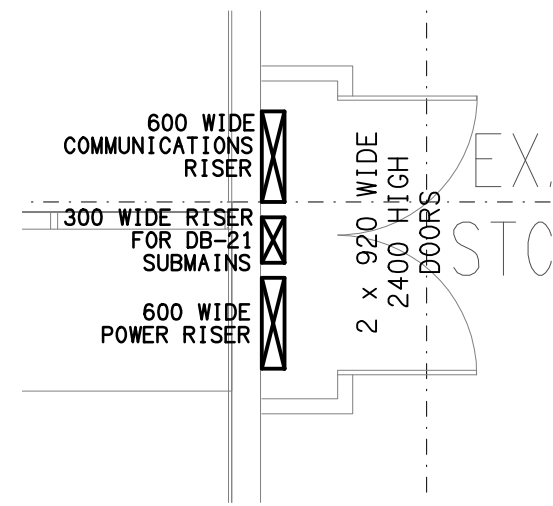

**DETAIL A**  
LEVEL 1 ELECTRICAL RISER CUPBOARD  
SCALE 1: 50

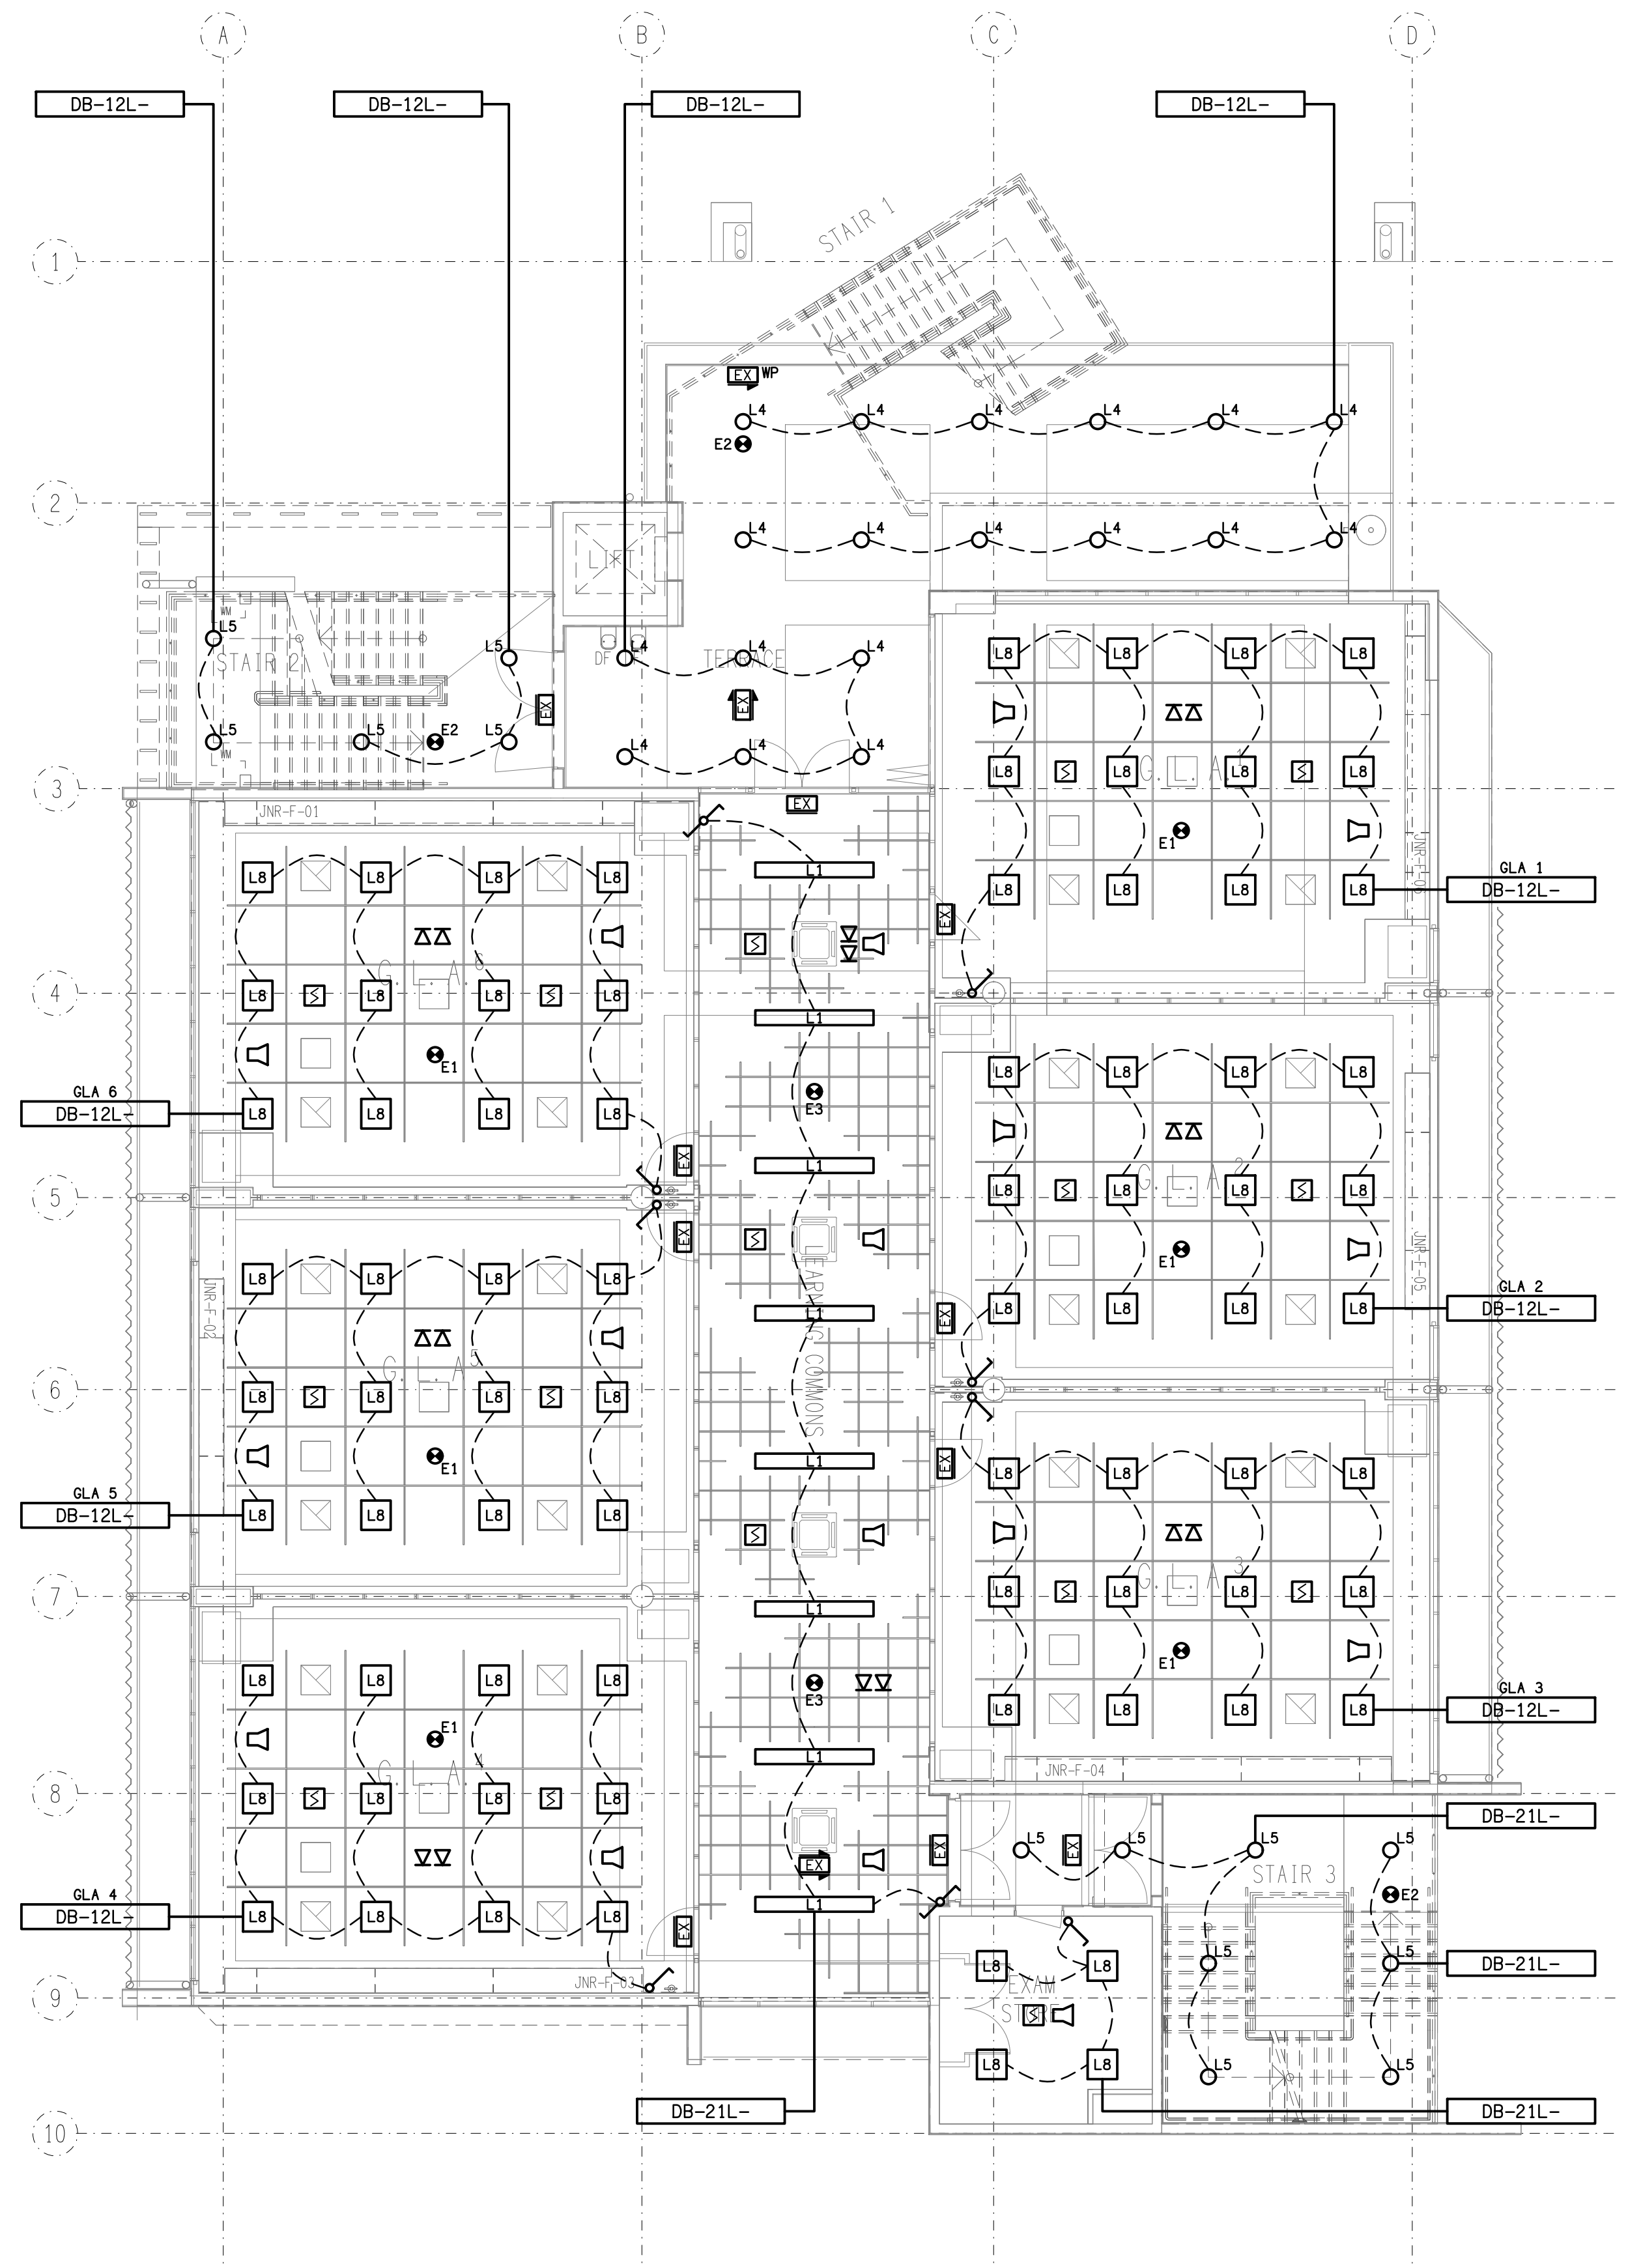

**REFLECTED CEILING PLAN**  
LEVEL 1  
SCALE 1: 100