



**FLOOR PLAN**  
LEVEL 2  
SCALE 1: 100

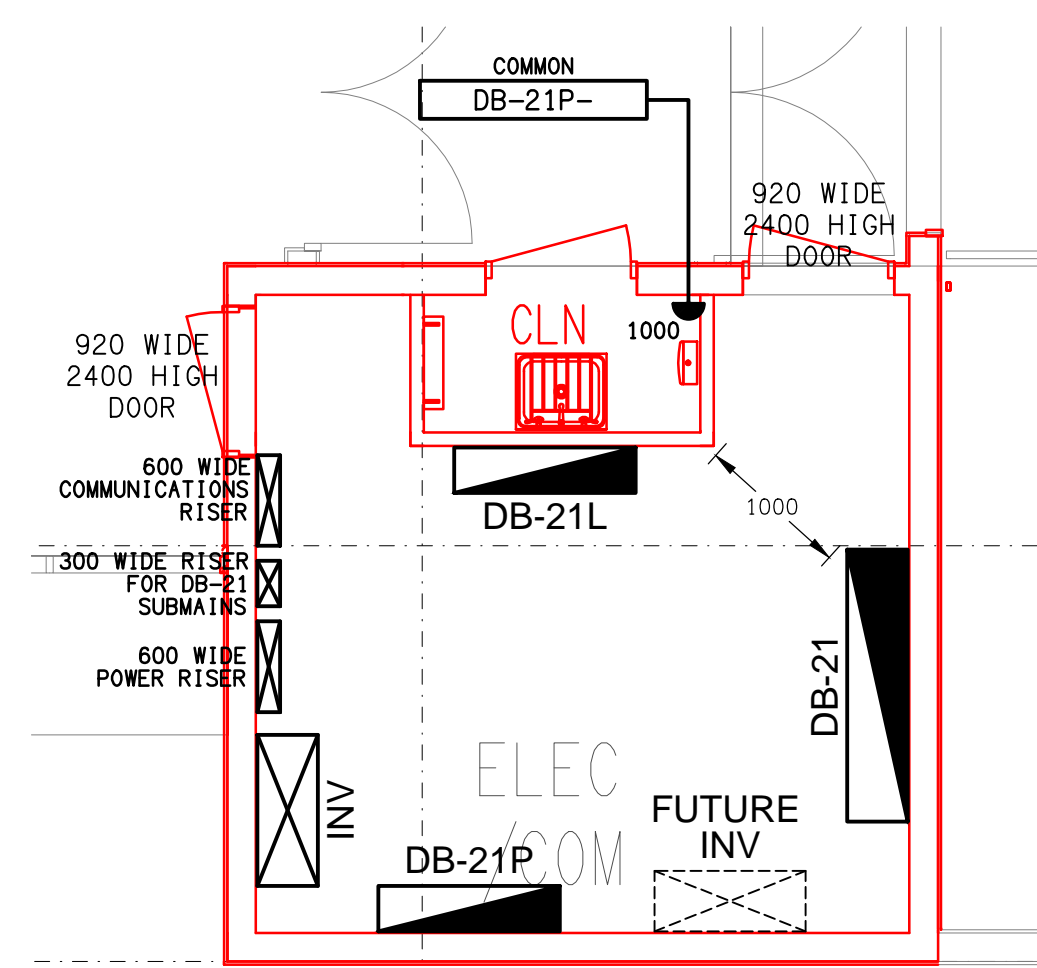

**DETAIL A**  
LEVEL 2 ELECTRICAL ROOM  
SCALE 1: 50

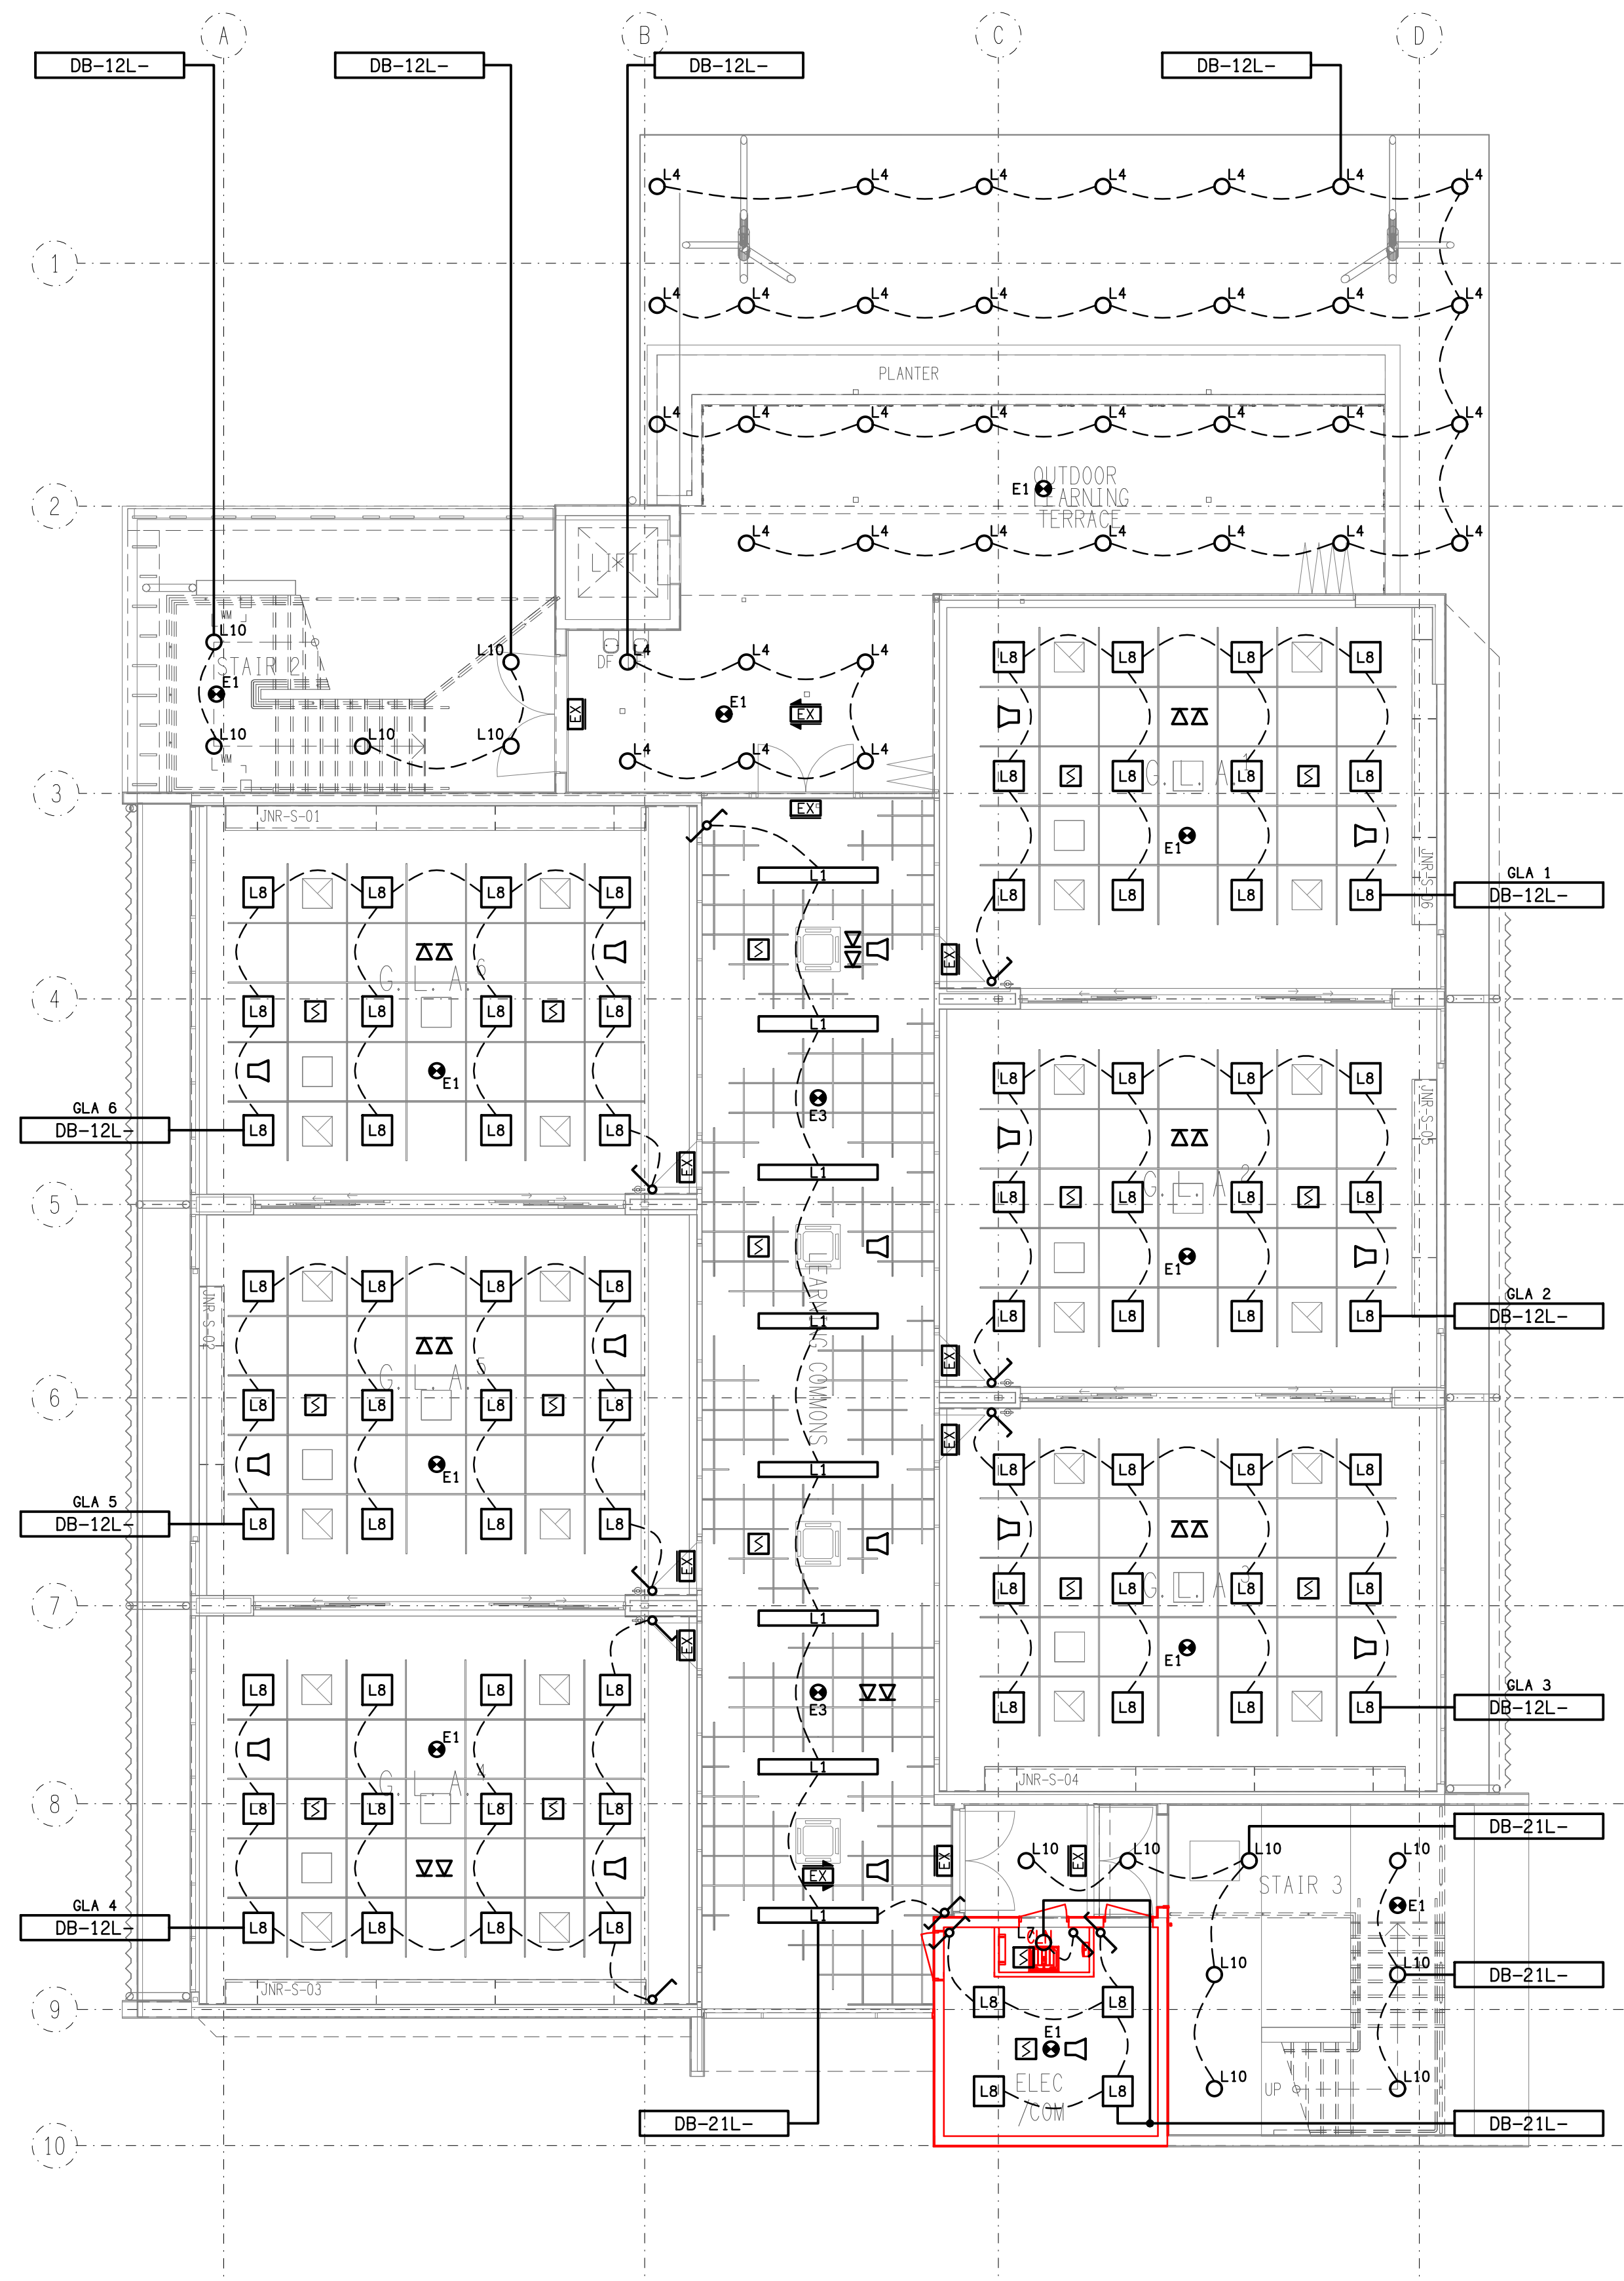

**REFLECTED CEILING PLAN**  
LEVEL 2  
SCALE 1: 100

ELECTRICAL DESIGN GROUP BRISBANE  
PTY LTD  
ACN 092 710 793  
TRADING AS:  
ELECTRICAL DESIGN GROUP

THE COPYRIGHT OF THIS DRAWING  
REMAINS THE PROPERTY OF THE  
ELECTRICAL DESIGN GROUP.  
USE FIGURED DIMENSIONS  
IN PREFERENCE TO SCALE.  
ALL DIMENSIONS TO BE  
VERIFIED ONSITE.

**ELECTRICAL DESIGN GROUP**  
ELECTRICAL BUILDING SERVICES CONSULTANTS  
BRISBANE GOLD COAST

P.O. Box 15, Sherwood Q.4075  
Phone: (07) 3278 4375  
Email: brisbane@edg.net.au  
Web: www.edg.net.au

PROJECT:  
**KINGS CHRISTIAN COLLEGE PIMPAMA  
SENIOR SCHOOL ADMINISTRATION - PIM21**

198 PIMPAMA JACOBS WELL ROAD, PIMPAMA, QUEENSLAND

A	PRELIMINARY	04/02/2026
REV:	DESCRIPTION:	DATE:

DRAWING: <b>ELECTRICAL SERVICES LEVEL 2 FLOOR PLAN &amp; REFLECTED CEILING PLAN</b>	PROJECT NO: <b>C3475a</b>	DRAWING NO: <b>E07</b>	REVISION: <b>A</b>
SCALE: 1:100 UNO	AT A1		