


LEVEL 1
FLOOR PLAN
SCALE 1: 100

ELECTRICAL LAYOUT PENDING RECEIPT OF ELEVATION

DETAIL A
STAFF KITCHENETTE ELEVATION
SCALE 1: 50

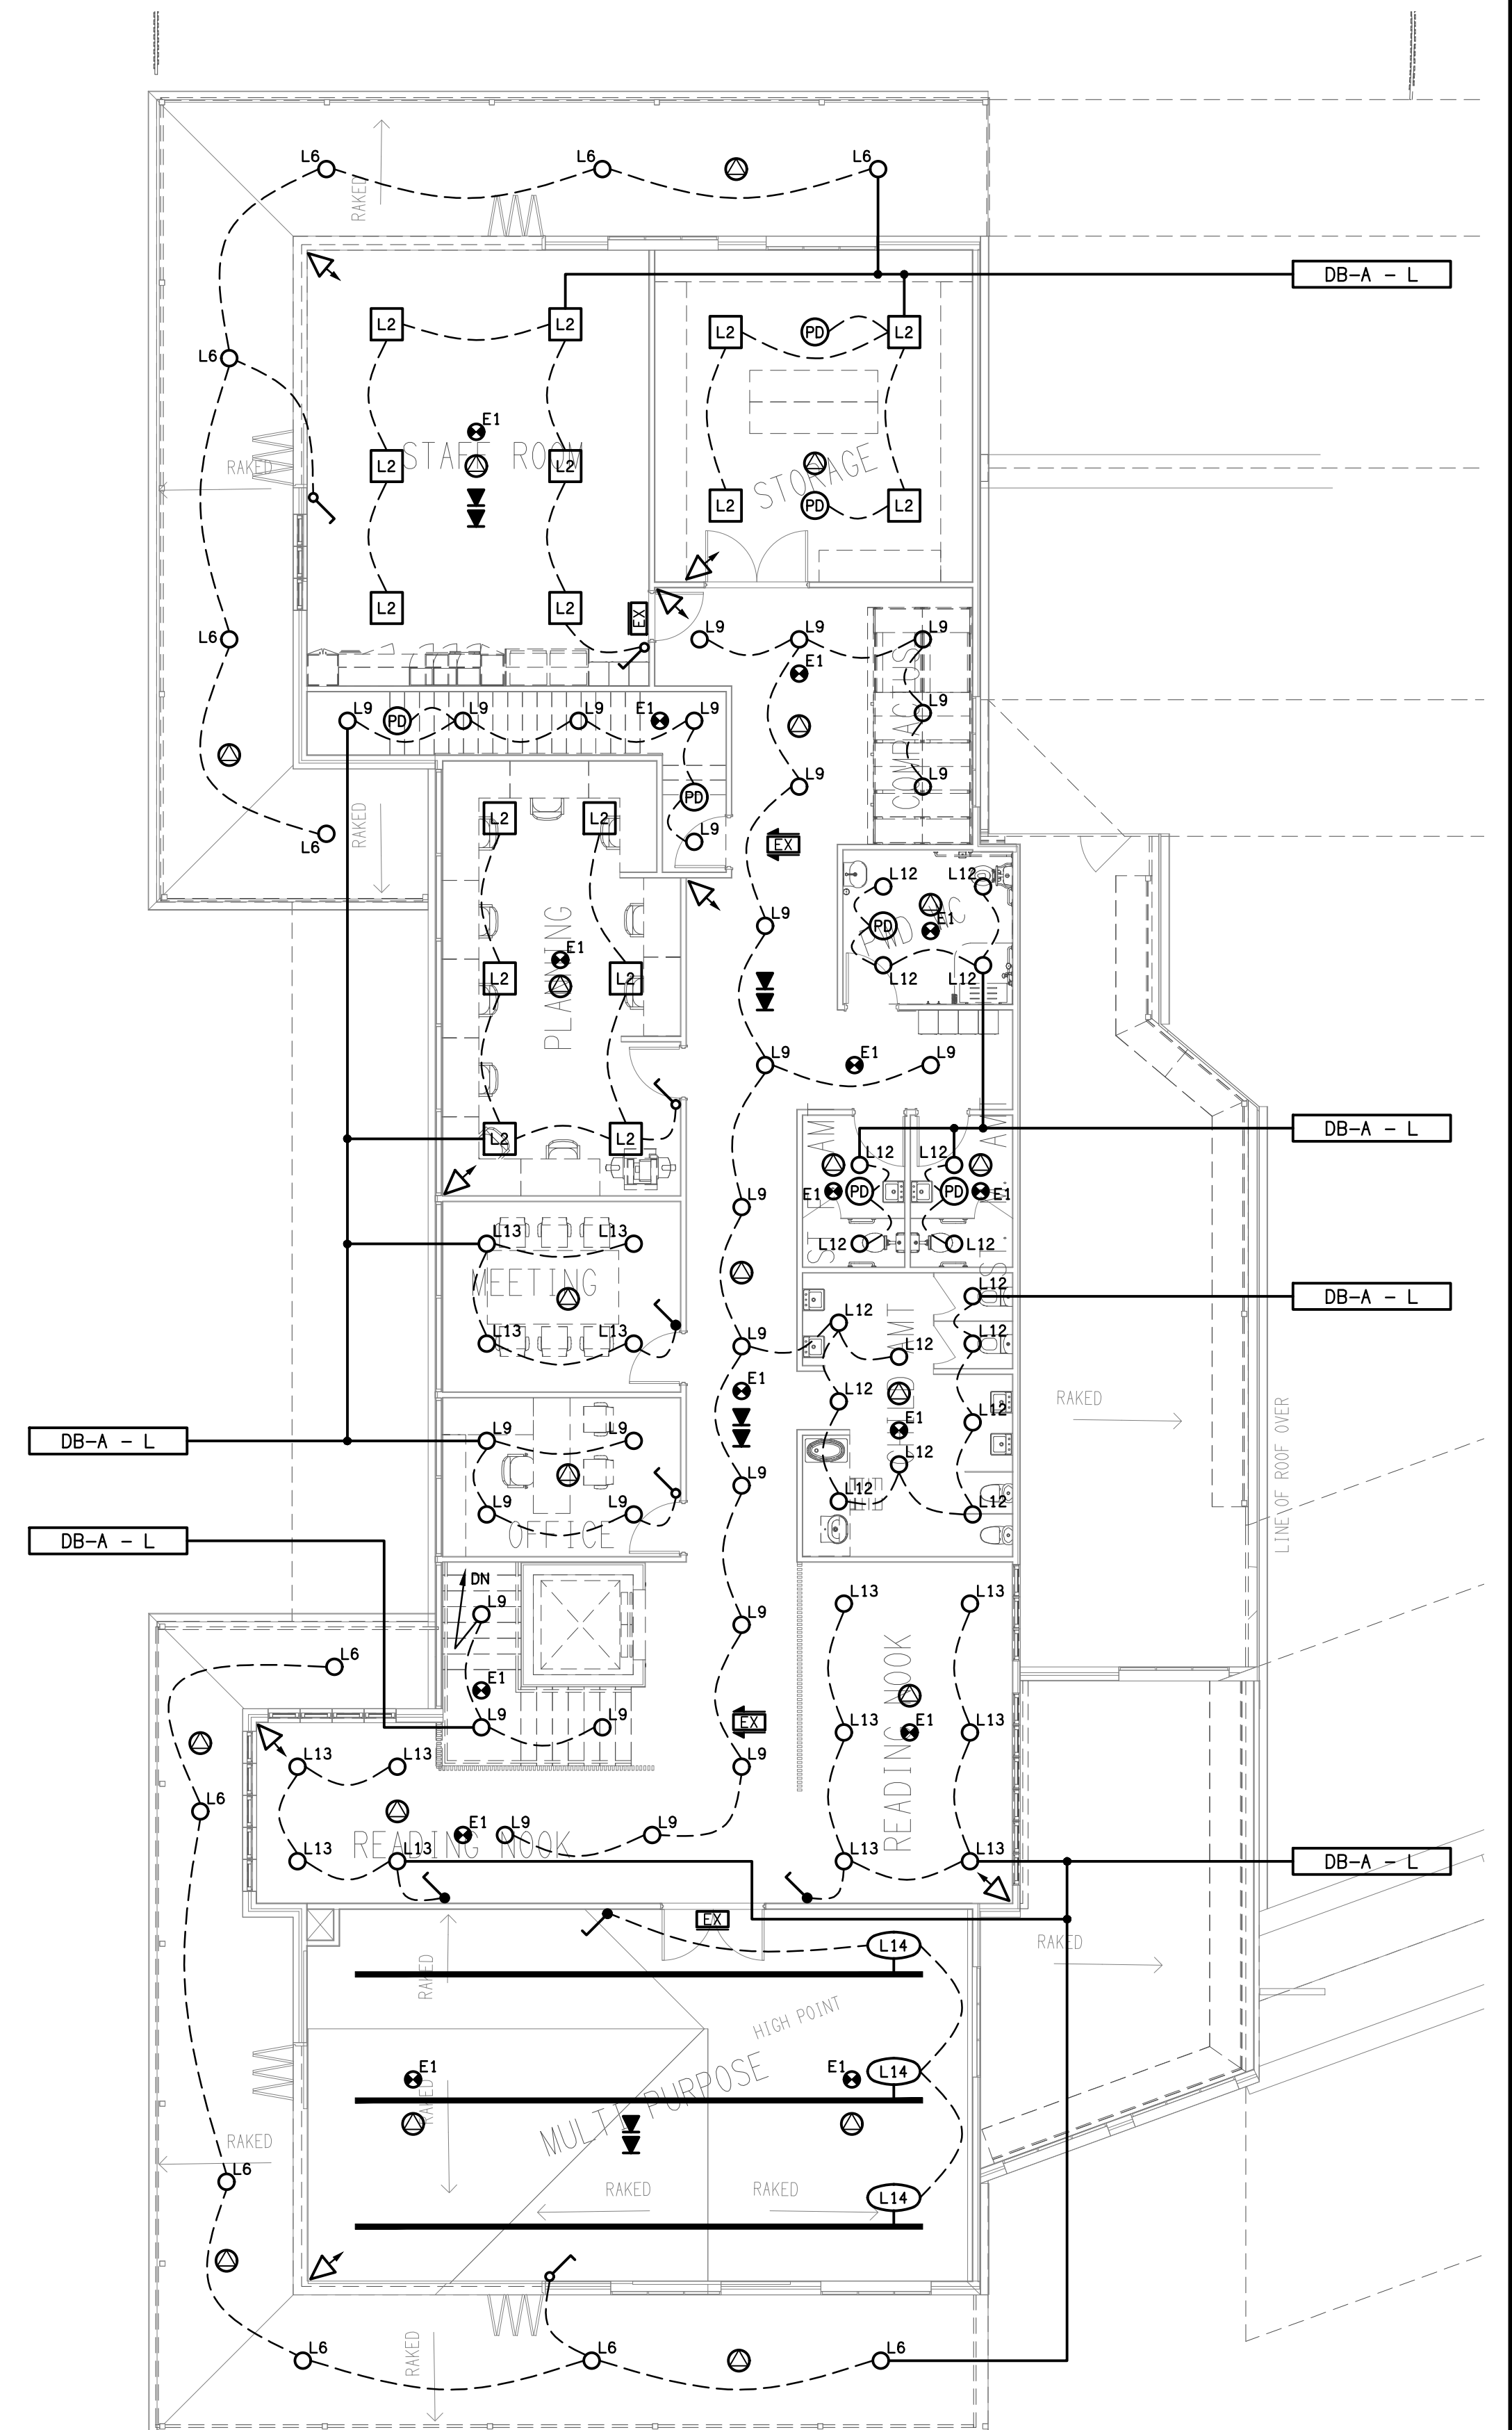

LEVEL 1
REFLECTED CEILING PLAN
SCALE 1: 100

ELECTRICAL DESIGN GROUP BRISBANE
PTY LTD
ACN 092 710 793
TRADING AS:
ELECTRICAL DESIGN GROUP

THE COPYRIGHT OF THIS DRAWING
REMAINS THE PROPERTY OF THE
ELECTRICAL DESIGN GROUP.
USE FIGURED DIMENSIONS
IN PREFERENCE TO SCALE.
ALL DIMENSIONS TO BE
VERIFIED ONSITE.

ELECTRICAL DESIGN GROUP
ELECTRICAL BUILDING SERVICES CONSULTANTS
BRISBANE GOLD COAST

P.O.Box 15, Sherwood Q.4075
Phone: (07) 3278 4375
Email: brisbane@edg.net.au
Web: www.edg.net.au

PROJECT:
**ORMISTON COLLEGE
EARLY LEARNING CENTRE**

168 DUNDAS STREET WEST, ORMISTON

A	PRELIMINARY	02/03/2026
REV:	DESCRIPTION:	DATE:

DRAWING:
**ELECTRICAL SERVICES
LEVEL 1 PLANS**

SCALE:
1:100 AT A1
PROJECT NO:
C3514a
DRAWING NO:
E06
REVISION:
A