
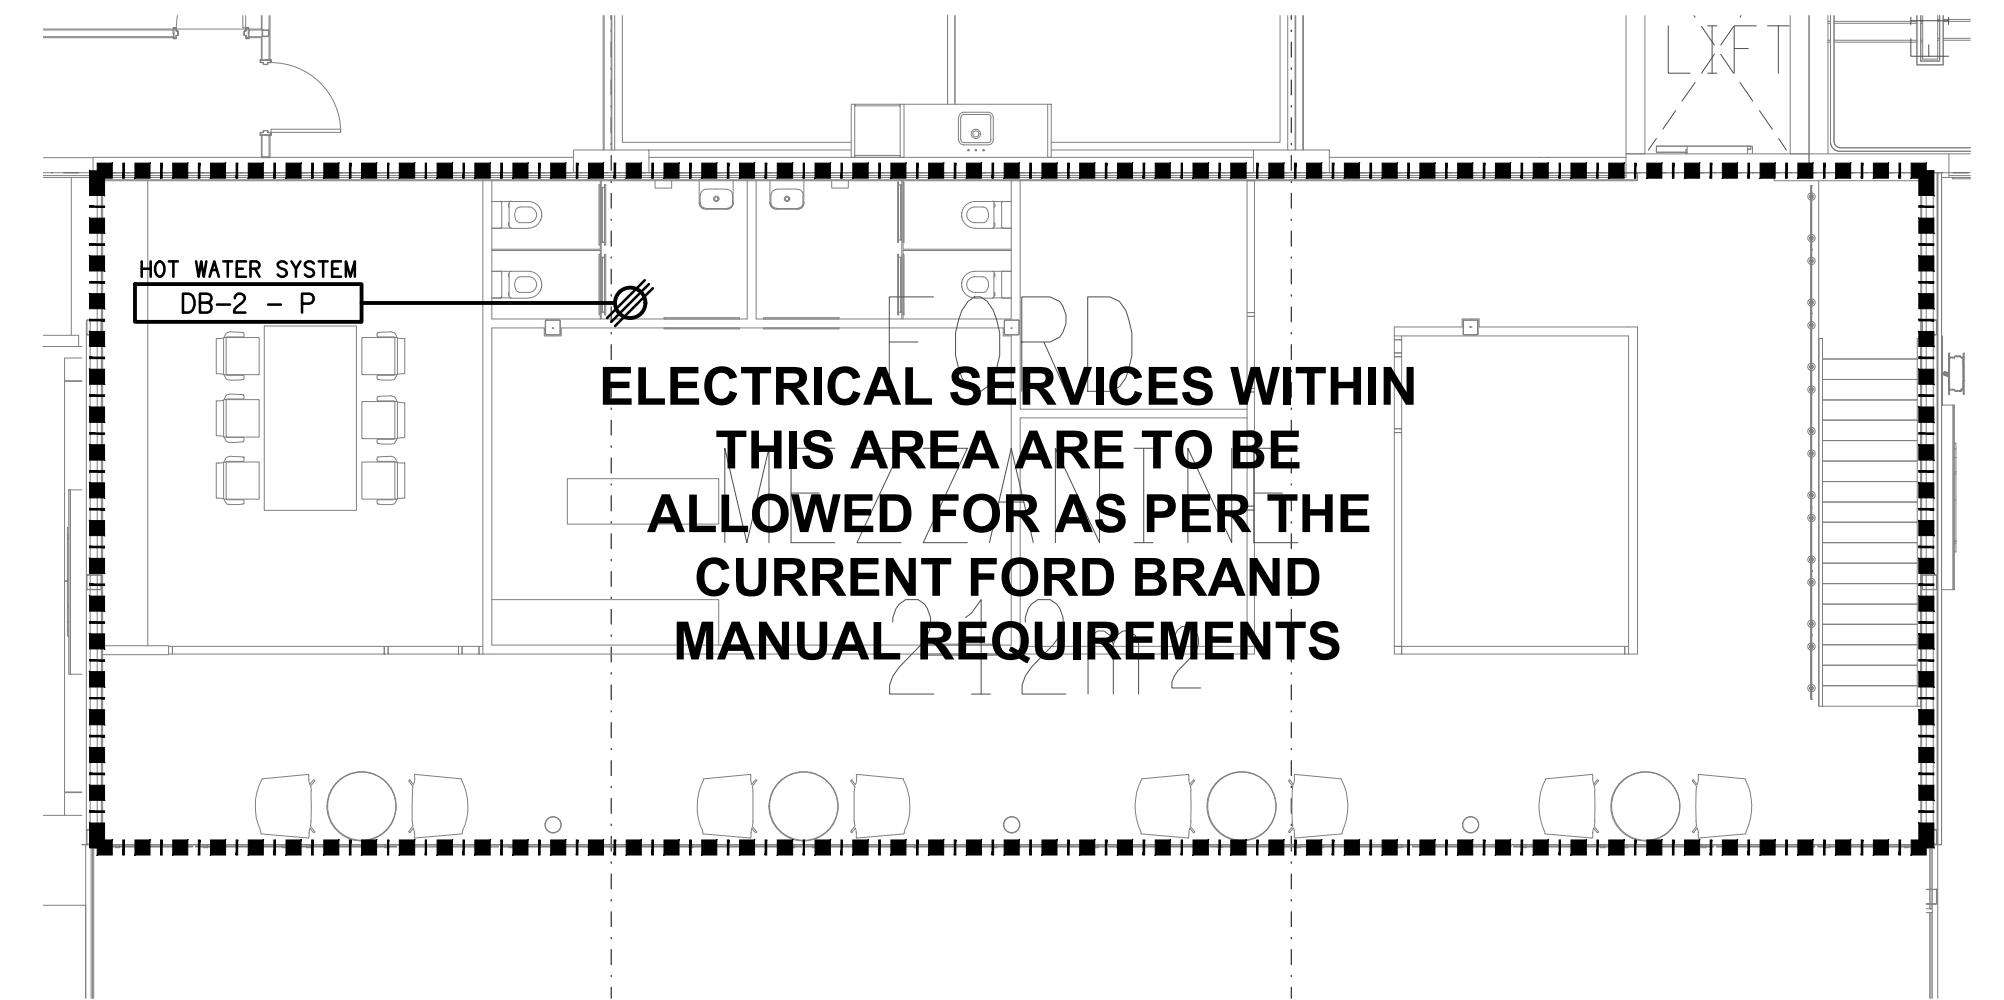


FOR CONTINUATION REFER TO STAGE 1 PART B FLOOR PLAN ON DRAWING E105

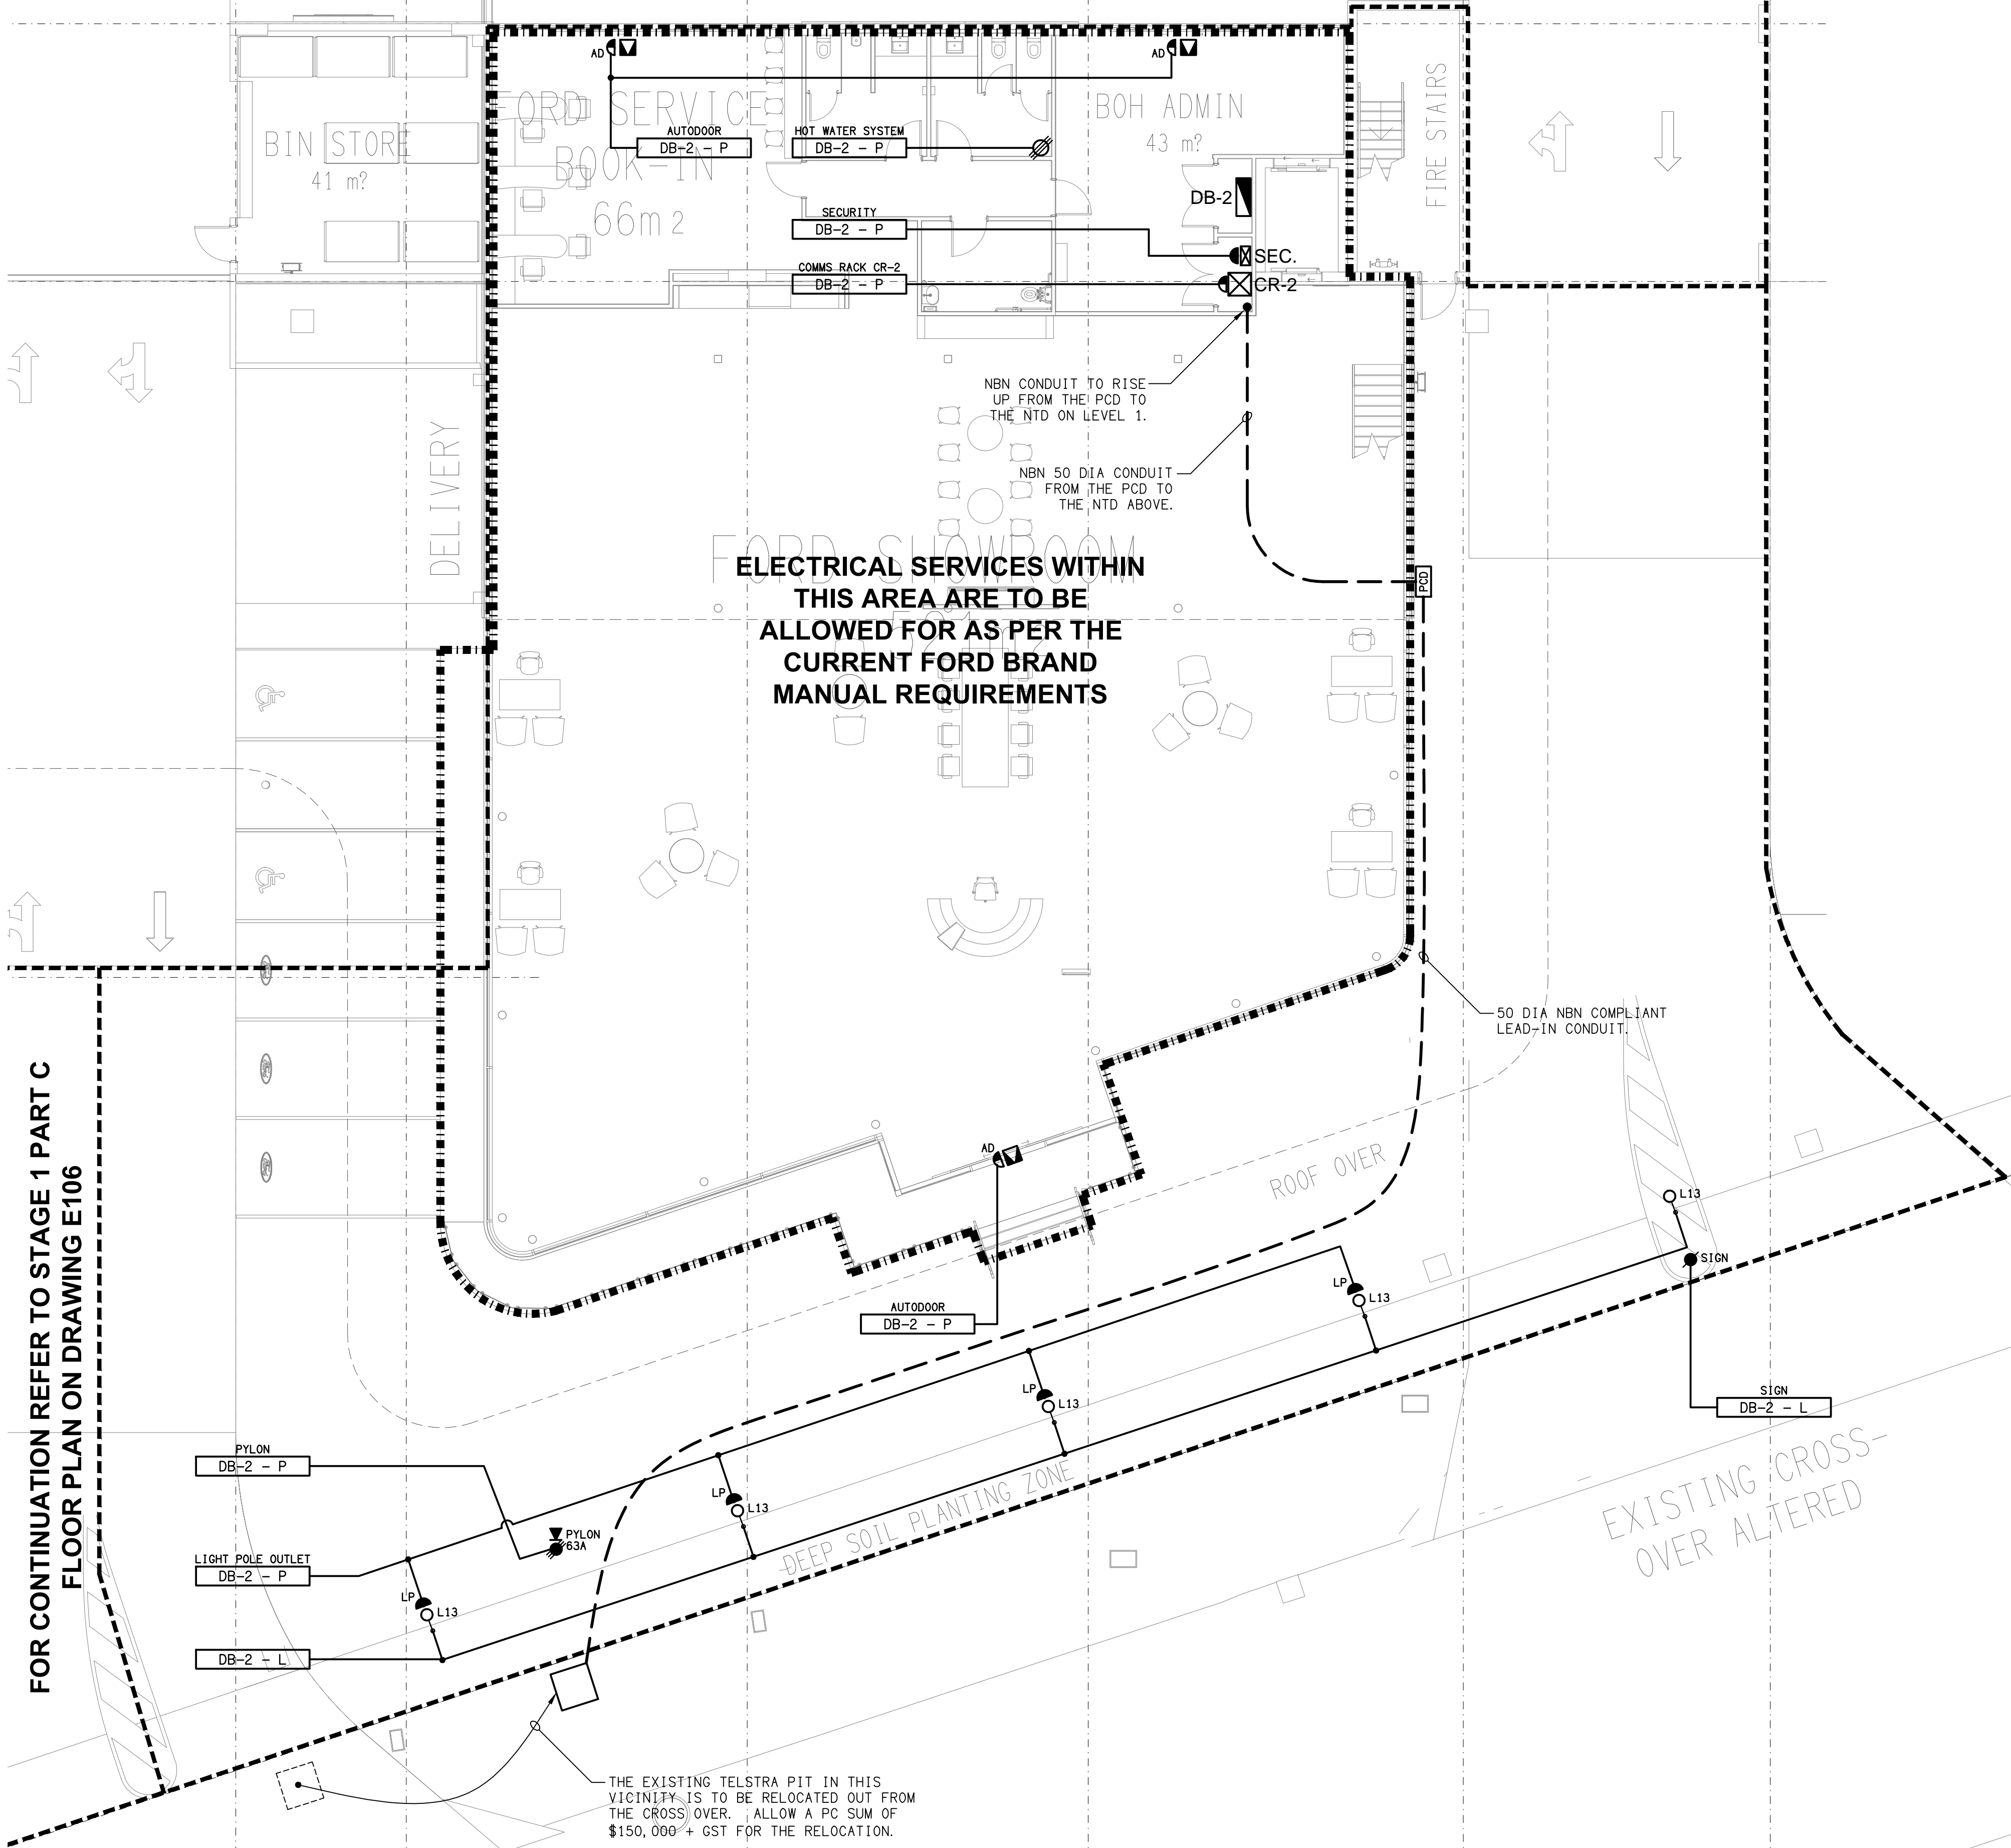

MEZZANINE LEVEL
FORD SHOWROOM
SCALE 1:100

FOR CONTINUATION REFER TO STAGE 1 PART C
FLOOR PLAN ON DRAWING E106

ELECTRICAL DESIGN GROUP BRISBANE
PTY LTD
ACN 092 710 793
TRADING AS:
ELECTRICAL DESIGN GROUP

THE COPYRIGHT OF THIS DRAWING
REMAINS THE PROPERTY OF THE
ELECTRICAL DESIGN GROUP.
USE FIGURED DIMENSIONS
IN PREFERENCE TO SCALE.
ALL DIMENSIONS TO BE
VERIFIED ONSITE.

ELECTRICAL DESIGN GROUP
ELECTRICAL BUILDING SERVICES CONSULTANTS
BRISBANE GOLD COAST
P.O.Box 15, Sherwood Q.4075
Phone: (07) 3278 4375
Email: brisbane@edg.net.au
Web: www.edg.net.au

PROJECT:
EAGERS 151 SANDGATE ROAD, ALBION
BRISBANE, QUEENSLAND

A	TENDER	13/11/2025
REV:	DESCRIPTION:	DATE:
DRAWING:	ELECTRICAL SERVICES	
	STAGE 1	
	GROUND LEVEL PART D FLOOR PLAN	
SCALE:	PROJECT NO:	DRAWING NO:
1:100	AT A1	C3531a E107
		REVISION:
		A