


**NOTE:**

REFER TO DRAWING C3540a-E06.dwg & C3540a-E07.dwg FOR  
ADDITIONAL JOINERY & WALL LIGHTING PLANS & DETAILS.

ELECTRICAL CEILING AND WALL  
FITTINGS WITHIN THIS DASH LINED  
AREA ARE TO BE REMOVED,  
UNLESS NOTED OTHERWISE.

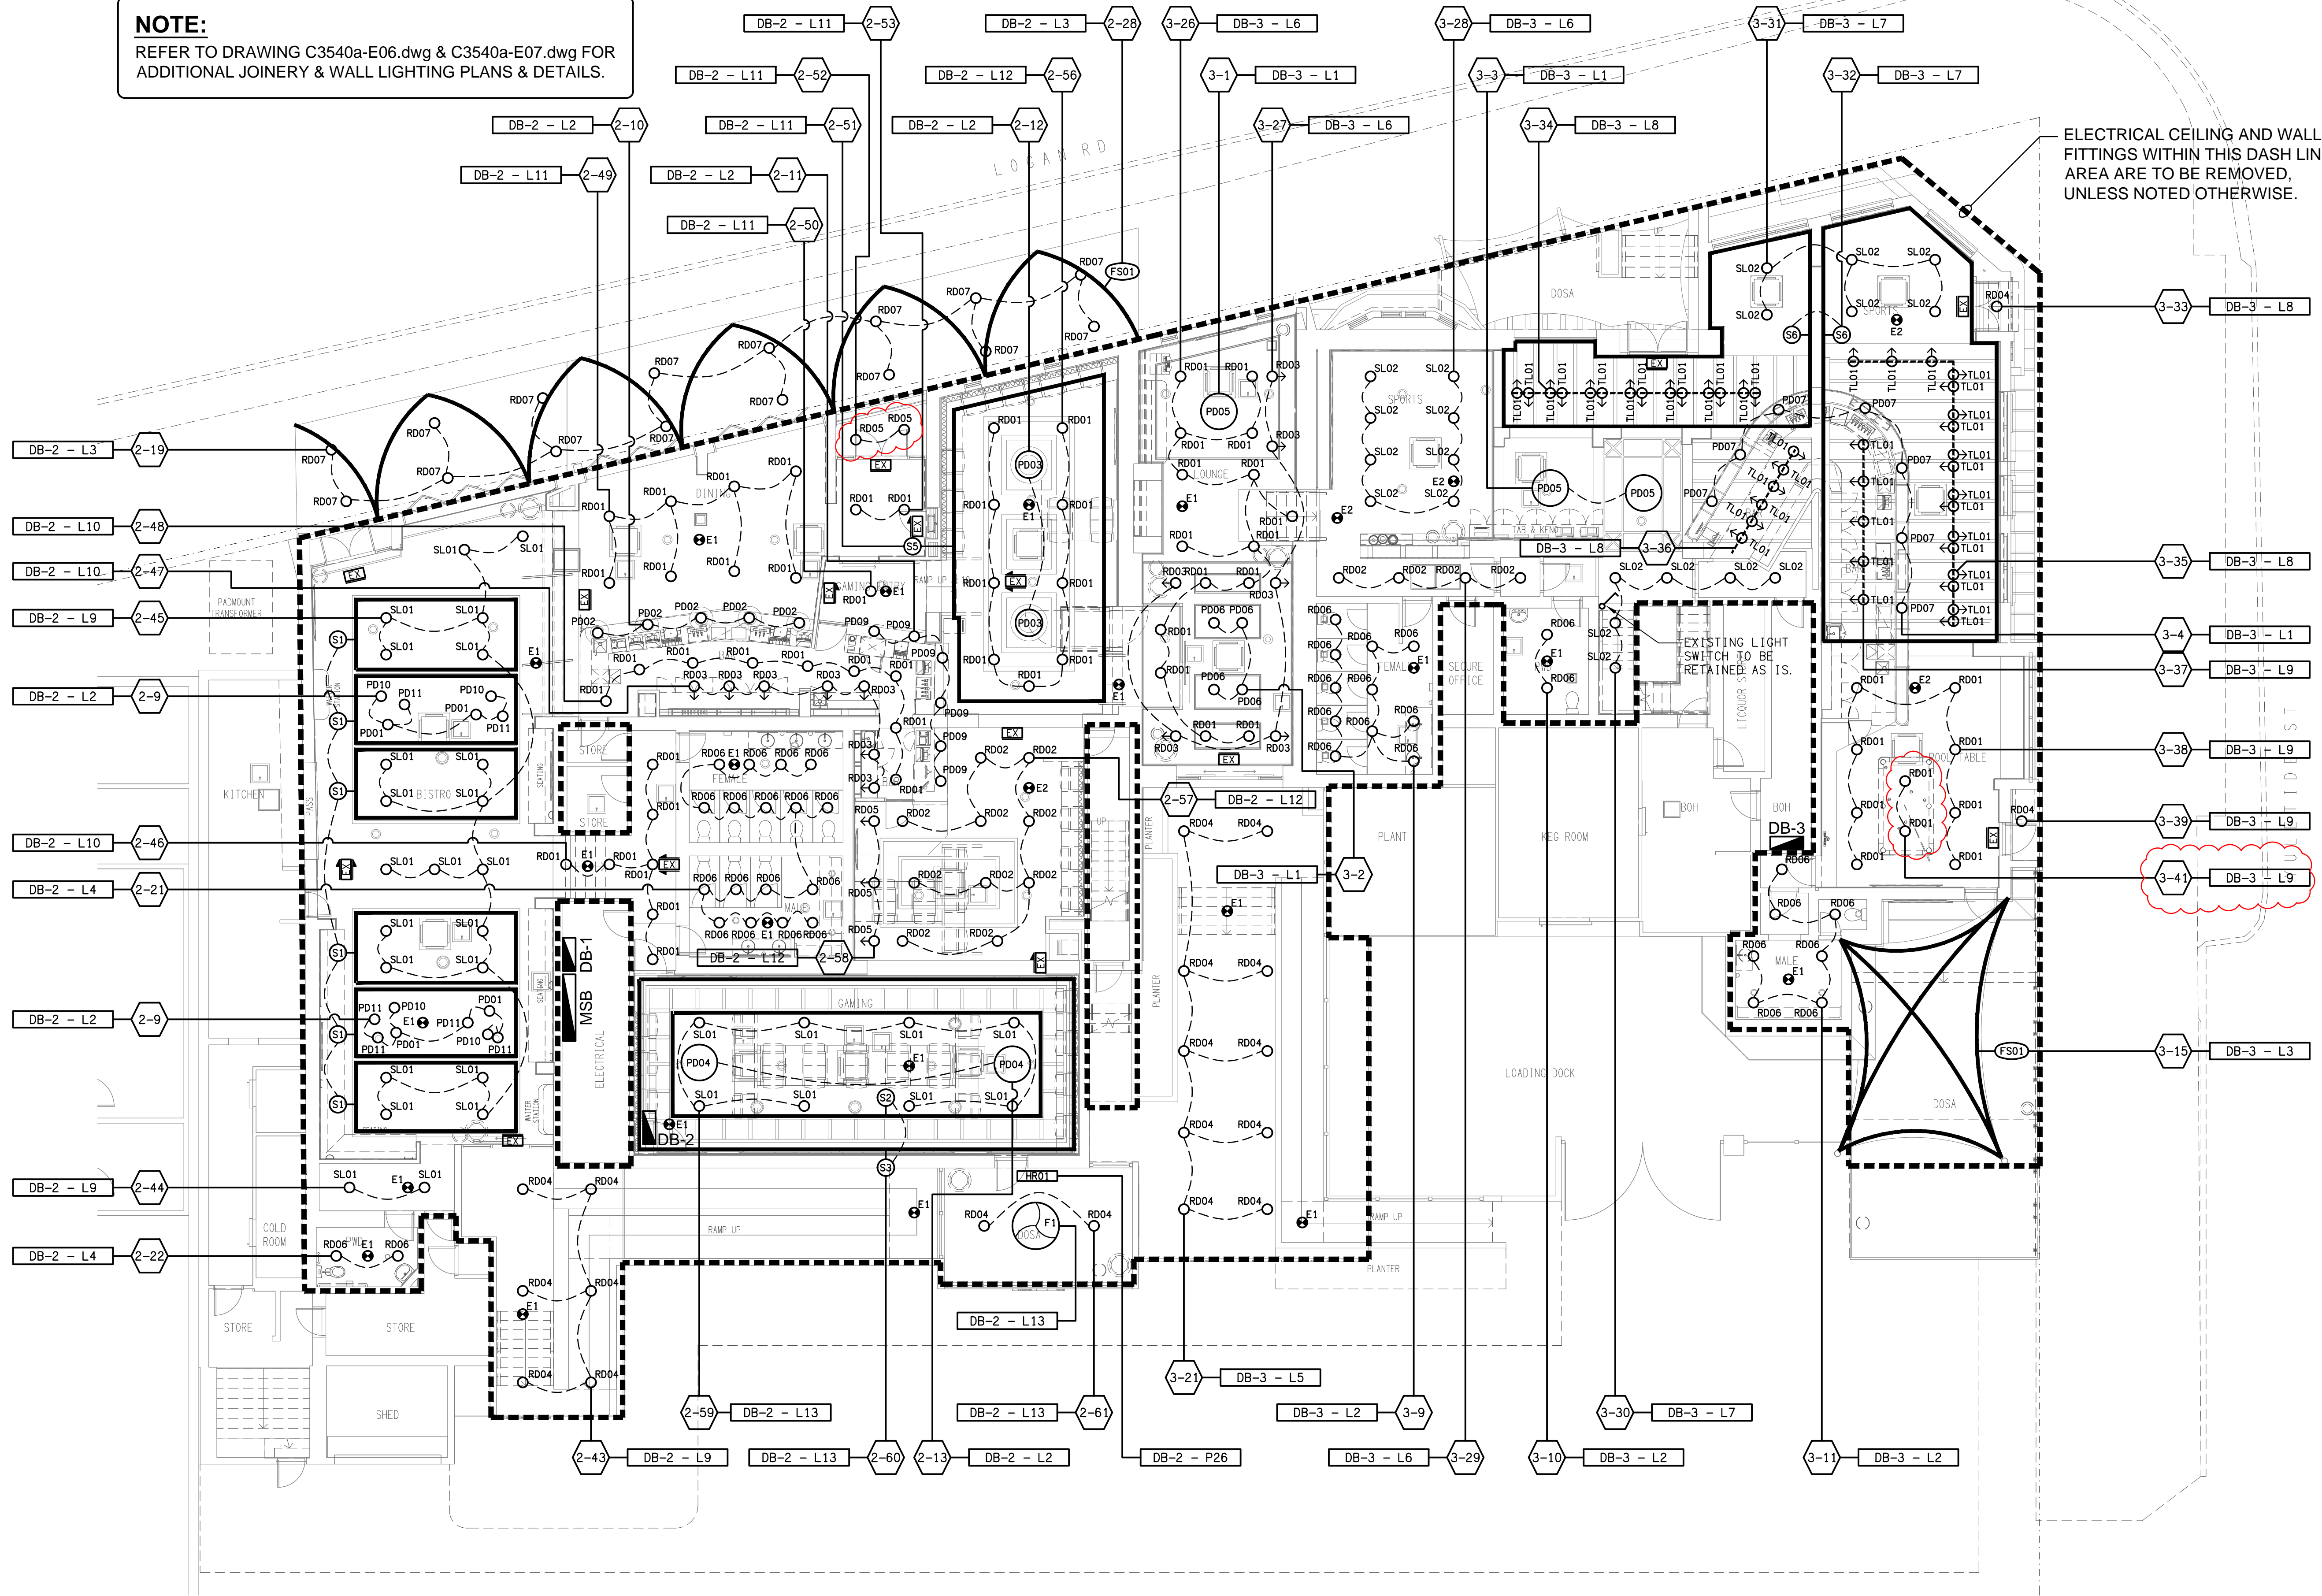

ELECTRICAL DESIGN GROUP BRISBANE  
PTY LTD  
ACN 092 710 793  
TRADING AS:  
ELECTRICAL DESIGN GROUP

THE COPYRIGHT OF THIS DRAWING  
REMAINS THE PROPERTY OF THE  
ELECTRICAL DESIGN GROUP.  
USE FIGURED DIMENSIONS  
IN PREFERENCE TO SCALE.  
ALL DIMENSIONS TO BE  
VERIFIED ONSITE.

**ELECTRICAL DESIGN GROUP**  
ELECTRICAL BUILDING SERVICES CONSULTANTS  
BRISBANE GOLD COAST

P.O. Box 15, Sherwood Q. 4075  
Phone: (07) 3278 4375  
Email: brisbane@edg.net.au  
Web: www.edg.net.au

PROJECT:  
**HOLLAND PARK HOTEL**

945 LOGAN ROAD, HOLLAND PARK

C	CONSTRUCTION	02/10/2025
REV.	DESCRIPTION:	DATE:

DRAWING:  
**ELECTRICAL SERVICES  
REFLECTED CEILING PLAN**

SCALE:  
1:100

AT A1

PROJECT NO:  
**C3540a**

DRAWING NO:  
**E05**

REVISION:  
**C**