


DETAIL A
TYPICAL S17 ELEVATION
SCALE

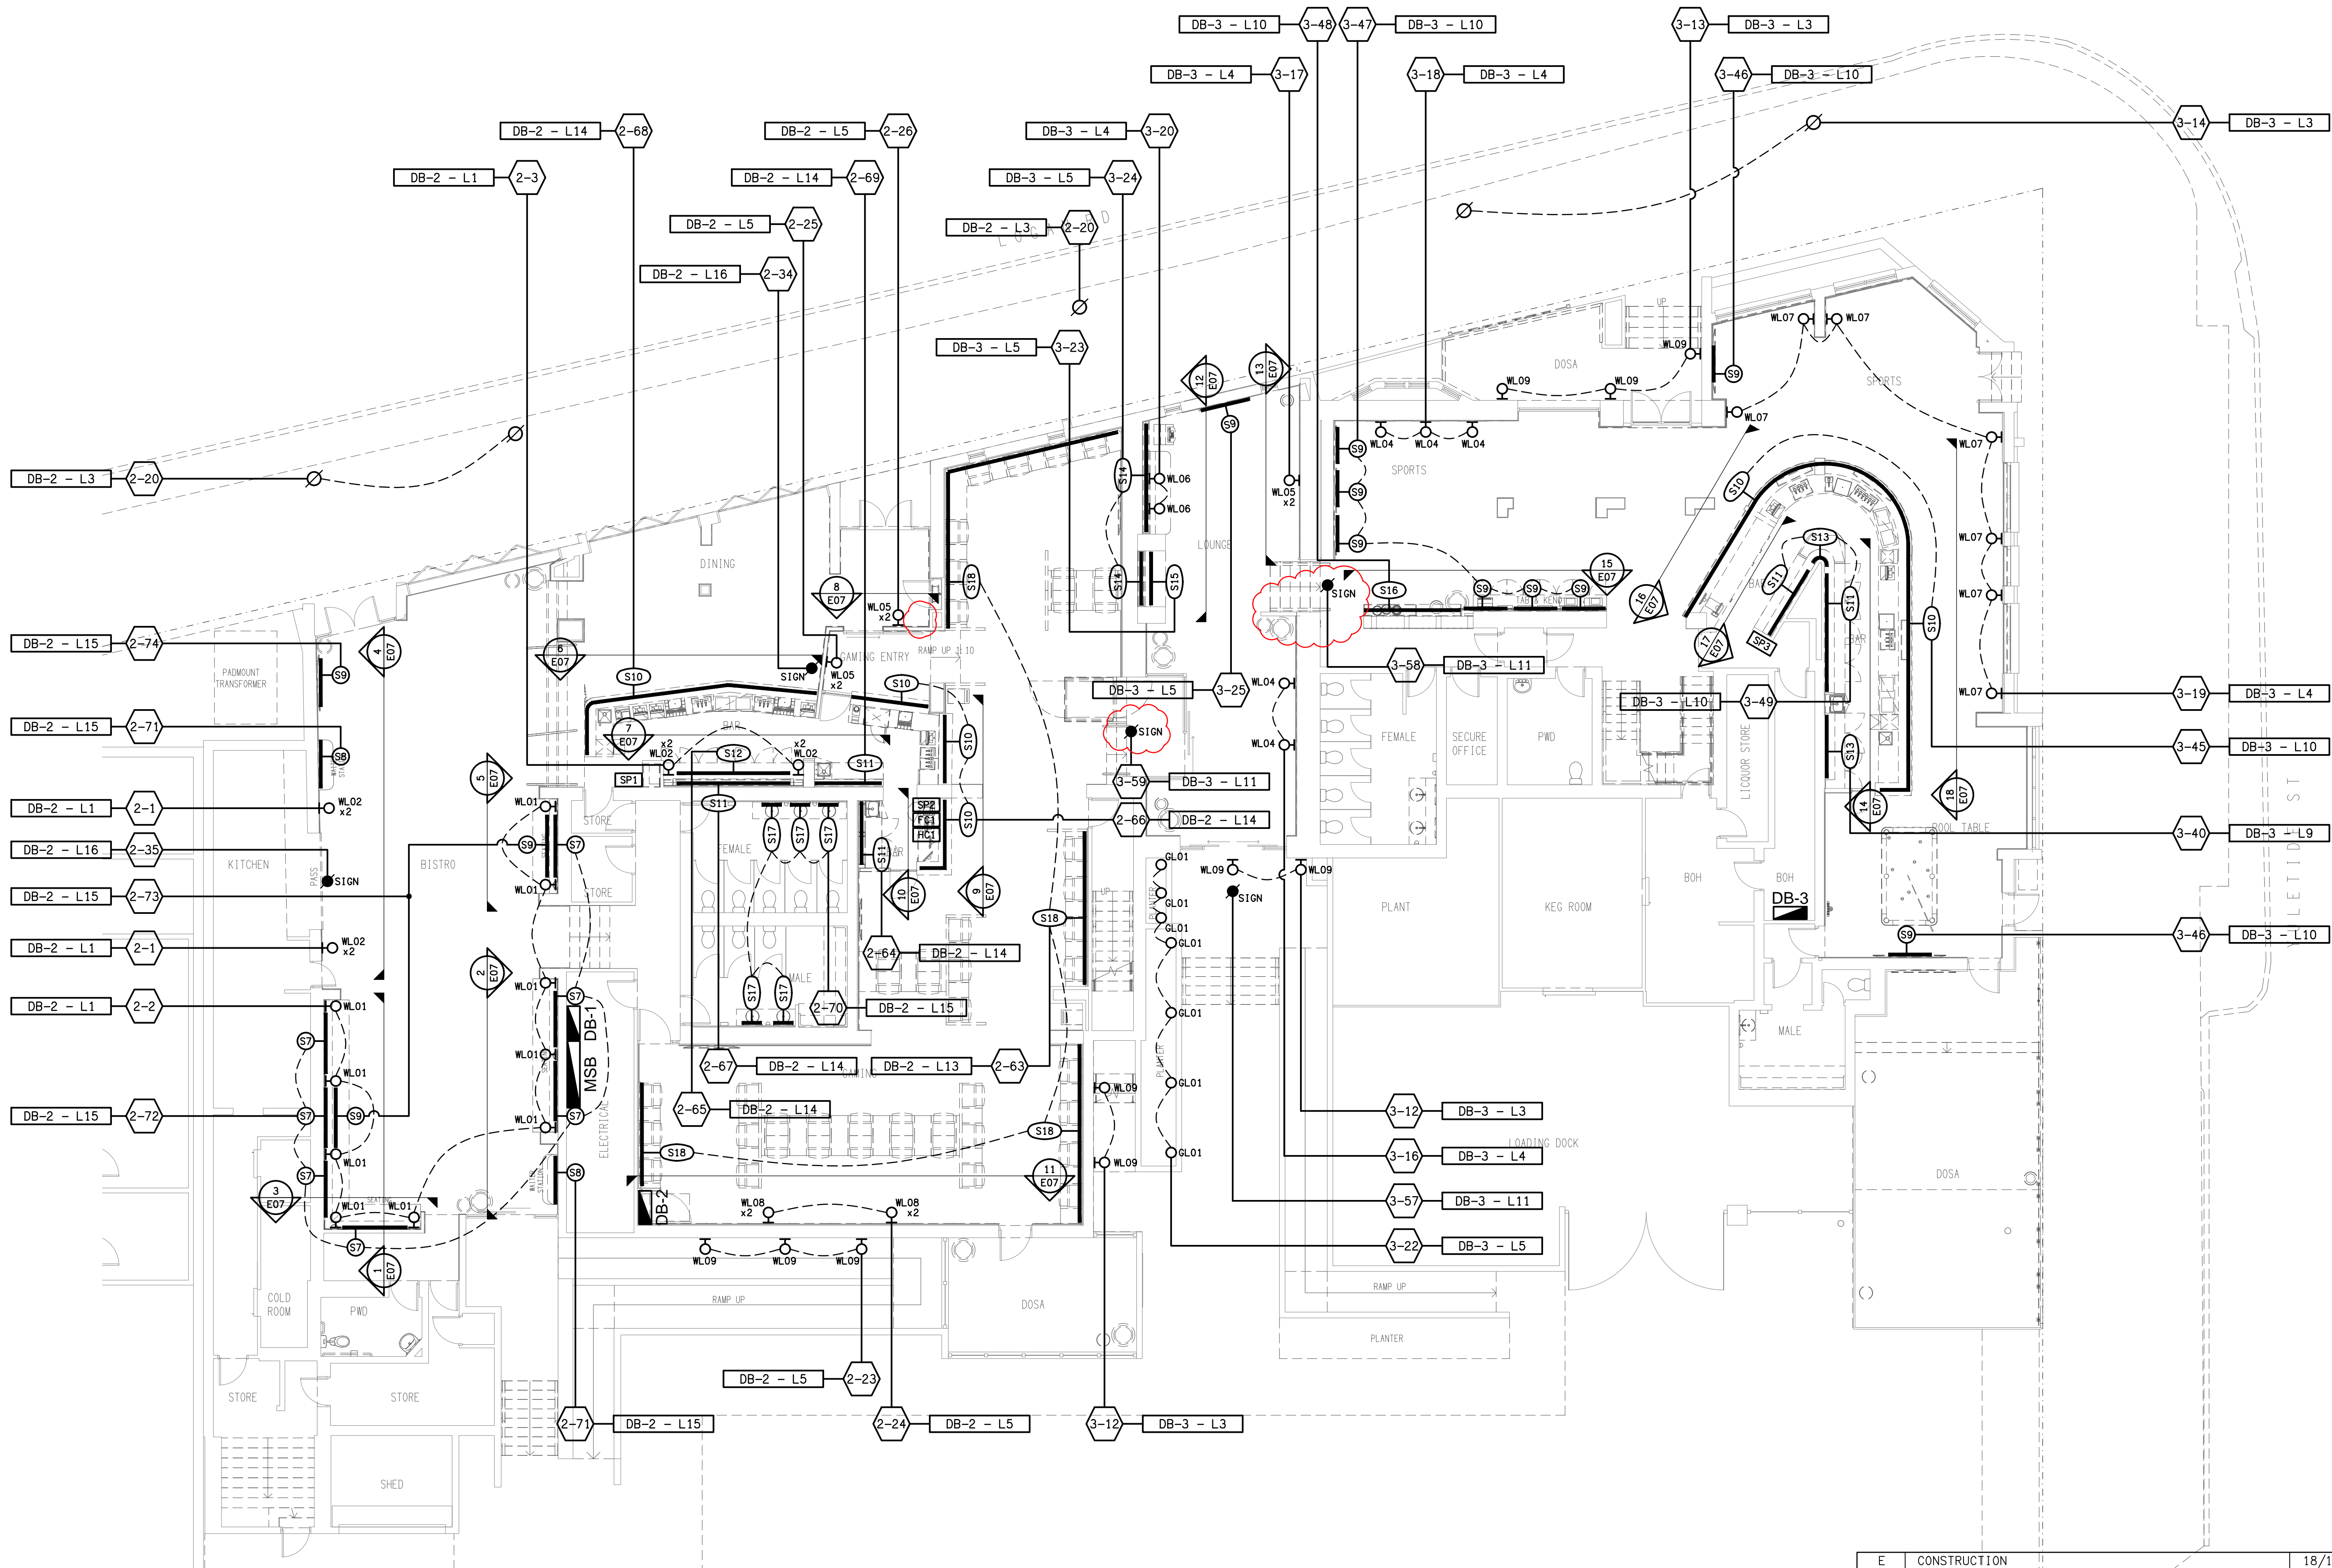

ELECTRICAL DESIGN GROUP BRISBANE
PTY LTD
ACN 092 710 793
TRADING AS:
ELECTRICAL DESIGN GROUP

THE COPYRIGHT OF THIS DRAWING
REMAINS THE PROPERTY OF THE
ELECTRICAL DESIGN GROUP.
USE FIGURED DIMENSIONS
IN PREFERENCE TO SCALE.
ALL DIMENSIONS TO BE
VERIFIED ONSITE.

ELECTRICAL DESIGN GROUP
ELECTRICAL BUILDING SERVICES CONSULTANTS
BRISBANE GOLD COAST

P.O.Box 15, Sherwood Q.4075
Phone: (07) 3278 4375
Email: brisbane@edg.net.au
Web: www.edg.net.au

PROJECT:
HOLLAND PARK HOTEL

945 LOGAN ROAD, HOLLAND PARK

REV.	DESCRIPTION:	DATE:
E	CONSTRUCTION	18/11/2025

DRAWING:
**ELECTRICAL SERVICES
JOINERY & WALL LIGHTING PLAN**

SCALE: 1:100	AT A1	PROJECT NO: C3540a	DRAWING NO: E06	REVISION: E
-----------------	-------	------------------------------	---------------------------	-----------------------