

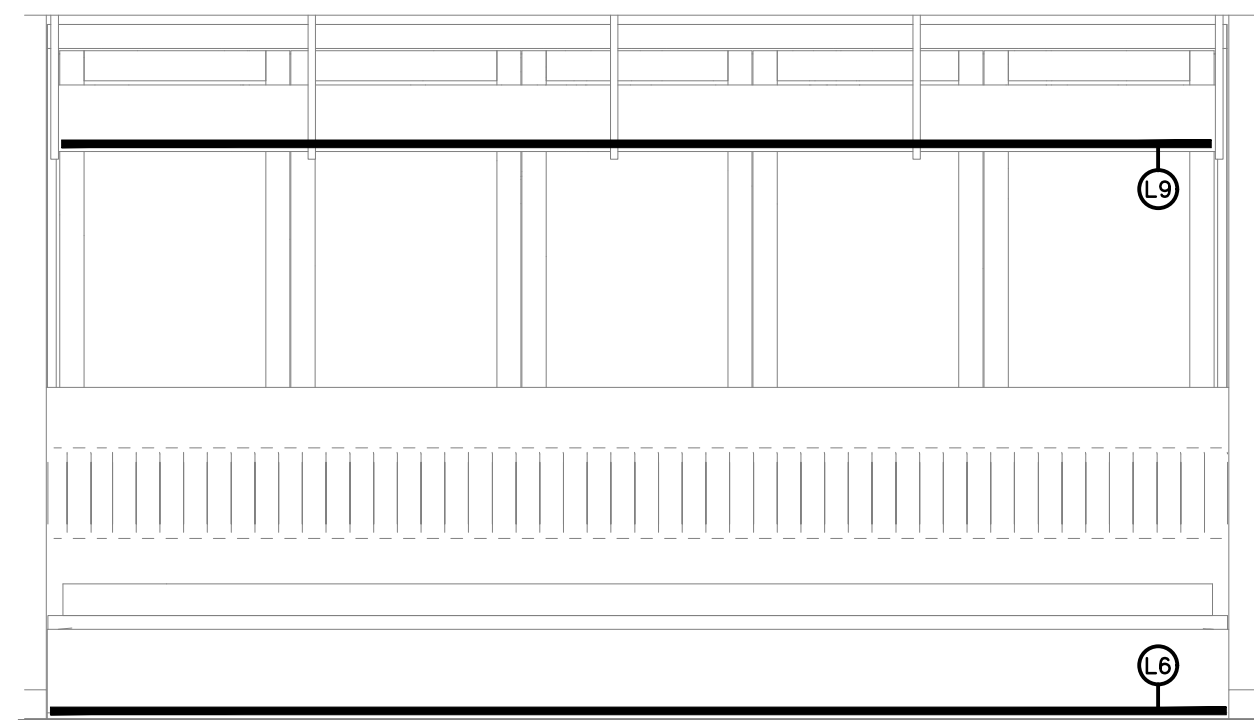


NOTE:
BK - OUTLETS ARE TO HAVE BLACK FACEPLATES
GD - OUTLETS ARE TO HAVE GOLD FACEPLATES.


BOTH THE BLACK (BK) AND GOLD (GD) NOTED
OUTLETS ARE TO HAVE THEIR POSITIONS
CONFIRMED WITH THE ARCHITECT ON SITE.

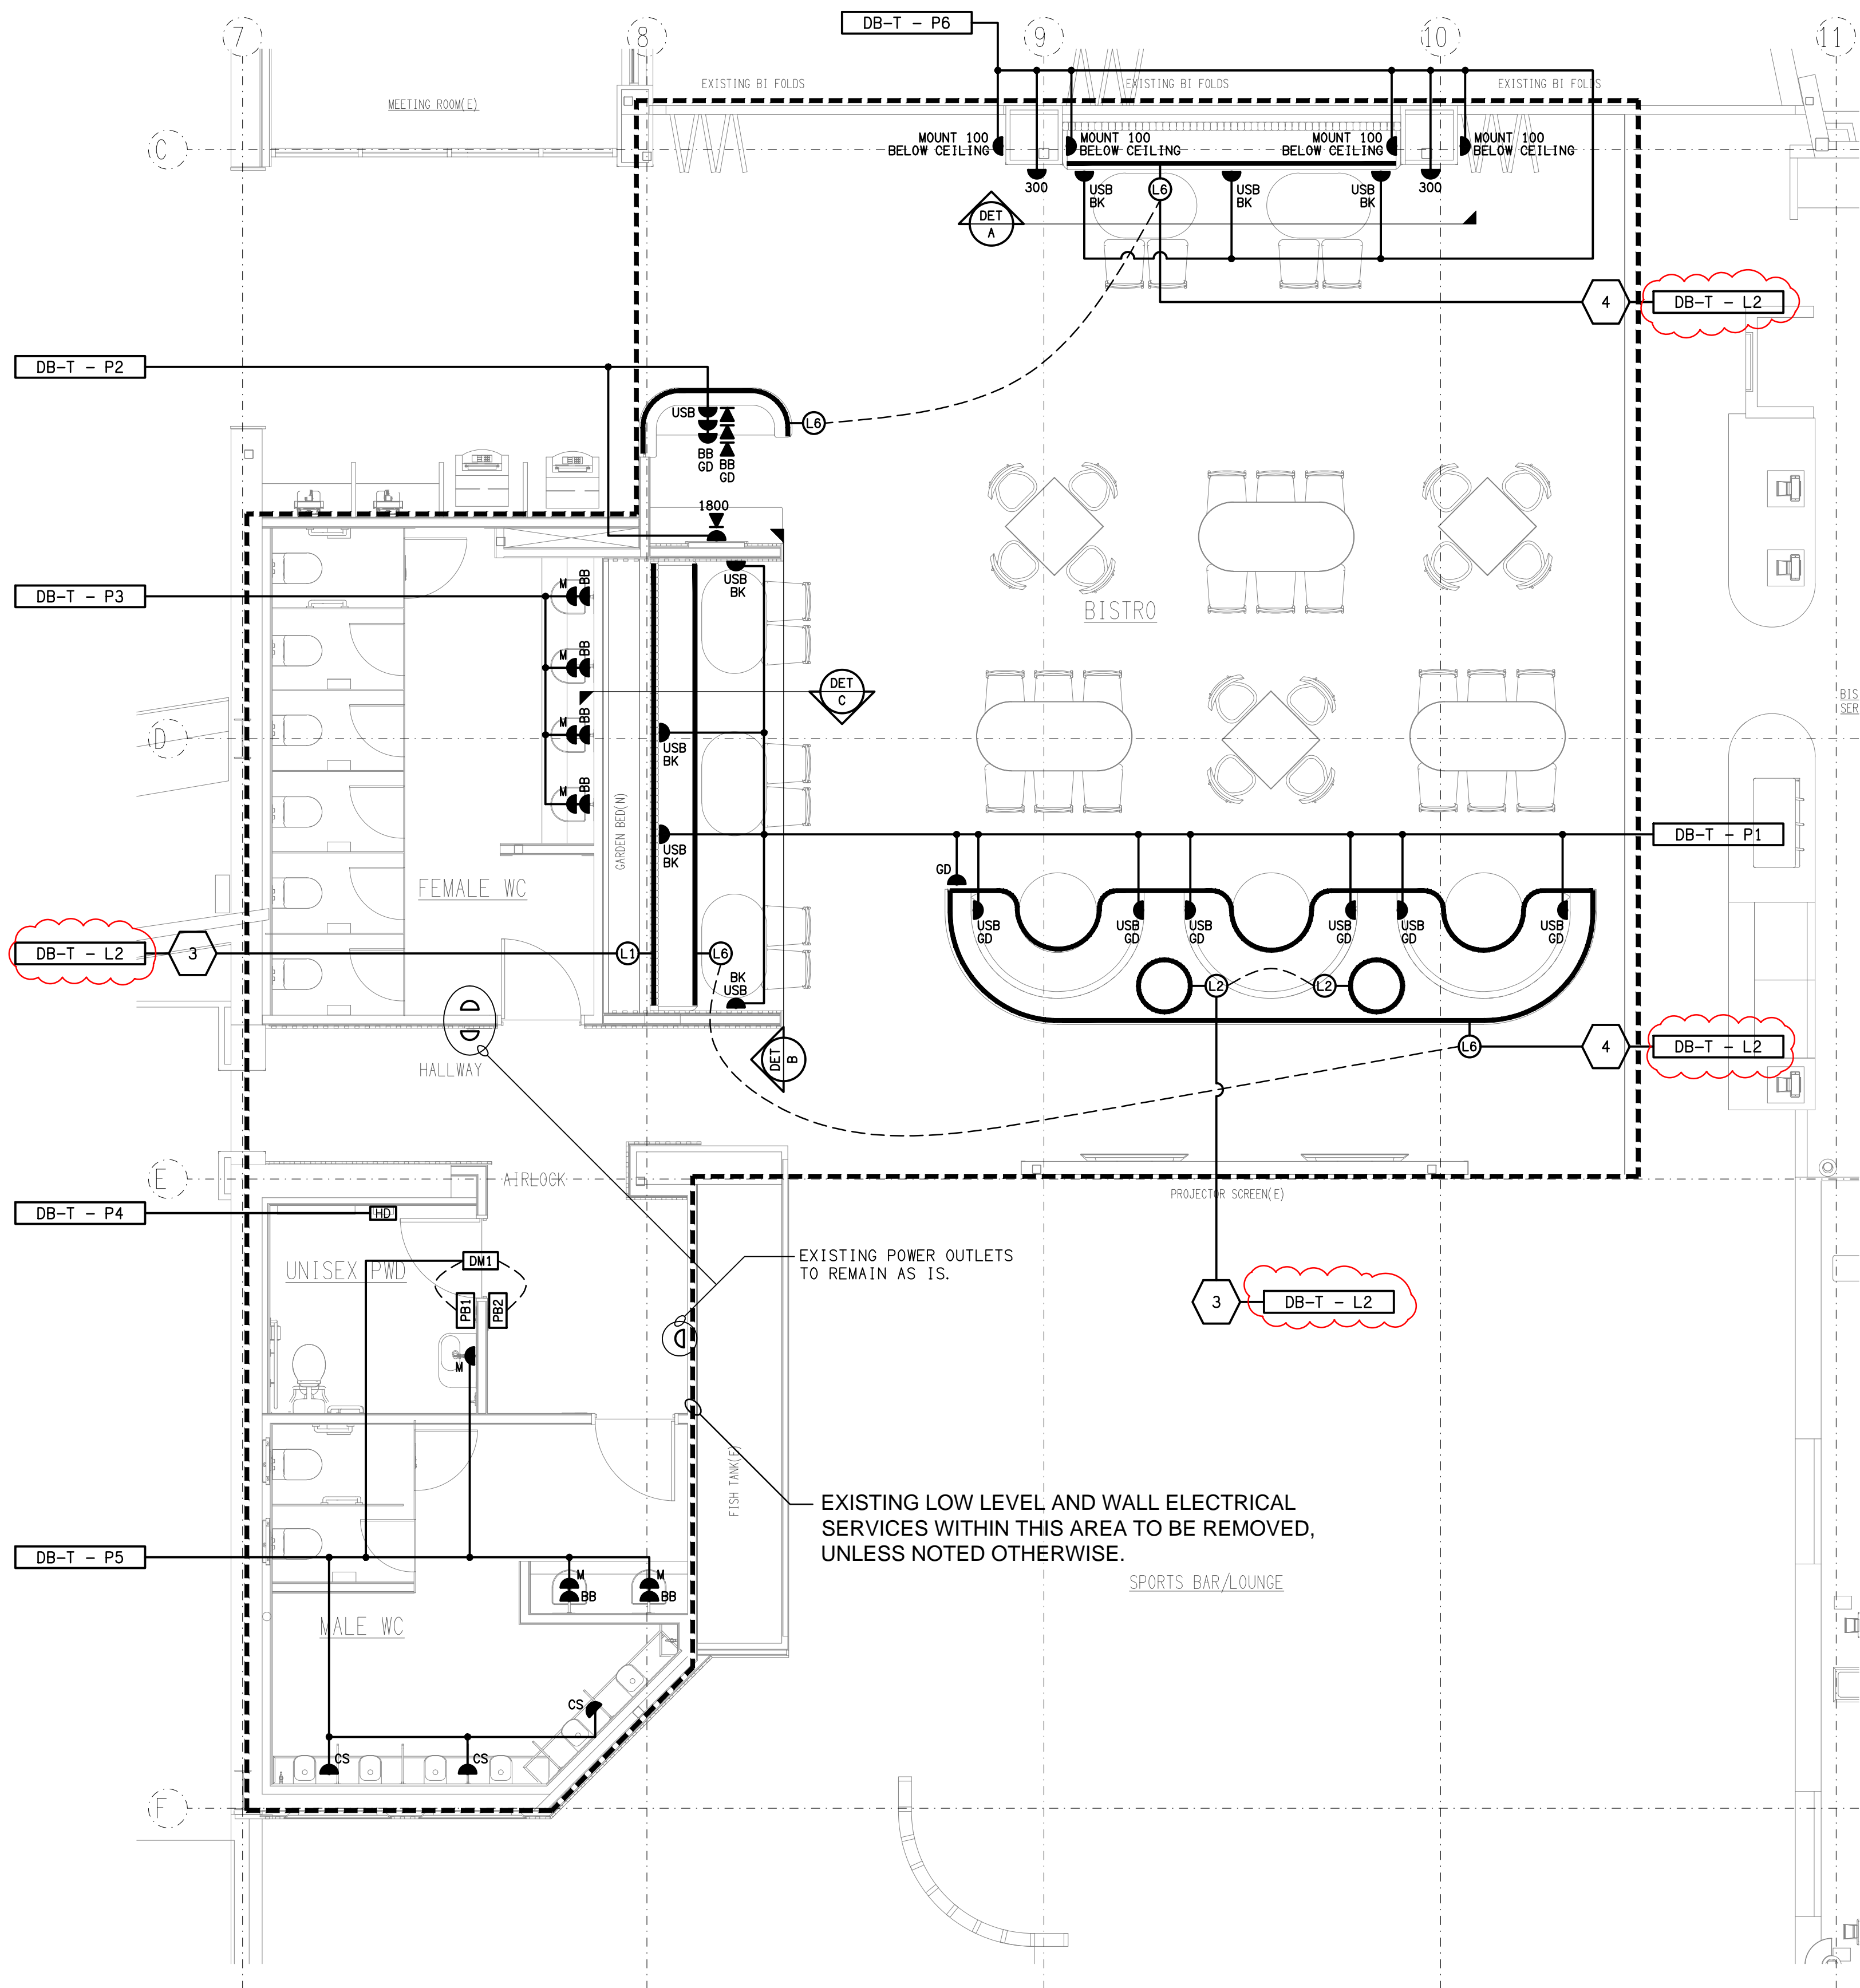

DETAIL A
SEAT SKIRTING LED STRIP LIGHT ELEVATION
SCALE 1: 25

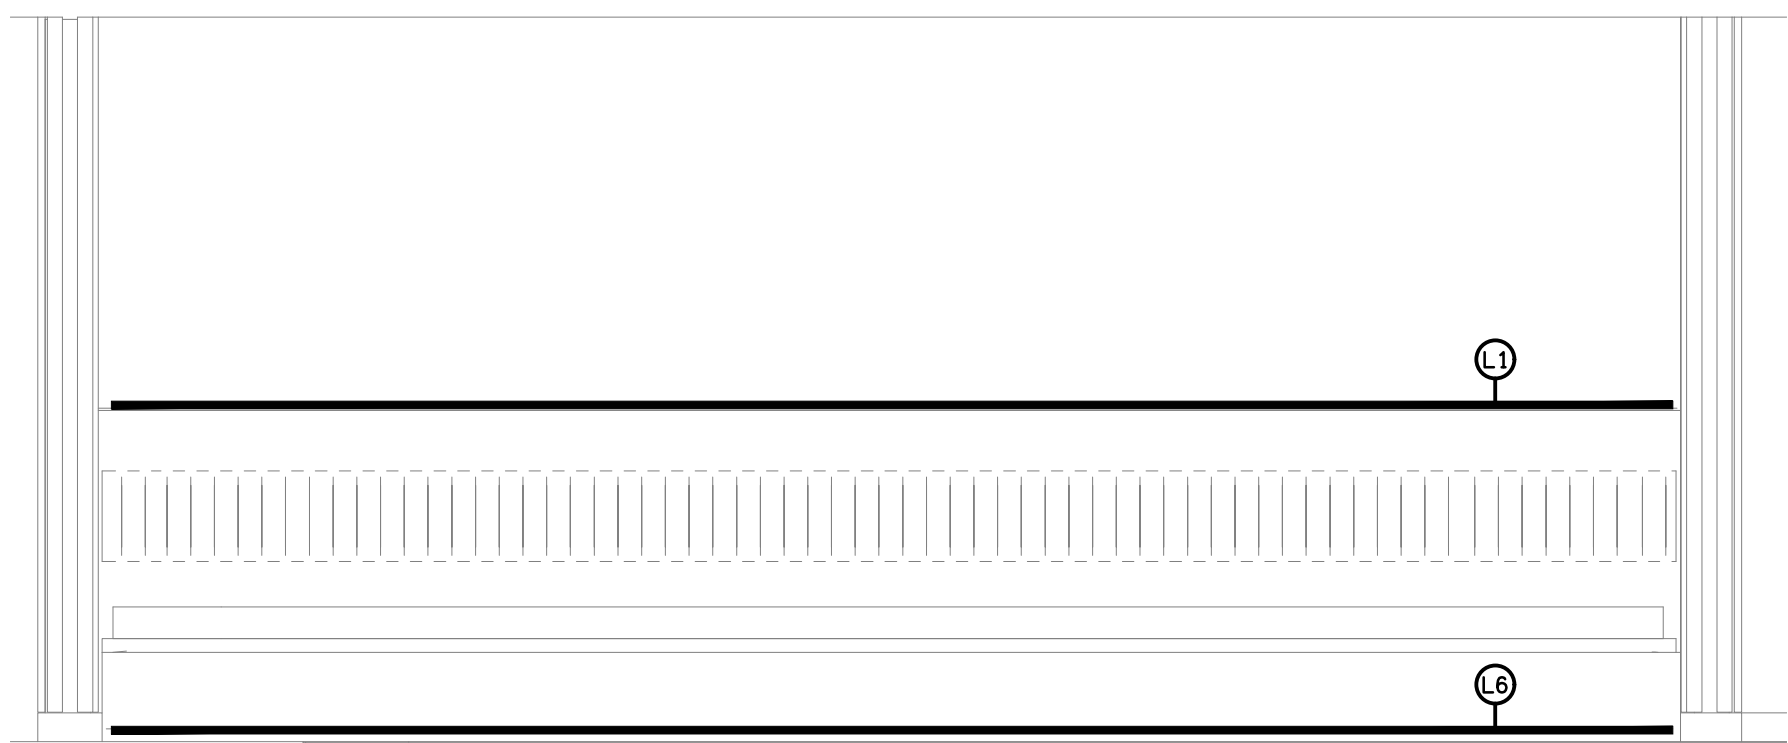

DETAIL B
SEAT LED STRIP LIGHT ELEVATION
SCALE 1: 25

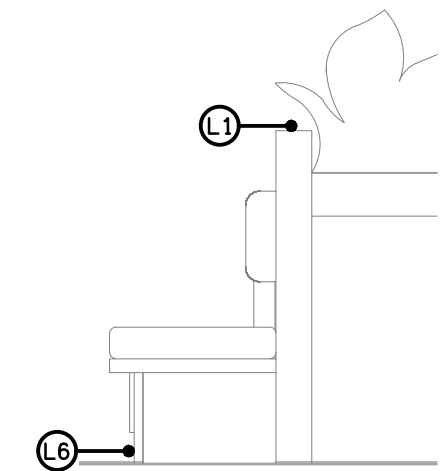

DETAIL C
SEAT LED STRIP LIGHT SECTION
SCALE 1: 25

THE COPYRIGHT OF THIS DRAWING REMAINS THE PROPERTY OF
THE ELECTRICAL DESIGN GROUP.

USE FIGURED DIMENSIONS IN PREFERENCE TO SCALE.

ALL DIMENSIONS TO BE VERIFIED ONSITE.

H	CONSTRUCTION	14/08/2025
REV.	DESCRIPTION:	DATE:

ELECTRICAL DESIGN GROUP
ELECTRICAL BUILDING SERVICES CONSULTANTS

BRISBANE: P.O. Box 15, Sherwood Qld 4075
Phone: (07) 3278 4375
Email: brisbane@edg.net.au
Web: www.edg.net.au

ELECTRICAL DESIGN GROUP BRISBANE PTY LTD
ACN 092 710 793

TRADING AS:
ELECTRICAL DESIGN
GROUP

PROJECT:
**BLUE FIN FISHING CLUB
INALA - STAGE 2**

SITE ADDRESS:
**24 LILAC STREET, INALA
QUEENSLAND**

SCALE: 1:50 UNO SHEET SIZE: A1
AT

DRAWING TITLE:
**ELECTRICAL SERVICES
FLOOR PLAN**

PROJECT NO: DRAWING NO: REVISION:
C3546a E04 H