



DETAIL D
TYPICAL L7 ELEVATION
SCALE 1: 25

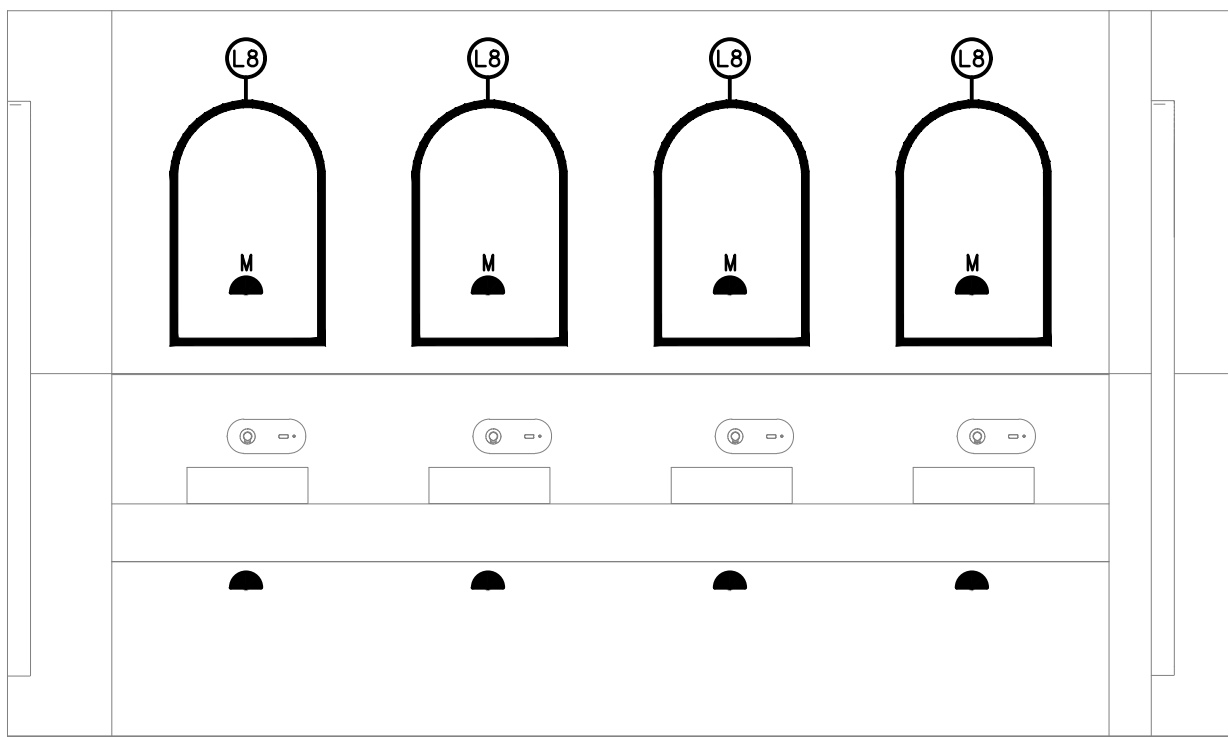

DETAIL E
VANITY L8 & MIRROR OUTLET ELEVATION
SCALE 1: 25

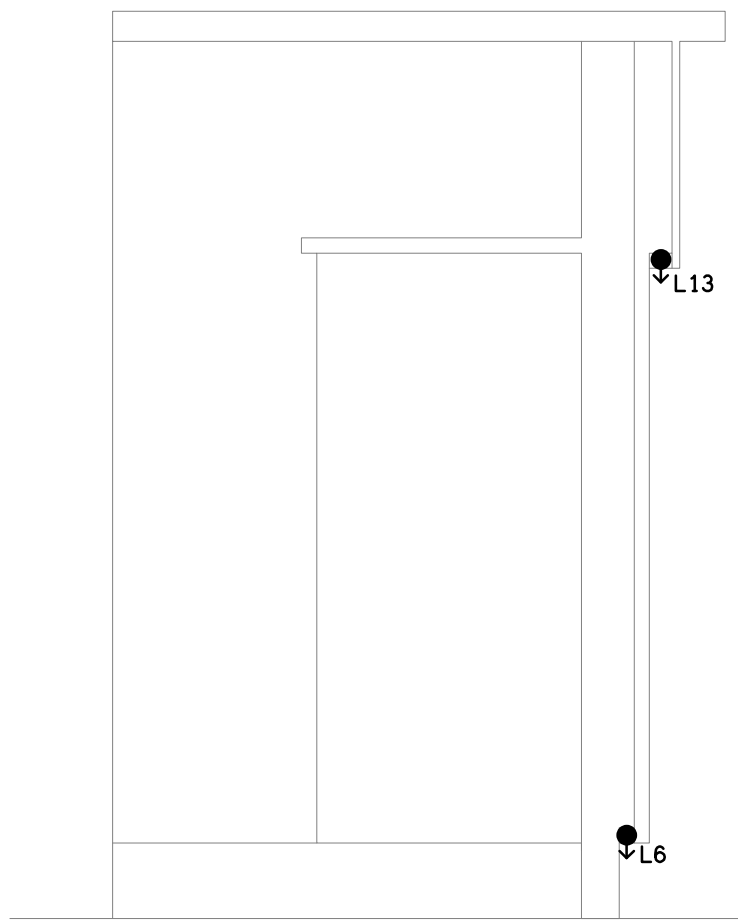

DETAIL F
MAÎTRE DE SECTION
NOT TO SCALE

THE COPYRIGHT OF THIS DRAWING REMAINS THE PROPERTY OF THE ELECTRICAL DESIGN GROUP.

USE FIGURED DIMENSIONS IN PREFERENCE TO SCALE.

ALL DIMENSIONS TO BE VERIFIED ONSITE.

E	CONSTRUCTION	14/08/2025
REV:	DESCRIPTION:	DATE:

ELECTRICAL DESIGN GROUP
ELECTRICAL BUILDING SERVICES CONSULTANTS

BRISBANE: P.O. Box 15 Sherwood Qld 4075
Phone: (07) 3278 4375
Email: brisbane@edg.net.au
Web: www.edg.net.au

ELECTRICAL DESIGN GROUP BRISBANE PTY LTD
ACN 092 710 793

TRADING AS:
ELECTRICAL DESIGN
GROUP

PROJECT:

**BLUE FIN FISHING CLUB
INALA - STAGE 2**

SITE ADDRESS:
**24 LILAC STREET, INALA
QUEENSLAND**

SCALE: SHEET SIZE:

1:50 UNO AT A1

DRAWING TITLE:

**ELECTRICAL SERVICES
REFLECTED CEILING PLAN**

PROJECT NO: DRAWING NO: REVISION:

C3546a E05 E