


OVERALL FLOOR PLAN
EXTENT OF WORKS
SCALE 1: 200

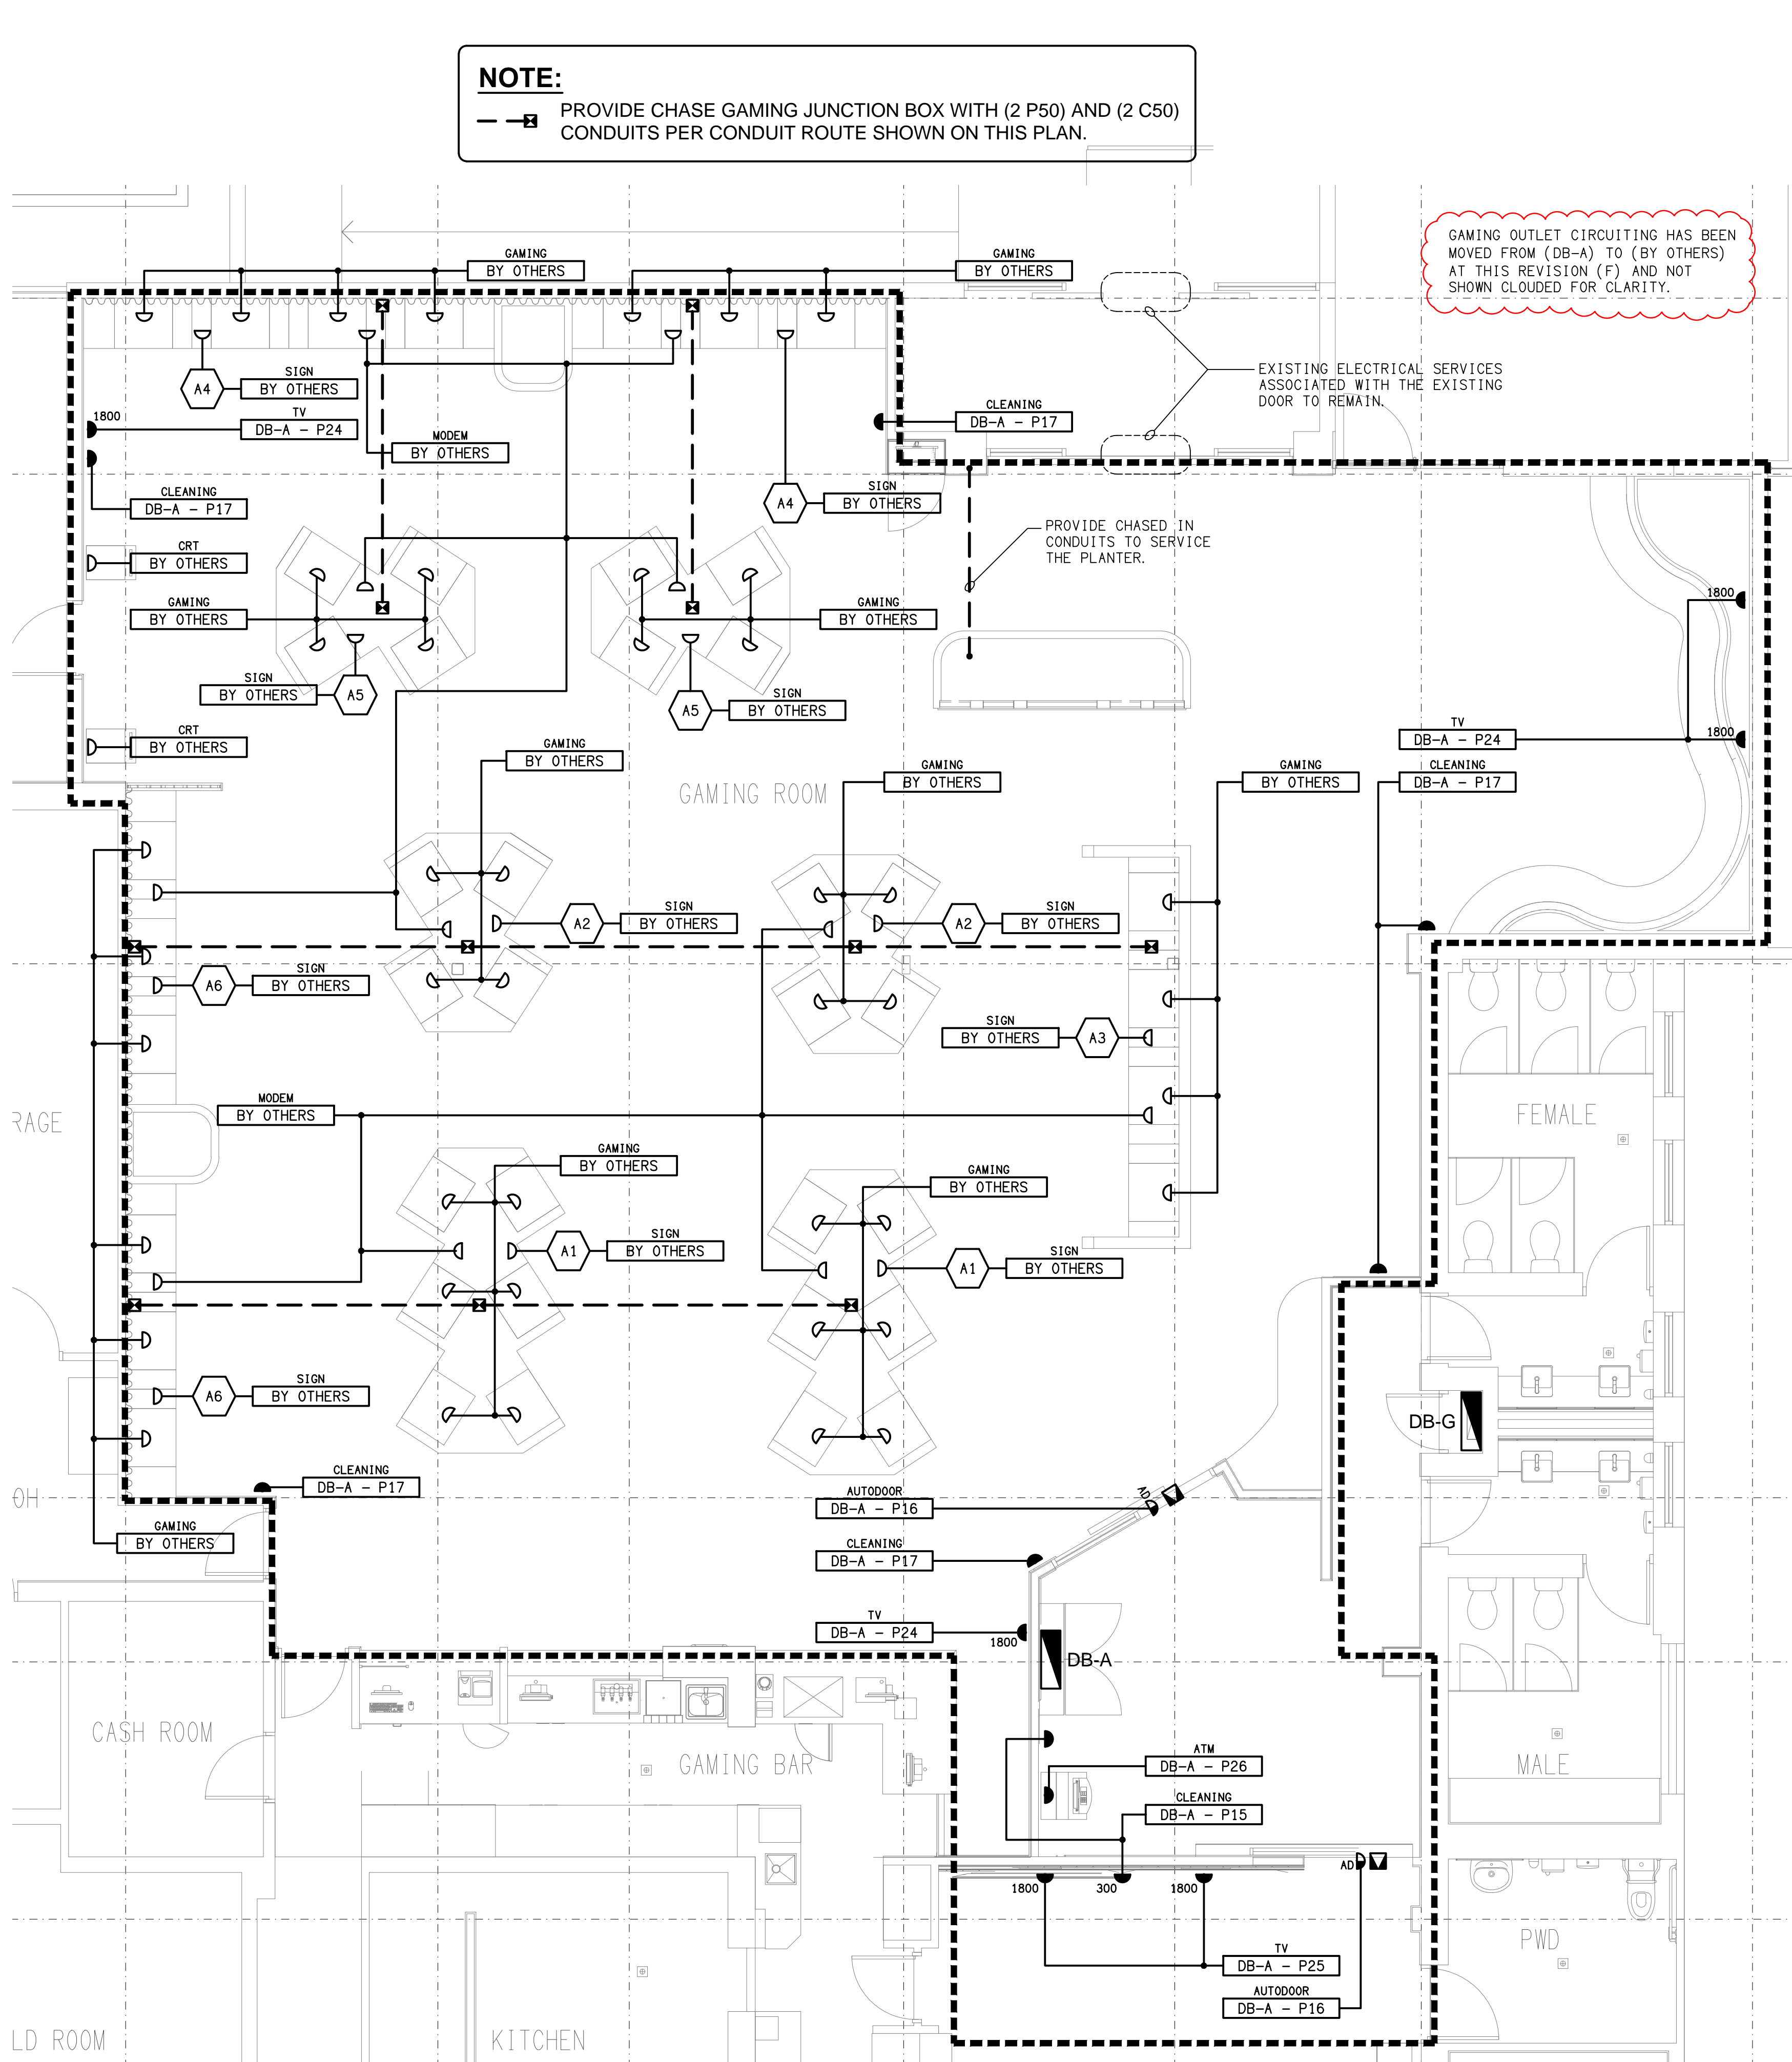

GAMING ROOM
FLOOR PLAN
SCALE 1: 50

THE COPYRIGHT OF THIS DRAWING REMAINS THE PROPERTY OF THE ELECTRICAL DESIGN GROUP.

USE FIGURED DIMENSIONS IN PREFERENCE TO SCALE.

ALL DIMENSIONS TO BE VERIFIED ONSITE.

F	CONSTRUCTION	27/08/2025
REV:	DESCRIPTION:	DATE:

ELECTRICAL DESIGN GROUP
ELECTRICAL BUILDING SERVICES CONSULTANTS

BRISBANE: P.O. Box 15 Sherwood Qld 4075
Phone: (07) 3278 4375
Email: brisbane@edg.net.au
Web: www.edg.net.au

ELECTRICAL DESIGN GROUP BRISBANE PTY LTD
ACN 092 710 793

TRADING AS:
ELECTRICAL DESIGN
GROUP

PROJECT:

ROYAL HOTEL, BEENLEIGH

SITE ADDRESS:
**85 GEORGE STREET, BEENLEIGH
QUEENSLAND**

SCALE: SHEET SIZE:

1:100 & 1:50 AT A1

DRAWING TITLE:

**ELECTRICAL SERVICES
FLOOR PLAN**

PROJECT NO: DRAWING NO: REVISION:

C3556a E03 F