

DETAIL A
MALE ELEVATION
SCALE 1:50


DETAIL B
FEMALE ELEVATION
SCALE 1:50

REFER TO DRAWING C3584a-E08.dwg FOR
THE BEER GARDEN PLAN WITHIN THIS AREA.

EXISTING ELECTRICAL CEILING
SERVICES WITHIN THIS AREA
TO REMAIN AS IS, UNLESS
NOTED OTHERWISE.

EXISTING ELECTRICAL CEILING
SERVICES WITHIN THIS AREA TO REMAIN
AS IS, UNLESS NOTED OTHERWISE.

EXISTING ELECTRICAL CEILING
SERVICES WITHIN THIS AREA TO REMAIN
AS IS, UNLESS NOTED OTHERWISE.

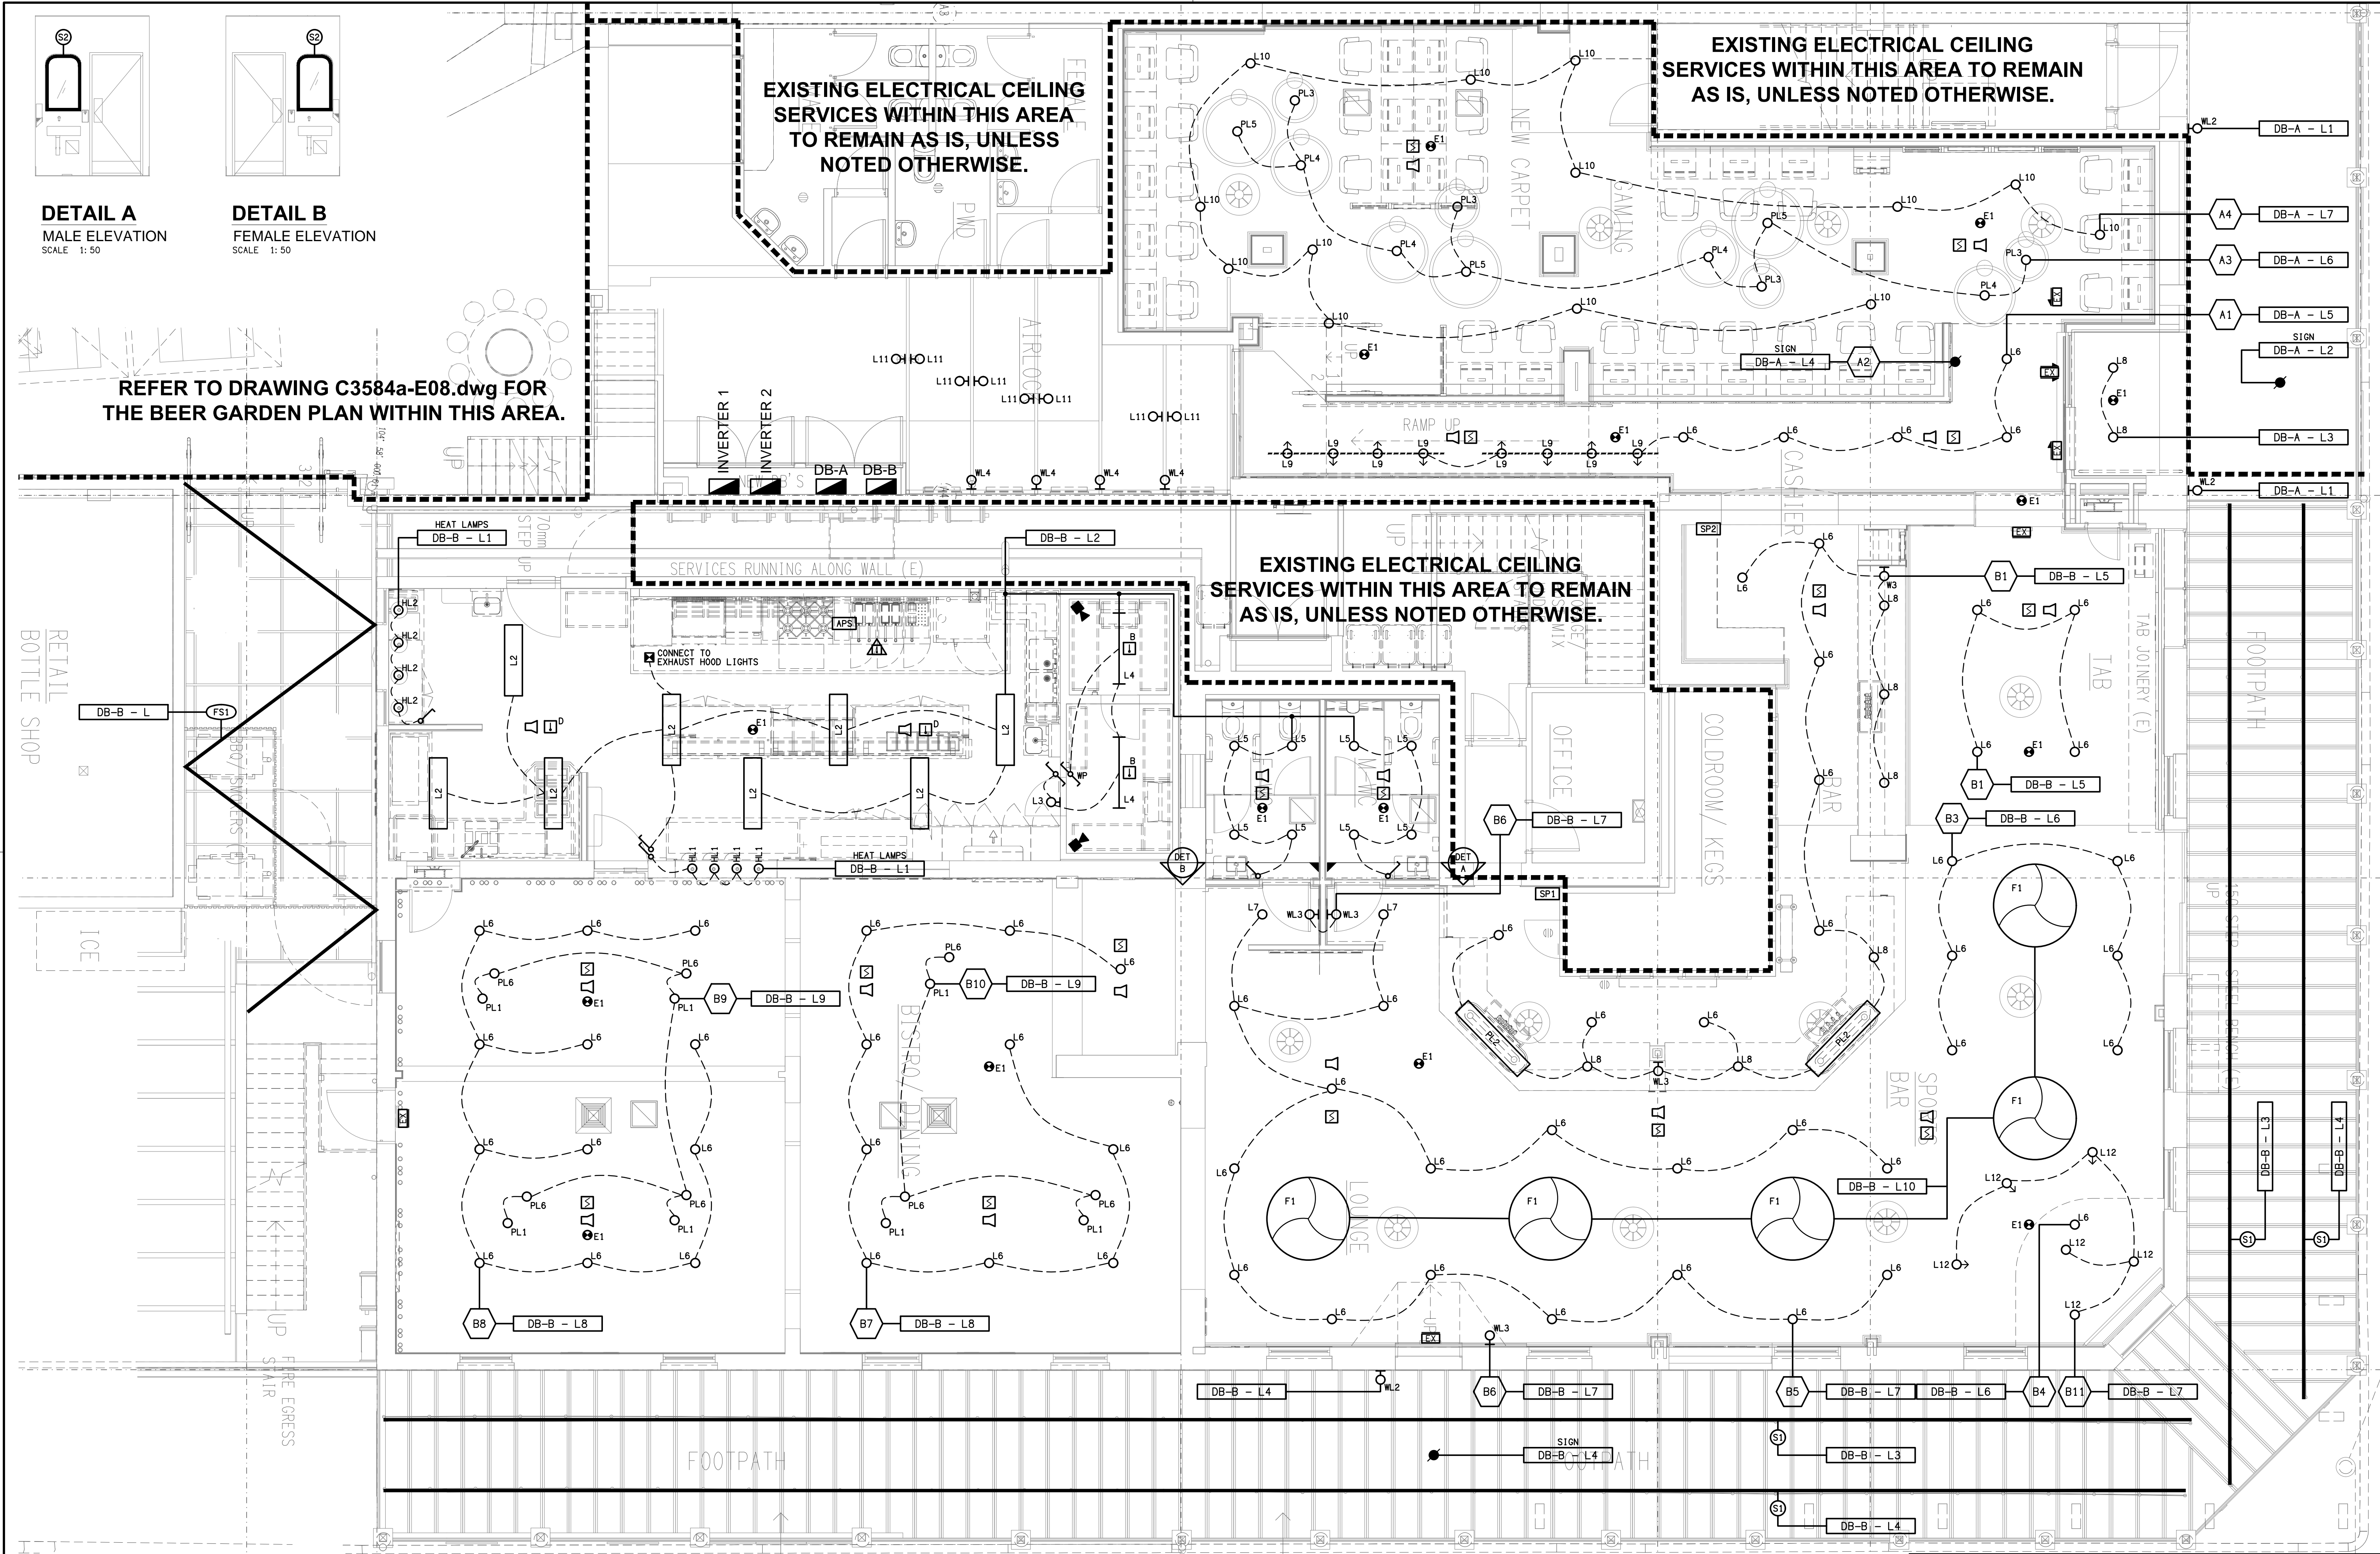

ELECTRICAL DESIGN GROUP BRISBANE
PTY LTD
ACN 092 710 793
TRADING AS:
ELECTRICAL DESIGN GROUP

THE COPYRIGHT OF THIS DRAWING
REMAINS THE PROPERTY OF THE
ELECTRICAL DESIGN GROUP.
USE FIGURED DIMENSIONS
IN PREFERENCE TO SCALE.
ALL DIMENSIONS TO BE
VERIFIED ONSITE.

ELECTRICAL DESIGN GROUP
ELECTRICAL BUILDING SERVICES CONSULTANTS
BRISBANE GOLD COAST

P.O. Box 15, Sherwood Q.4075
Phone: (07) 3278 4375
Email: brisbane@edg.net.au
Web: www.edg.net.au

PROJECT:
METROPOLE HOTEL, PROSERPINE
74, 78 & 82 MAIN STREET, PROSERPINE, QUEENSLAND

A	PRELIMINARY	16/10/2025
REV:	DESCRIPTION:	DATE:

DRAWING: ELECTRICAL SERVICES HOTEL REFLECTED CEILING PLAN	PROJECT NO: C3584a	DRAWING NO: E06	REVISION: A
SCALE: 1:50	AT A1		