




**JOINERY LIGHTING**  
FLOOR PLAN  
SCALE 1: 100

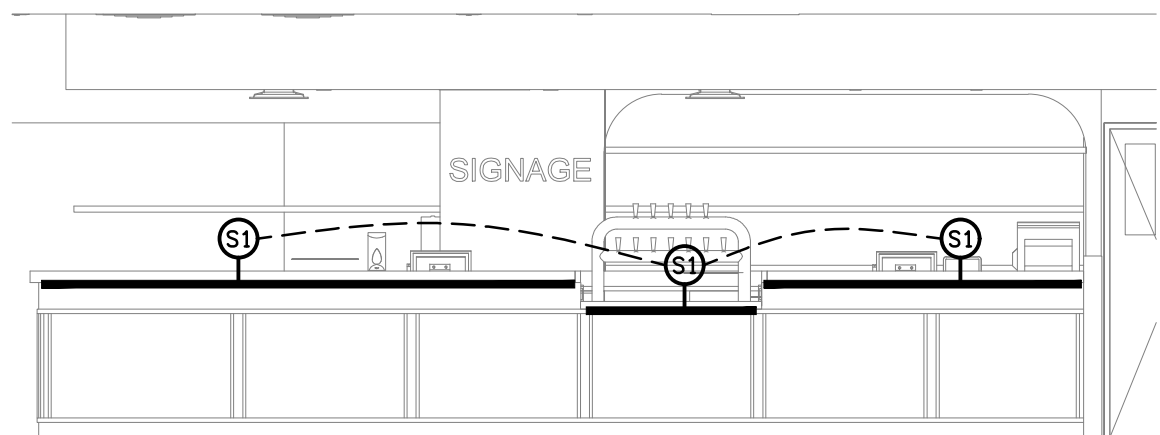


**DETAIL A**  
SPORT BAR COUNTER LIGHTING  
SCALE 1: 50

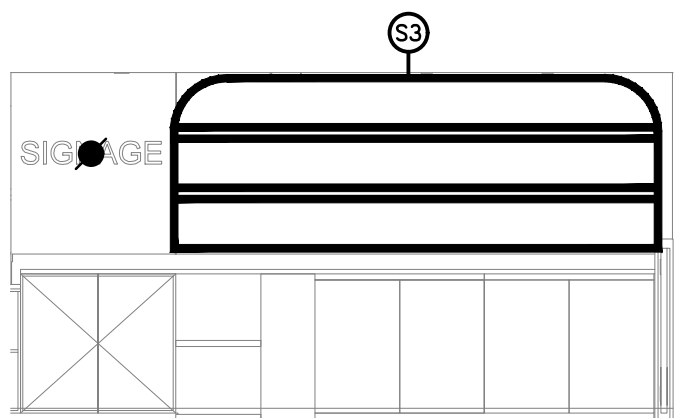


**DETAIL B**  
SPORT BAR REAR WALL LIGHTING  
SCALE 1: 50

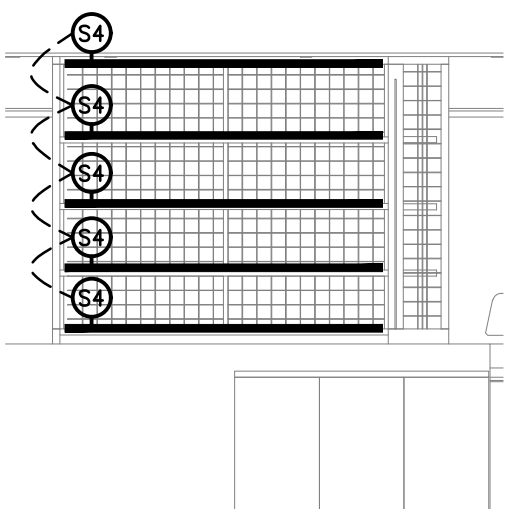


**DETAIL C**  
BISTRO DISPLAY SHELVEING LIGHTING  
SCALE 1: 50

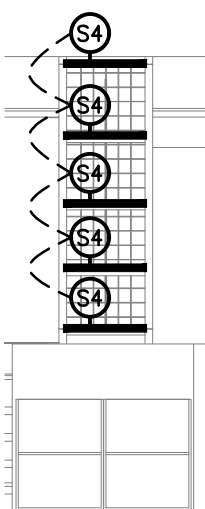

**DETAIL D**  
BISTRO DISPLAY SHELVEING LIGHTING  
SCALE 1: 50

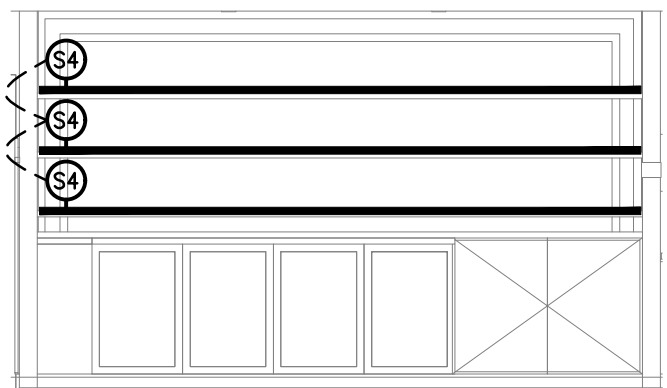

**DETAIL E**  
GAMING BAR REAR WALL LIGHTING  
SCALE 1: 50

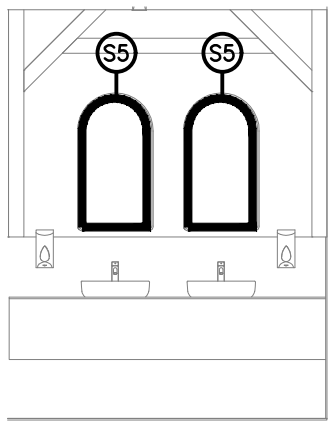

**DETAIL F**  
TYPICAL AMENITIES MIRROR LIGHTING  
SCALE 1: 50

THE COPYRIGHT OF THIS DRAWING REMAINS THE PROPERTY OF THE ELECTRICAL DESIGN GROUP.

USE FIGURED DIMENSIONS IN PREFERENCE TO SCALE.

ALL DIMENSIONS TO BE VERIFIED ONSITE.

C	CONSTRUCTION	28/08/2025
REV:	DESCRIPTION:	DATE:

**ELECTRICAL DESIGN GROUP**  
ELECTRICAL BUILDING SERVICES CONSULTANTS

BRISBANE: P.O. Box 15 Sherwood Qld 4075  
Phone: (07) 3278 4375  
Email: brisbane@edg.net.au  
Web: www.edg.net.au

ELECTRICAL DESIGN GROUP BRISBANE PTY LTD  
ACN 092 710 793

TRADING AS:  
ELECTRICAL DESIGN GROUP

PROJECT:

**OXFENFORD TAVERN**

SITE ADDRESS:

179 OLD PACIFIC HIGHWAY,  
OXENFORD, QUEENSLAND

SCALE: SHEET SIZE:

1:100 & 1:50 AT A1

DRAWING TITLE:

**ELECTRICAL SERVICES**  
**JOINERY LIGHTING PLAN**

PROJECT NO: DRAWING NO: REVISION:

**C3585a E06 C**