



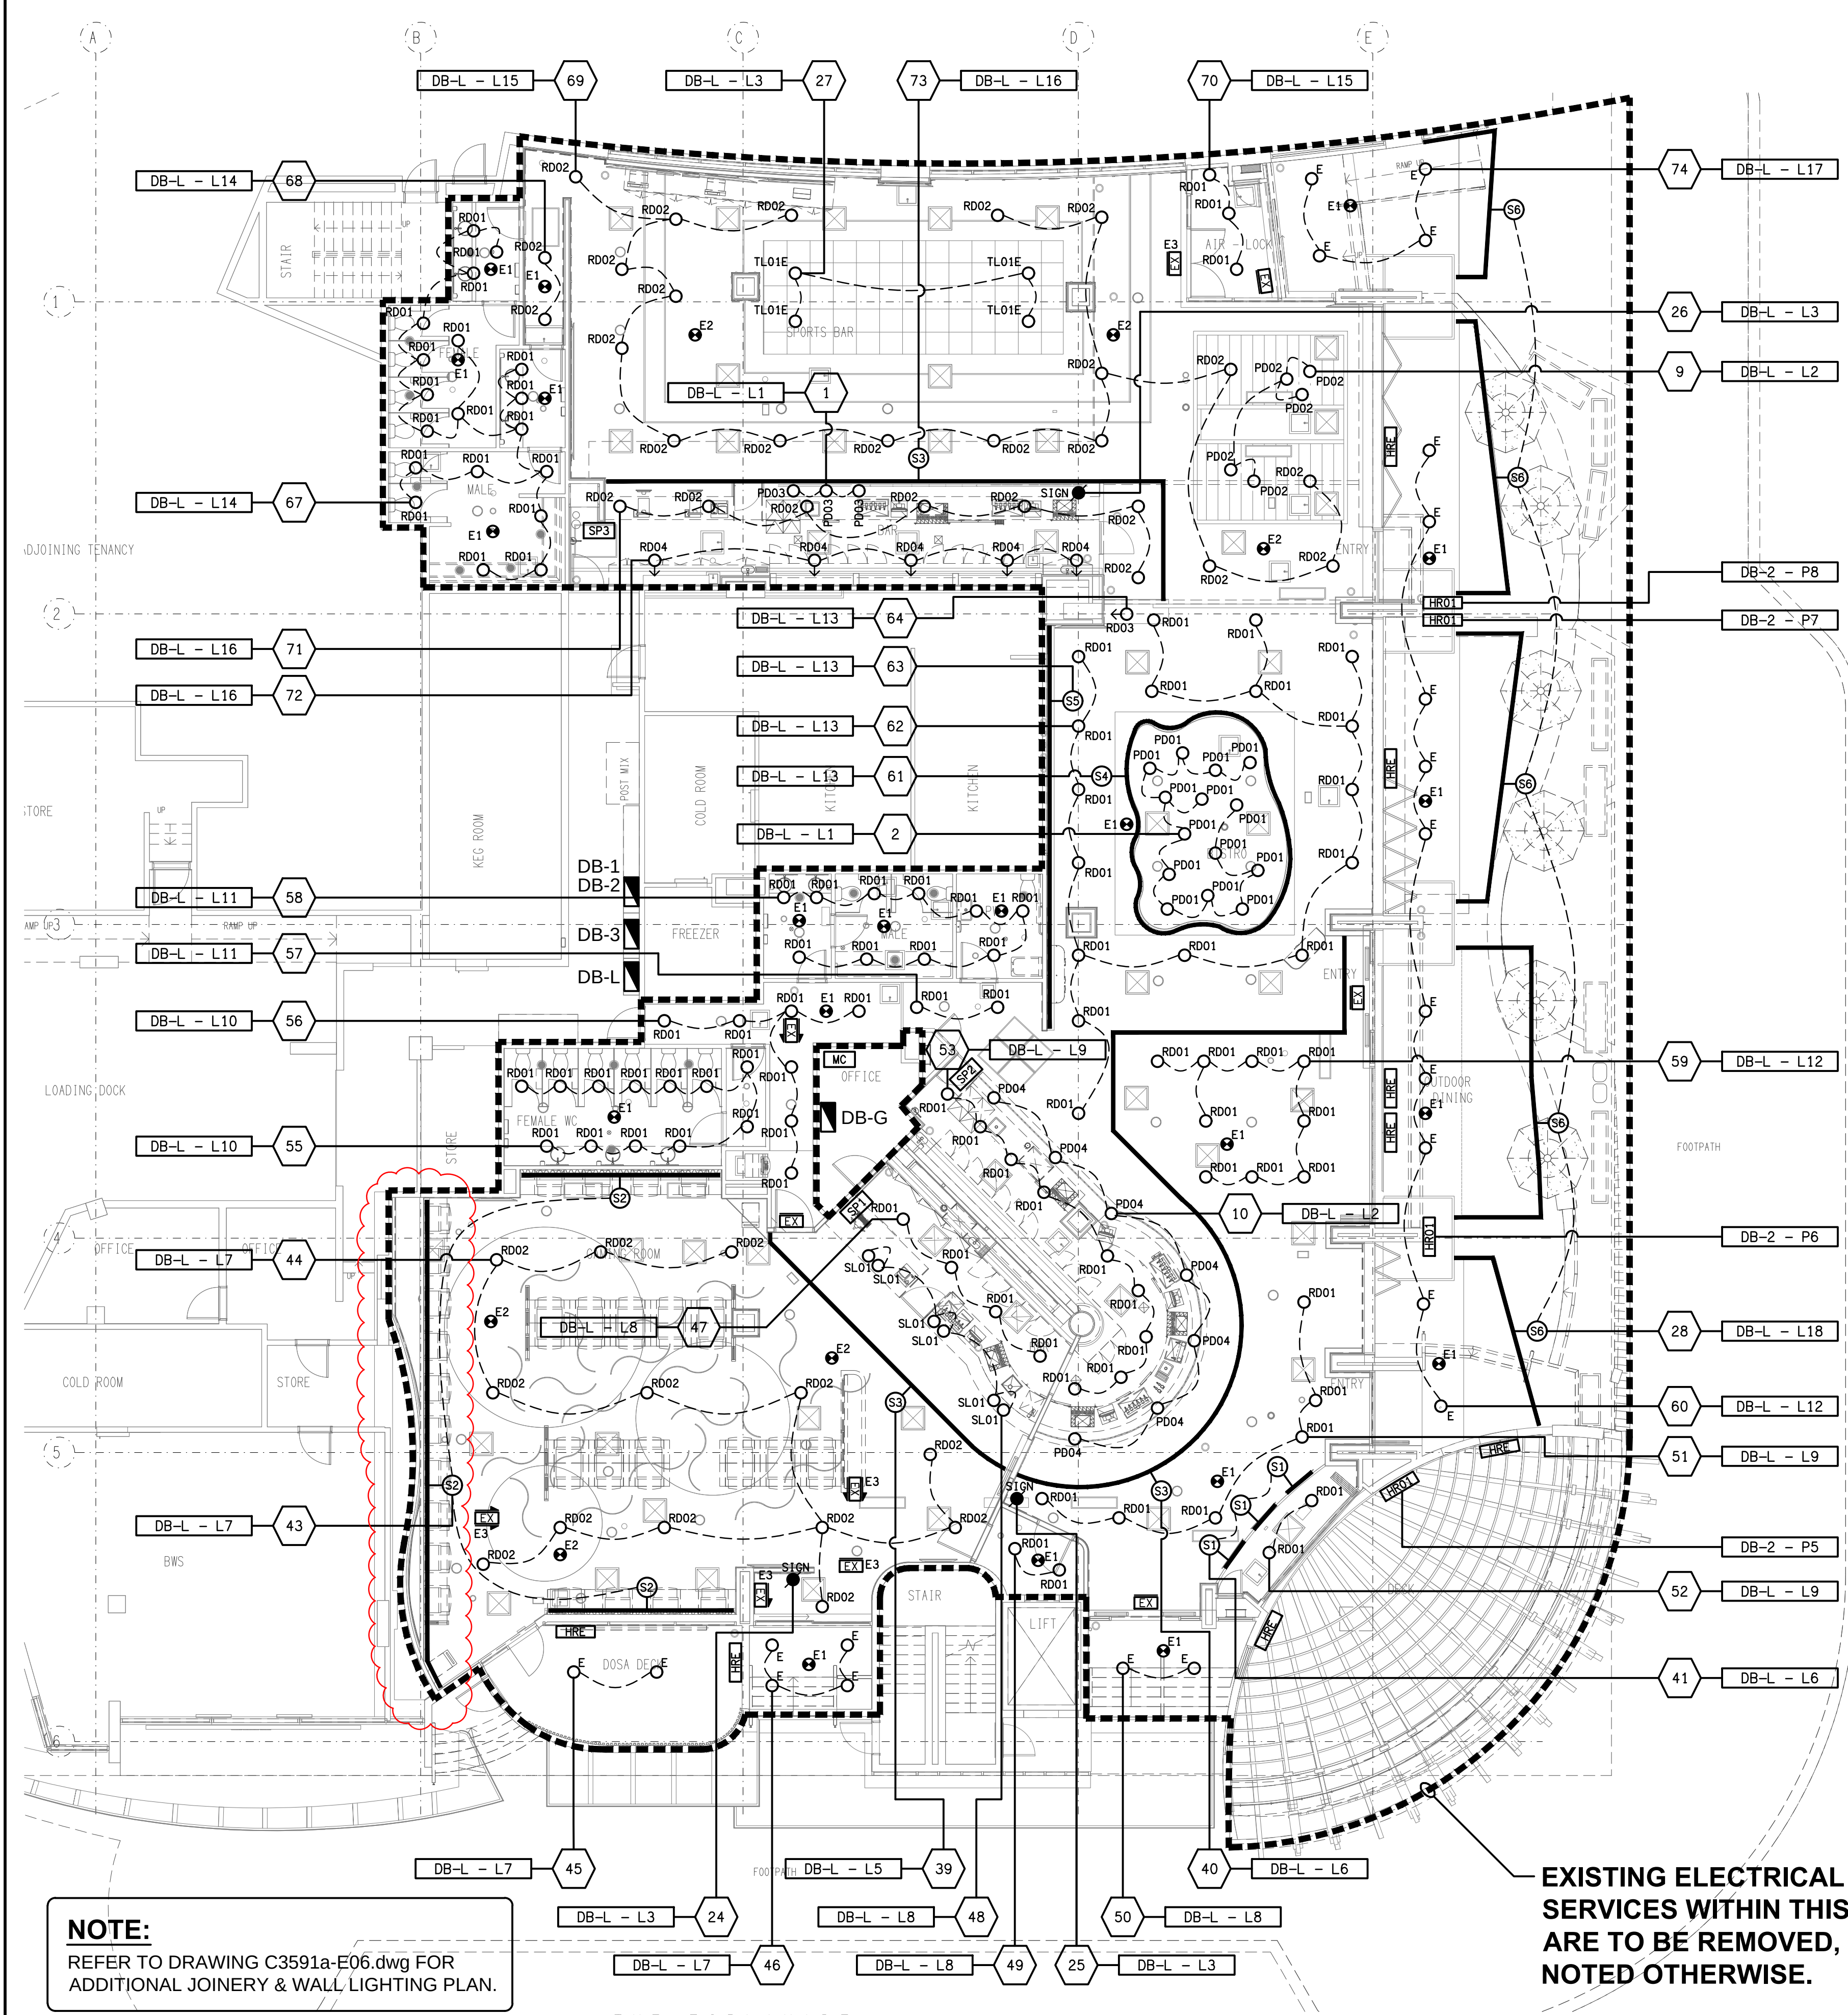

NOTE:
REFER TO DRAWING C3591a-E06.dwg FOR
ADDITIONAL JOINERY & WALL LIGHTING PLAN.

**EXISTING ELECTRICAL CEILING
SERVICES WITHIN THIS AREA
ARE TO BE REMOVED, UNLESS
NOTED OTHERWISE.**

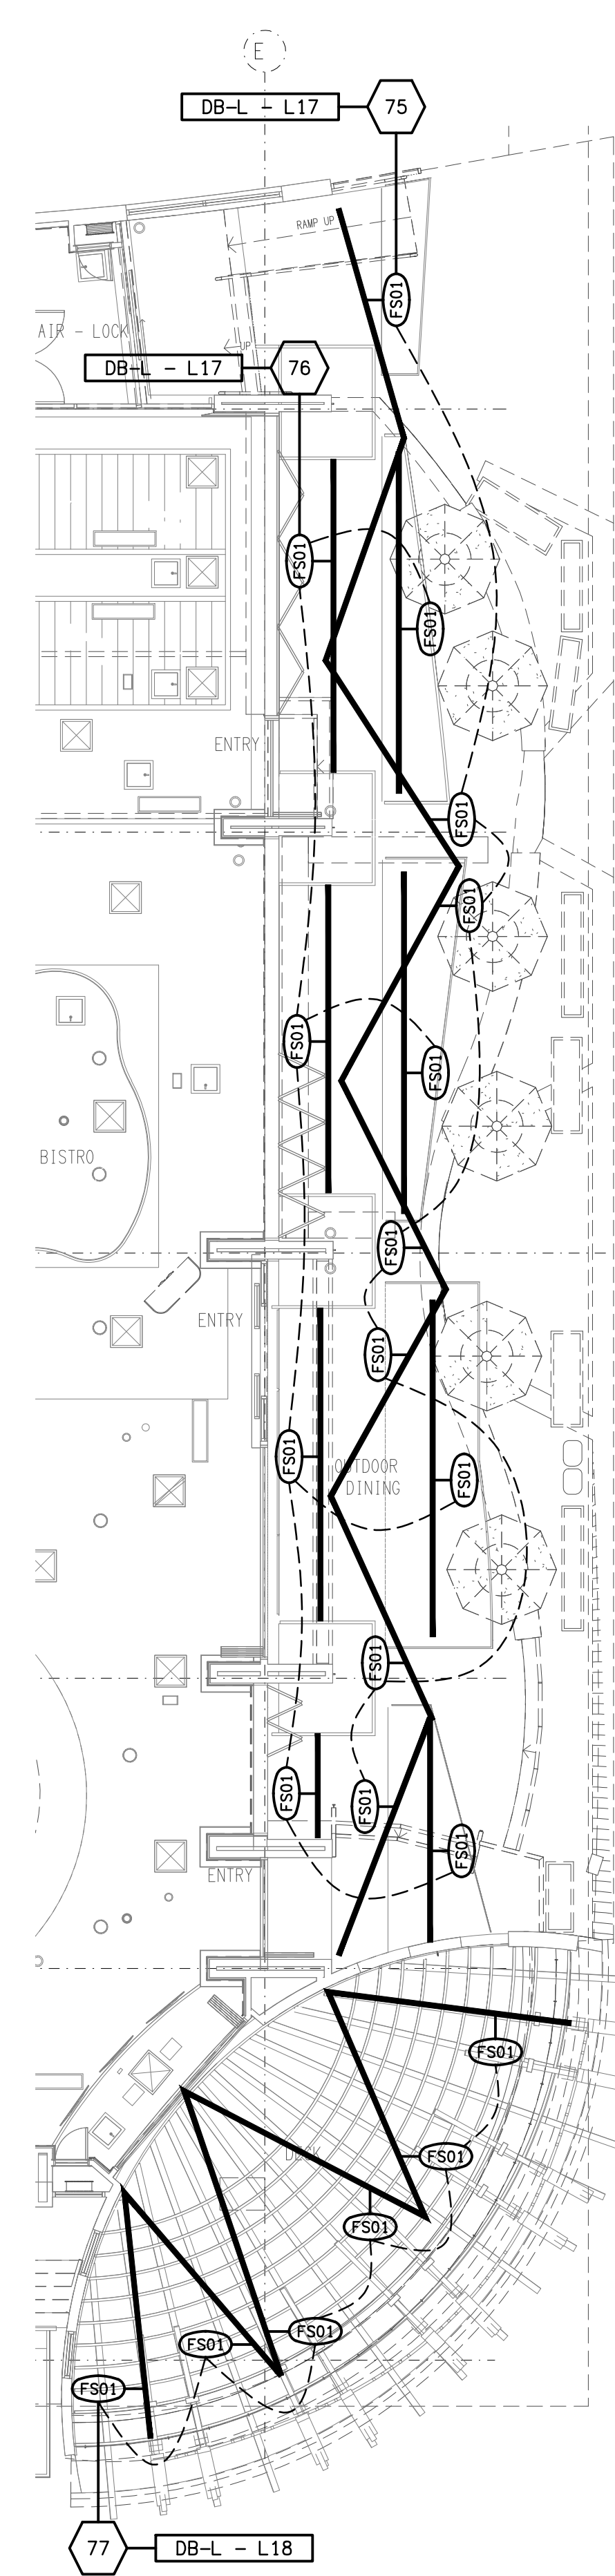

FESTOON LIGHTING
REFLECTED CEILING PLAN
SCALE 1:100

THE COPYRIGHT OF THIS DRAWING REMAINS THE PROPERTY OF THE ELECTRICAL DESIGN GROUP.

USE FIGURED DIMENSIONS IN PREFERENCE TO SCALE.

ALL DIMENSIONS TO BE VERIFIED ONSITE.

D	CONSTRUCTION	05/11/2025
REV:	DESCRIPTION:	DATE:

ELECTRICAL DESIGN GROUP
ELECTRICAL BUILDING SERVICES CONSULTANTS

BRISBANE: P.O. Box 15 Sherwood Qld 4075
Phone: (07) 3278 4375
Email: brisbane@edg.net.au
Web: www.edg.net.au

ELECTRICAL DESIGN GROUP BRISBANE PTY LTD
ACN 092 710 793

TRADING AS:
ELECTRICAL DESIGN GROUP

PROJECT:
BURLEIGH HEADS HOTEL

SITE ADDRESS:
4 THE ESPLANADE, BURLEIGH HEADS
QUEENSLAND

SCALE: 1:100 SHEET SIZE: A1

DRAWING TITLE:
**ELECTRICAL SERVICES
REFLECTED CEILING PLAN**

PROJECT NO: DRAWING NO: REVISION:

C3591a E05 D