


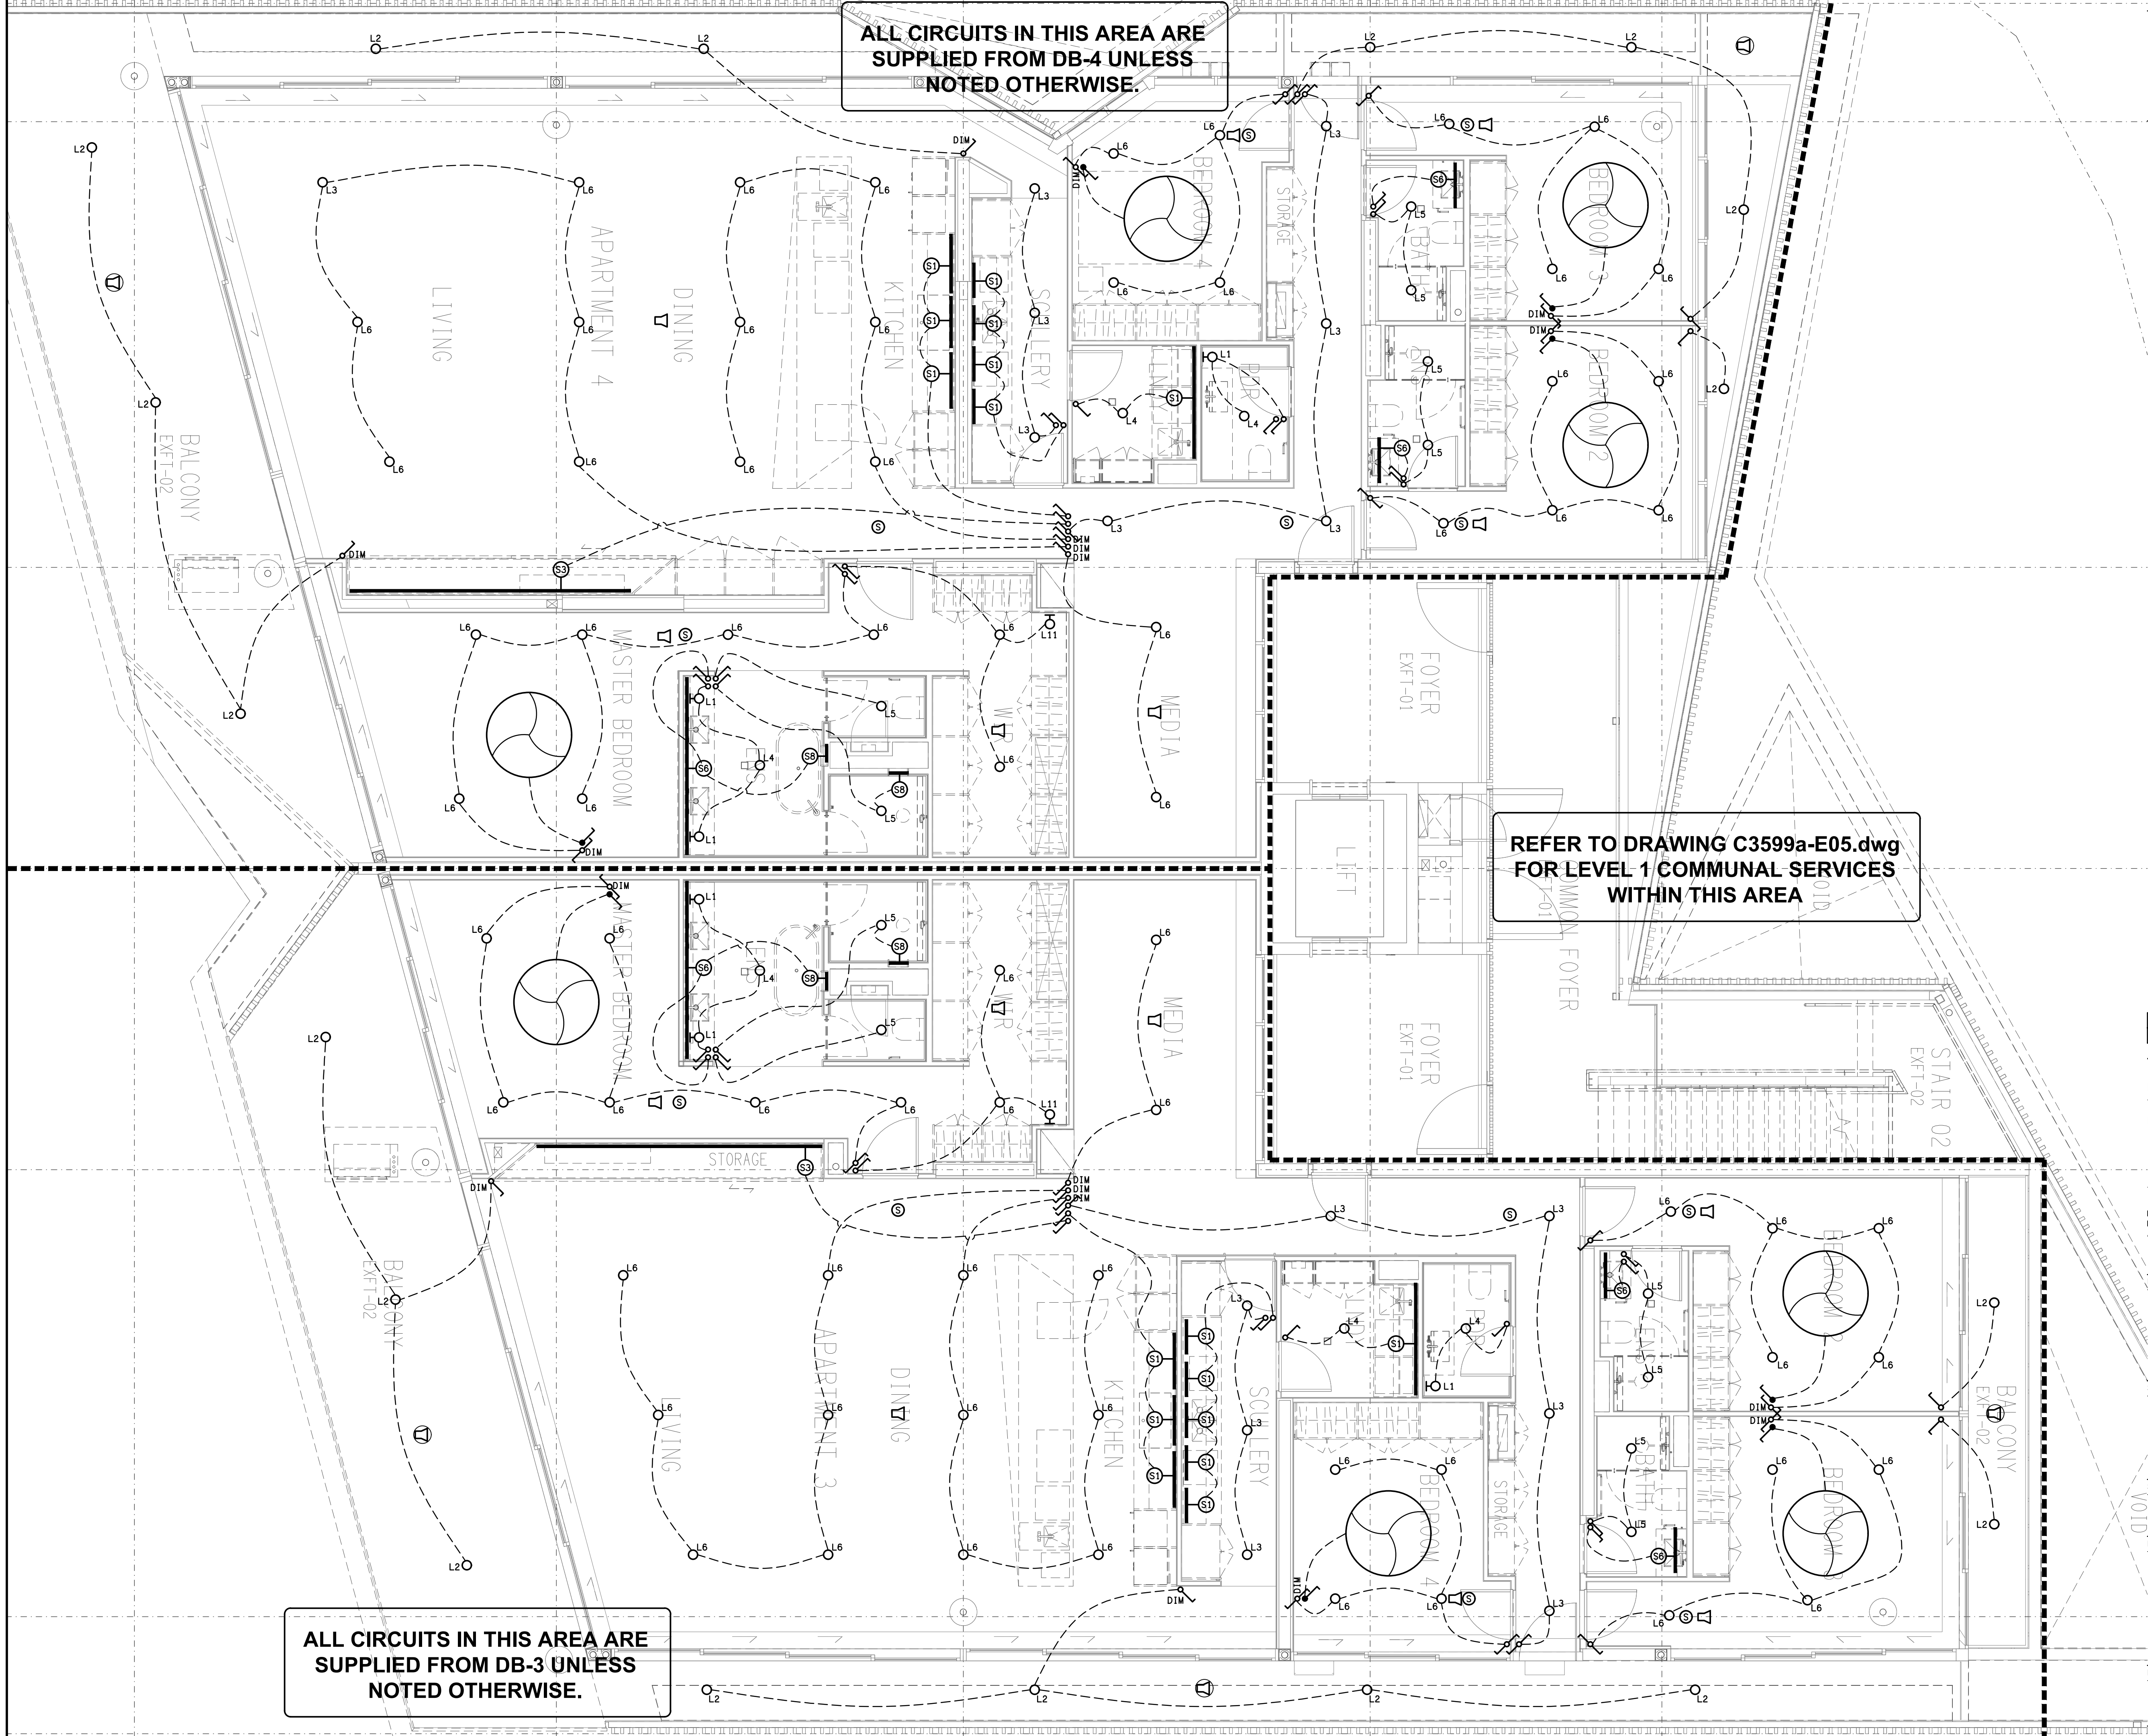

ALL CIRCUITS IN THIS AREA ARE SUPPLIED FROM DB-4 UNLESS NOTED OTHERWISE.

REFER TO DRAWING C3599a-E05.dwg FOR LEVEL 1 COMMUNAL SERVICES WITHIN THIS AREA

ALL CIRCUITS IN THIS AREA ARE SUPPLIED FROM DB-3 UNLESS NOTED OTHERWISE.

THE COPYRIGHT OF THIS DRAWING REMAINS THE PROPERTY OF THE ELECTRICAL DESIGN GROUP.

USE FIGURED DIMENSIONS IN PREFERENCE TO SCALE.

ALL DIMENSIONS TO BE VERIFIED ONSITE.

D	APPROVAL	06/07/2026
REV:	DESCRIPTION:	DATE:

ELECTRICAL DESIGN GROUP
ELECTRICAL BUILDING SERVICES CONSULTANTS

BRISBANE: P.O. Box 15 Sherwood Qld 4075
Phone: (07) 3278 4375
Email: brisbane@edg.net.au
Web: www.edg.net.au

ELECTRICAL DESIGN GROUP BRISBANE PTY LTD
ACN 092 710 793

TRADING AS:
ELECTRICAL DESIGN GROUP

PROJECT:
TI-TREE COLLECTIVE

SITE ADDRESS:
**294-298 GIVEN TERRACE, PADDINGTON
BRISBANE, QUEENSLAND**

SCALE: 1:50 SHEET SIZE: AT A1

DRAWING TITLE:
**ELECTRICAL SERVICES
LEVEL 1
REFLECTED CEILING PLAN**

PROJECT NO: DRAWING NO: REVISION:
C3599a E09 D