




BURGER URGE

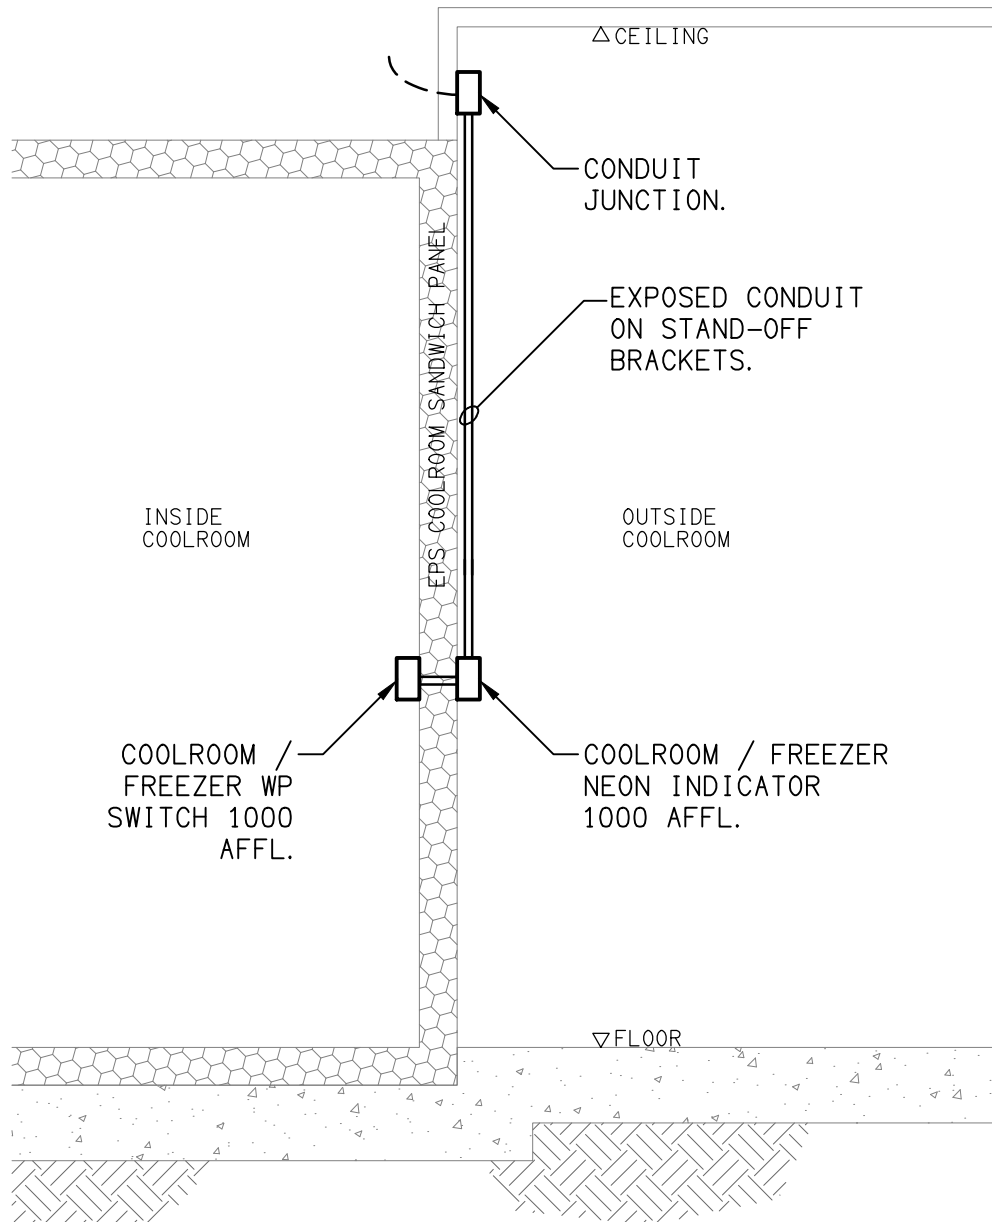

DETAIL A
COOLROOM / FREEZER LIGHTING CONTROL
NOT TO SCALE

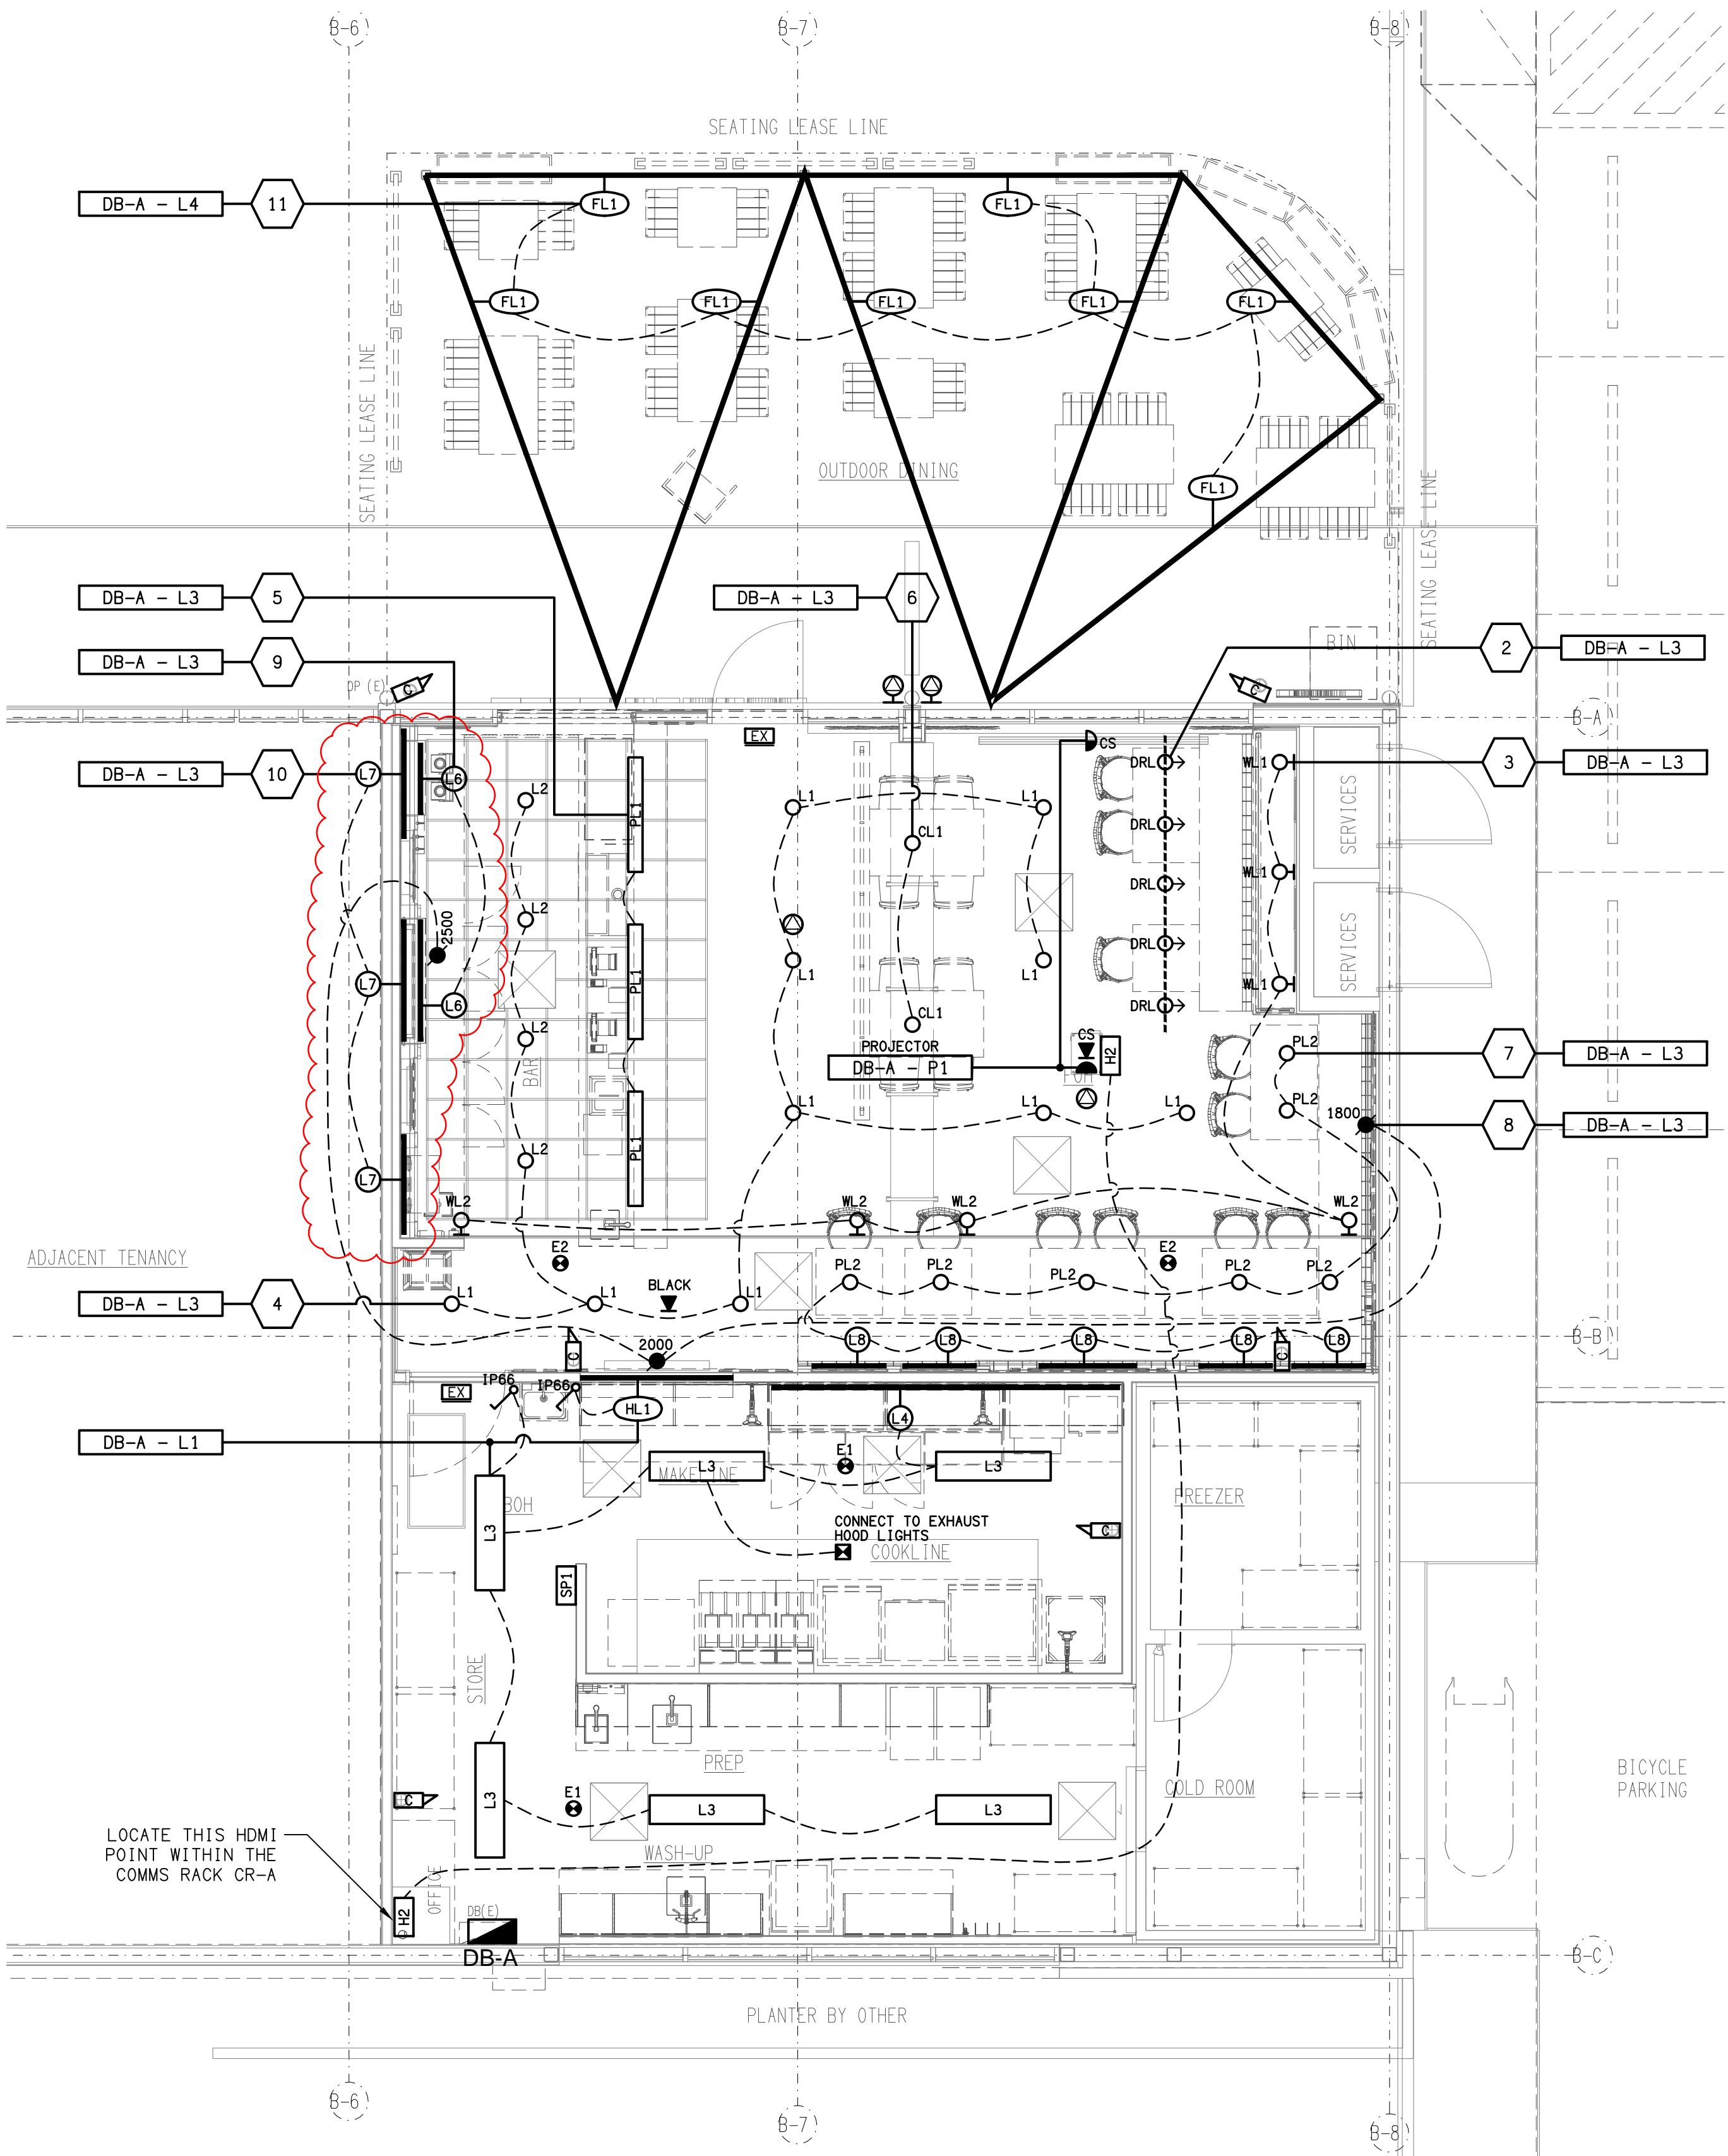

REFLECTED CEILING PLAN
BURGER URGE TENANCY
SCALE 1:50

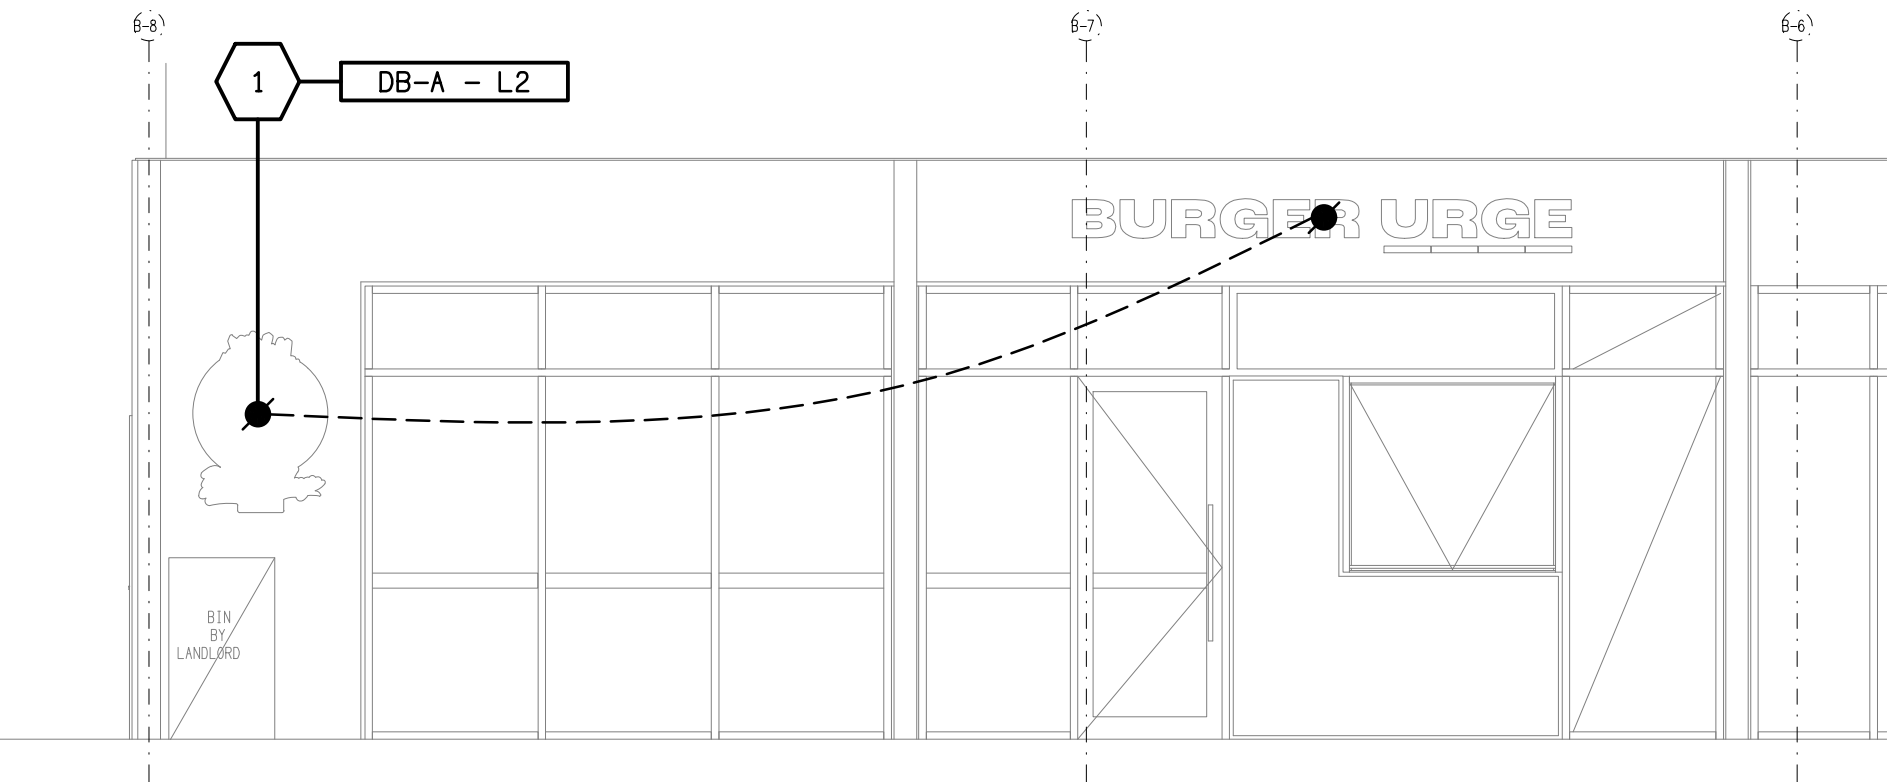

ELEVATION
MAIN ENTRY BUILDING EXTERNAL
SCALE 1:50

| | | |
|------|--------------|------------|
| D | TENDER | 22/08/2025 |
| REV: | DESCRIPTION: | DATE: |

ELECTRICAL DESIGN GROUP
ELECTRICAL BUILDING SERVICES CONSULTANTS

BRISBANE: P.O. Box 15 Sherwood Qld 4075
Phone: (07) 3278 4375
Email: brisbane@edg.net.au
Web: www.edg.net.au

ELECTRICAL DESIGN GROUP BRISBANE PTY LTD
ACN 092 710 793

TRADING AS:
ELECTRICAL DESIGN
GROUP

PROJECT:

**BURGER URGE
BURPENGARY EAST**

SITE ADDRESS:
TENANCY 12, 122 BUCKLEY ROAD,
137 & 143 ULHMANN ROAD,
BURPENGARY EAST, QUEENSLAND

SCALE: SHEET SIZE:

1:50 AT A1

DRAWING TITLE:

**ELECTRICAL SERVICES
REFLECTED CEILING PLAN**

PROJECT NO: DRAWING NO: REVISION:

C3609a E04 D