


**NOTE:**  
—R— EXISTING CONDUITS TO BE REMOVED.

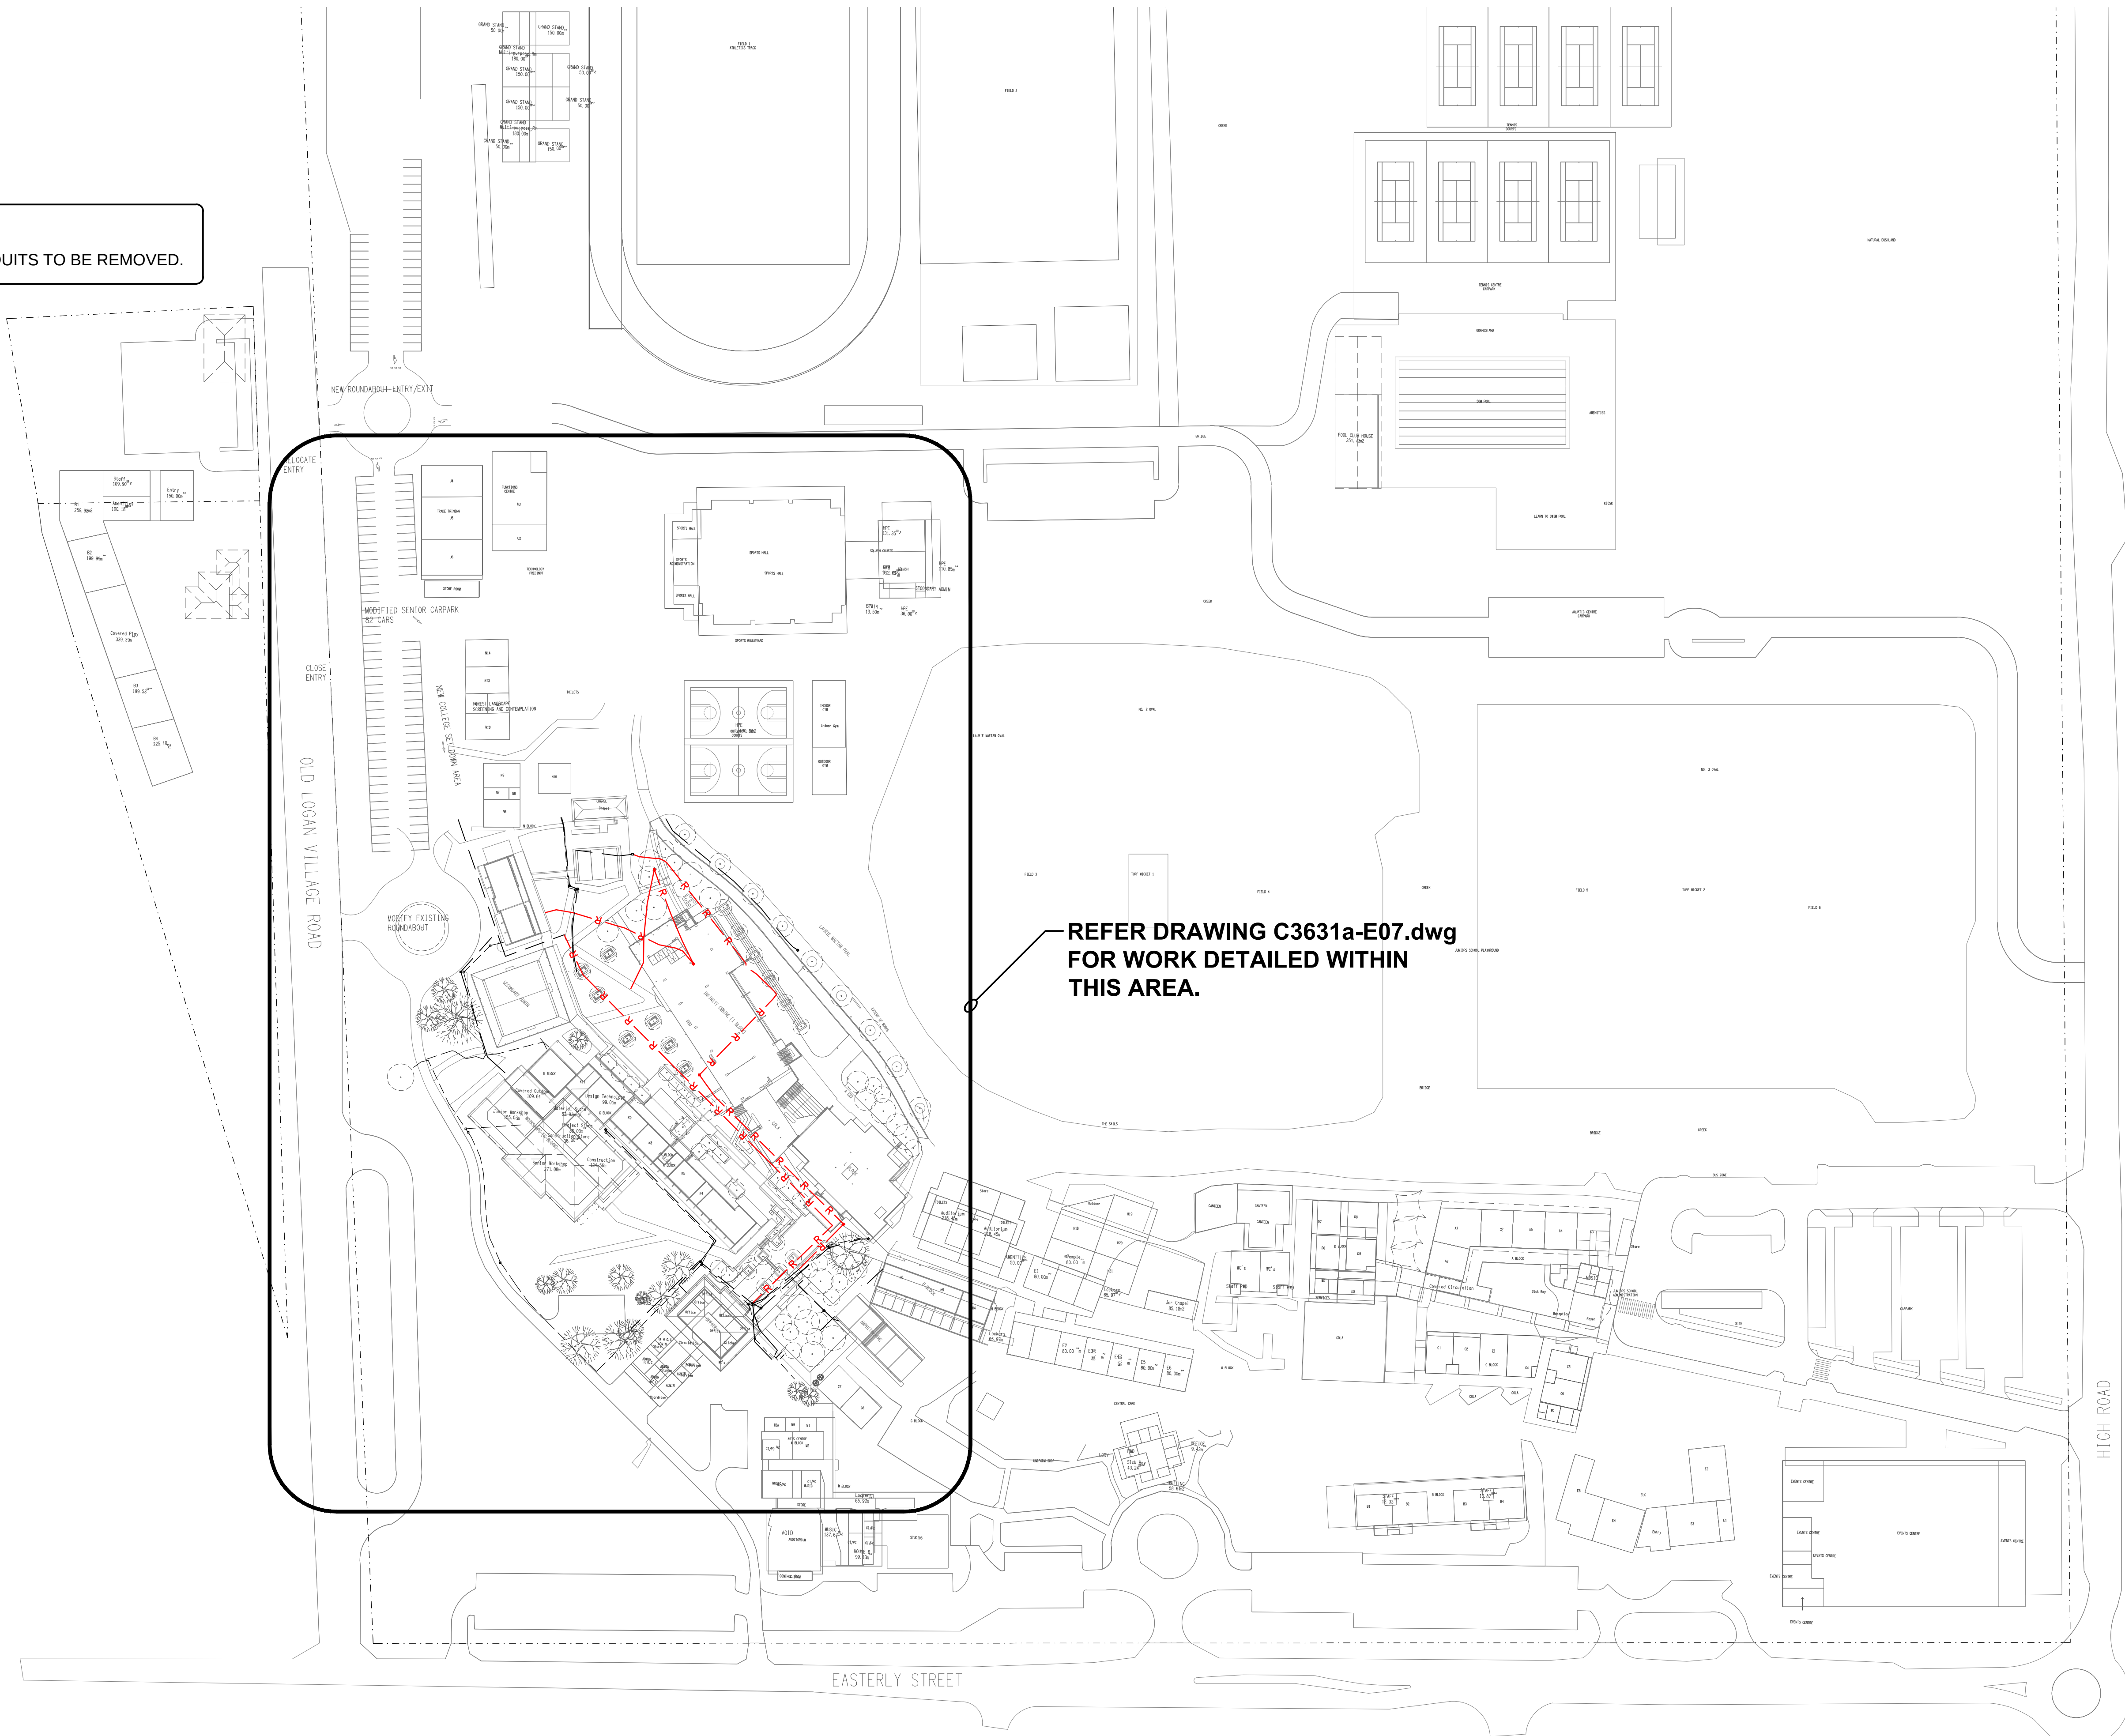

ELECTRICAL DESIGN GROUP BRISBANE  
PTY LTD  
ACN 092 710 793  
TRADING AS:  
ELECTRICAL DESIGN GROUP

THE COPYRIGHT OF THIS DRAWING  
REMAINS THE PROPERTY OF THE  
ELECTRICAL DESIGN GROUP.  
USE FIGURED DIMENSIONS  
IN PREFERENCE TO SCALE.  
ALL DIMENSIONS TO BE  
VERIFIED ONSITE.

**ELECTRICAL DESIGN GROUP**  
ELECTRICAL BUILDING SERVICES CONSULTANTS  
BRISBANE GOLD COAST

P.O. Box 15, Sherwood Q.4075  
Phone: (07) 3278 4375  
Email: brisbane@edg.net.au  
Web: www.edg.net.au

PROJECT:  
CANTERBURY COLLEGE SENIOR SCHOOL  
TALNGAI PRECINCT

182 OLD LOGAN VILLAGE ROAD, WATERFORD

|      |              |            |
|------|--------------|------------|
| D    | 90% ISSUE    | 27/07/2026 |
| REV. | DESCRIPTION: | DATE:      |

DRAWING:  
**ELECTRICAL SERVICES  
PROPOSED SITE PLAN**

SCALE:  
1:1000

AT A1

PROJECT NO:  
**C3631a**

DRAWING NO:  
**E06**

REVISION:  
**D**