


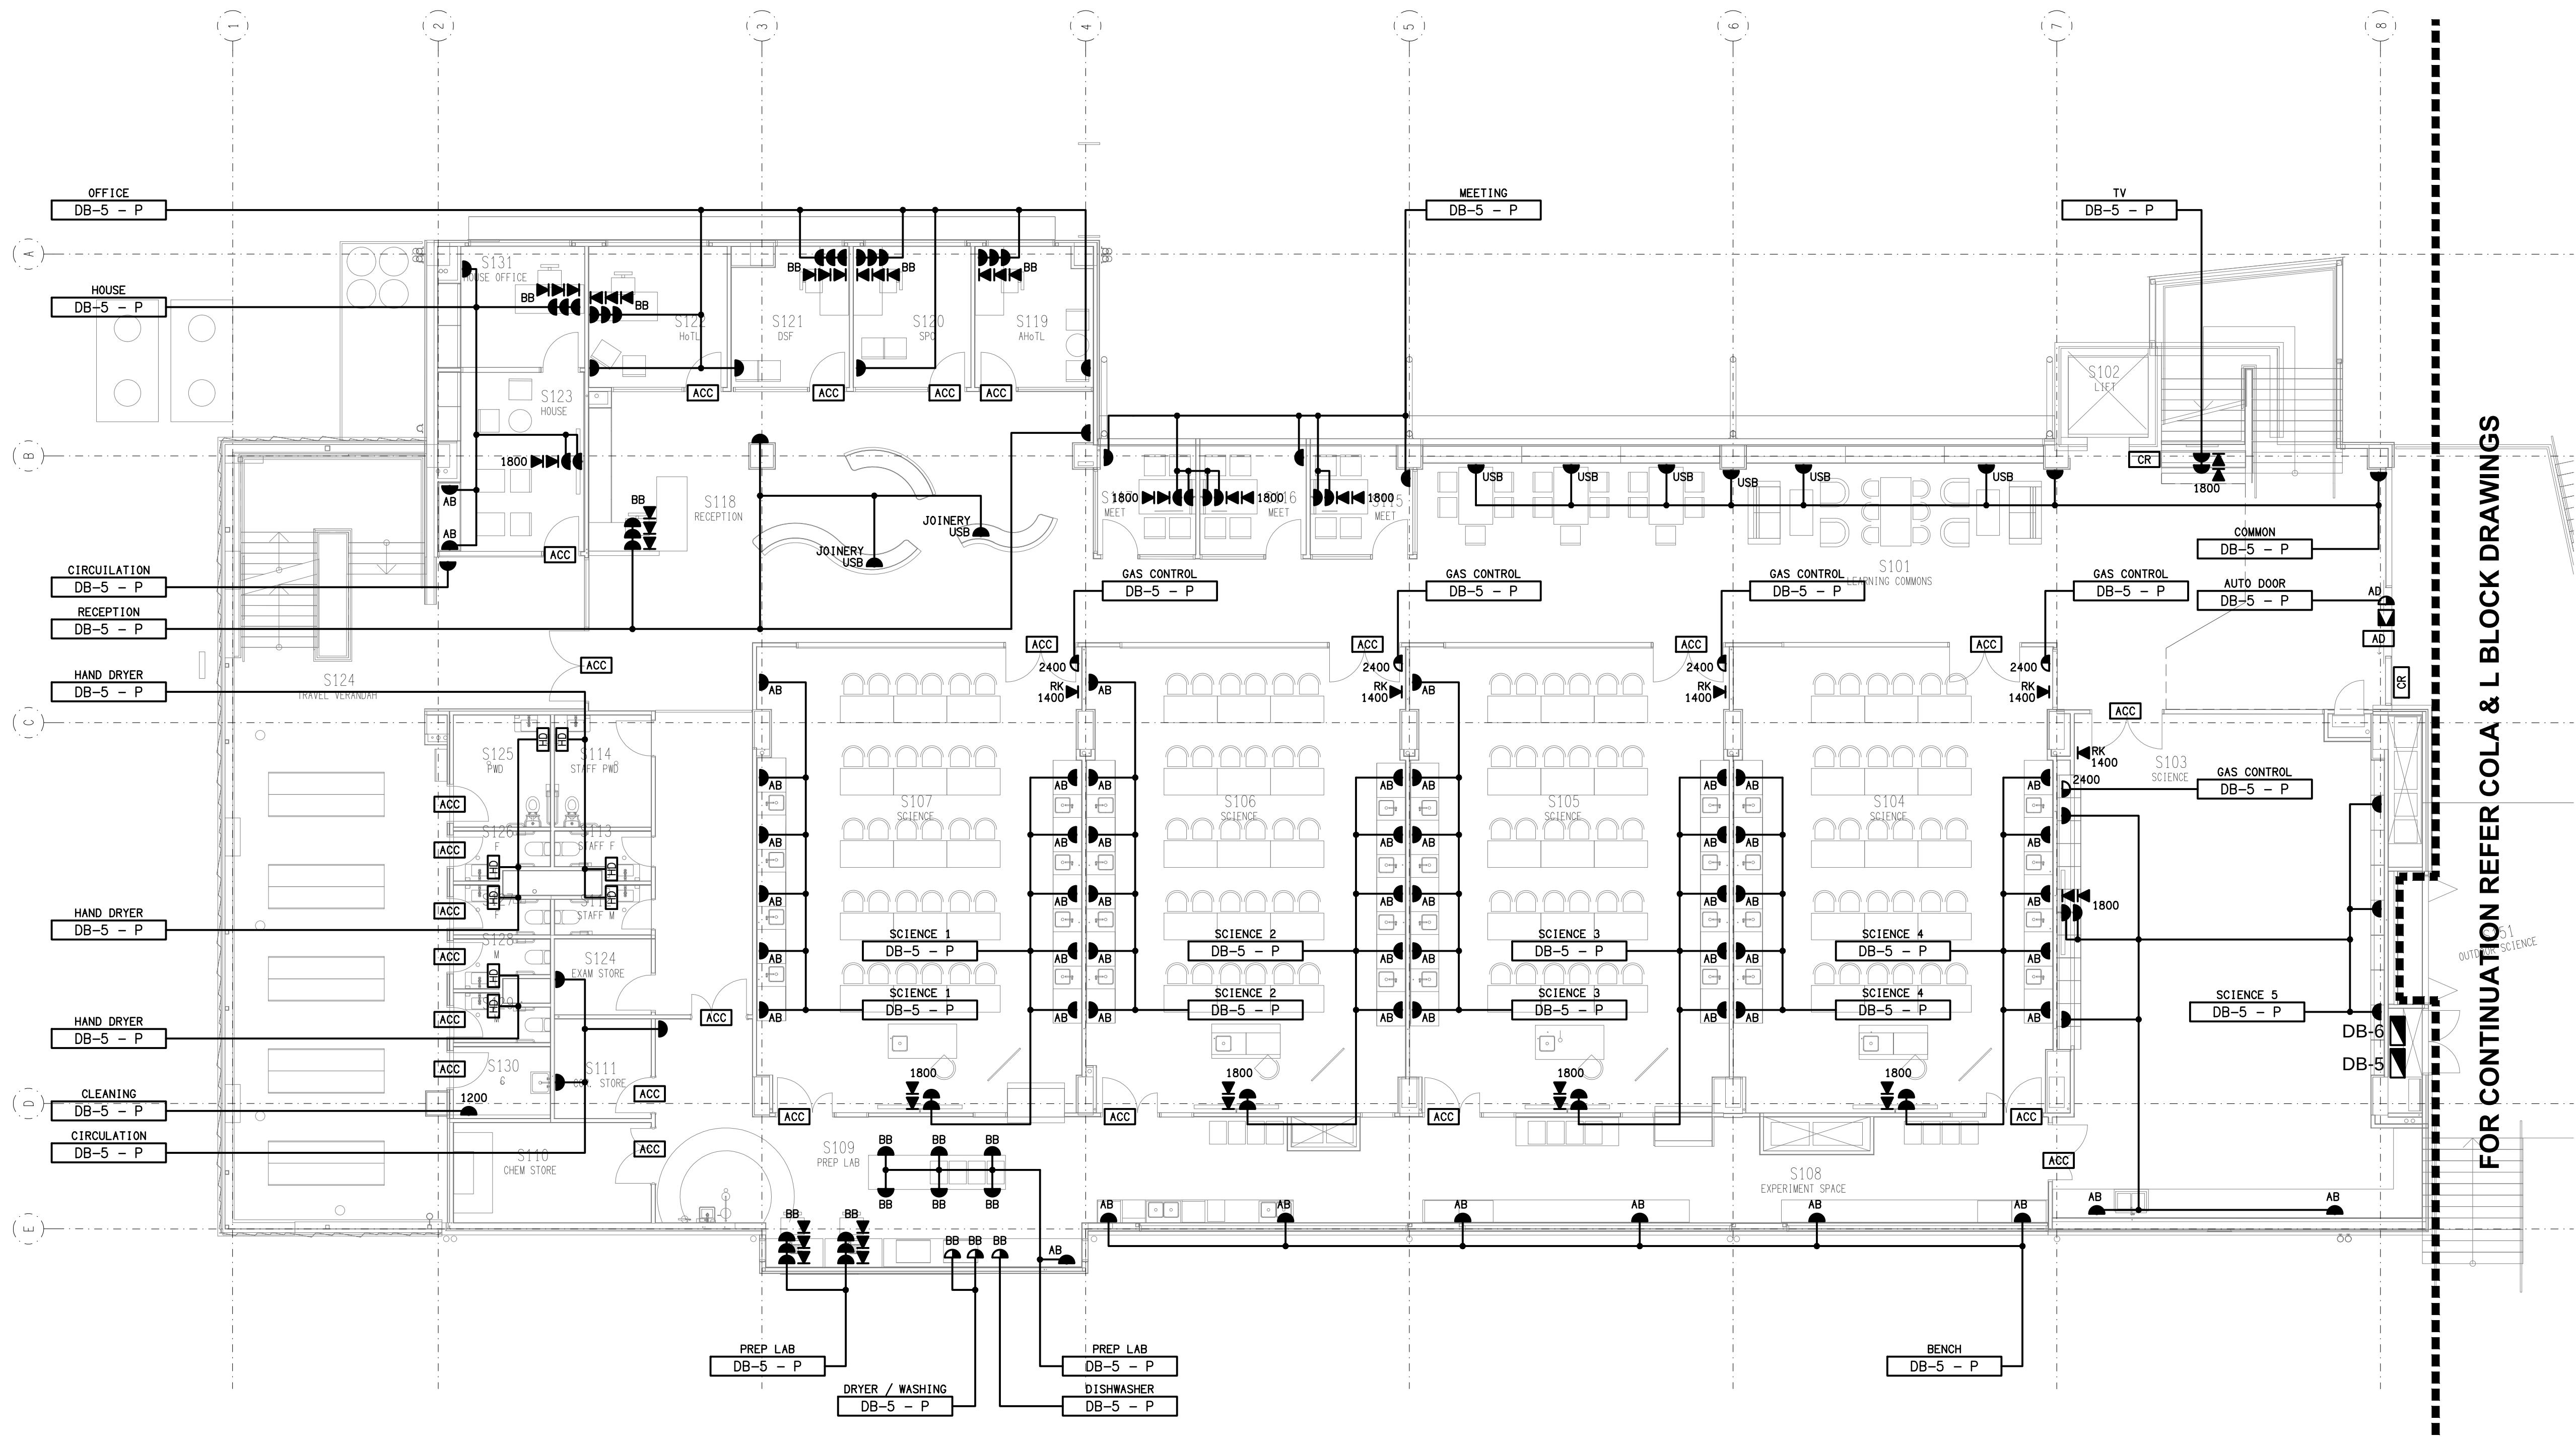

ELECTRICAL DESIGN GROUP BRISBANE
PTY LTD
ACN 092 710 793
TRADING AS:
ELECTRICAL DESIGN GROUP

THE COPYRIGHT OF THIS DRAWING
REMAINS THE PROPERTY OF THE
ELECTRICAL DESIGN GROUP.
USE FIGURED DIMENSIONS
IN PREFERENCE TO SCALE.
ALL DIMENSIONS TO BE
VERIFIED ONSITE.

ELECTRICAL DESIGN GROUP
ELECTRICAL BUILDING SERVICES CONSULTANTS
BRISBANE GOLD COAST

P.O. Box 15, Sherwood Q.4075
Phone: (07) 3278 4375
Email: brisbane@edg.net.au
Web: www.edg.net.au

PROJECT:
CANTERBURY COLLEGE SENIOR SCHOOL
TALNGAI PRECINCT

182 OLD LOGAN VILLAGE ROAD, WATERFORD

D	90% ISSUE	27/07/2026
REV.	DESCRIPTION:	DATE:

DRAWING:
**ELECTRICAL SERVICES
INFINITY CENTRE (I BLOCK)
GROUND FLOOR PLAN**

SCALE:
1:100

AT A1

PROJECT NO:
C3631a

DRAWING NO:
E14

REVISION:
D