


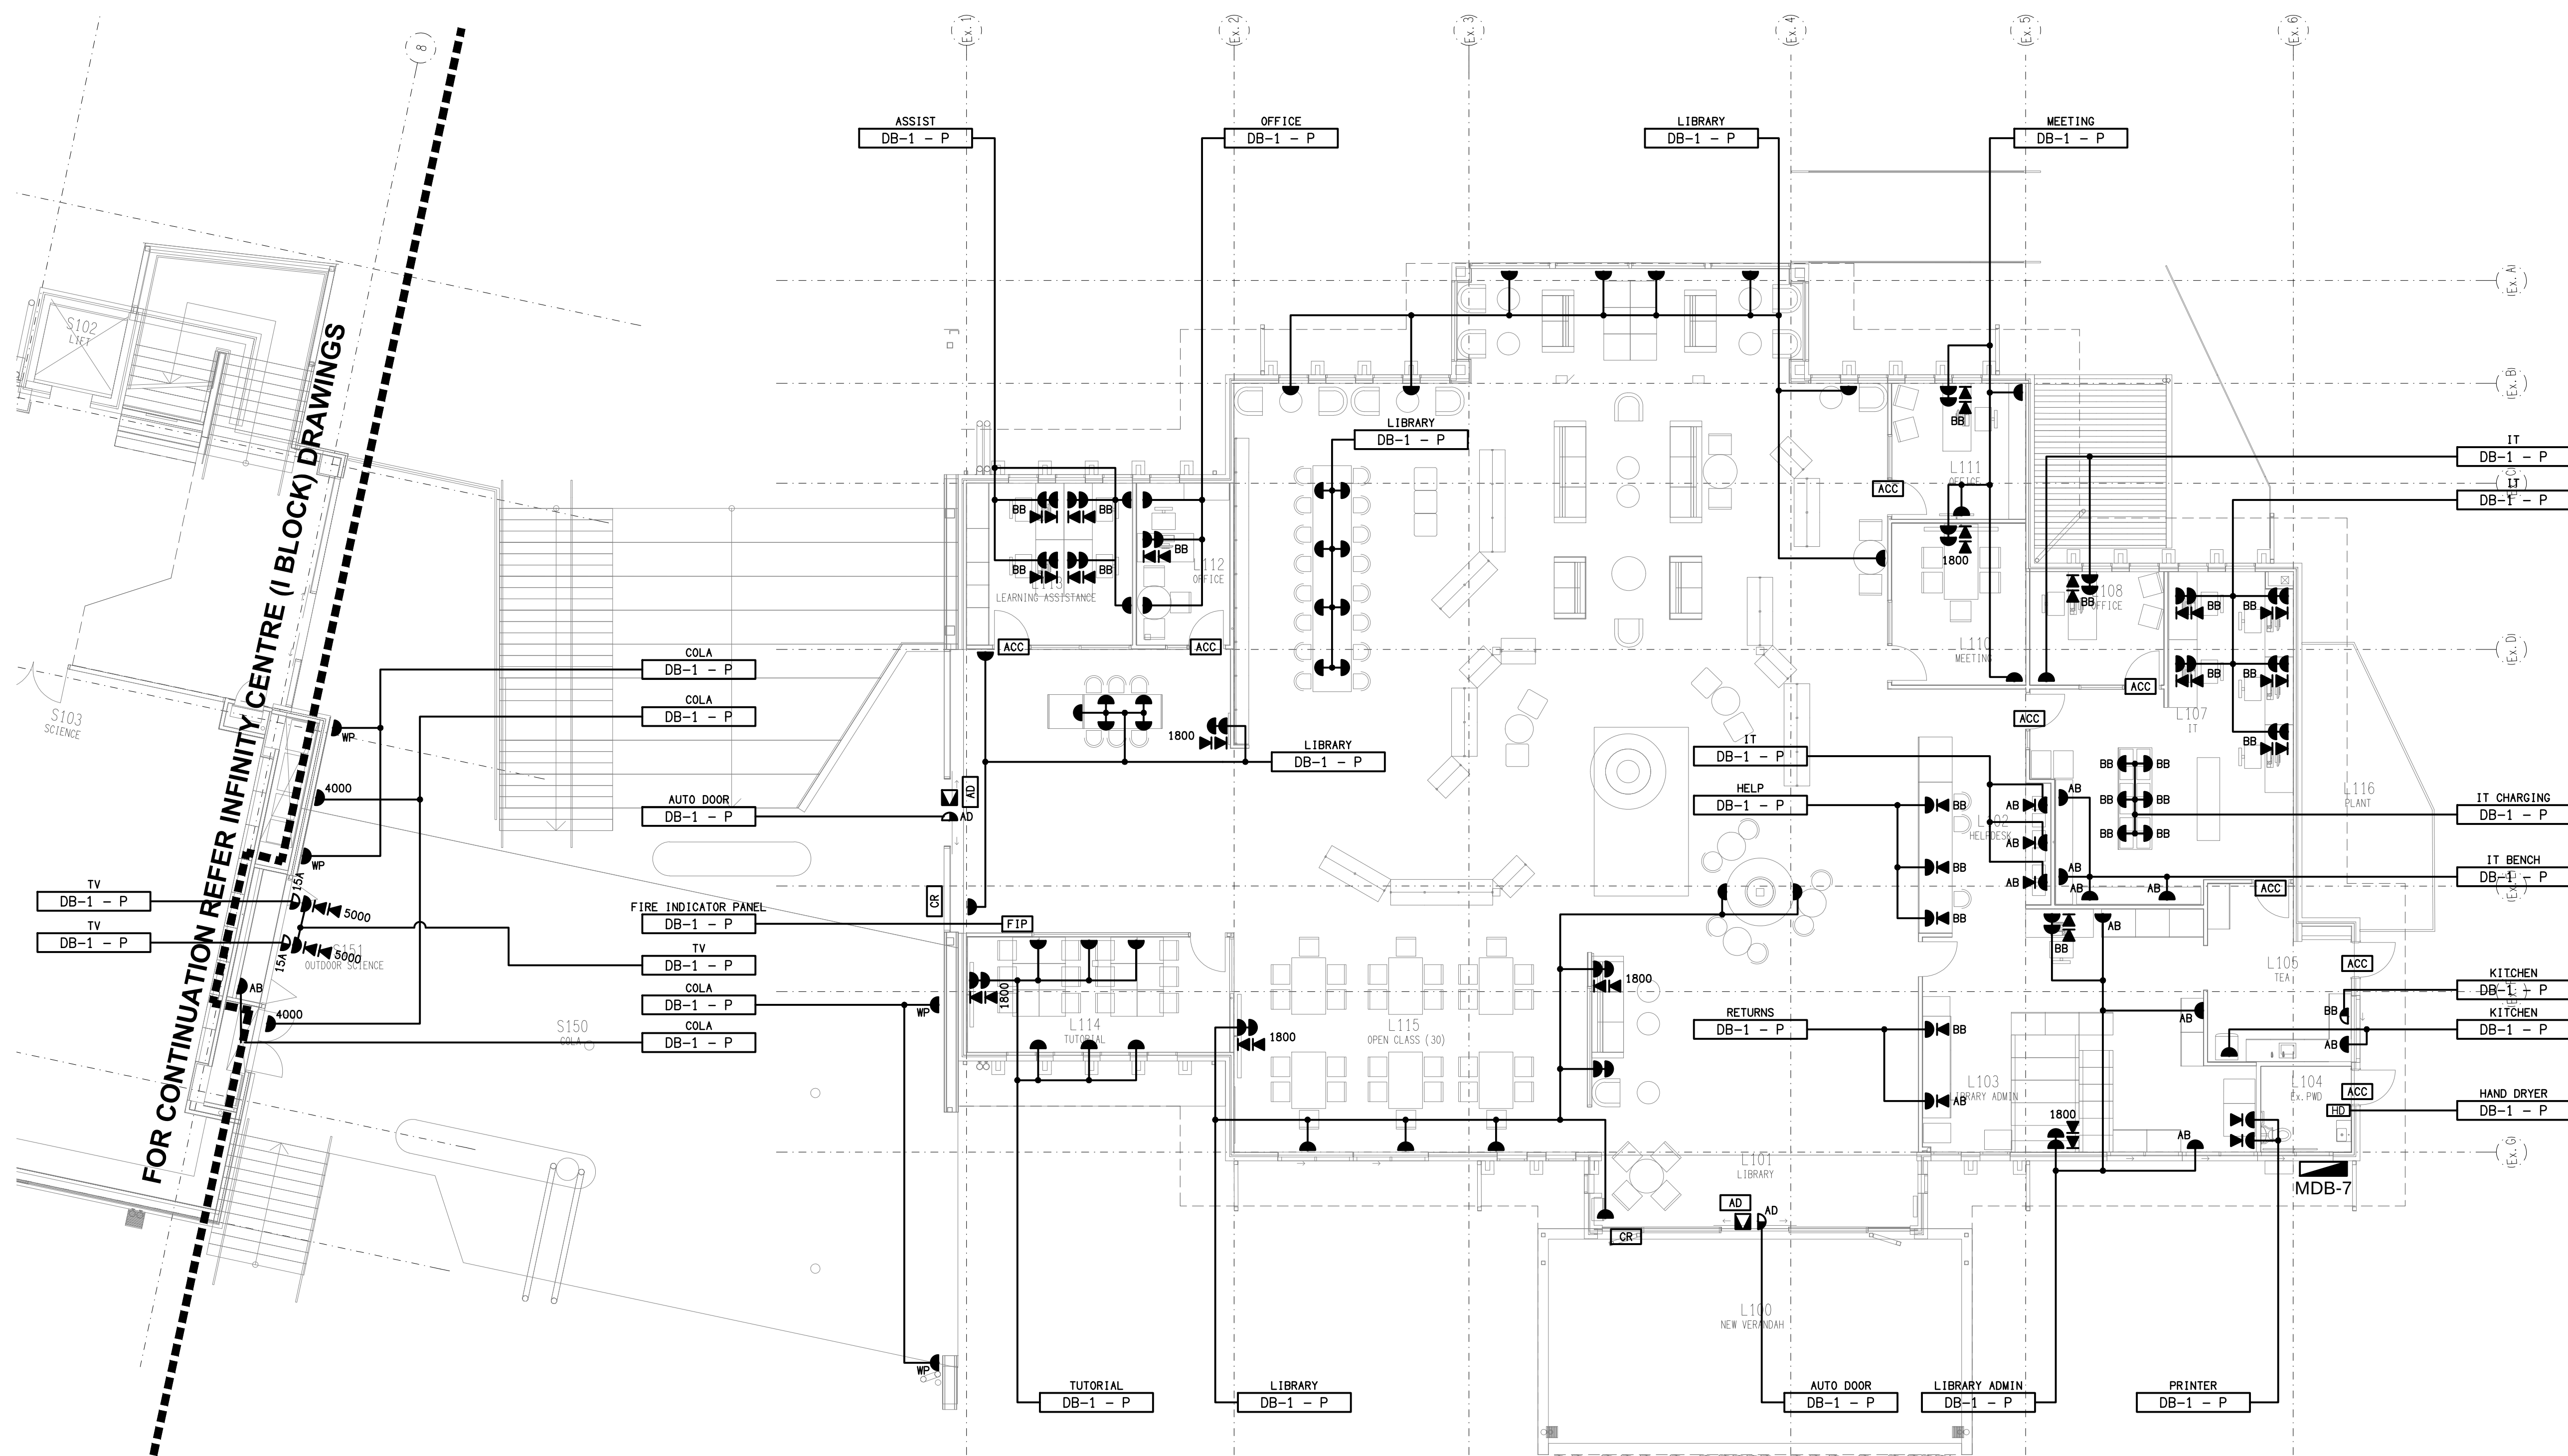

FOR CONTINUATION REFER INFINITY CENTRE (I BLOCK) DRAWINGS

ELECTRICAL DESIGN GROUP BRISBANE
PTY LTD
ACN 092 710 793
TRADING AS:
ELECTRICAL DESIGN GROUP

THE COPYRIGHT OF THIS DRAWING
REMAINS THE PROPERTY OF THE
ELECTRICAL DESIGN GROUP.
USE FIGURED DIMENSIONS
IN PREFERENCE TO SCALE.
ALL DIMENSIONS TO BE
VERIFIED ONSITE.

ELECTRICAL DESIGN GROUP
ELECTRICAL BUILDING SERVICES CONSULTANTS
BRISBANE GOLD COAST

P.O. Box 15, Sherwood Q. 4075
Phone: (07) 3278 4375
Email: brisbane@edg.net.au
Web: www.edg.net.au

PROJECT:
CANTERBURY COLLEGE SENIOR SCHOOL
TALNGAI PRECINCT

182 OLD LOGAN VILLAGE ROAD, WATERFORD

D	90% ISSUE	27/07/2026
REV.	DESCRIPTION:	DATE:

DRAWING:
ELECTRICAL SERVICES
COLA & L BLOCK
GROUND FLOOR PLAN

SCALE: 1:100 UNO	AT A1	PROJECT NO: C3631a	DRAWING NO: E23	REVISION: D
---------------------	-------	------------------------------	---------------------------	-----------------------