




DETAIL A
BISTRO BAR FLOOR PLAN
SCALE 1:50

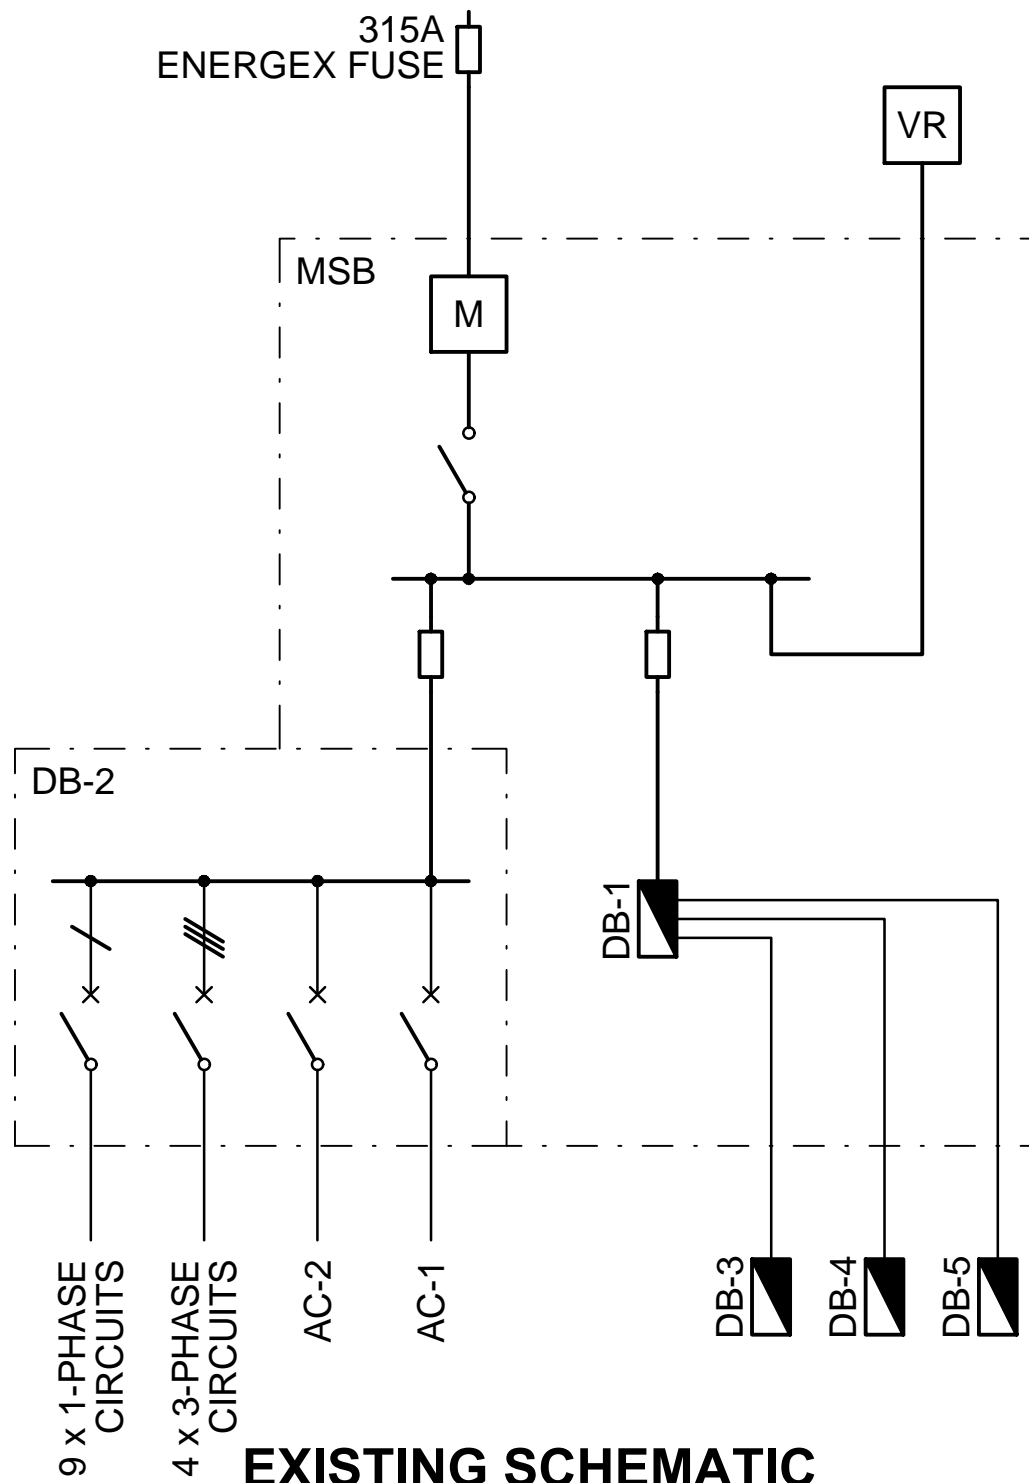


EXISTING SCHEMATIC
POWER CONFIGURATION
NOT TO SCALE

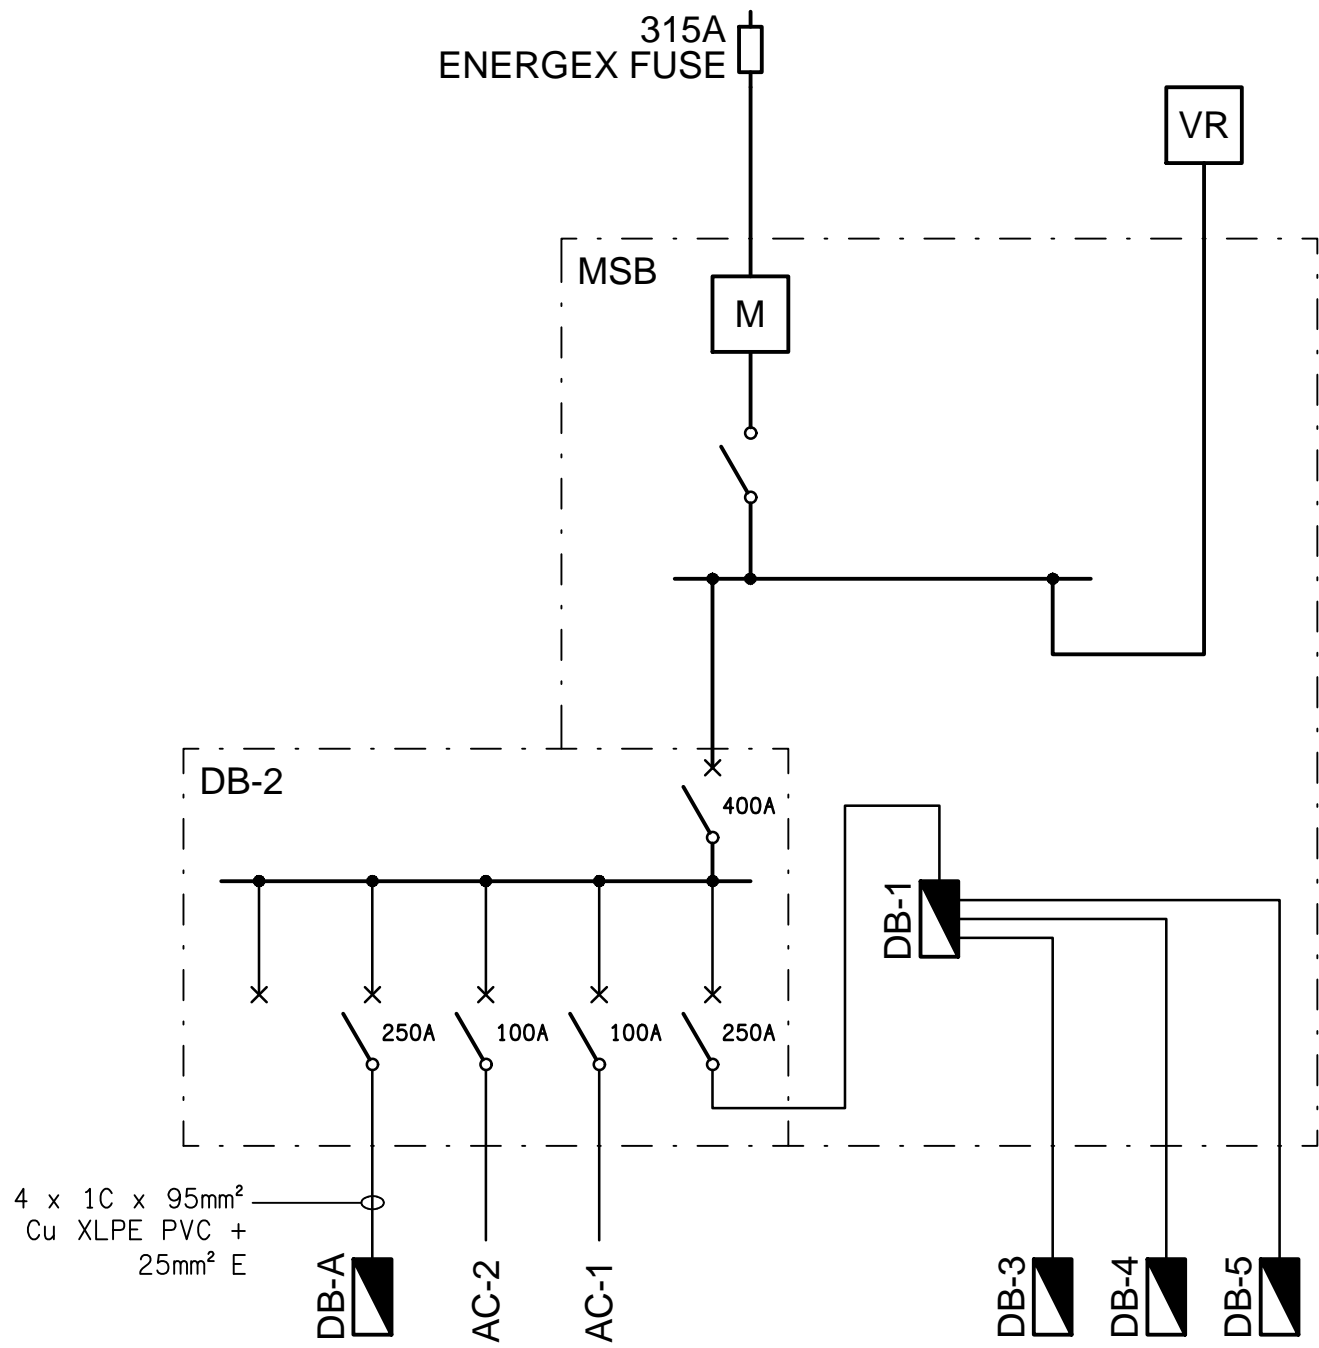


PROPOSED SCHEMATIC
POWER CONFIGURATION
NOT TO SCALE

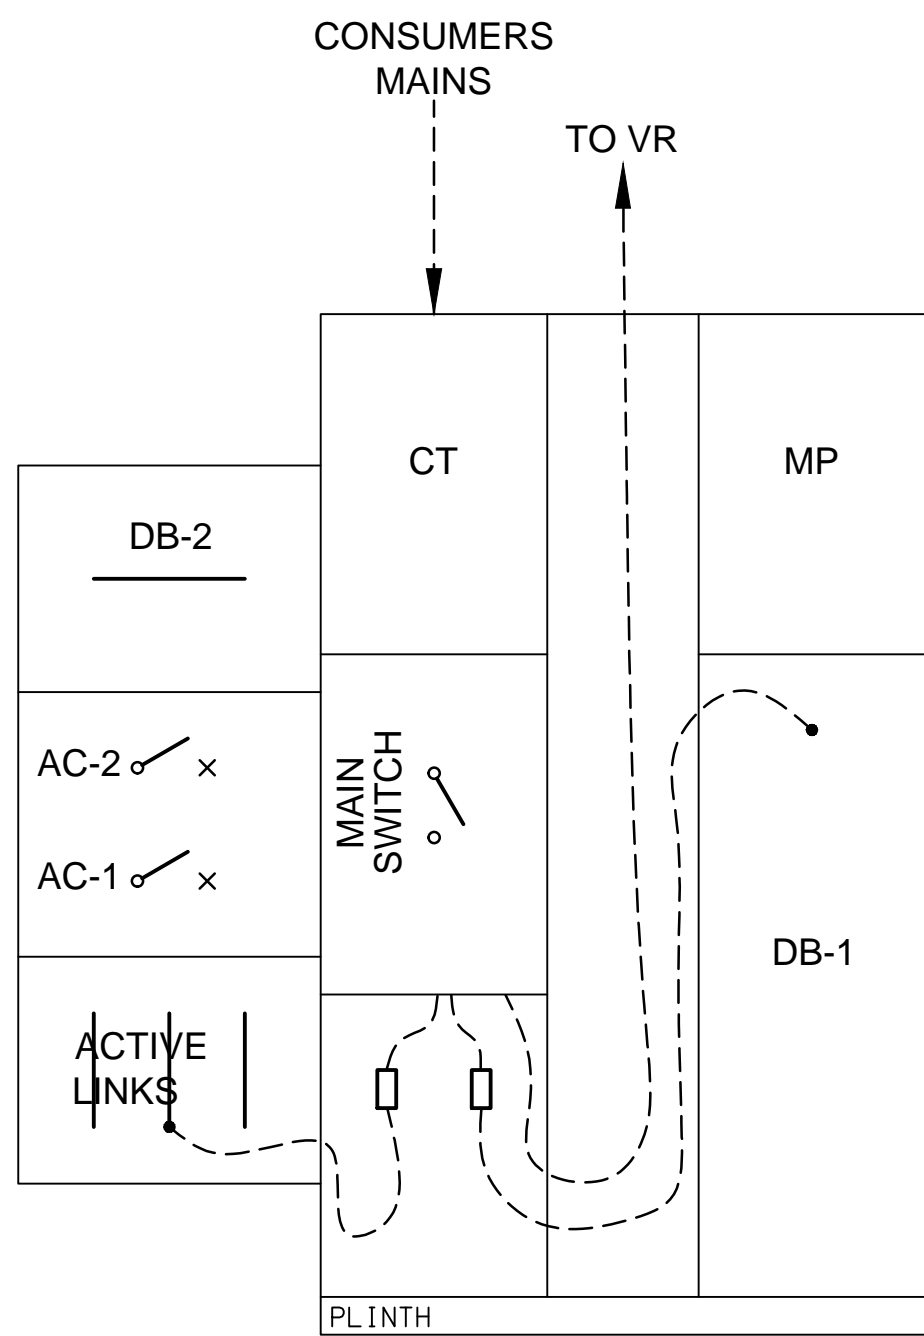

EXISTING ELEVATION
MSB CONFIGURATION
NOT TO SCALE

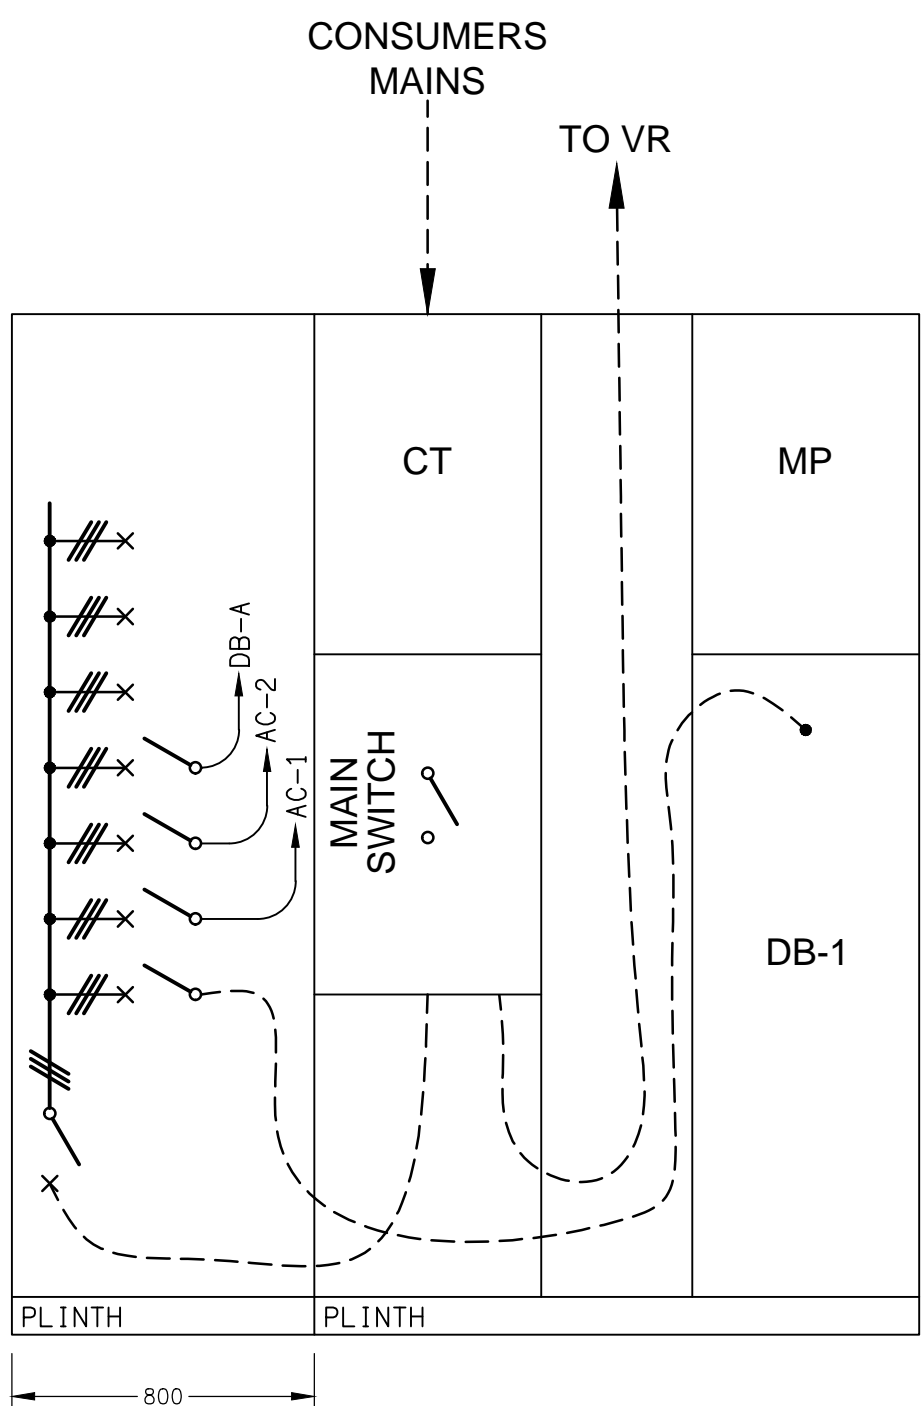

PROPOSED ELEVATION
MSB CONFIGURATION
NOT TO SCALE

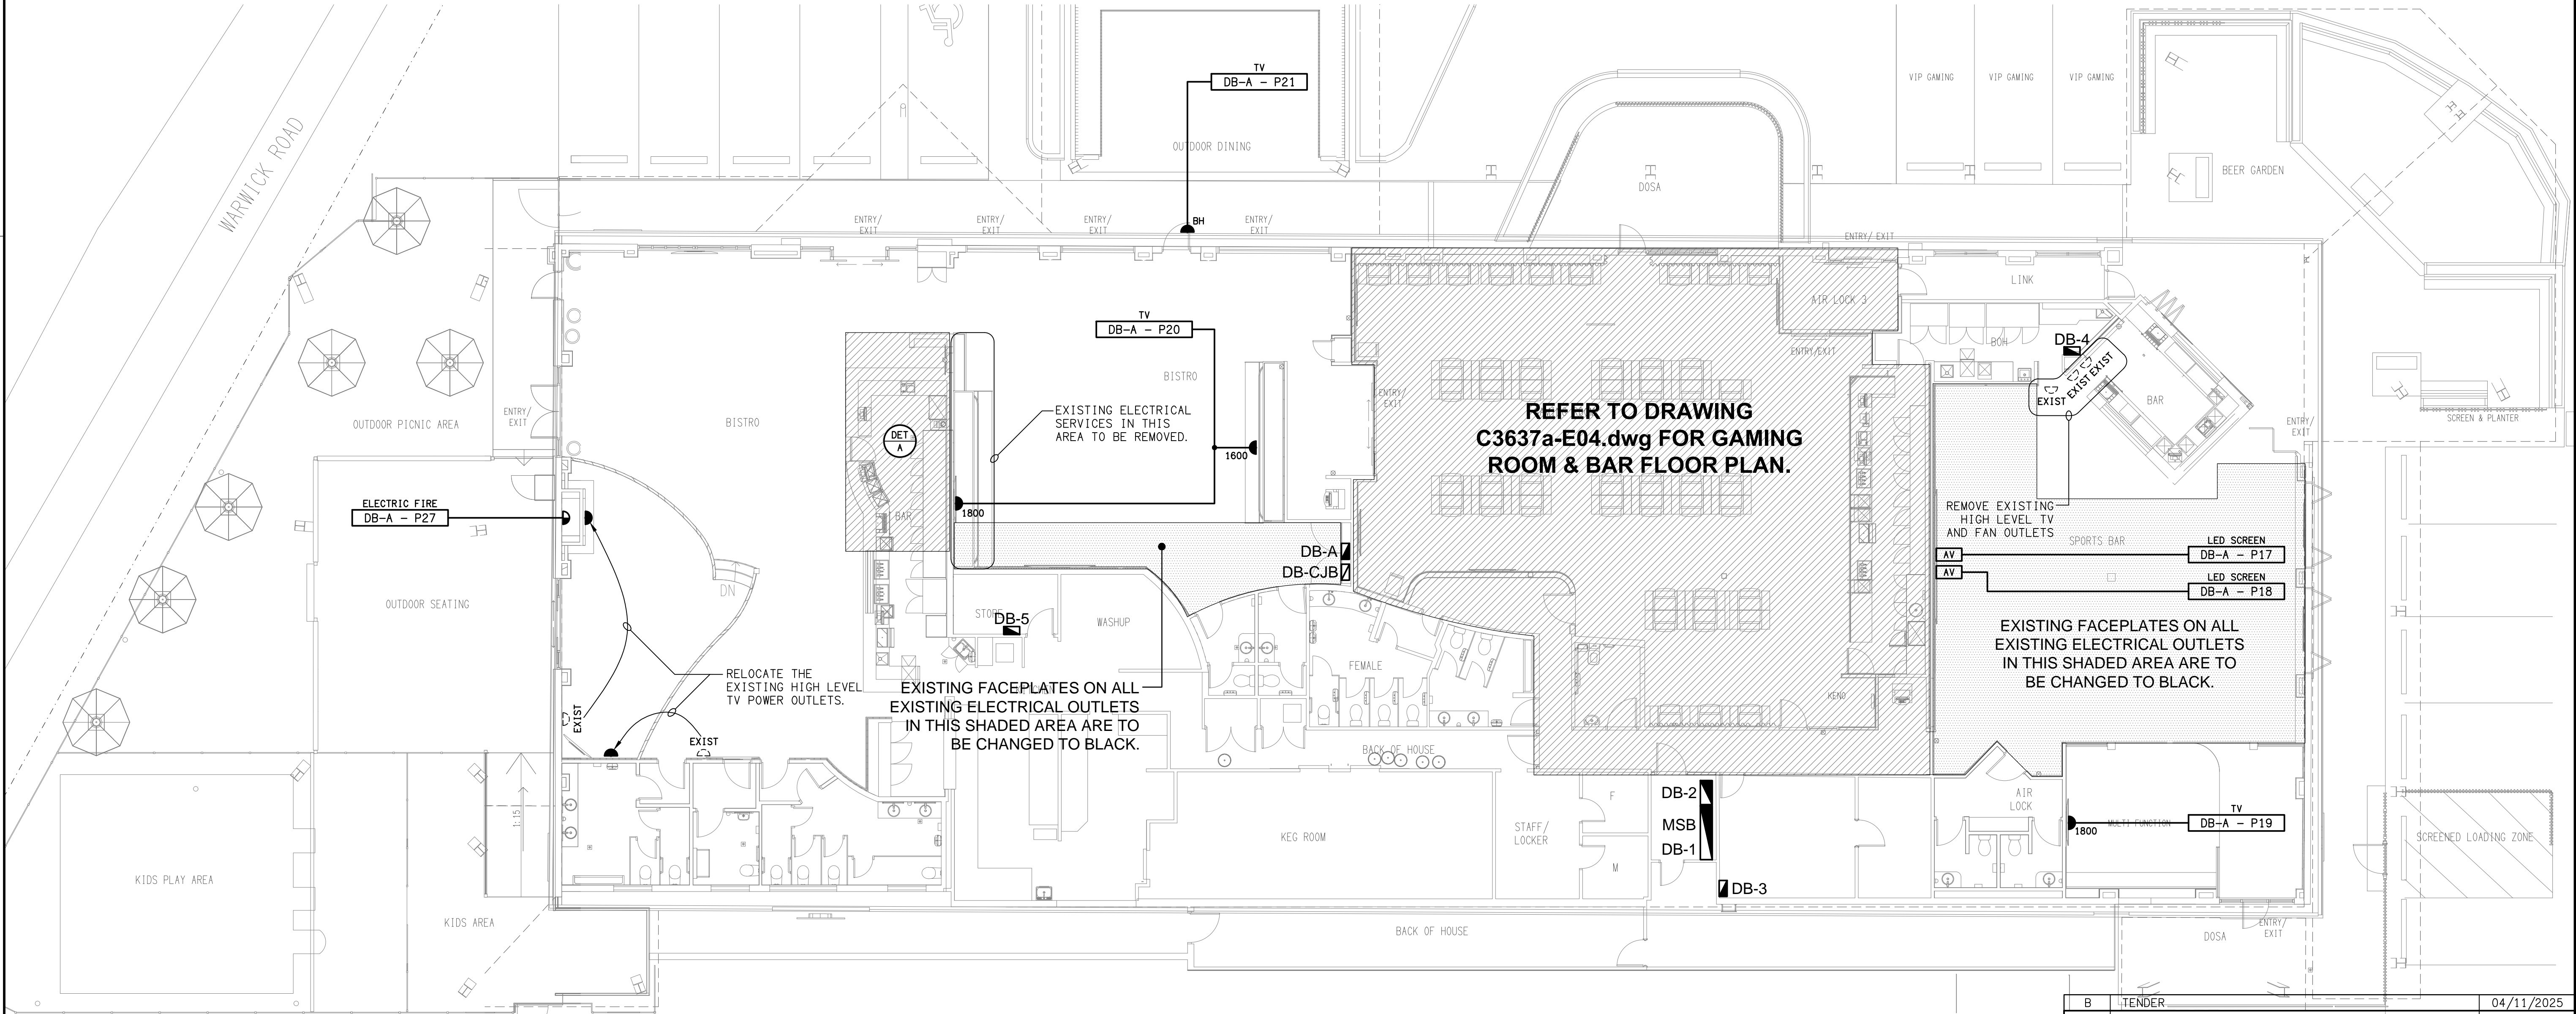

ELECTRICAL DESIGN GROUP BRISBANE
PTY LTD
ACN 092 710 793
TRADING AS:
ELECTRICAL DESIGN GROUP

THE COPYRIGHT OF THIS DRAWING
REMAINS THE PROPERTY OF THE
ELECTRICAL DESIGN GROUP.
USE FIGURED DIMENSIONS
IN PREFERENCE TO SCALE.
ALL DIMENSIONS TO BE
VERIFIED ONSITE.

ELECTRICAL DESIGN GROUP
ELECTRICAL BUILDING SERVICES CONSULTANTS
BRISBANE GOLD COAST

P.O. Box 15, Sherwood Q.4075
Phone: (07) 3278 4375
Email: brisbane@edg.net.au
Web: www.edg.net.au

PROJECT:
YAMANTO TAVERN

502-510 WARWICK ROAD, YAMANTO, QUEENSLAND

B TENDER 04/11/2025
REV: - DESCRIPTION: DATE:

DRAWING:
**ELECTRICAL SERVICES
FLOOR PLAN**

SCALE:
1:100 & 1:50

AT A1

PROJECT NO:
C3637a

DRAWING NO:
E03

REVISION:
B