



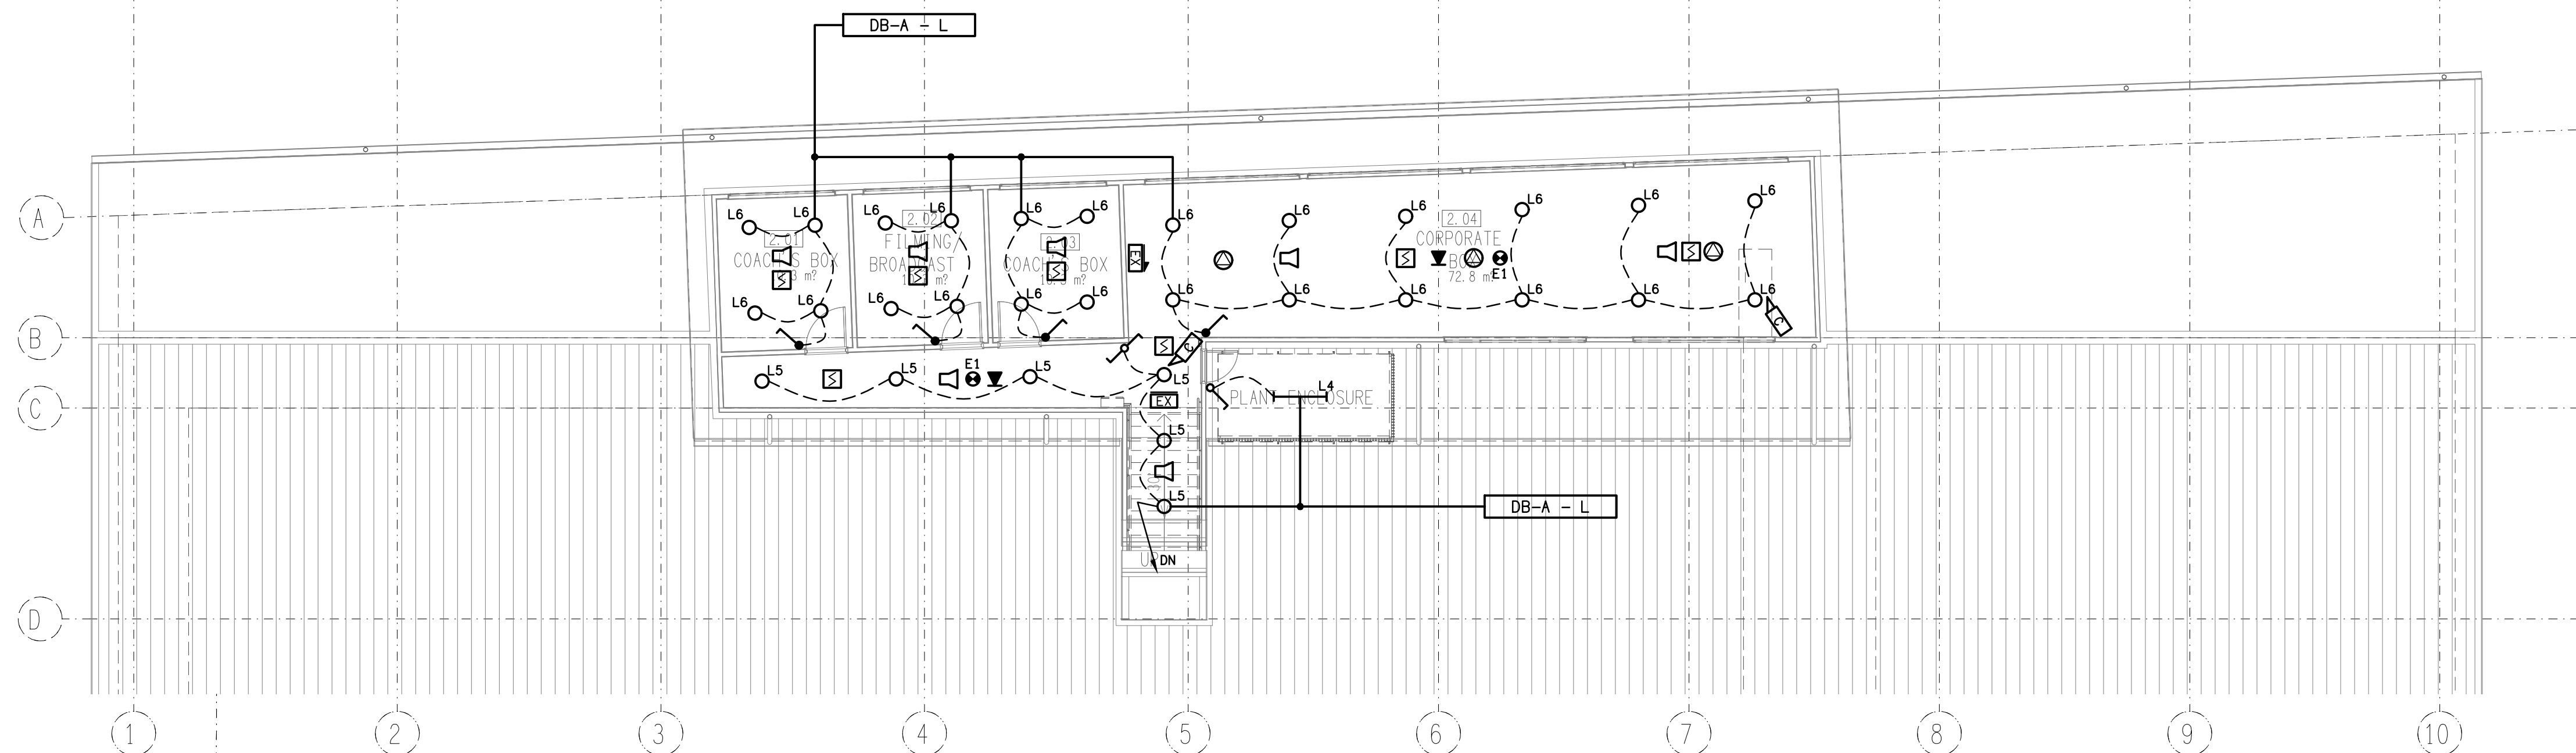

REFLECTED CEILING PLAN
LEVEL 2
SCALE 1: 100

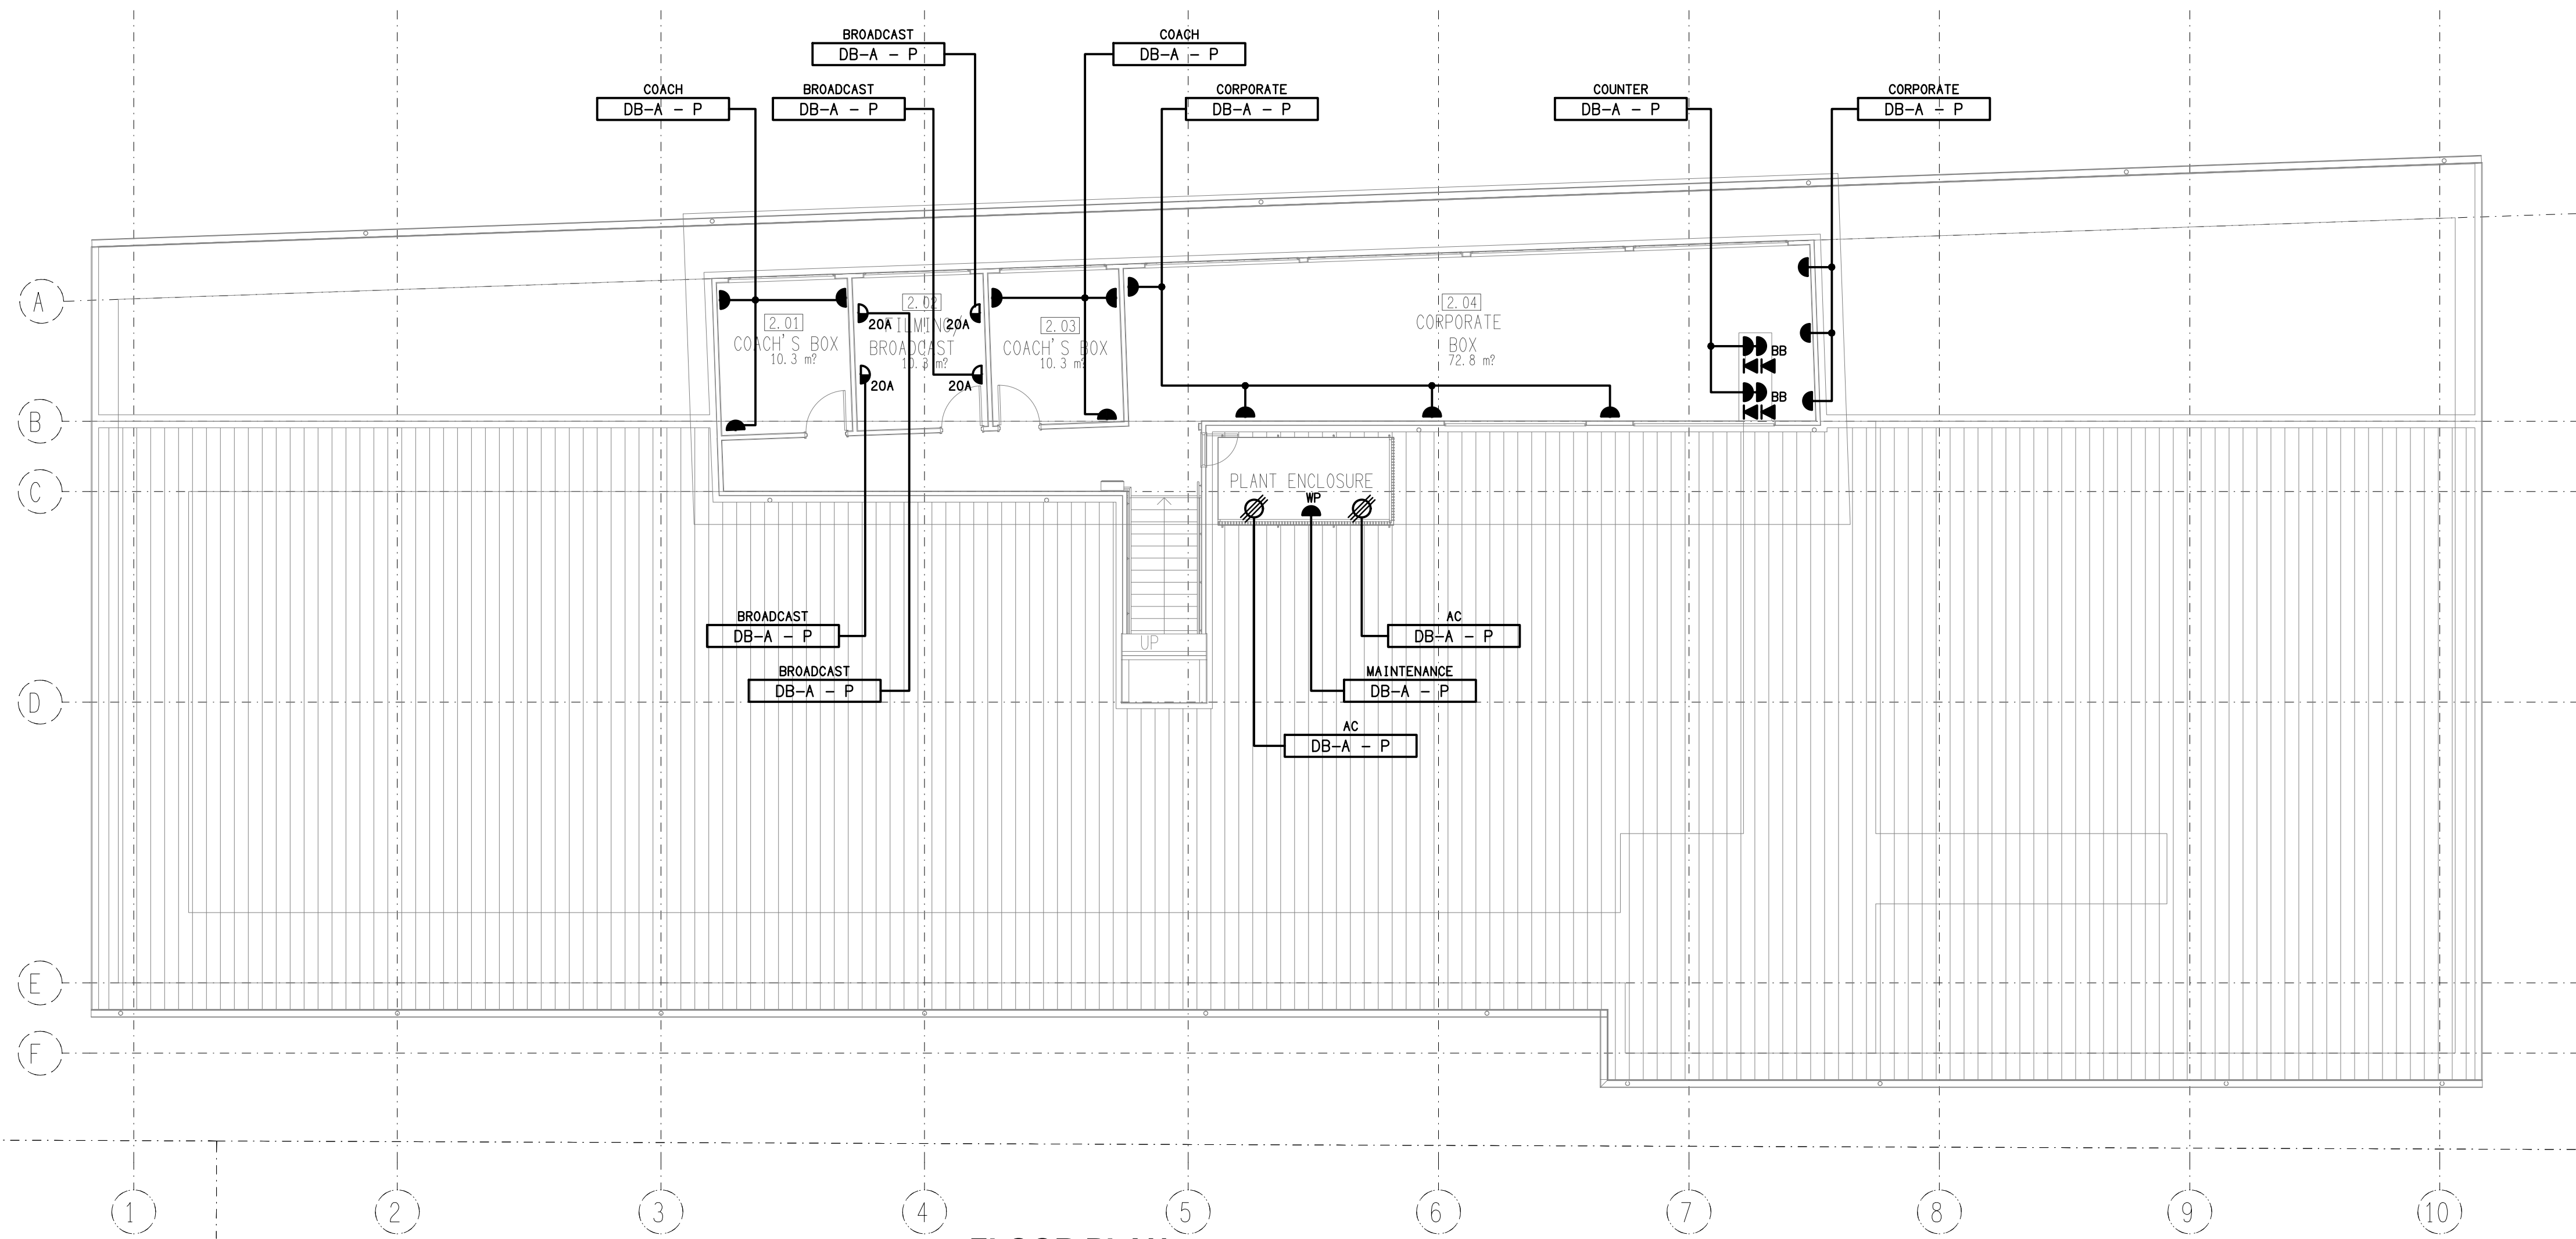

FLOOR PLAN
LEVEL 2
SCALE 1: 100

ELECTRICAL DESIGN GROUP BRISBANE
PTY LTD
ACN 092 710 793
TRADING AS:
ELECTRICAL DESIGN GROUP

THE COPYRIGHT OF THIS DRAWING
REMAINS THE PROPERTY OF THE
ELECTRICAL DESIGN GROUP.
USE FIGURED DIMENSIONS
IN PREFERENCE TO SCALE.
ALL DIMENSIONS TO BE
VERIFIED ONSITE.

ELECTRICAL DESIGN GROUP
ELECTRICAL BUILDING SERVICES CONSULTANTS
BRISBANE GOLD COAST
P.O.Box 15, Sherwood Q.4075
Phone: (07) 3278 4375
Email: brisbane@edg.net.au
Web: www.edg.net.au

PROJECT:
BROTHERS RUGBY CLUB - REDEVELOPMENT
103 CROSBY ROAD, ALBION, QUEENSLAND

A	PRELIMINARY	22/07/2026
REV:	DESCRIPTION:	DATE:
DRAWING:	ELECTRICAL SERVICES LEVEL 2 PLANS	
SCALE: 1:100 UNO	AT A1	PROJECT NO: C3657a DRAWING NO: E08 REVISION: A