




**REFLECTED CEILING PLAN**  
MEZZANINE LEVEL  
SCALE 1:50

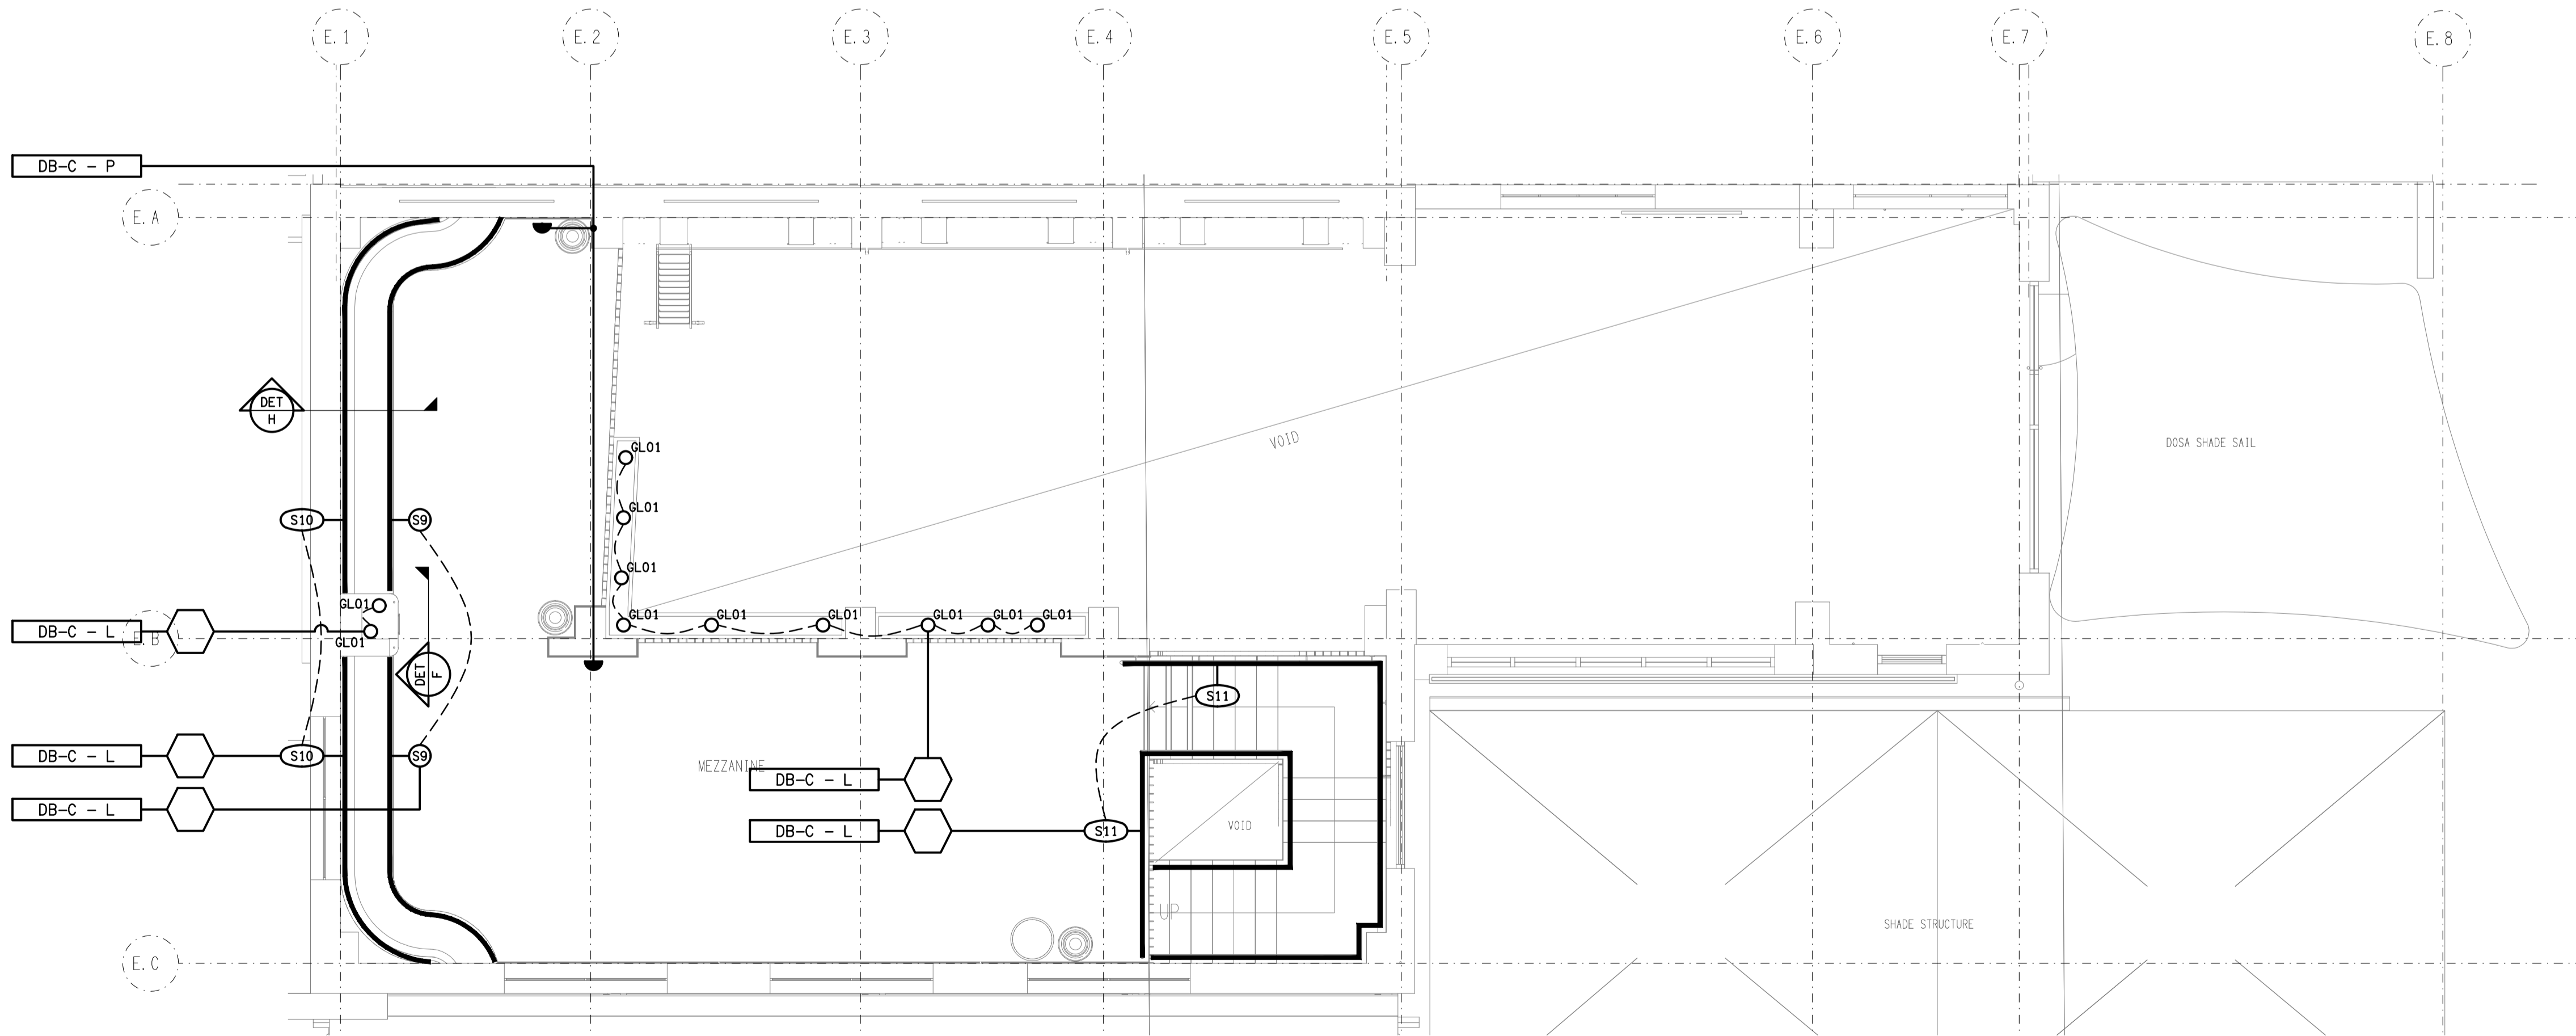


**FLOOR PLAN**  
MEZZANINE LEVEL  
SCALE 1:50

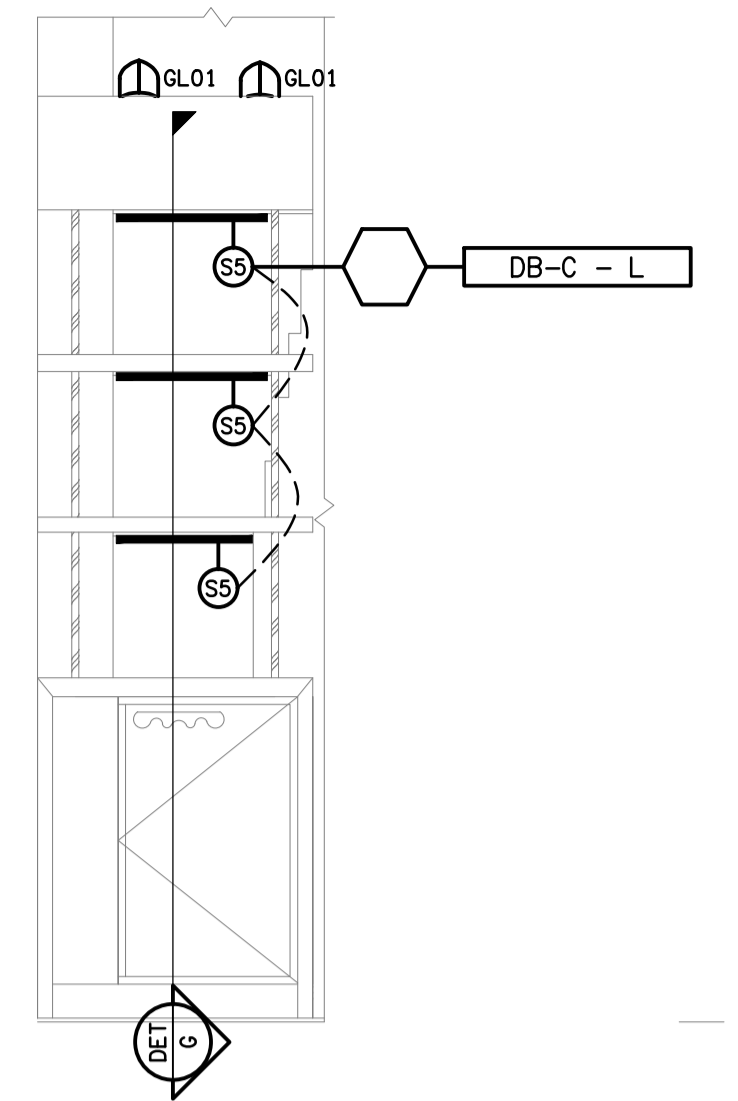

**DETAIL F**  
WAITERS STATION ELEVATION  
SCALE 1:20

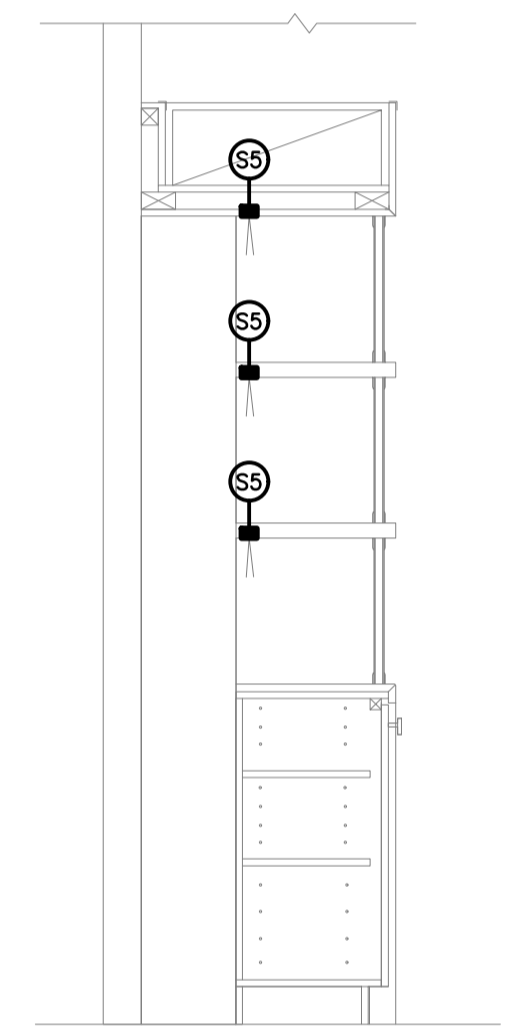

**DETAIL G**  
WAITERS STATION SECTION  
SCALE 1:20

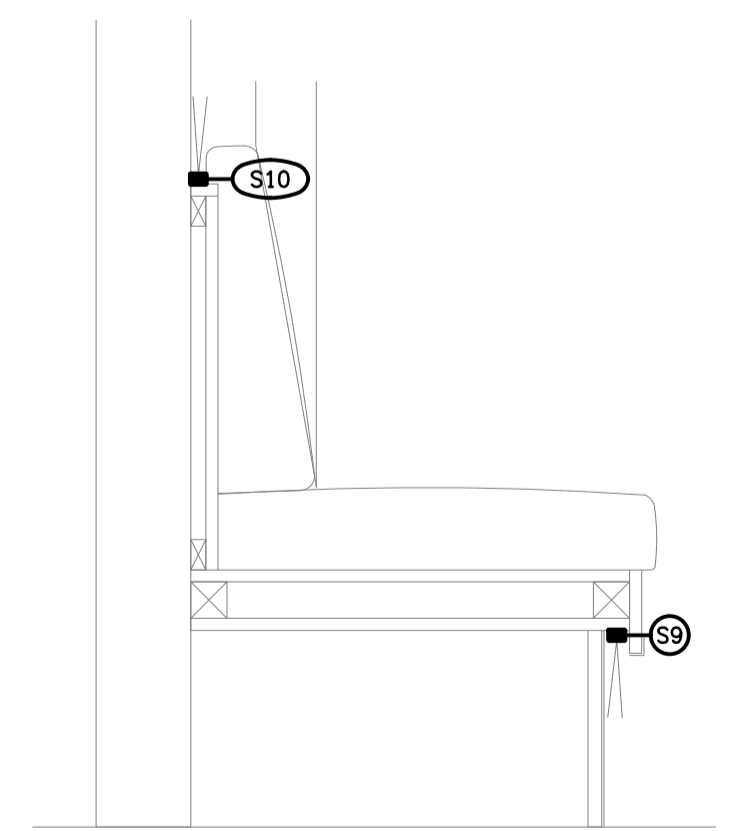

**DETAIL H**  
BANQUETTE SEAT SECTION  
SCALE 1:10

ELECTRICAL DESIGN GROUP BRISBANE  
PTY LTD  
ACN 092 710 793  
TRADING AS:  
ELECTRICAL DESIGN GROUP

THE COPYRIGHT OF THIS DRAWING  
REMAINS THE PROPERTY OF THE  
ELECTRICAL DESIGN GROUP.

USE FIGURED DIMENSIONS  
IN PREFERENCE TO SCALE.  
ALL DIMENSIONS TO BE  
VERIFIED ONSITE.

**ELECTRICAL DESIGN GROUP**  
ELECTRICAL BUILDING SERVICES CONSULTANTS  
BRISBANE GOLD COAST

P.O. Box 15, Sherwood Q.4075  
Phone: (07) 3278 4375  
Email: brisbane@edg.net.au  
Web: www.edg.net.au

PROJECT:  
**BREAKFAST CREEK HOTEL - STAGE 2**

2 KINGSFORD SMITH DRIVE, ALBION, QUEENSLAND

|      |              |            |
|------|--------------|------------|
| A    | PRELIMINARY  | 23/12/2025 |
| REV. | DESCRIPTION: | DATE:      |

DRAWING:  
**ELECTRICAL SERVICES**  
ZONE E  
SUBSTATION BAR MEZZANINE PLANS

SCALE: 1:50 UNO AT A1  
PROJECT NO: **C3674a**  
DRAWING NO: **EE03**  
REVISION: **A**