



DETAIL A
BAR COUNTER LIGHTING SECTION
SCALE 1:10

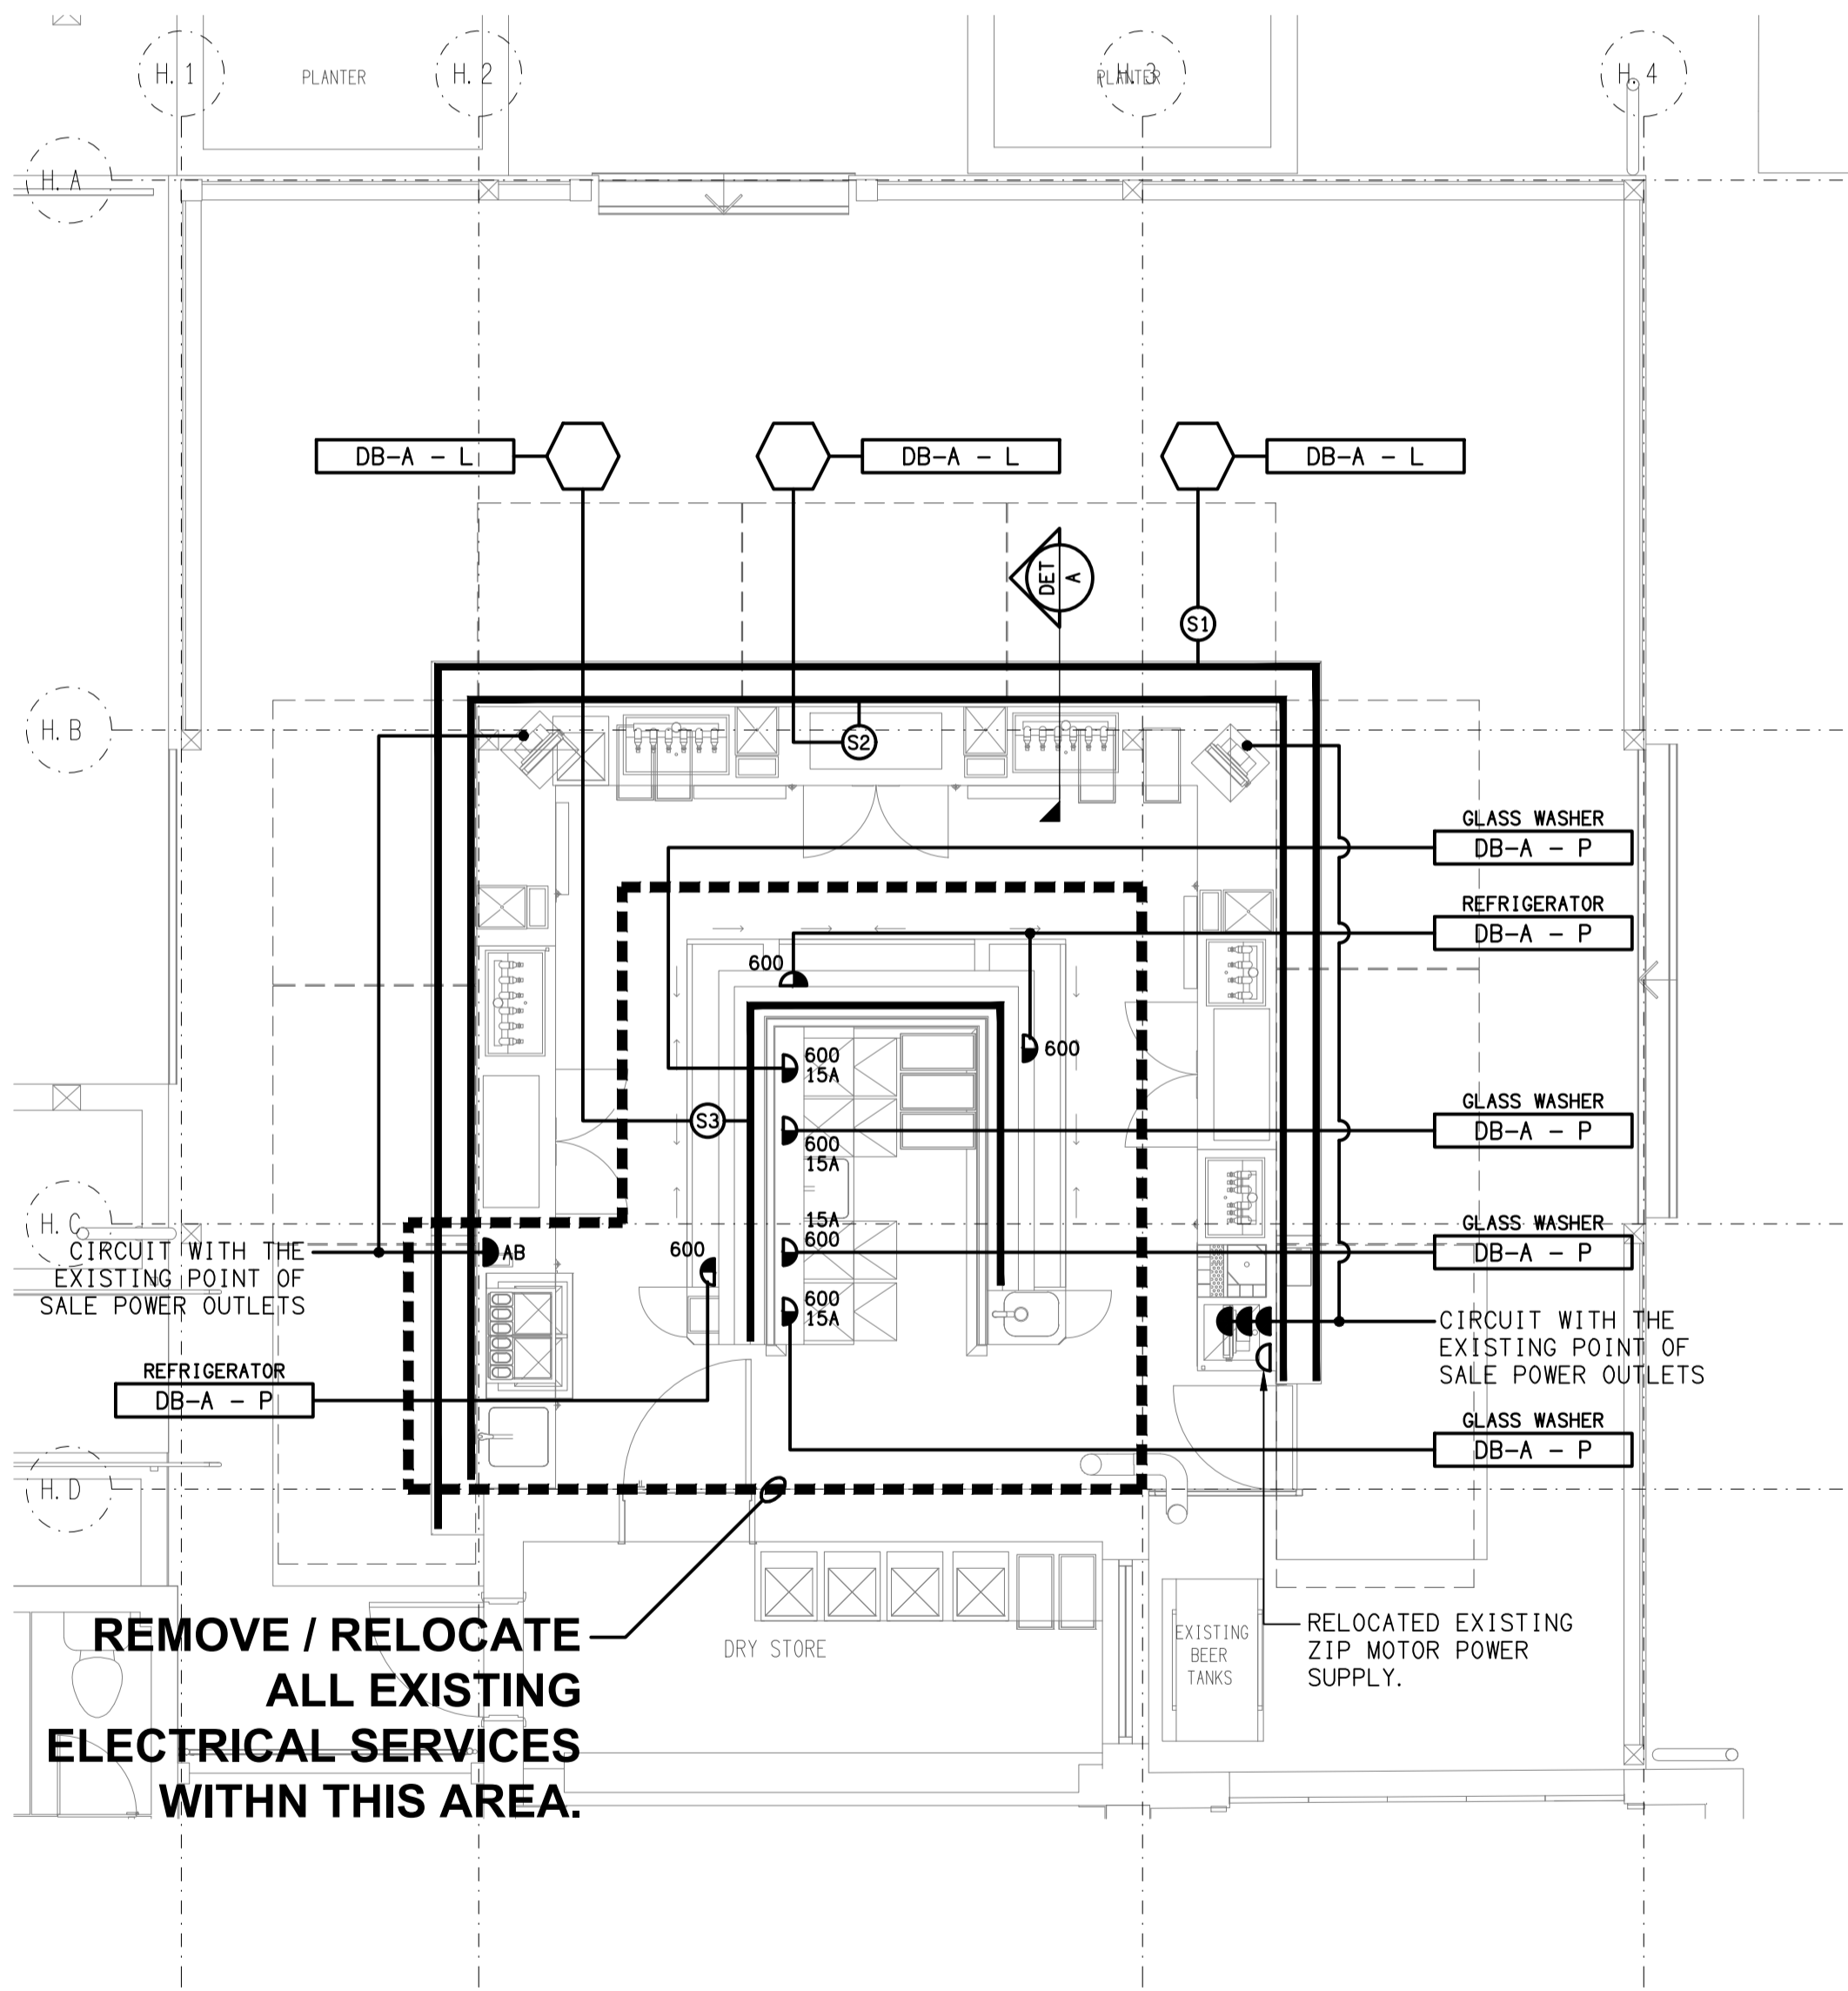

FLOOR PLAN
STAGHORN BAR
SCALE 1:50

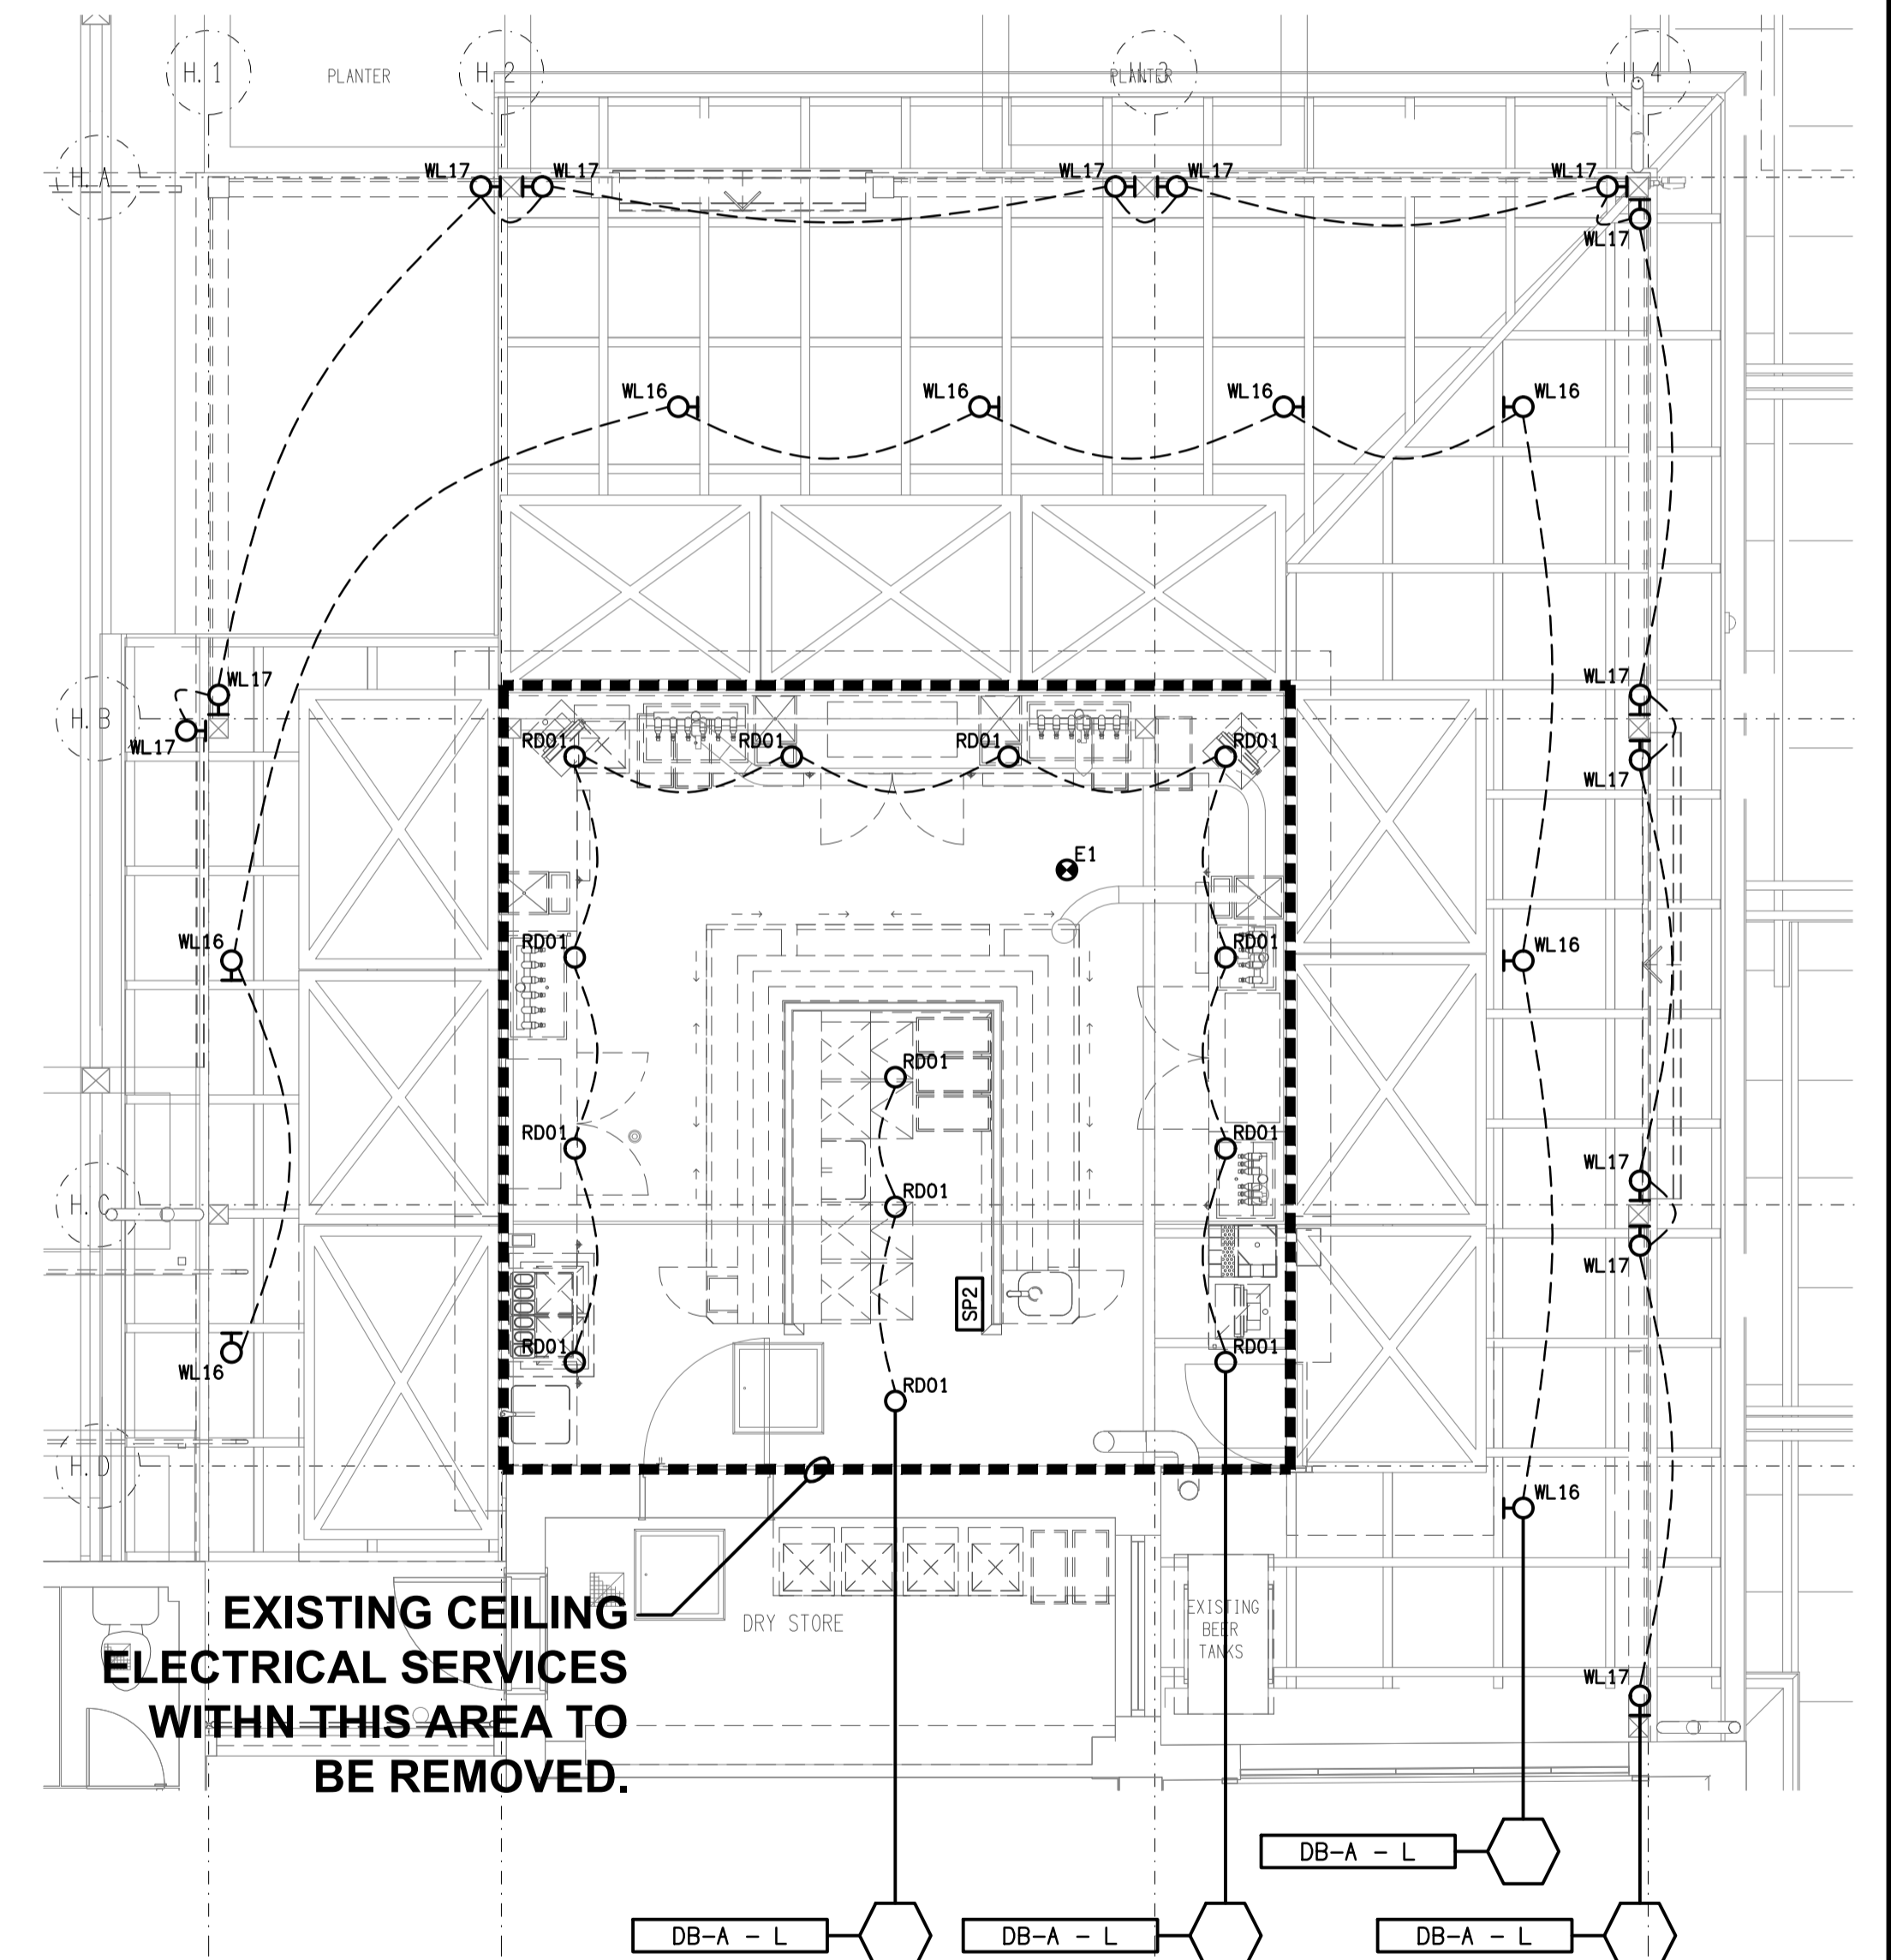

REFLECTED CEILING PLAN
STAGHORN BAR
SCALE 1:50

ELECTRICAL DESIGN GROUP BRISBANE
PTY LTD
ACN 092 710 793
TRADING AS:
ELECTRICAL DESIGN GROUP

THE COPYRIGHT OF THIS DRAWING
REMAINS THE PROPERTY OF THE
ELECTRICAL DESIGN GROUP.
USE FIGURED DIMENSIONS
IN PREFERENCE TO SCALE.
ALL DIMENSIONS TO BE
VERIFIED ONSITE.

ELECTRICAL DESIGN GROUP
ELECTRICAL BUILDING SERVICES CONSULTANTS
BRISBANE GOLD COAST

P.O. Box 15, Sherwood Q.4075
Phone: (07) 3278 4375
Email: brisbane@edg.net.au
Web: www.edg.net.au

PROJECT:
BREAKFAST CREEK HOTEL - STAGE 2
2 KINGSFORD SMITH DRIVE, ALBION, QUEENSLAND

A	PRELIMINARY	23/12/2025
REV.	DESCRIPTION:	DATE:
DRAWING: ELECTRICAL SERVICES ZONE H STAGHORN BAR PLANS		
SCALE: 1:50 UNO	PROJECT NO: C3674a	DRAWING NO: EH01
AT A1	REVISION: A	