



# BURGER URGE

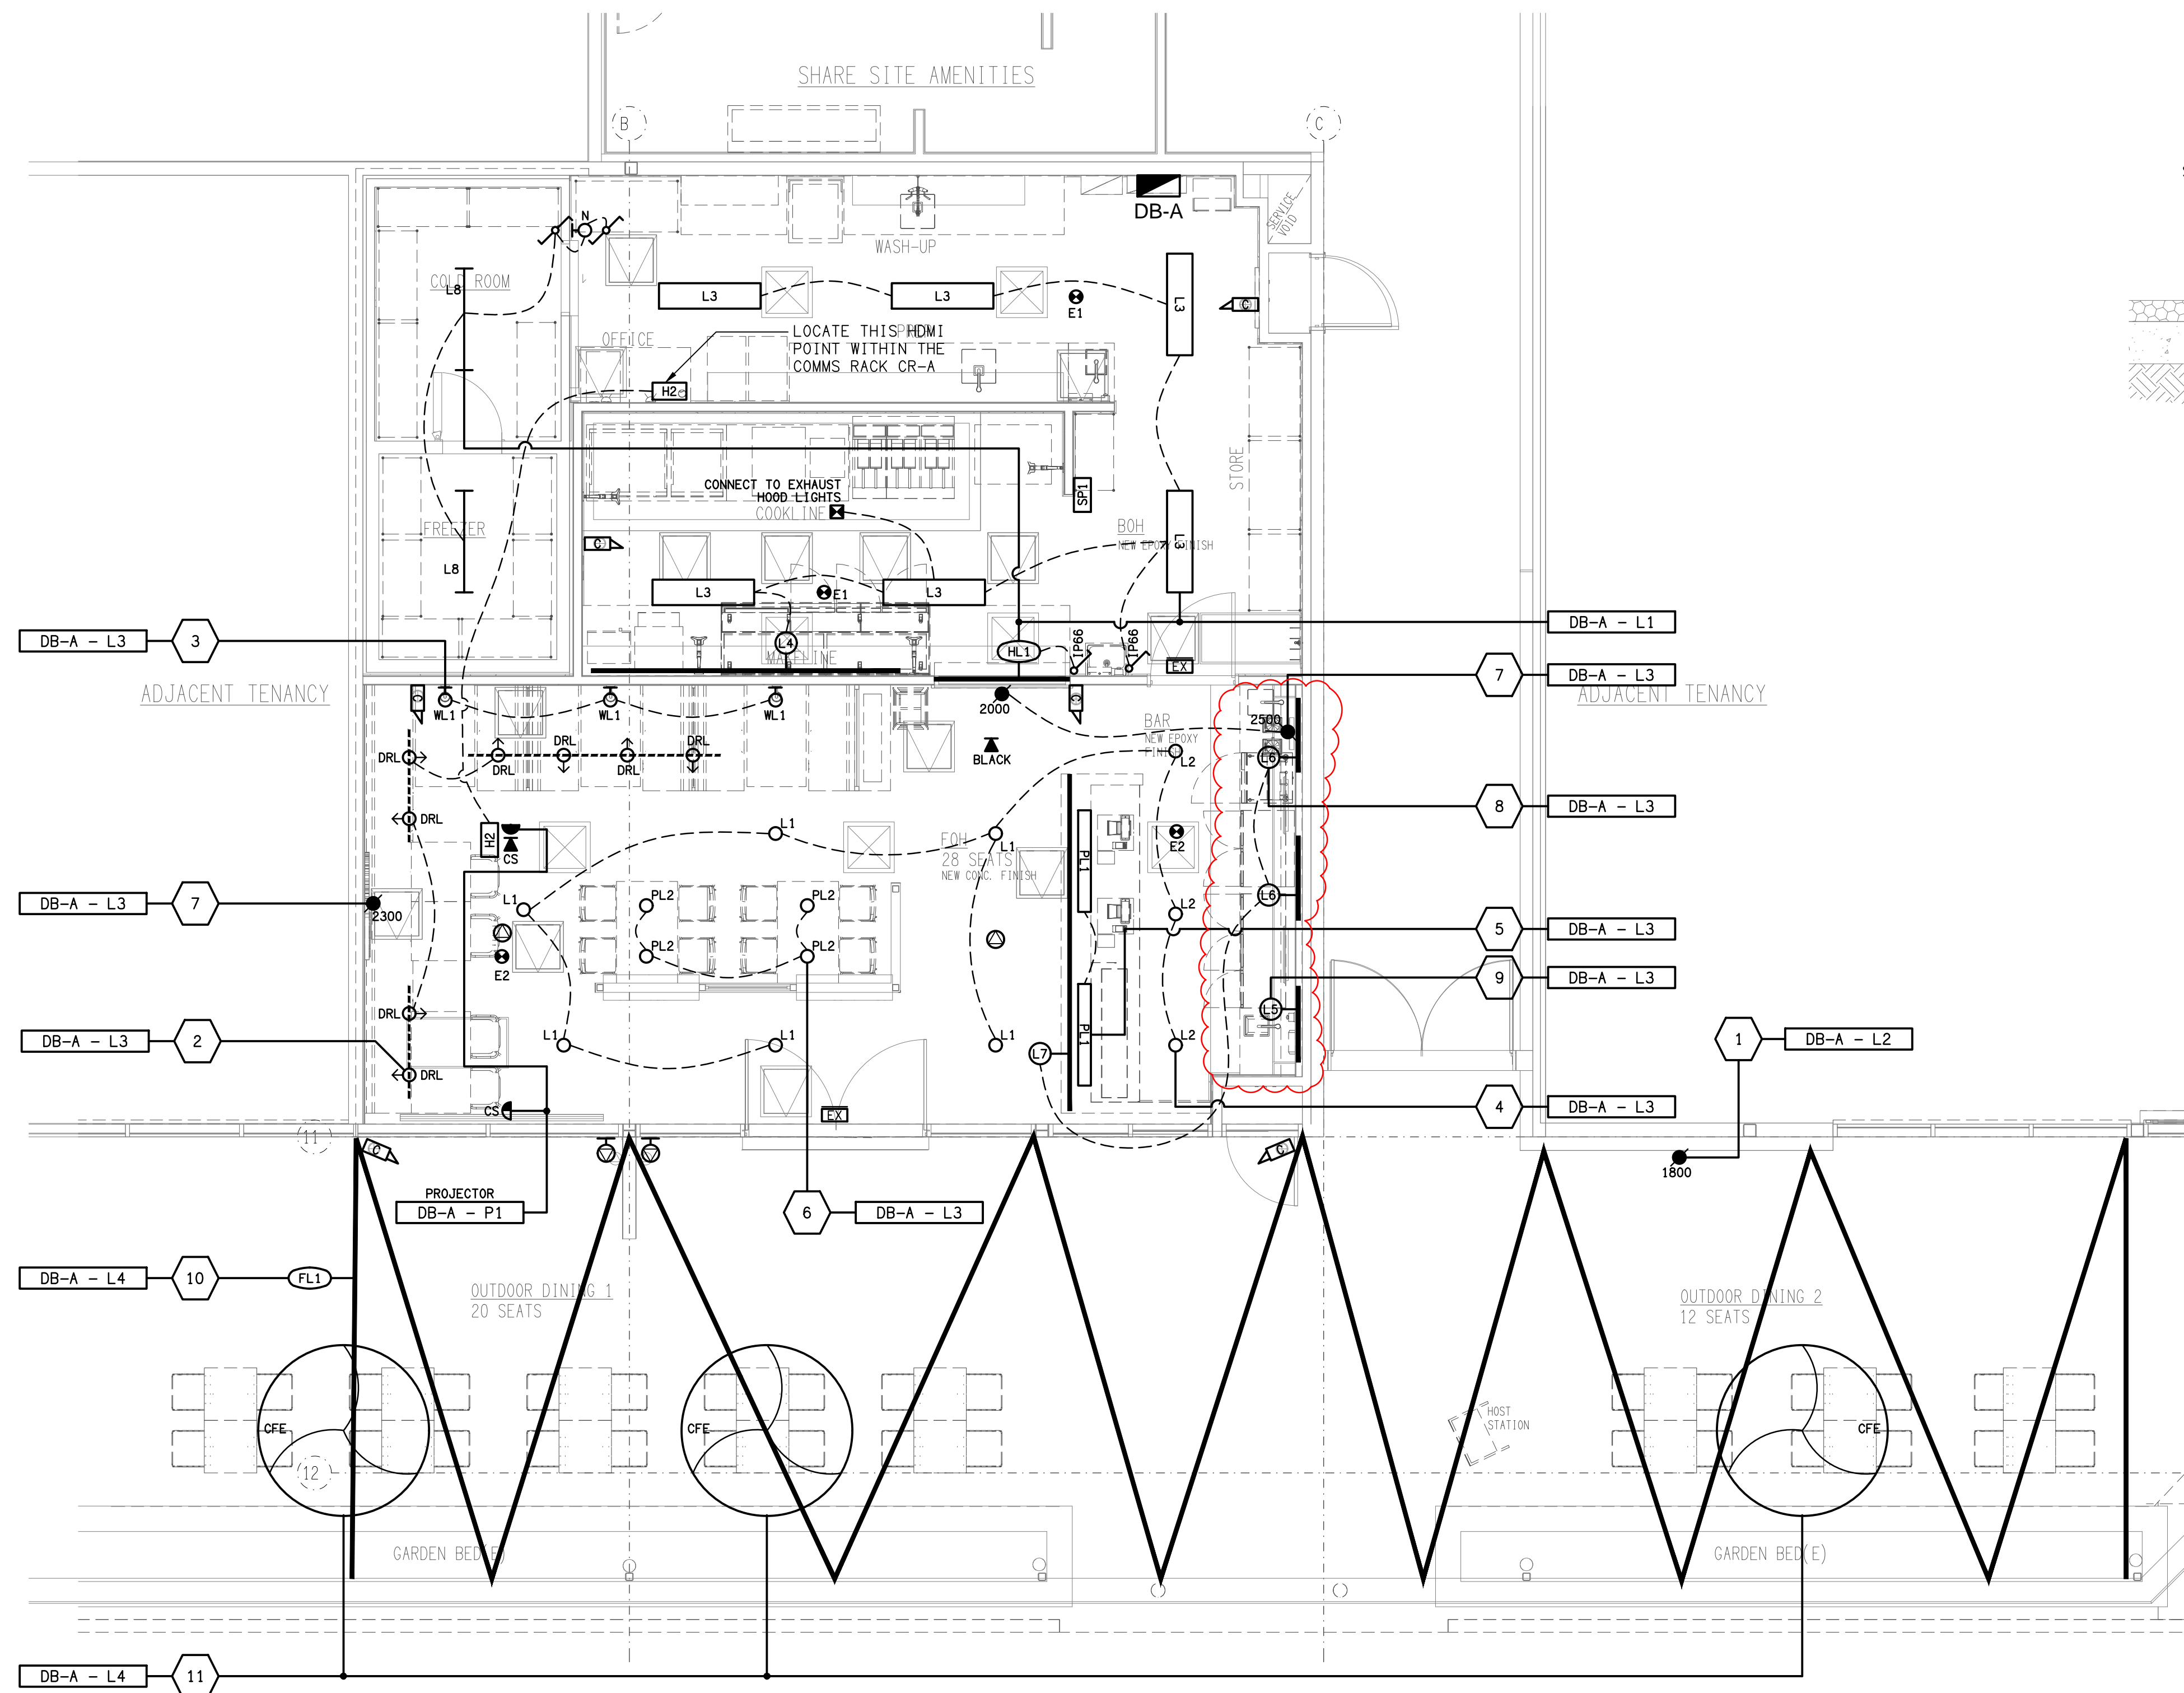

**REFLECTED CEILING PLAN**  
BURGER URGE TENANCY  
SCALE 1: 50

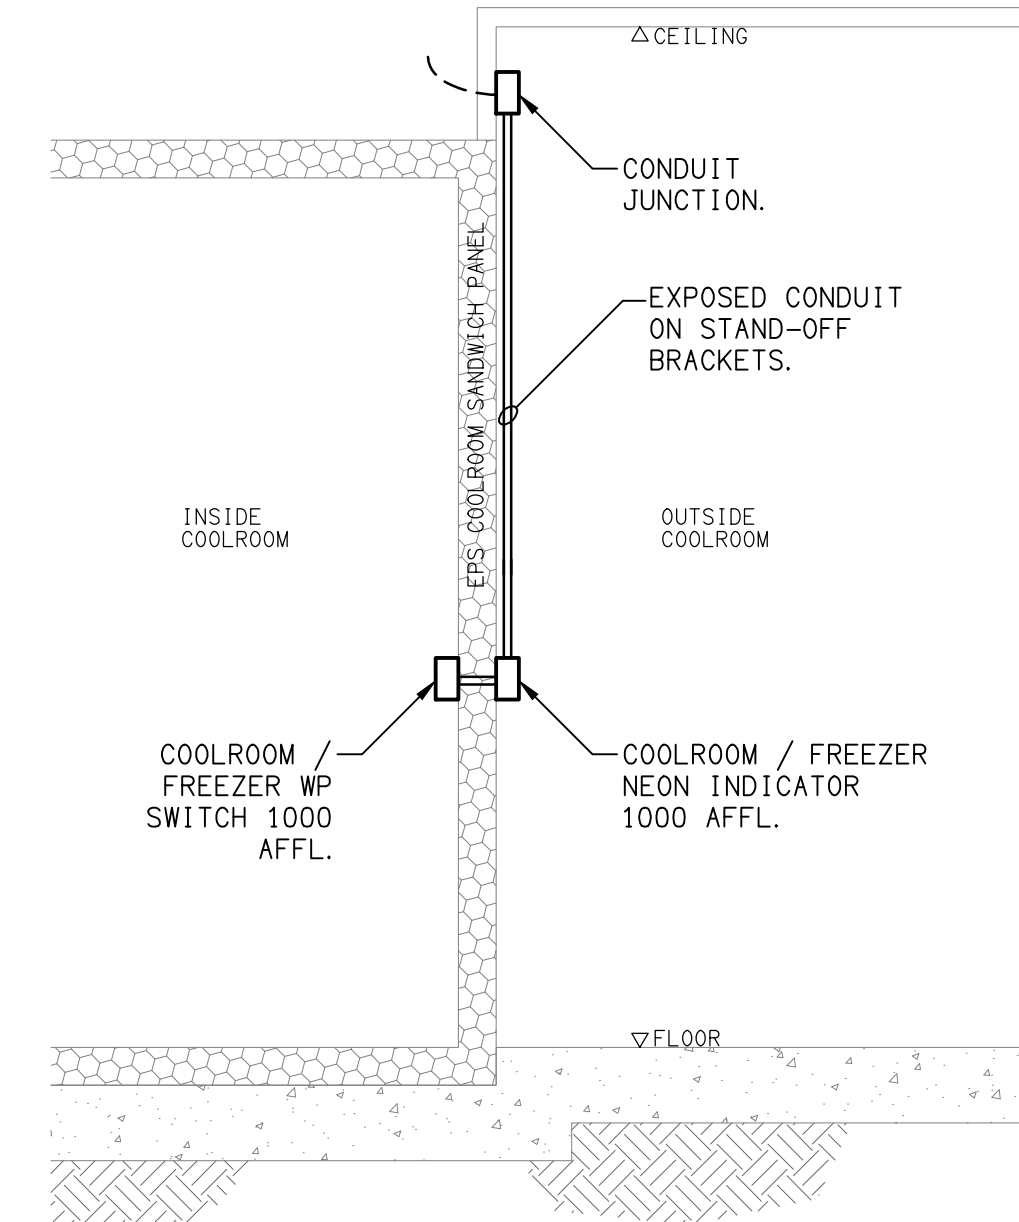

**DETAIL A**  
COOLROOM / FREEZER LIGHTING CONTROL  
NOT TO SCALE

C	CONSTRUCTION	12/02/2026
REV:	DESCRIPTION:	DATE:

**ELECTRICAL DESIGN GROUP**  
ELECTRICAL BUILDING SERVICES CONSULTANTS

BRISBANE: P.O. Box 15 Sherwood Qld 4075  
Phone: (07) 3278 4375  
Email: [brisbane@edg.net.au](mailto:brisbane@edg.net.au)  
Web: [www.edg.net.au](http://www.edg.net.au)

ELECTRICAL DESIGN GROUP BRISBANE  
PTY LTD  
ACN 092 710 793

TRADING AS:  
ELECTRICAL DESIGN  
GROUP

PROJECT: \_\_\_\_\_

BURGER URGE  
RIPLEY

SITE ADDRESS:

7004 BARRAMS ROAD, SOUTH RIPLEY  
QUEENSLAND

SCALE: SHEET SIZE:

1:50 AT A1

DRAWING TITLE: \_\_\_\_\_

## ELECTRICAL SERVICES

### REFLECTED CEILING PLAN

---

PROJECT NO: DRAWING NO: REVISION:

**C3693a E04 C**