


THE COPYRIGHT OF THIS DRAWING REMAINS THE PROPERTY OF
THE ELECTRICAL DESIGN GROUP.

USE FIGURED DIMENSIONS IN PREFERENCE TO SCALE.

ALL DIMENSIONS TO BE VERIFIED ONSITE.

BURGER URGE

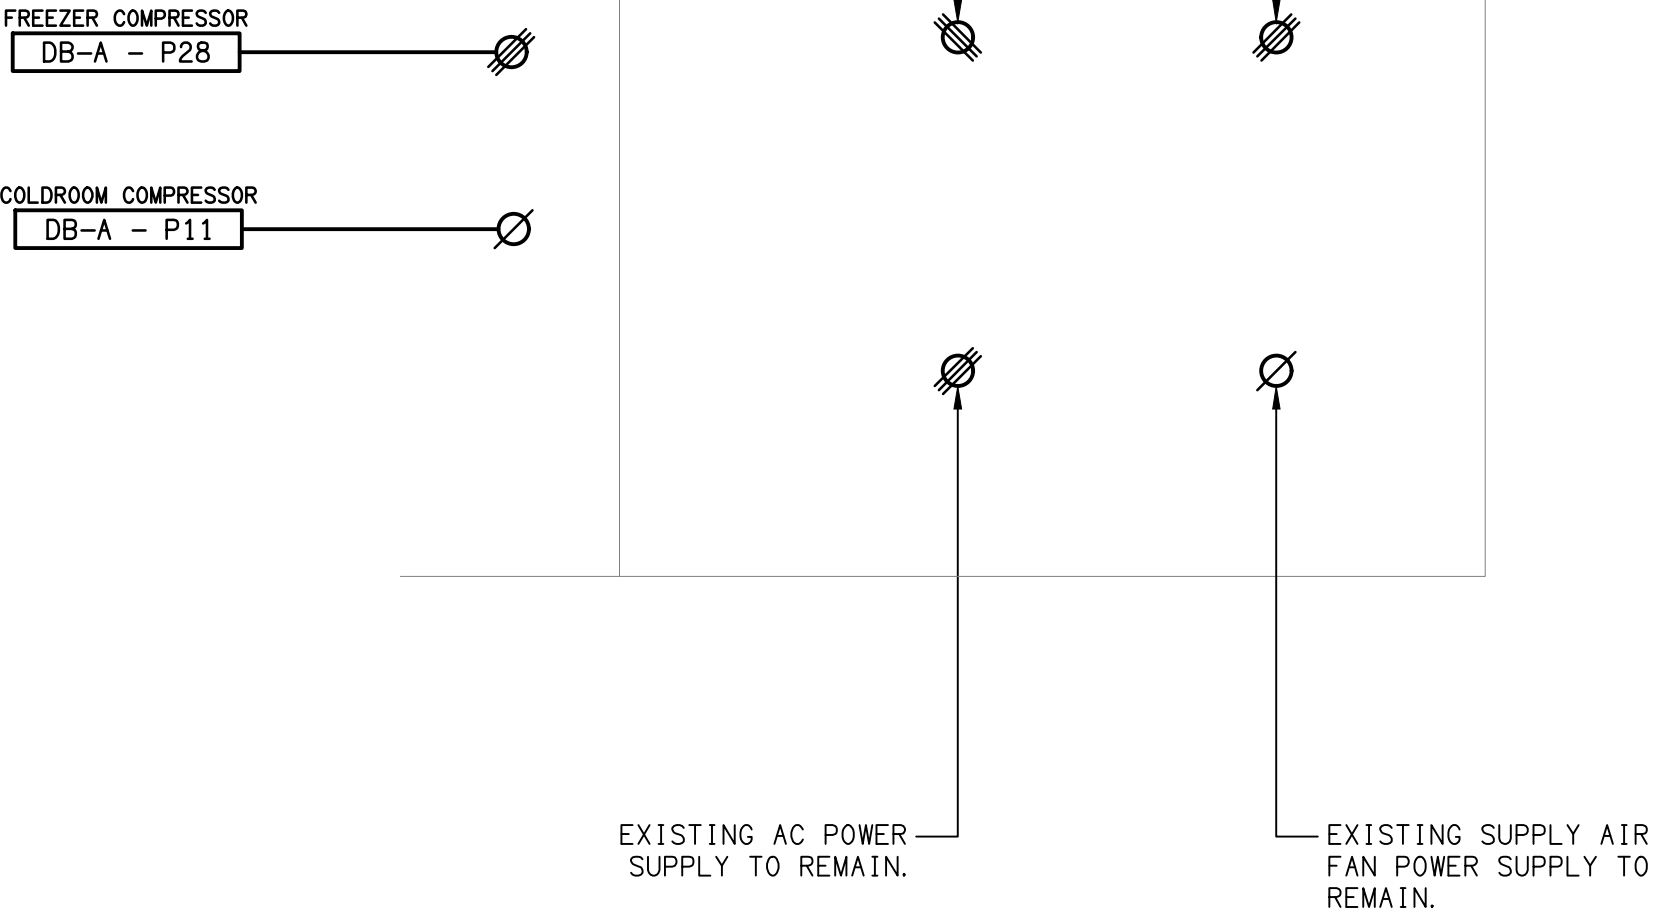

NOTE


ALL ELECTRICAL PENETRATIONS THROUGH THE ROOF SHEETING ARE TO BE IN LINE WITH THE STRUCTURAL OR MECHANICAL SERVICES PENETRATIONS TO AVOID DEDICATED FLASHINGS FOR THE ELECTRICAL SERVICES.

NOTE:

ALL REFRIGERATION SERVICES LOCATIONS ARE TO BE CONFIRMED ON SITE WITH THE REFRIGERATION SUBCONTRACTOR.

ROOF PLAN

BURGER URGE TENANCY
SCALE 1: 100

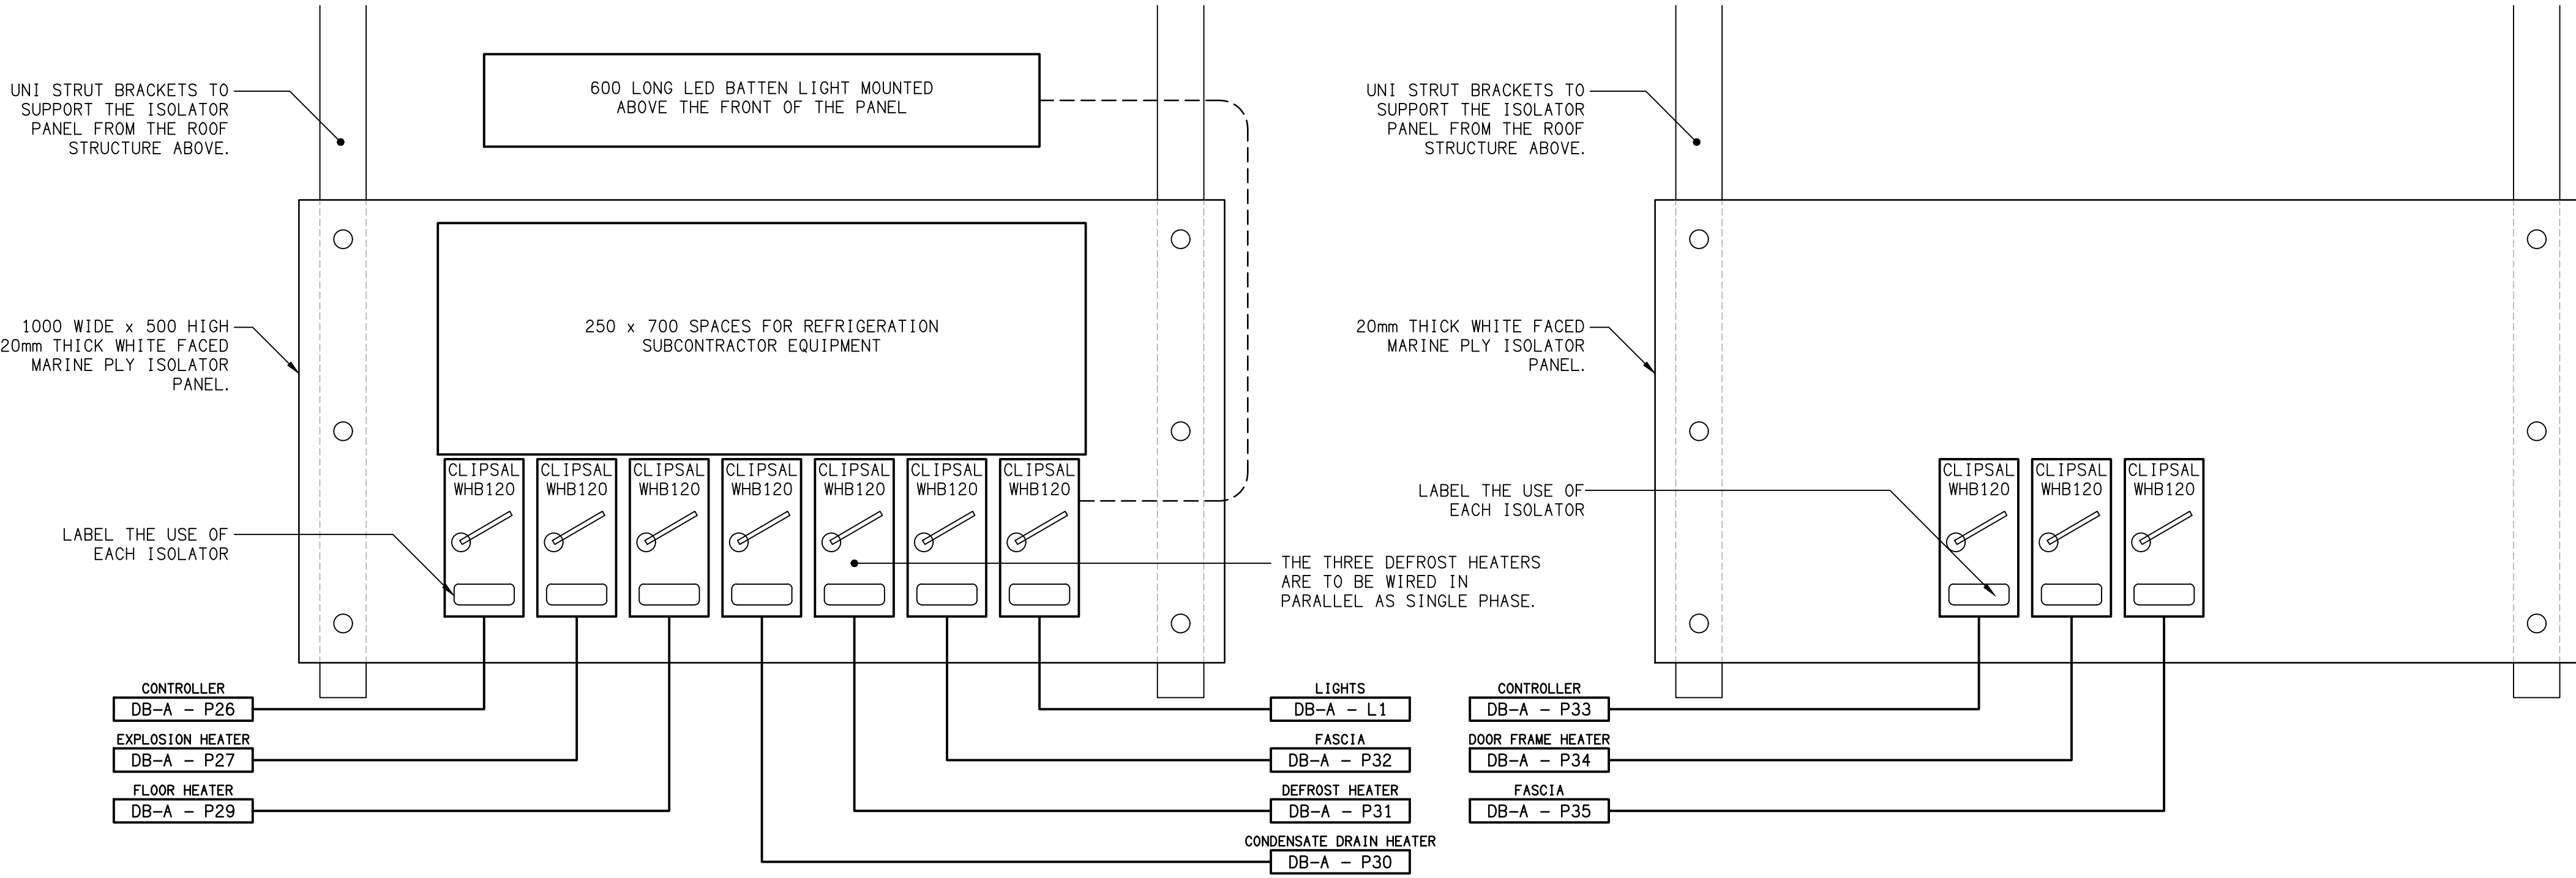

NOTE:

LOCATE THE ELECTRICAL ISOLATOR PANELS IN THE CEILING SPACE ABOVE THE ENTRY DOORS OF THE FREEZER AND COOLROOMS. CEILING ACCESS PANEL TO BE PROVIDED BY THE BUILDER.

DETAILS

ISOLATOR PANEL ELEVATIONS

NOT TO SCALE

C	CONSTRUCTION	12/02/2026
REV:	DESCRIPTION:	DATE:

ELECTRICAL DESIGN GROUP
ELECTRICAL BUILDING SERVICES CONSULTANTS

BRISBANE: P.O. Box 15 Sherwood Qld 4075
Phone: (07) 3278 4375
Email: brisbane@edg.net.au
Web: www.edg.net.au

ELECTRICAL DESIGN GROUP BRISBANE
PTY LTD
ACN 092 710 793

TRADING AS:
ELECTRICAL DESIGN
GROUP

PROJECT: _____

BURGER URGE
RIPLEY

SITE ADDRESS:

7004 BARRAMS ROAD, SOUTH RIPLEY
QUEENSLAND

SCALE: SHEET SIZE:

1:100 UNO AT A1

DRAWING TITLE:

ELECTRICAL SERVICES

ROOF PLAN & DETAILS

PROJECT NO:	DRAWING NO:	REVISION:
-------------	-------------	-----------

C3693a E06 C