



ELECTRICAL DESIGN GROUP

ELECTRICAL BUILDING SERVICES CONSULTANTS

P.O. Box 15, SHERWOOD Q. 4075

Phone: (07) 3278 4375

Website: www.edg.net.au Email: brisbane@edg.net.au

C3700a - MERCANTILE DALGETY PLACE

C3700a-0001(A).xls


ELECTRICAL SERVICES CONTRACT DOCUMENT SCHEDULE

REVISION A - 01 JUNE 2026


| ISSUING INFORMATION | | | | DATE OF ISSUE | | | | | | | |
|---|--|--|----|---------------|--|--|--|--|--|--|--|
| | | DAY MONTH YEAR REASON FOR ISSUE | 01 | | | | | | | | |
| | | | 06 | | | | | | | | |
| | | | 26 | | | | | | | | |
| | | | P | | | | | | | | |
| A = APPROVAL C = CONSTRUCTION N = COORDINATION P = PRELIMINARY T = TENDER | | | | | | | | | | | |

| DISTRIBUTION | | NUMBER OF COPIES | | | | | | | | | |
|--|--|------------------|--|--|--|--|--|--|--|--|--|
| WWW.EDG.NET.AU | | 1E | | | | | | | | | |
| MERCANTILE, DALGETY PLACE | | 1E | | | | | | | | | |
| | | | | | | | | | | | |
| | | | | | | | | | | | |
| | | | | | | | | | | | |
| | | | | | | | | | | | |
| P = PRINT T = TRACING D = DISC E = EMAIL F = FAX | | | | | | | | | | | |


| DOCUMENTS | | REVISION | | | | | | | | | |
|-----------------|--------------------------------------|----------|--|--|--|--|--|--|--|--|--|
| C3700a-E01.dwg | LEGEND & NOTES | A | | | | | | | | | |
| C3700a-E02.dwg | BLOCKS A & B LEVEL 1, 2 & 3 PLANS | A | | | | | | | | | |
| C3700a-E03.dwg | BLOCKS A & B LEVEL 4, 5 & ROOF PLANS | A | | | | | | | | | |
| C3700a-E04.dwg | BLOCKS C & D LEVEL 1, 2 & 3 PLANS | A | | | | | | | | | |
| C3700a-E05.dwg | BLOCKS C & D LEVEL 4, 5 & ROOF PLANS | A | | | | | | | | | |
| | | | | | | | | | | | |
| C3700a-0001.xls | CONTRACT DOCUMENT SCHEDULE | A | | | | | | | | | |
| | | | | | | | | | | | |
| | | | | | | | | | | | |
| | | | | | | | | | | | |
| | | | | | | | | | | | |
| | | | | | | | | | | | |

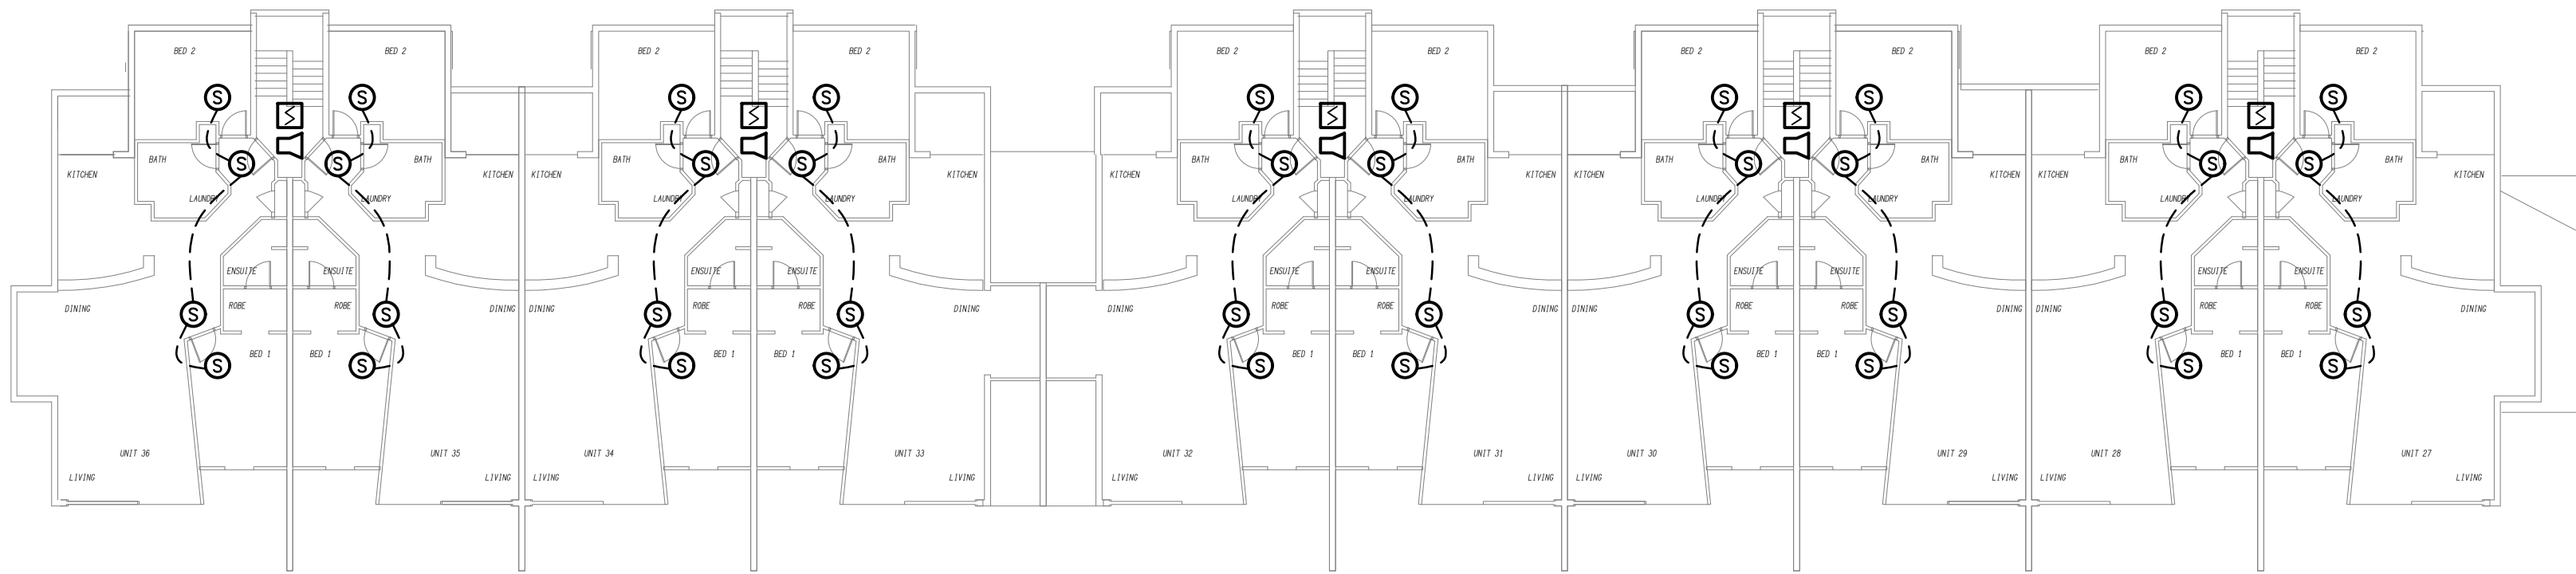

LEVEL 3
FLOOR / REFLECTED CEILING PLAN
SCALE 1: 200

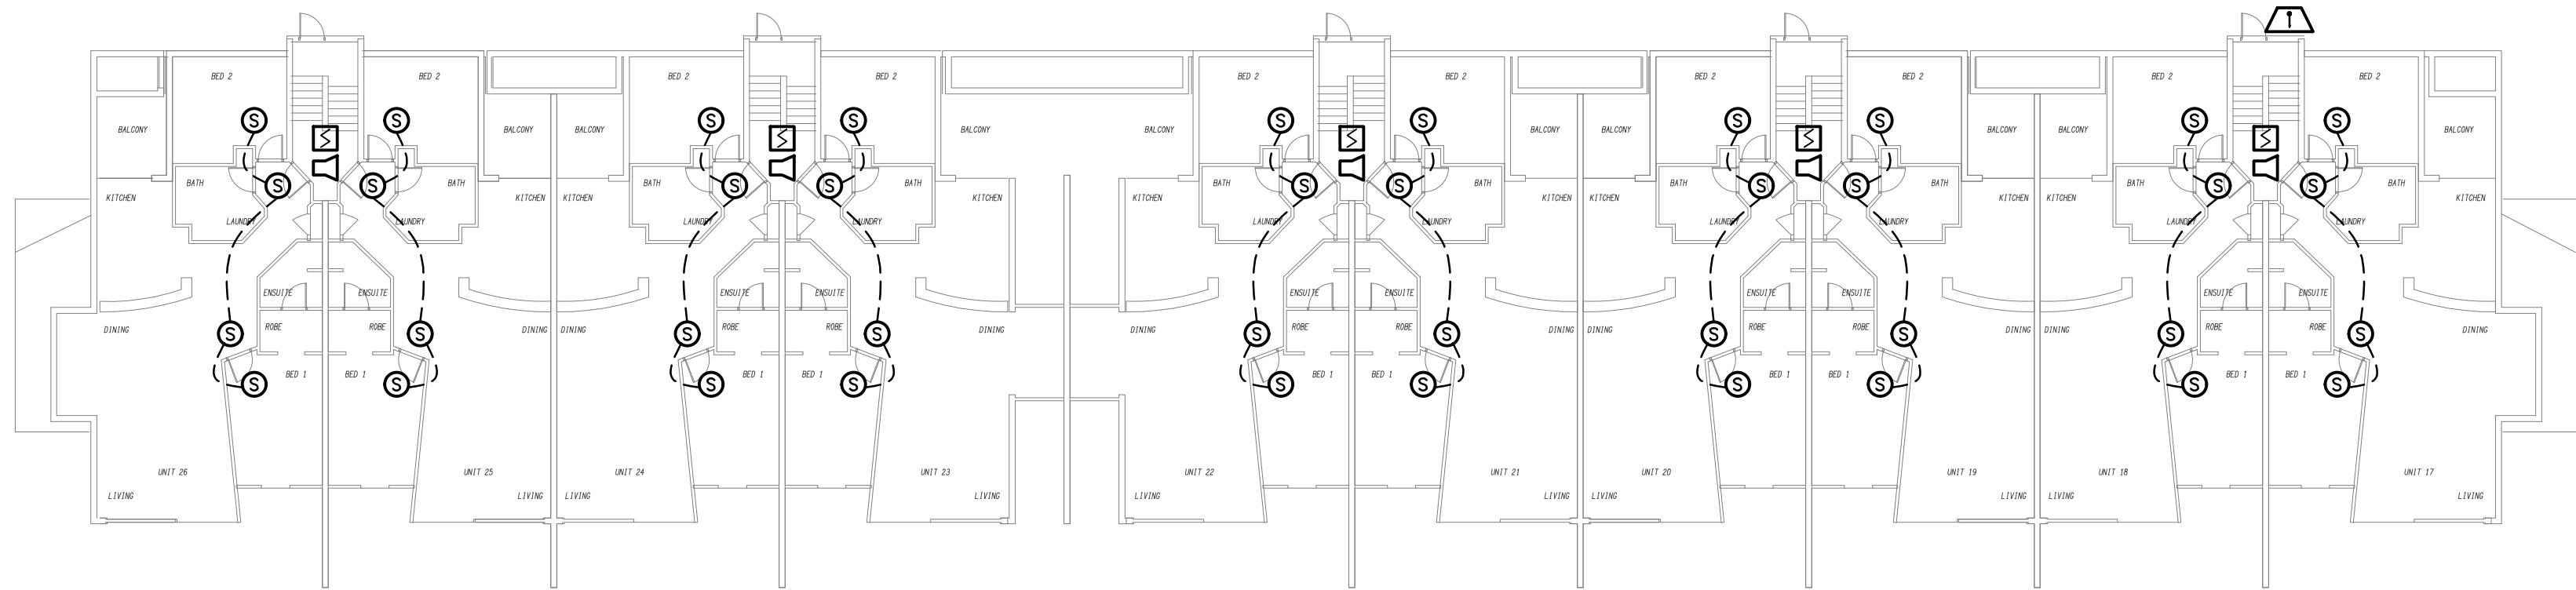

LEVEL 2
FLOOR / REFLECTED CEILING PLAN
SCALE 1: 200

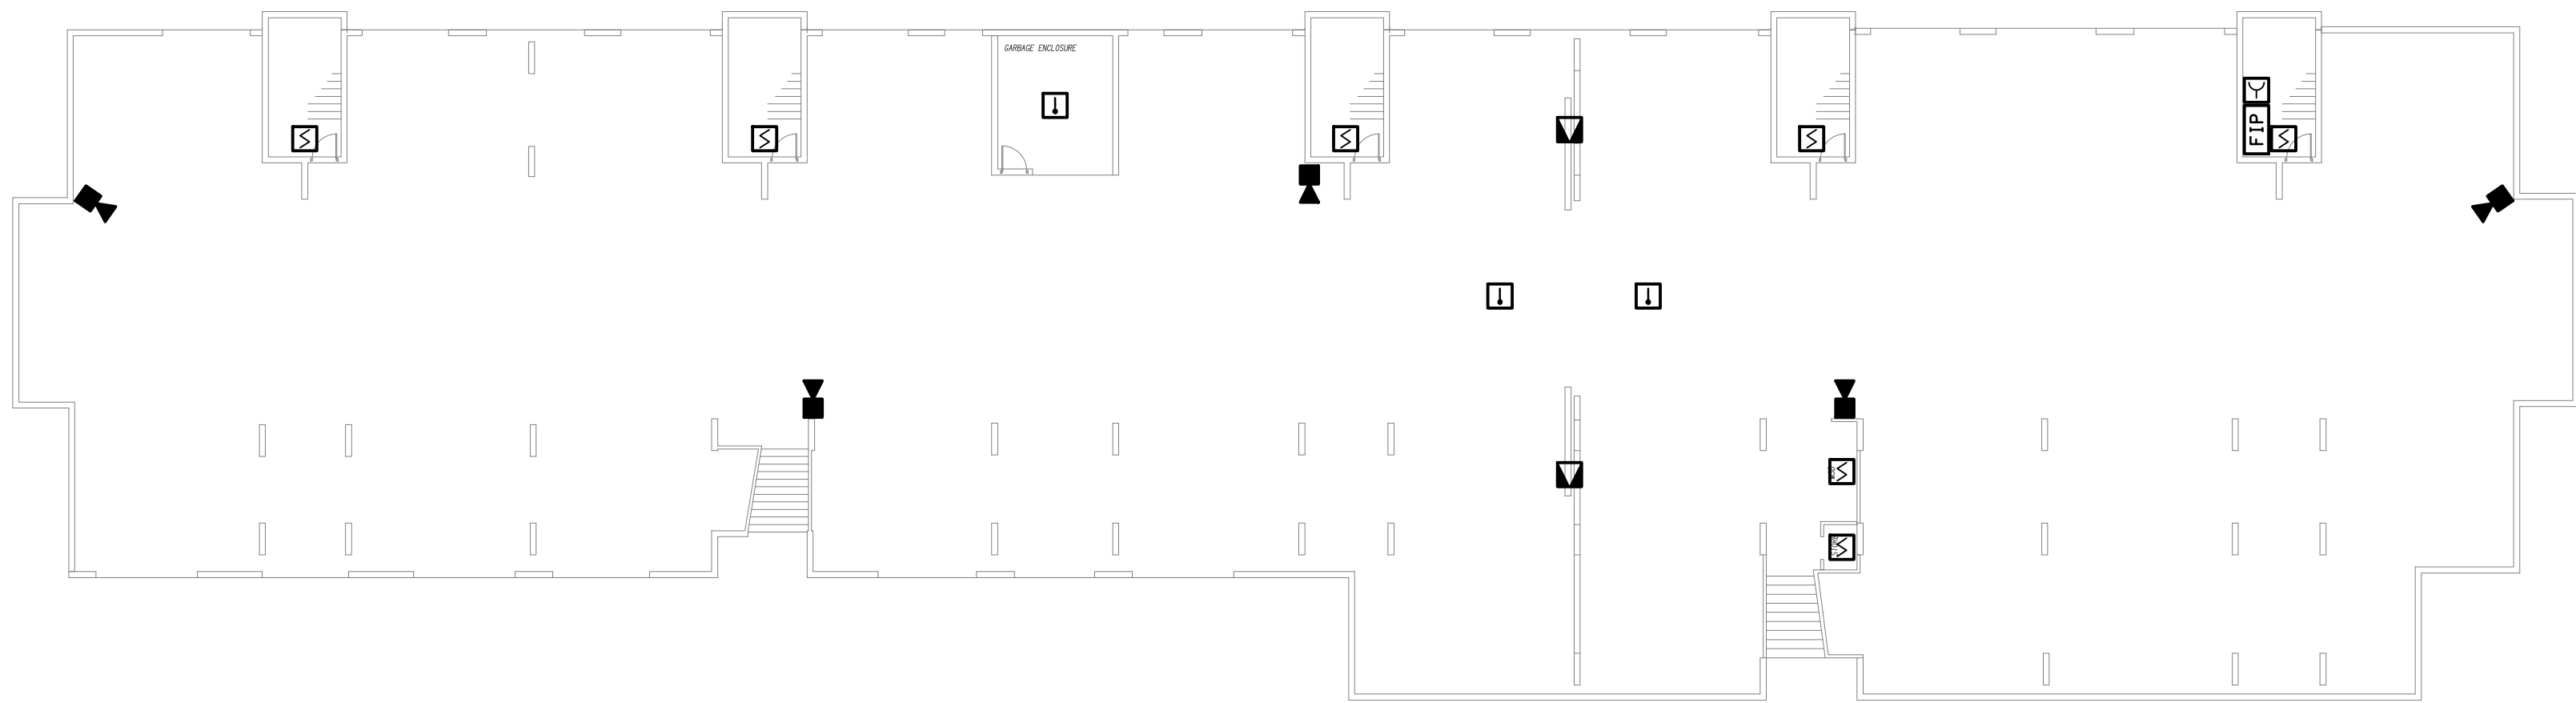

LEVEL 1
FLOOR / REFLECTED CEILING PLAN
SCALE 1: 200


ELECTRICAL DESIGN GROUP BRISBANE
PTY LTD
ACN 092 710 793
TRADING AS:
ELECTRICAL DESIGN GROUP

THE COPYRIGHT OF THIS DRAWING
REMAINS THE PROPERTY OF THE
ELECTRICAL DESIGN GROUP.
USE FIGURED DIMENSIONS
IN PREFERENCE TO SCALE.
ALL DIMENSIONS TO BE
VERIFIED ONSITE.


ELECTRICAL DESIGN GROUP
ELECTRICAL BUILDING SERVICES CONSULTANTS
BRISBANE GOLD COAST
P.O.Box 15, Sherwood Q.4075
Phone: (07) 3278 4375
Email: brisbane@edg.net.au
Web: www.edg.net.au

PROJECT:
MERCANTILE, DALGETY PLACE
135 MACQUARIE STREET, TENERIFFE


| | | |
|--|------------------------------|---------------------------|
| A | INFORMATION | 01/06/2026 |
| REV: | DESCRIPTION: | DATE: |
| DRAWING: ELECTRICAL SERVICES BLOCKS A & B LEVEL 1, 2 & 3 PLANS | | |
| SCALE: 1:200 | PROJECT NO: C3700a | DRAWING NO: E02 |
| AT A1 | REVISION: A | |

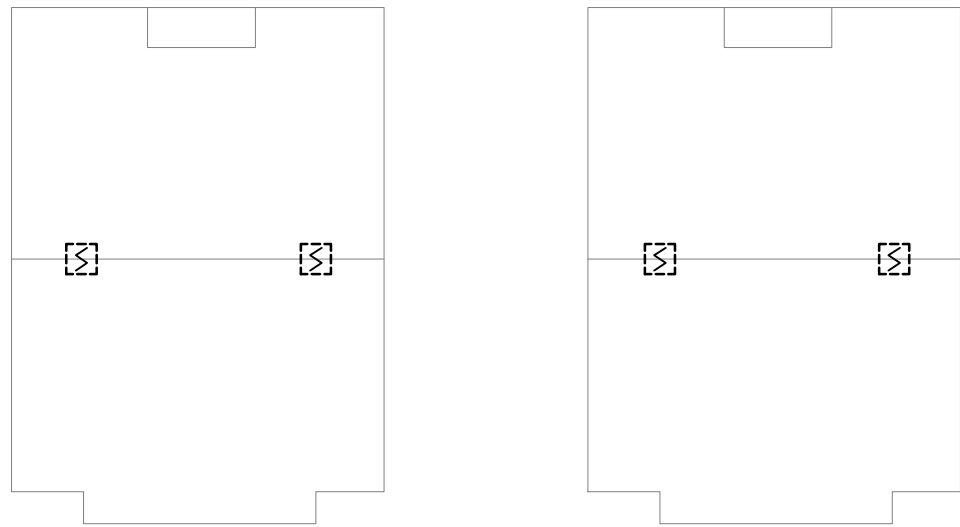


ROOF
FLOOR / REFLECTED CEILING PLAN
SCALE 1: 200

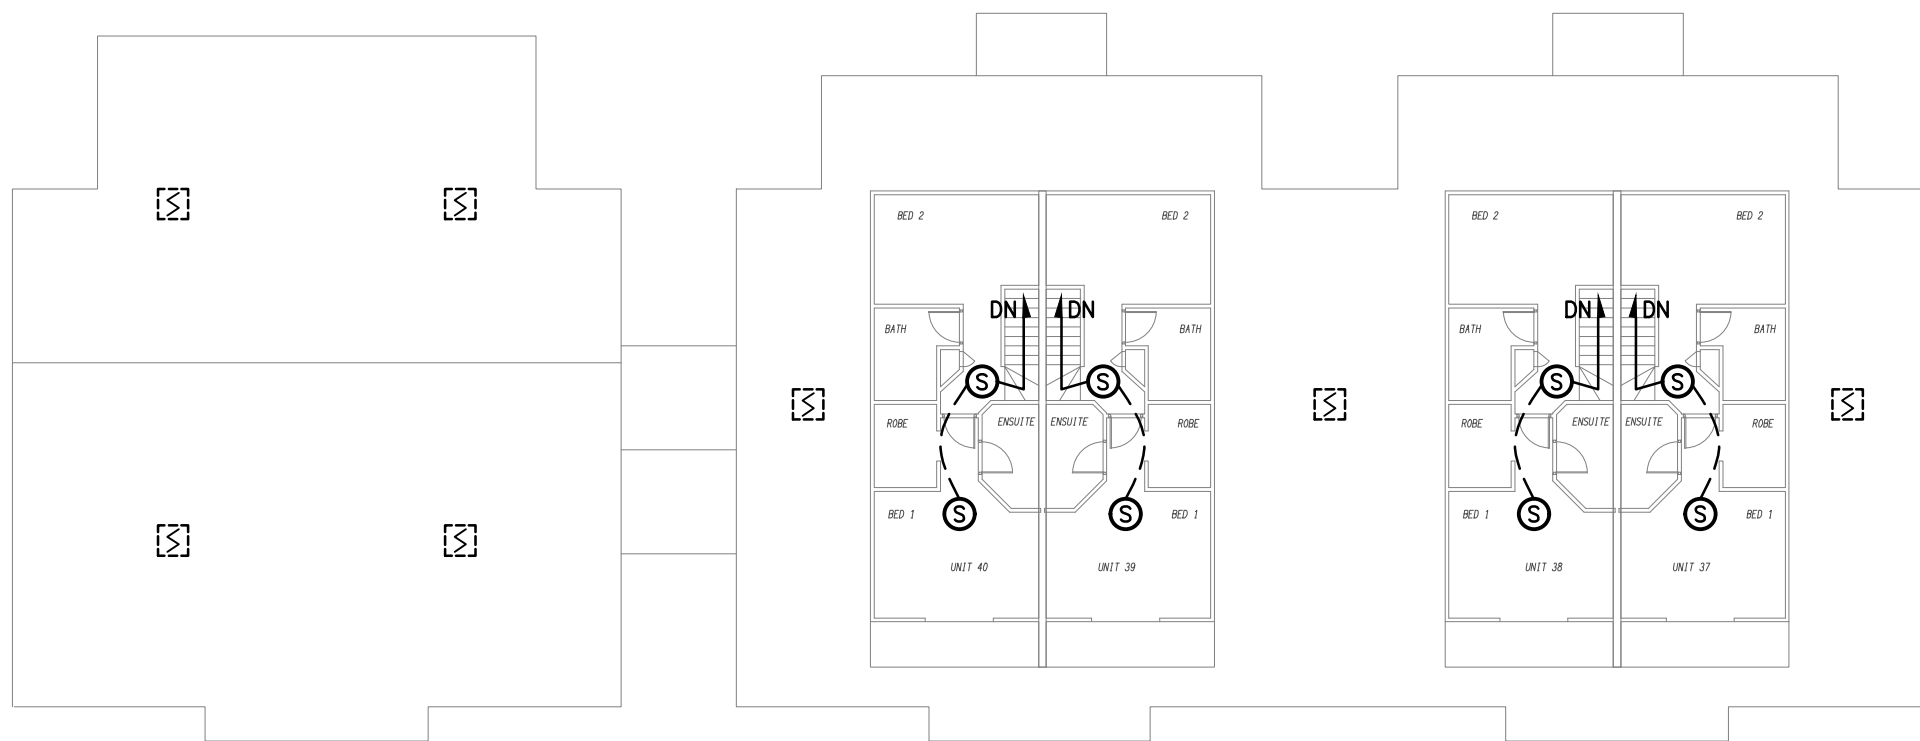


LEVEL 5
FLOOR / REFLECTED CEILING PLAN
SCALE 1: 200

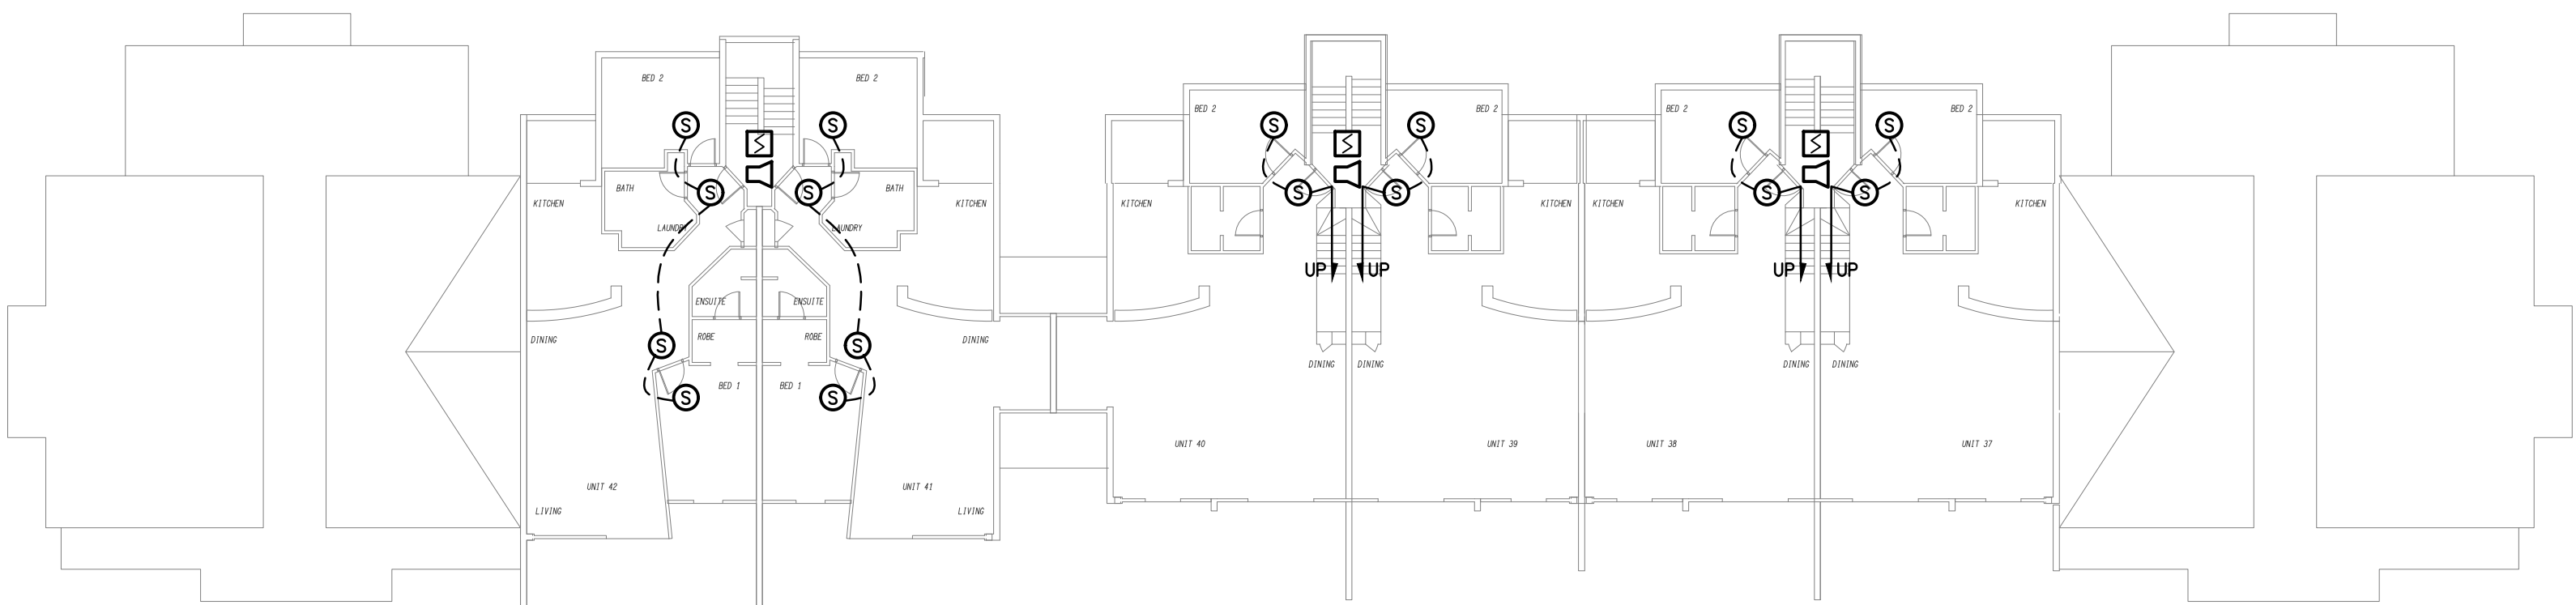


LEVEL 4
FLOOR / REFLECTED CEILING PLAN
SCALE 1: 200

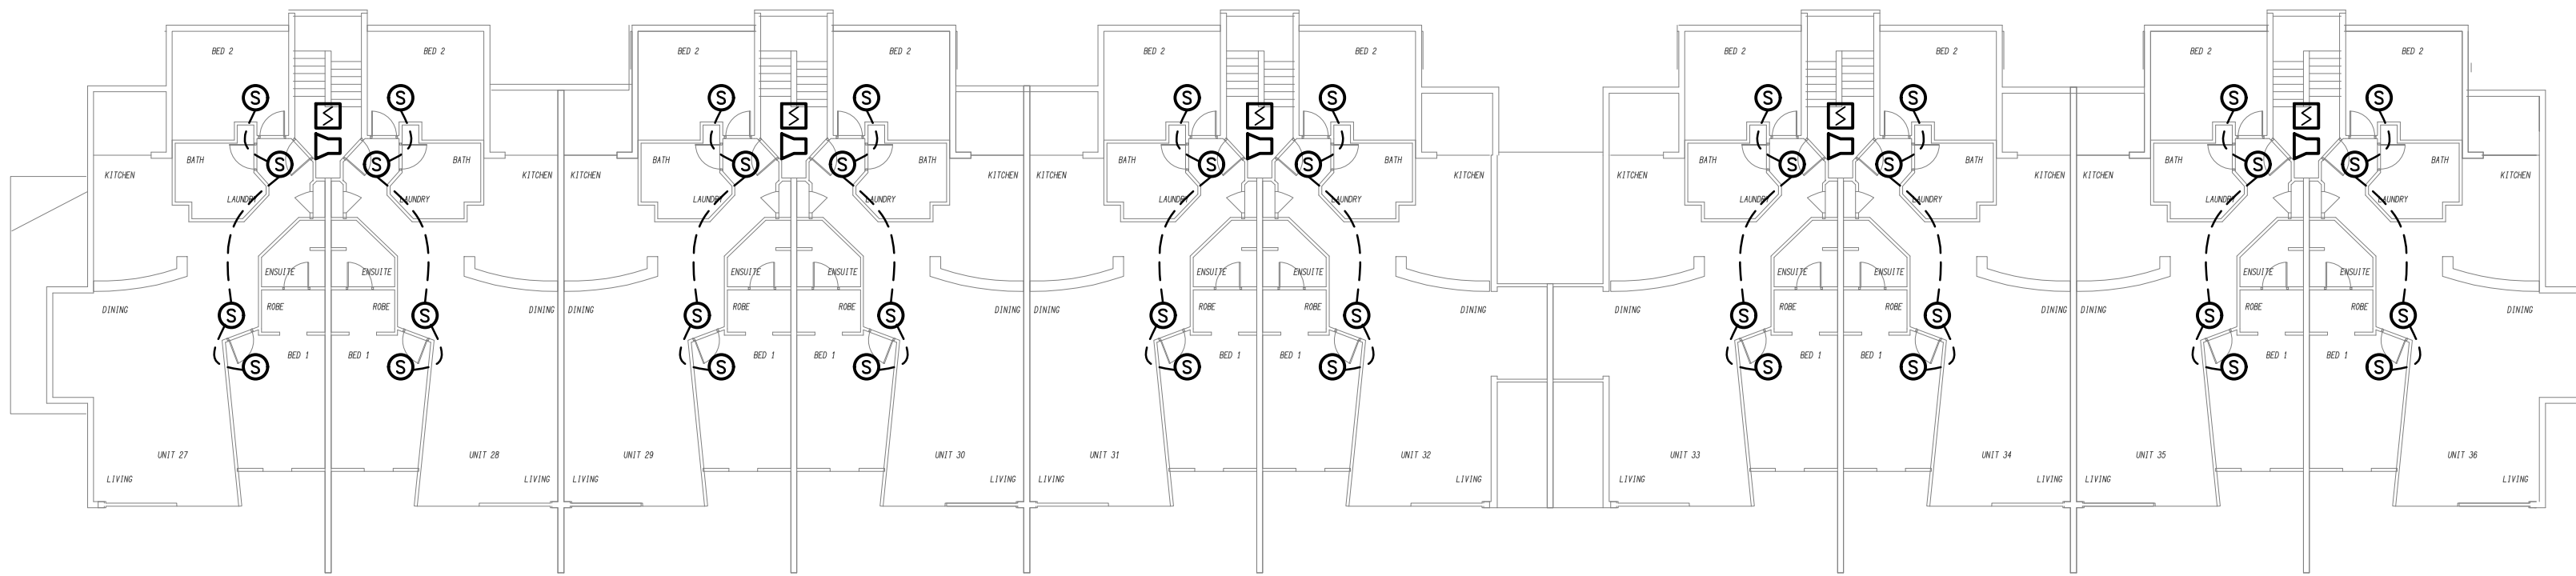


LEVEL 3
FLOOR / REFLECTED CEILING PLAN
SCALE 1: 200

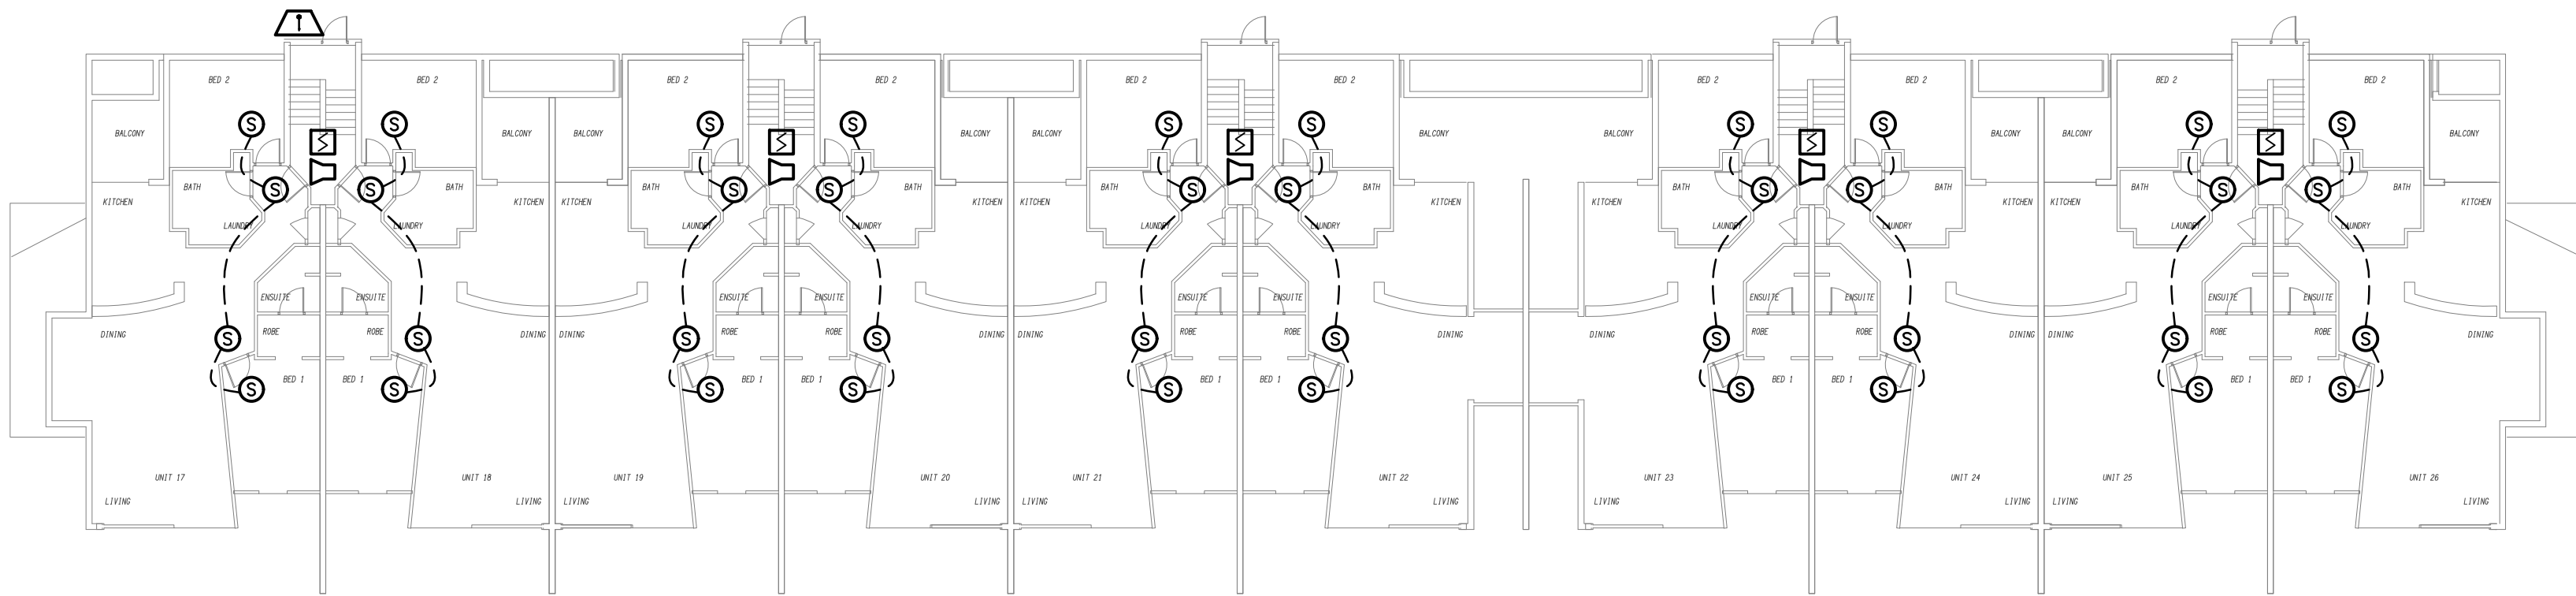


LEVEL 2
FLOOR / REFLECTED CEILING PLAN
SCALE 1: 200

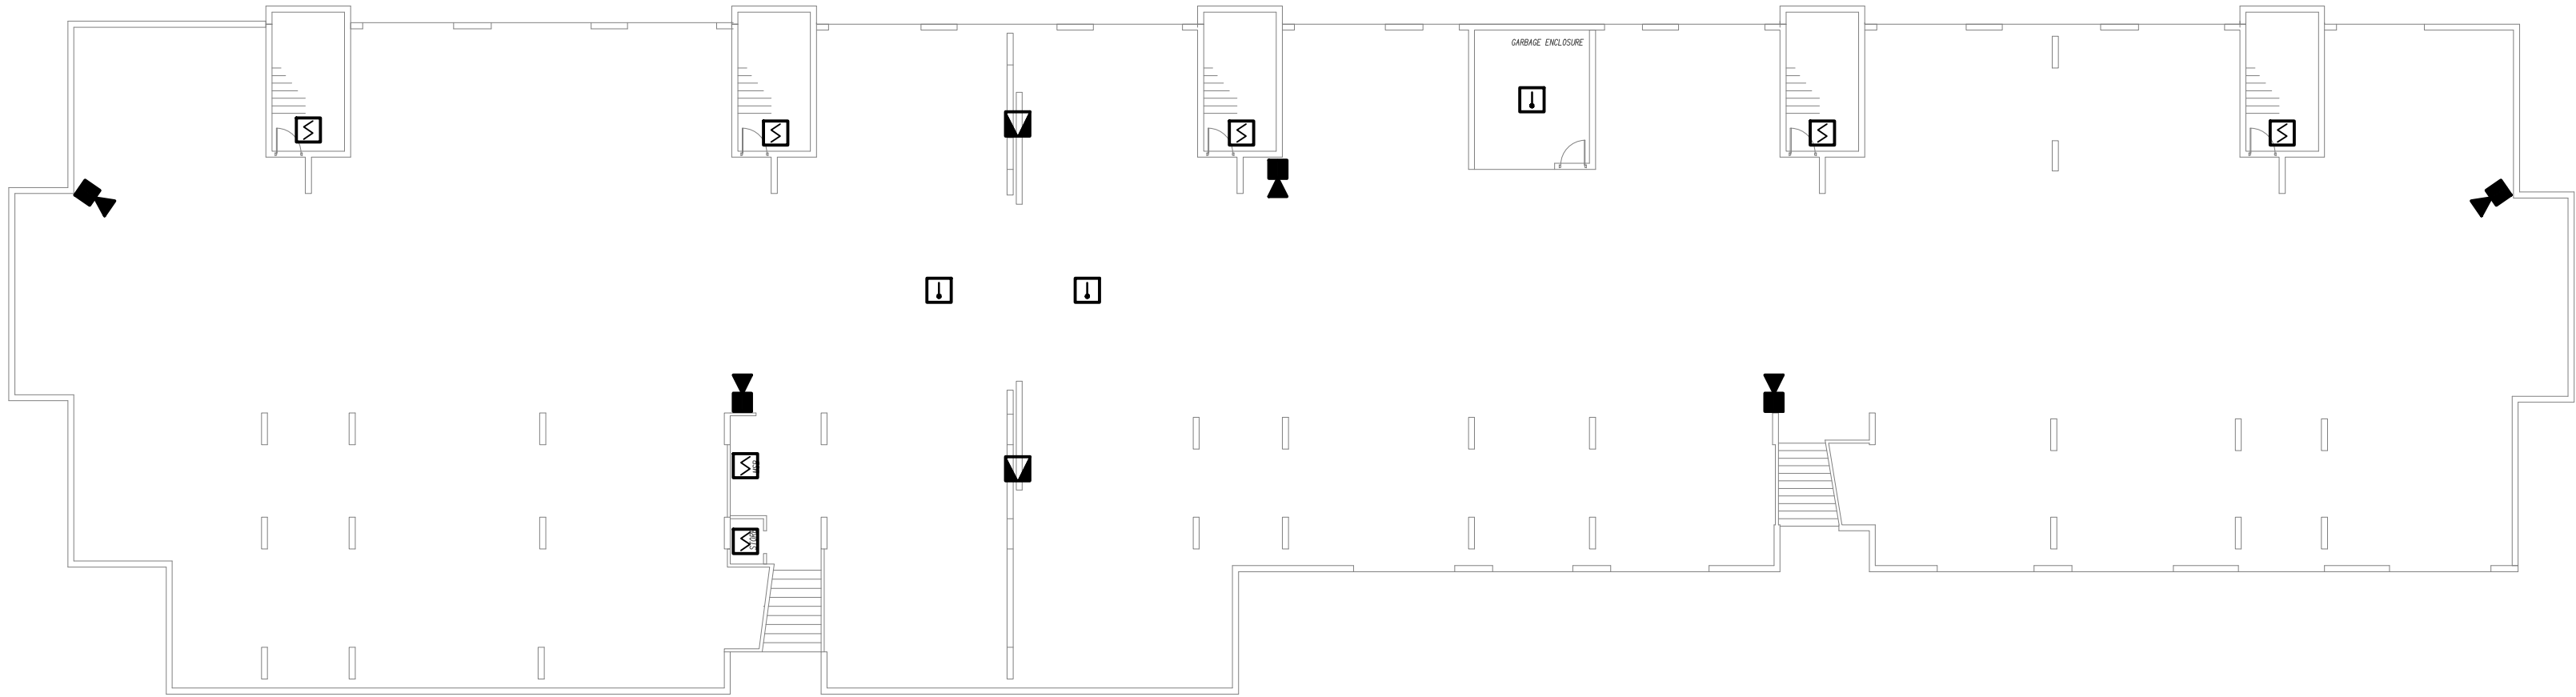


LEVEL 1
FLOOR / REFLECTED CEILING PLAN
SCALE 1: 200

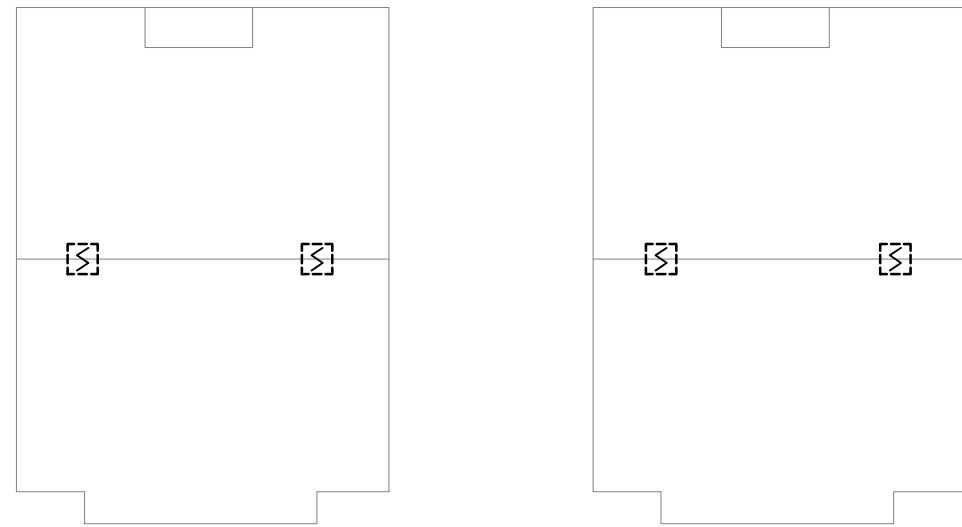

ROOF
FLOOR / REFLECTED CEILING PLAN
SCALE 1: 200

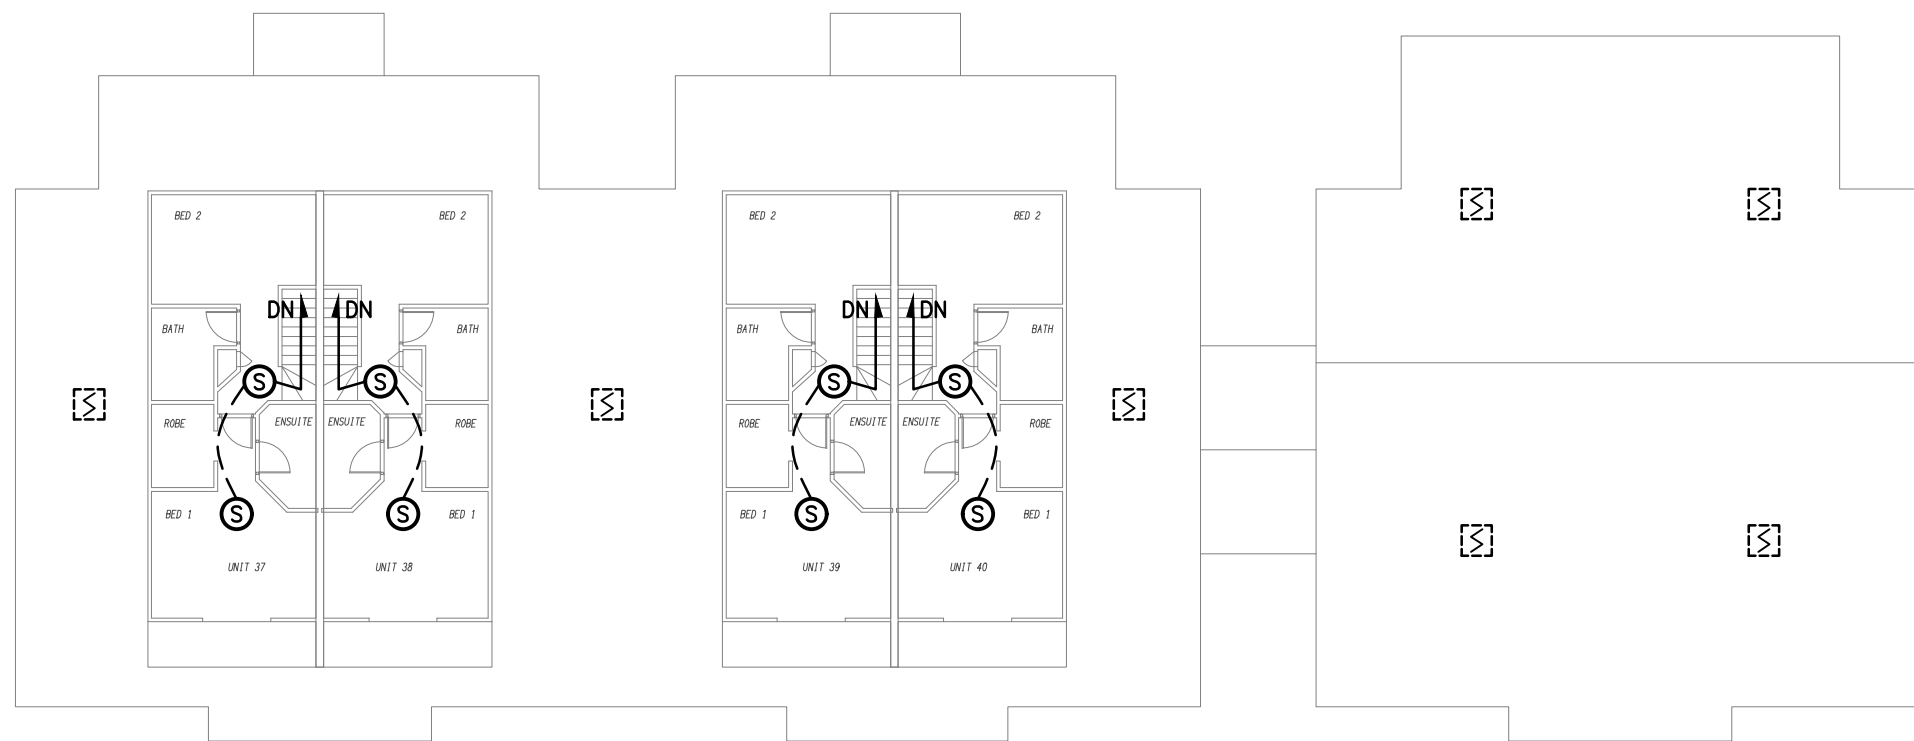

LEVEL 5
FLOOR / REFLECTED CEILING PLAN
SCALE 1: 200

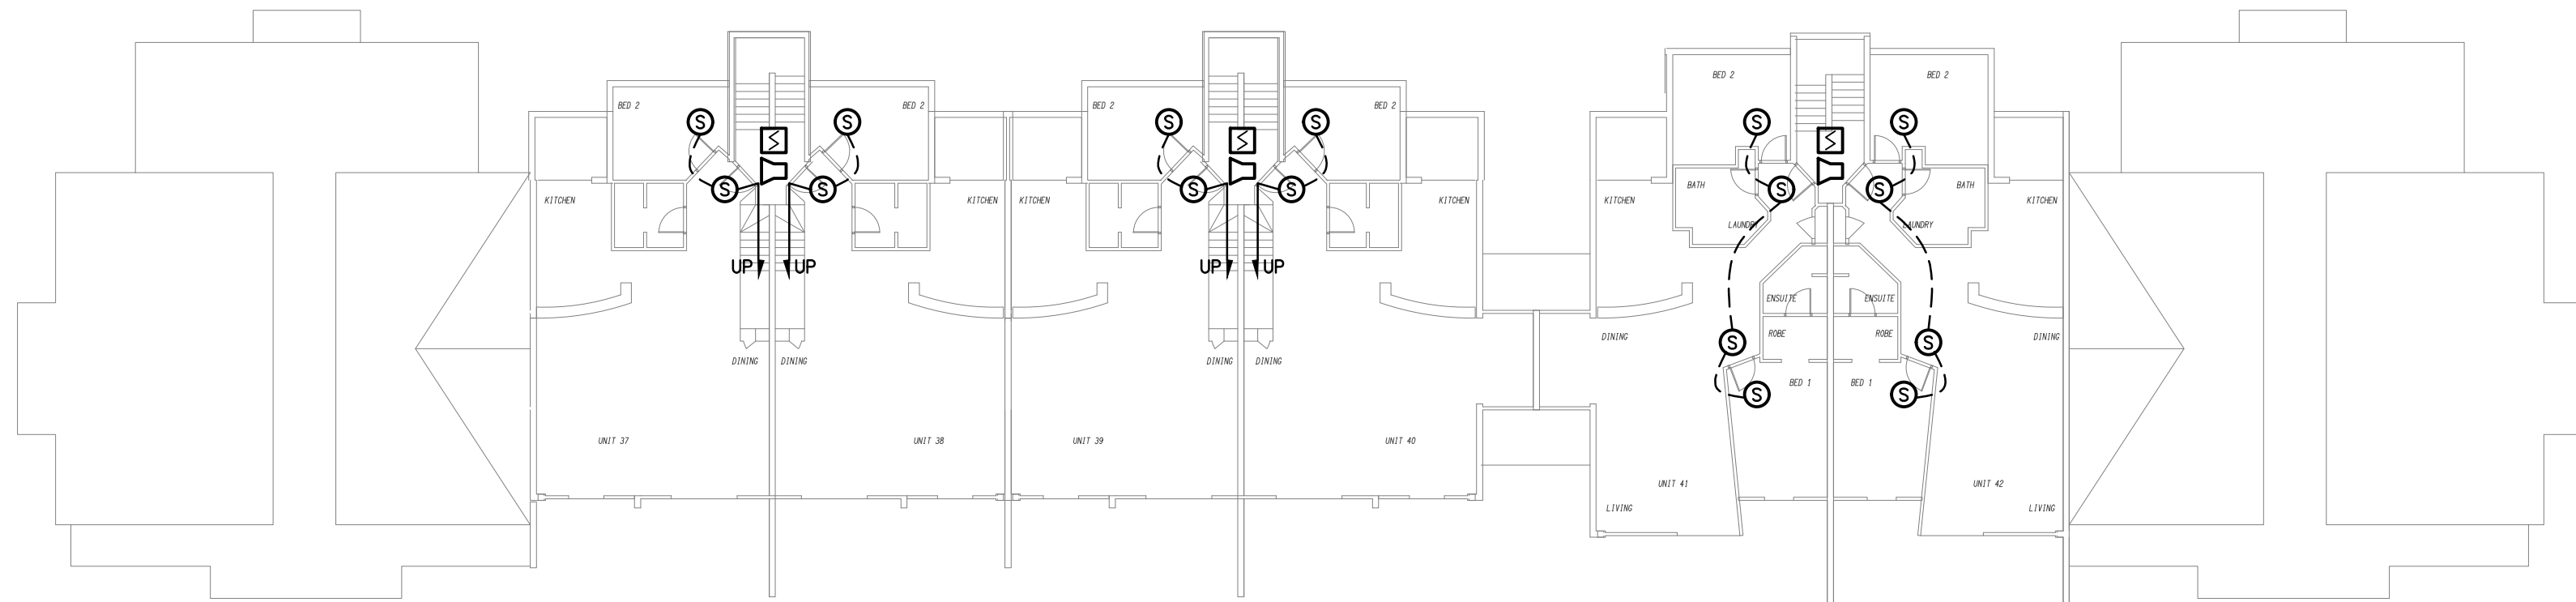

LEVEL 4
FLOOR / REFLECTED CEILING PLAN
SCALE 1: 200