



CURTIN AVENUE EAST


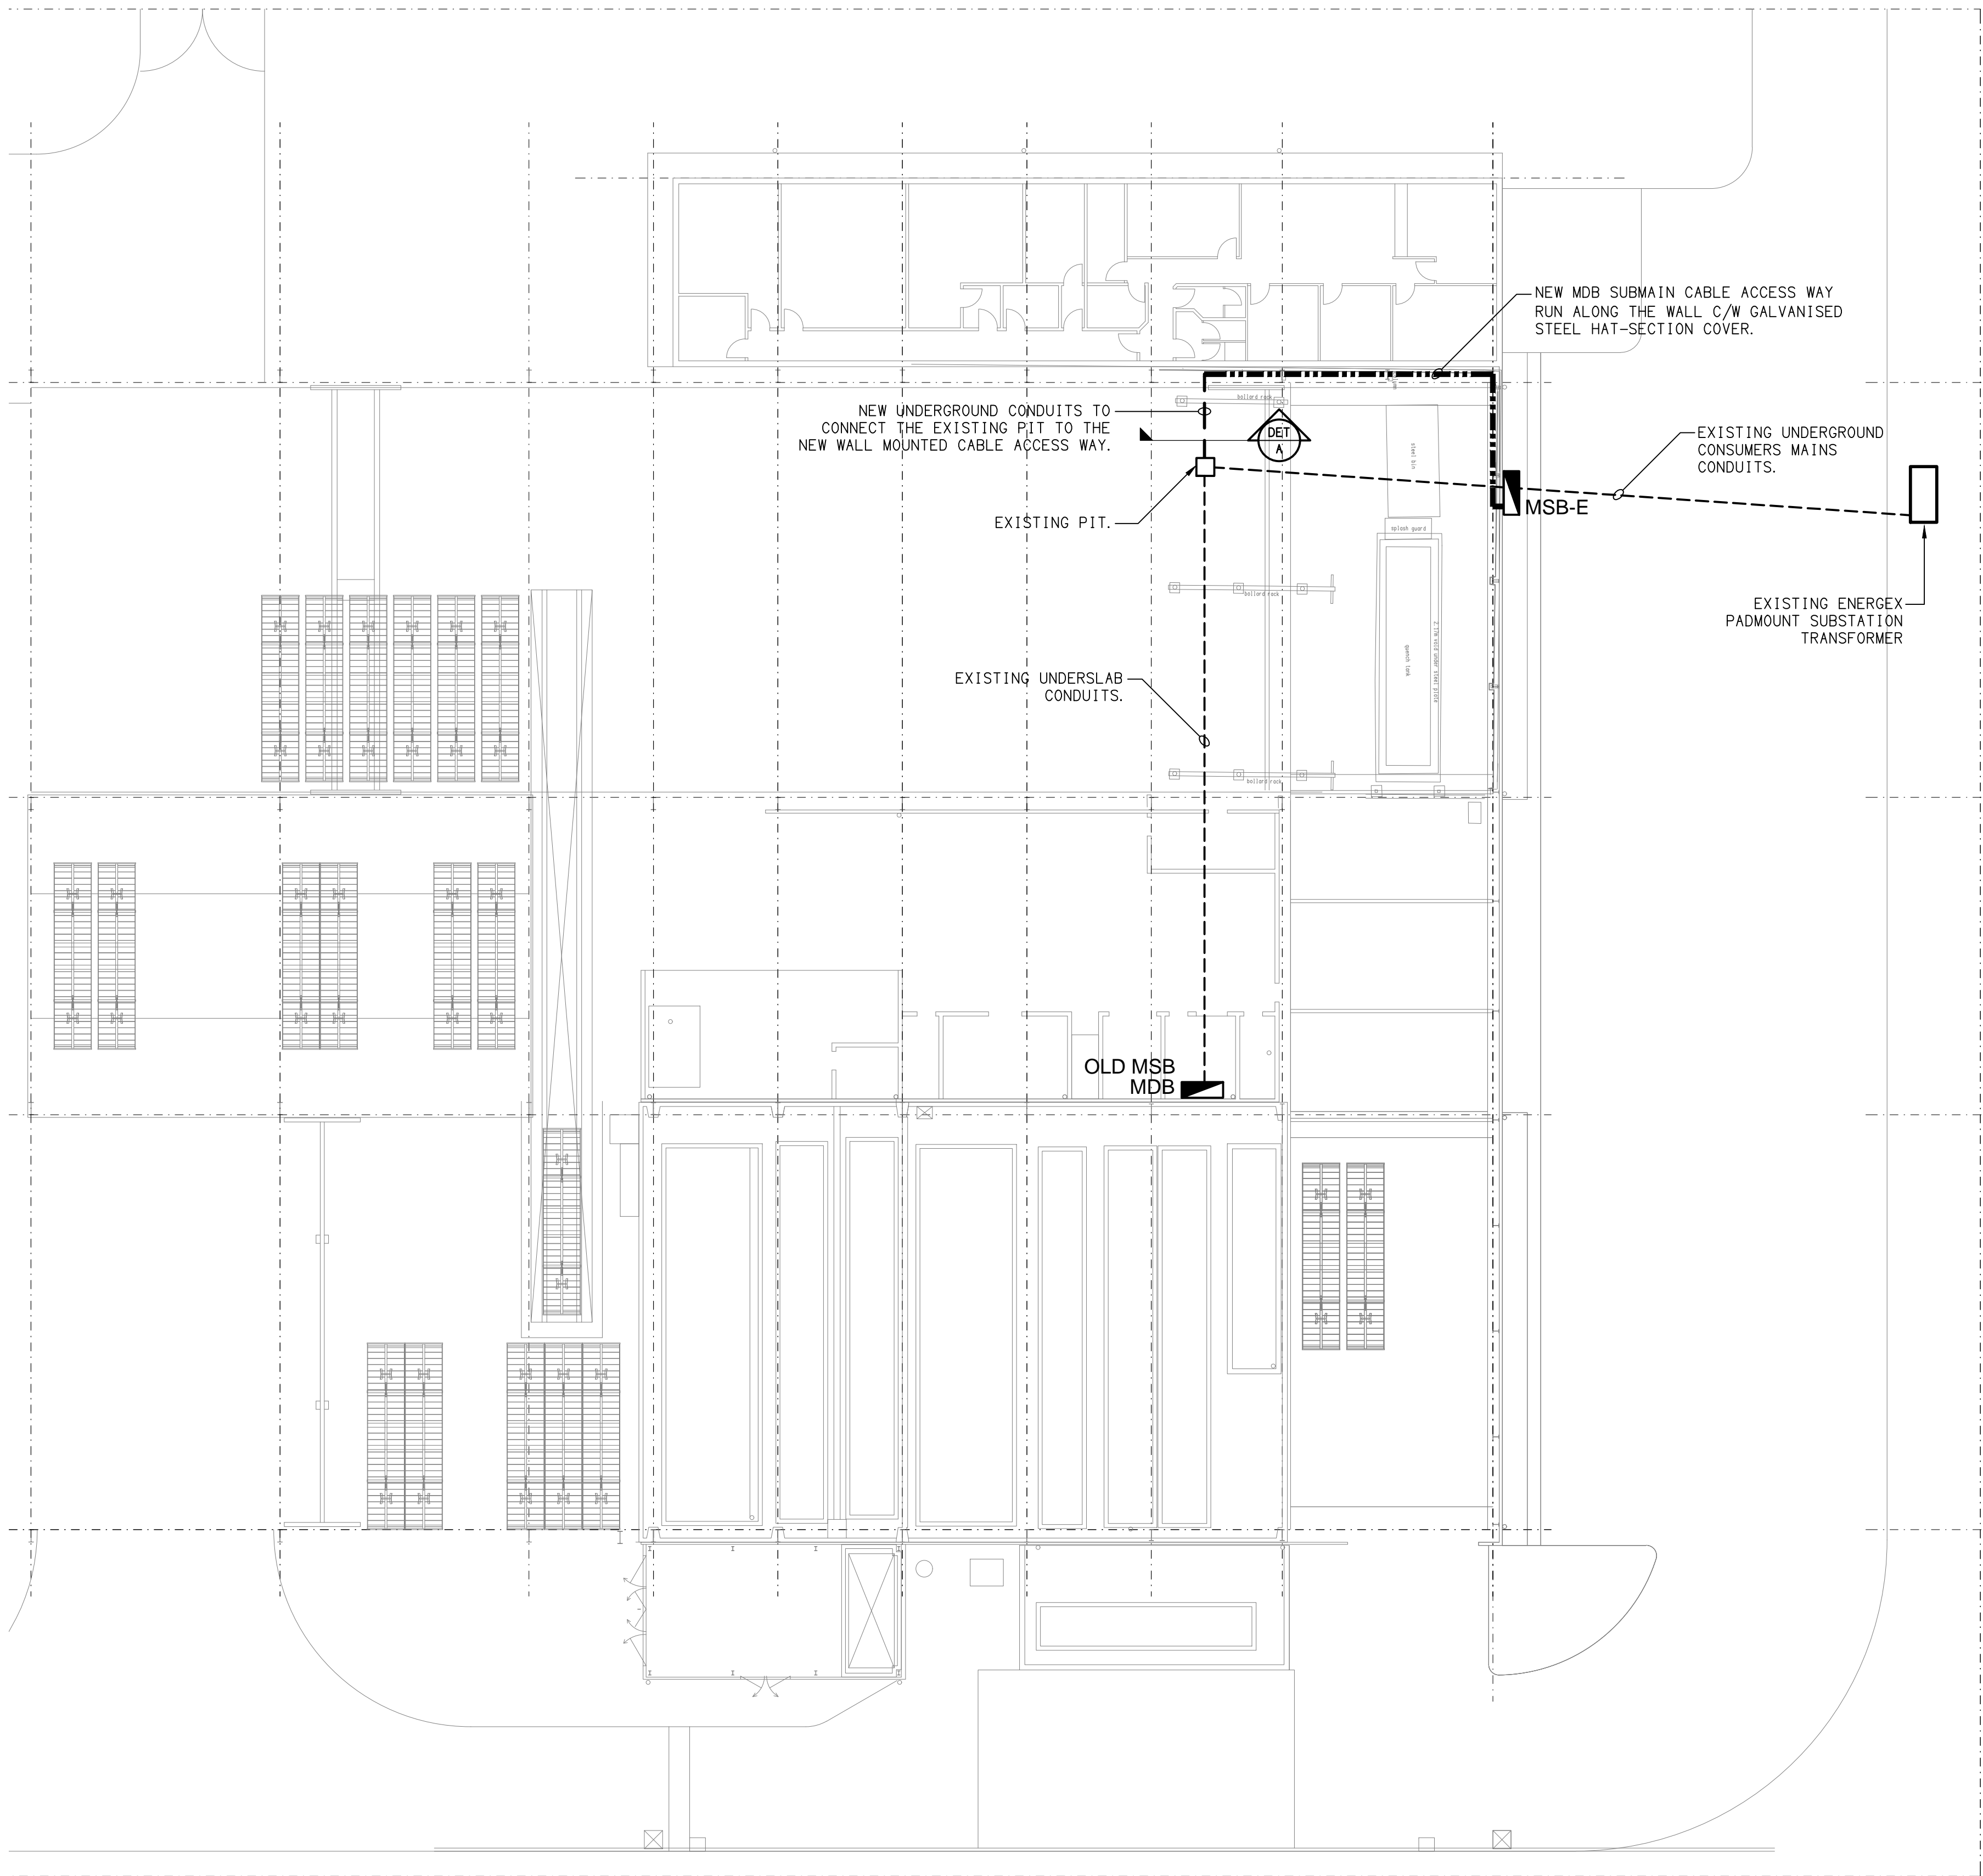


PART SITE PLAN
MSB-E & PIT ARRANGEMENTS
SCALE 1: 200

PLAN VIEW
MSB-E & PIT
SCALE 1: 25

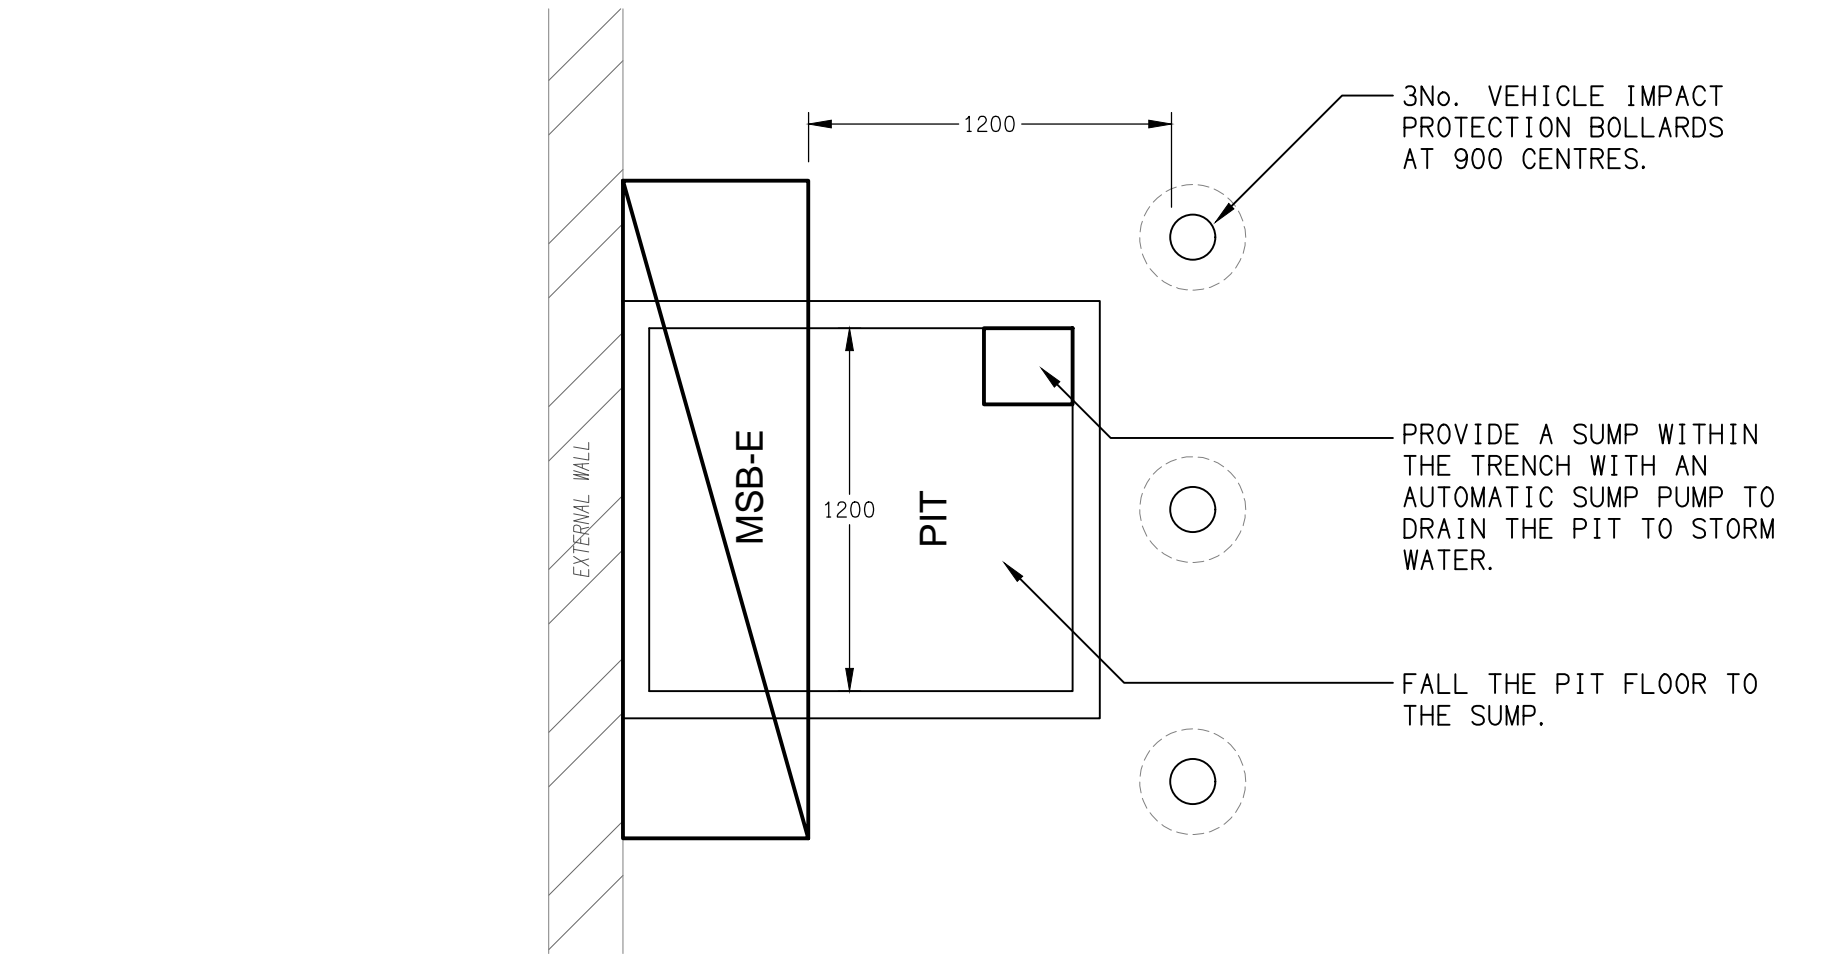

SECTION VIEW
MSB-E & PIT
SCALE 1: 25

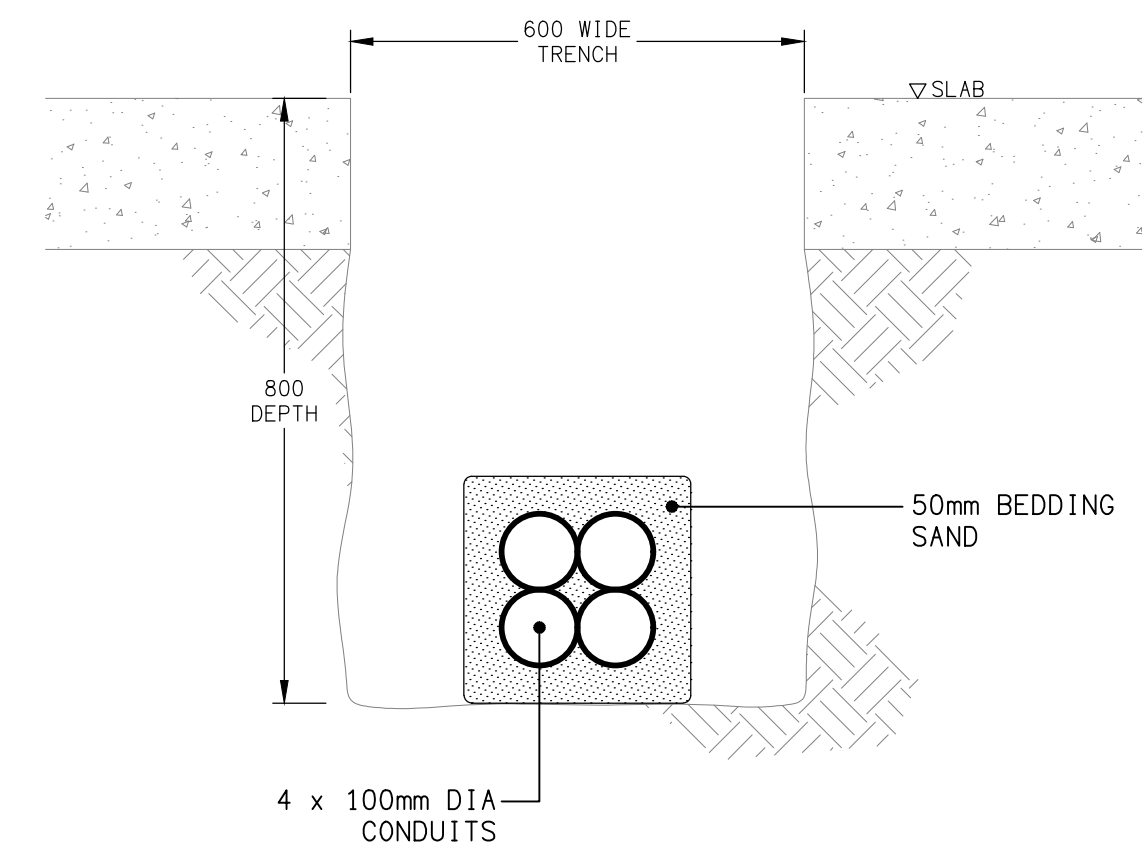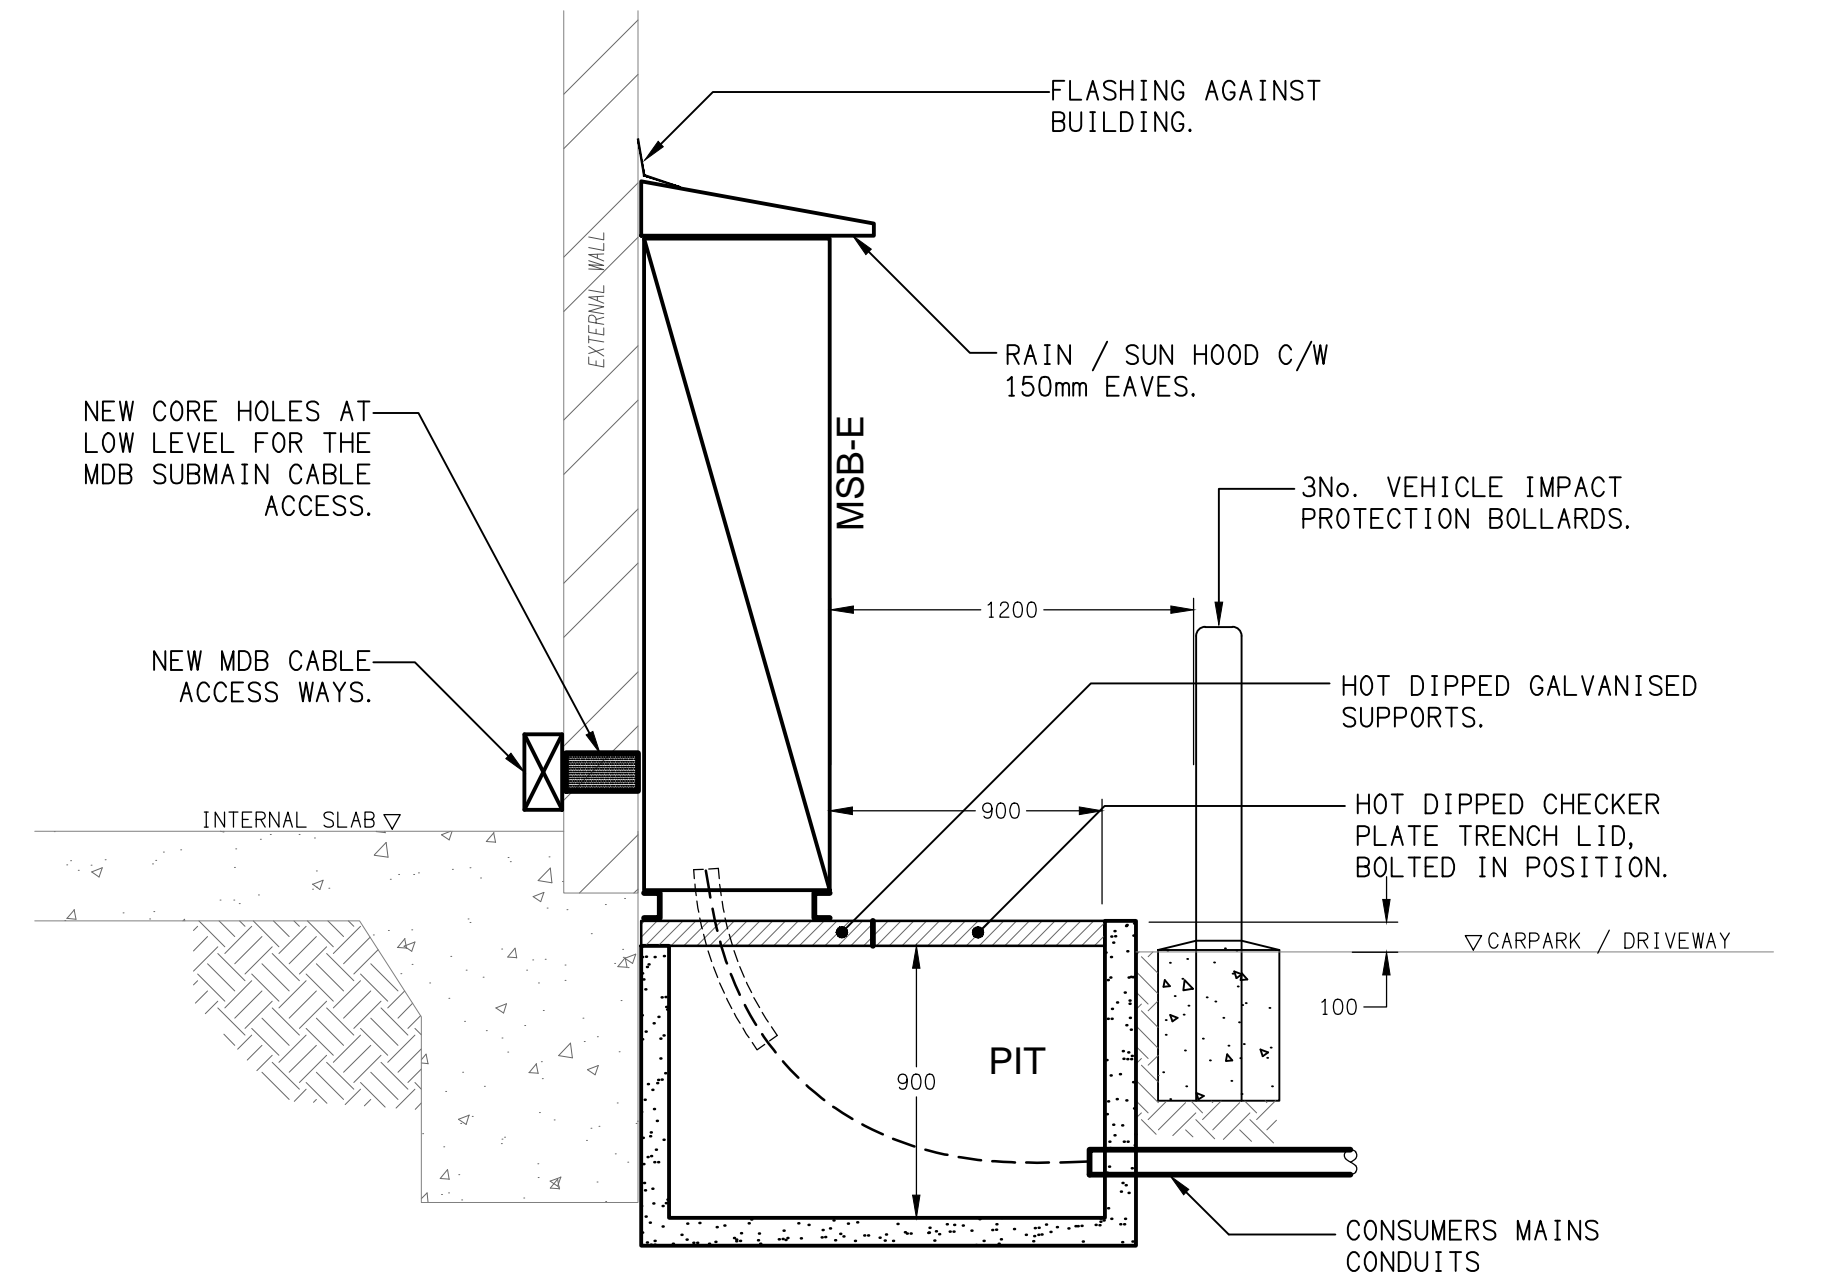

DETAIL A
TRENCH SECTION VIEW
NOT TO SCALE

ELECTRICAL DESIGN GROUP BRISBANE
PTY LTD
ACN 092 710 793
TRADING AS:
ELECTRICAL DESIGN GROUP

THE COPYRIGHT OF THIS DRAWING
REMAINS THE PROPERTY OF THE
ELECTRICAL DESIGN GROUP.
USE FIGURED DIMENSIONS
IN PREFERENCE TO SCALE.
ALL DIMENSIONS TO BE
VERIFIED ONSITE.

ELECTRICAL DESIGN GROUP
ELECTRICAL BUILDING SERVICES CONSULTANTS
BRISBANE GOLD COAST

P.O.Box 15, Sherwood Q.4075
Phone: (07) 3278 4375
Email: brisbane@edg.net.au
Web: www.edg.net.au

PROJECT:
661 CURTIN AVENUE EAST, PINKENBA

BRISBANE

C	APPROVAL	11/06/2026
REV:	DESCRIPTION:	DATE:

DRAWING:
ELECTRICAL SERVICES
PART SITE PLAN

SCALE:
1:200 UNO AT A1

PROJECT NO:
C3712a
DRAWING NO:
E03
REVISION:
C